

**Jensen  
Yorba  
Lott  
Inc.**

522 West 10th Street  
Juneau, Alaska 99801  
phone 907-586-1070  
fax 907-586-3959  
jensenyorbaltott.com



**Juneau International Airport  
AIRPORT AIRCRAFT RESCUE &  
FIREFIGHTING STATION MODIFICATION**  
Juneau, Alaska  
CBJ Project No. EXX-XXX


Schematic Des.

- REVISIONS
- △ .
  - △ .
  - △ .

SHEET TITLE  
**FIRST  
FLOOR PLAN**

DATE: January 12, 2016  
FILE: 15034

**A201**

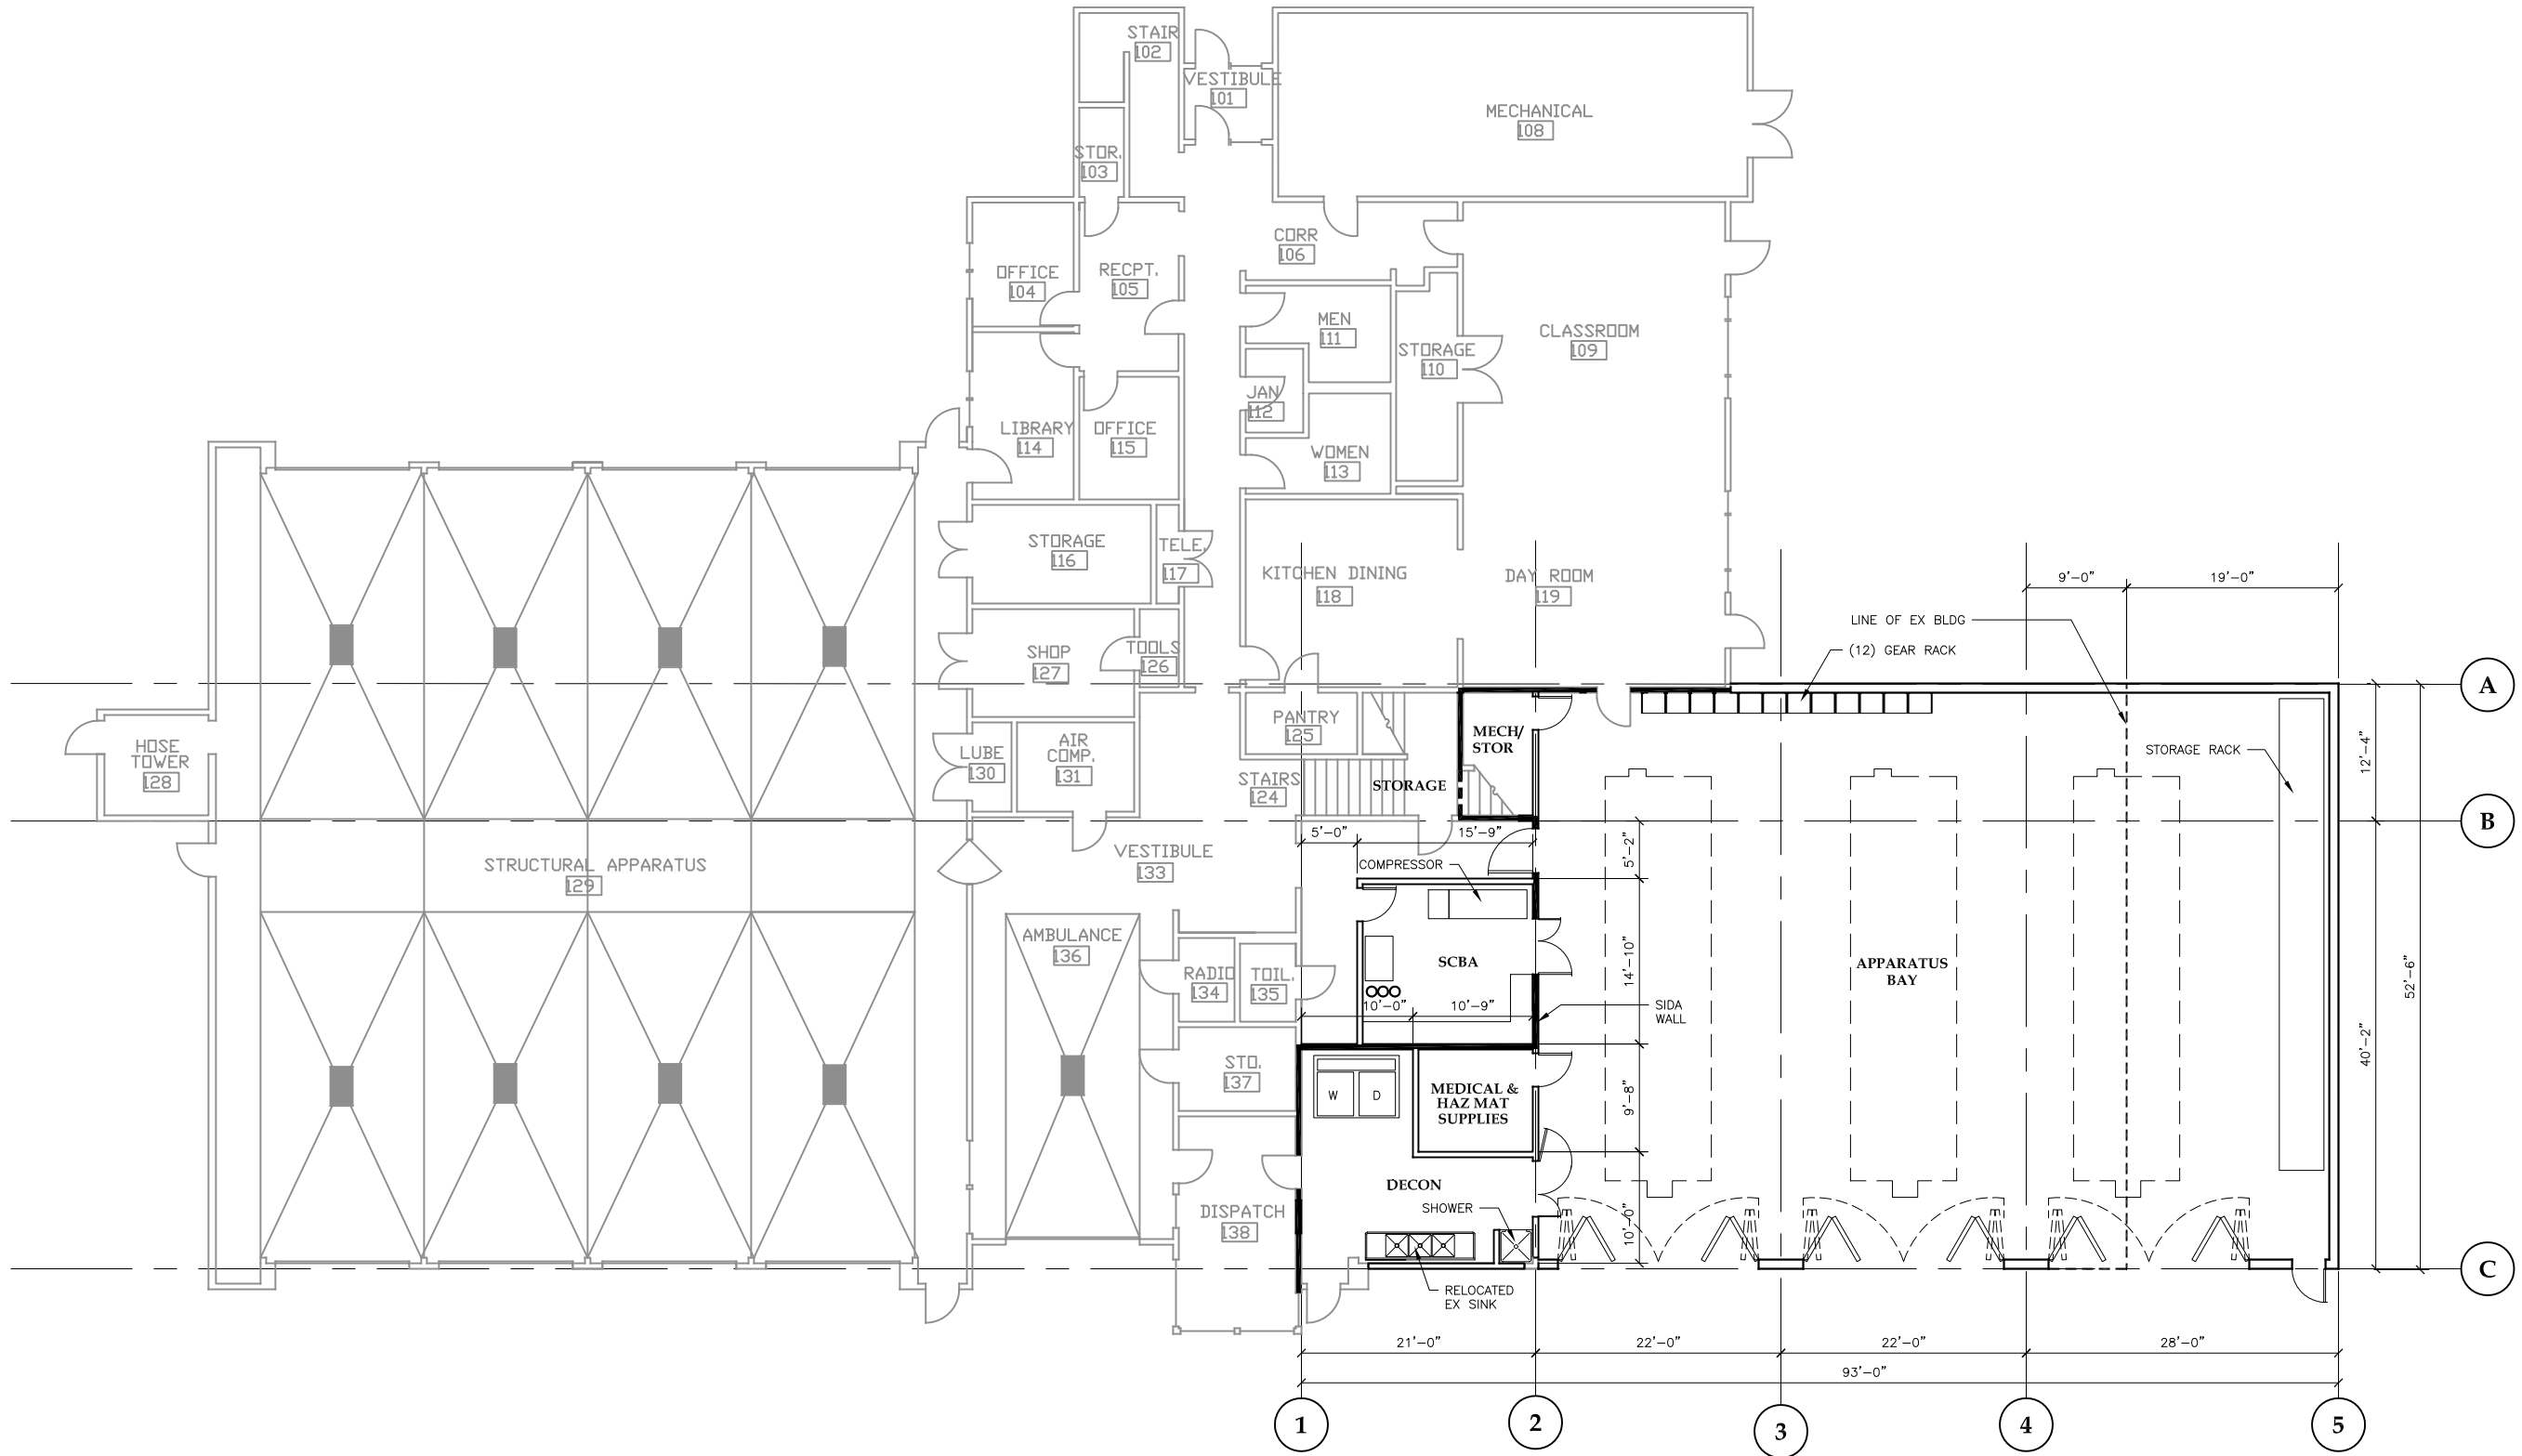

**1 FIRST FLOOR PLAN**

SCALE: 0 4' 8' 16'

