


SYMBOLS

	EXISTING, DEMOLISH, NEW	AAV	AUTOMATIC AIR VENT
	CW	BFP	BACK FLOW PREVENTER
	HW	C	COMMON
	HWR	CI	CAST IRON
	KHW	CO	CLEANOUT
	KHW	D-X	DRAIN FIXTURE DESIGNATION
	THW	DI	DUCTILE IRON
	V	DN	DOWN
	W	DU	DIELECTRIC UNION
	RD	DV	DRAIN VALVE
	WSPR	FRP	FIBERGLASS REINFORCED PLASTIC
	ARW	GD	GARBAGE DISPOSAL
	PW	IAW	IN ARCHITECTURAL WORK
	VC	IEW	IN ELECTRICAL WORK
	MV	ICW	IN CIVIL WORK
	MA	INV. EL.	INVERT ELEVATION
	O2	IPS	IRON PIPE SIZE
		L	LAVATORY
		MBH	1,000 BTU PER HOUR
	AV	NF	NON-FREEZE
		NIC	NOT IN CONTRACT
		NIM	NOT IN MECHANICAL
		NO	NORMALLY OPEN
	DV	O.C.	ON CENTER
		ORD	OVERFLOW ROOF DRAIN
		P-X	PLUMBING FIXTURE DESIGNATION
		P	PUMP
		PSI	POUNDS PER SQUARE INCH
	CO	RD	ROOF DRAIN
	FCO	REF	REFRIGERATOR
		RI	ROUGH IN
		RL	ROOF LEADER
		RPBP	REDUCED PRESSURE BACKFLOW PREVENTER
		S	SINK
		SH	SHOWER
		T&P	TEMPERATURE AND PRESSURE RELIEF VALVE
		TPV	TRAP PRIMER VALVE
		TYP	TYPICAL
		VTR	VENT THROUGH ROOF
		WB	WASHER BOX
		WC	WATER CLOSET
		WH	WALL HYDRANT
		WHA	WATER HAMMER ARRESTOR
		YCO	YARD CLEANOUT

MECHANICAL DRAWING INDEX

P000	PLUMBING SYMBOLS AND SCHEDULES
P001	PLUMBING SCHEDULES
P1202	DEMOLITION FLOOR PLAN LEVEL 2 NORTH PLUMBING
P1203	DEMOLITION FLOOR PLAN LEVEL 2 CORRIDOR PLUMBING
P1204	DEMOLITION FLOOR PLAN LEVEL 2 SOUTH PLUMBING
P1205	DEMOLITION FLOOR PLAN LEVEL 3 NORTH PLUMBING
P1206	DEMOLITION FLOOR PLAN LEVEL 3 SOUTH PLUMBING
P1302	DEMOLITION FLOOR PLAN LEVEL 2 NORTH MEDICAL GAS PIPING
P1303	DEMOLITION FLOOR PLAN LEVEL 2 CORRIDOR MEDICAL GAS PIPING
P1304	DEMOLITION FLOOR PLAN LEVEL 2 SOUTH MEDICAL GAS PIPING
P1305	DEMOLITION FLOOR PLAN LEVEL 3 NORTH MEDICAL GAS PIPING
P1306	DEMOLITION FLOOR PLAN LEVEL 3 SOUTH MEDICAL GAS PIPING
P202	FLOOR PLAN LEVEL 2 NORTH PLUMBING
P203	FLOOR PLAN LEVEL 2 CORRIDOR PLUMBING
P204	FLOOR PLAN LEVEL 2 SOUTH PLUMBING
P205	FLOOR PLAN LEVEL 3 NORTH PLUMBING
P206	FLOOR PLAN LEVEL 3 SOUTH PLUMBING
P305	FLOOR PLAN LEVEL 3 NORTH MEDICAL GAS PIPING
P306	FLOOR PLAN LEVEL 3 SOUTH MEDICAL GAS PIPING
P401	DETAILS AND DIAGRAMS

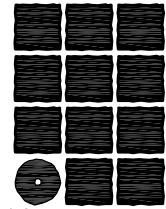

Jensen
Yorba
Lott
Inc.


522 West 10th Street
Juneau, Alaska 99801
phone 907-586-1070
fax 907-586-3959
jensenyorbalott.com

MURRAY &
ASSOCIATES P.C.

P.O. BOX 21081
Juneau, Alaska 99802-1081

phone 907-780-6151
fax 907-780-6182

www.murraypc.com

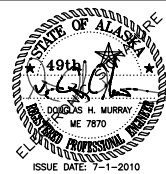

City & Borough of Juneau
Bartlett Regional Hospital
Medical/ Surgical East Wing Renovation
CBJ Contract No. E10-221
Juneau, Alaska

CONSTRUCTION
DOCUMENTS

REVISIONS
△ .
△ .
△ .

SHEET TITLE
PLUMBING
SYMBOLS &
SCHEDULES

DATE: July 1, 2010
JOB #: 10-256

P000

PLUMBING FIXTURE SCHEDULE

MARK	ITEM	MFR/ MODEL	DESCRIPTION	COLD WATER (IN)	HOT WATER (IN)	WASTE (IN)	VENT (IN)
P-1	WATER CLOSET	AMERICAN STANDARD 2257.103	WALL HUNG, VITREOUS CHINA, ELONGATED BOWL, 1-1/2" TOP SPUD, SIPHON JET ACTION, 1.6 GPF.	1-1/4	-	4	2
	FLUSH VALVE	SLOAN 8111	WATER SAVER FLUSH VALVE, CHROME PLATED, SCREWDRIVER STOP, INTEGRAL VACUUM BREAKER, 1.6 GPF. BATTERY POWERED, SENSOR OPERATED.				
	SEAT	OLSONITE 1055C	SOLID PLASTIC, OPEN FRONT, STAINLESS STEEL HINGE WITH CHECK, HEAVY DUTY MOLTEX COMMERCIAL HIGH IMPACT POLYSTYRENE.				
	NOTE: WATER CLOSET SHALL BE MOUNTED WHERE TOP OF SEAT IS 19" AFF.						
P-2	WATER CLOSET	AMERICAN STANDARD 2256.194	SAME AS P-1, EXCEPT WITH BEDPAN LUGS.	1-1/4	-	4	2
	FLUSH VALVE BEDPAN WASHER	SLOAN BPW-8000	FLUSH VALVE, DIVERTER VALVE ASSEMBLY WITH SPRAY ARM, DIVERTER VALVE WALL SUPPORT, 1.6 GPF, CHROME PLATED, SCREWDRIVER STOP, INTEGRAL VACUUM BREAKER. BATTERY POWERED, SENSOR OPERATED.				
	SEAT	OLSONITE 1055C	SAME AS P-1.				
	NOTE: WATER CLOSET SHALL BE MOUNTED WHERE TOP OF SEAT IS 19" AFF.						
P-3	WATER CLOSET	ZURN Z5699	FLOOR MOUNTED, VITREOUS CHINA, ELONGATED BOWL, 1-1/2" TOP SPUD, SIPHON JET ACTION, 1.6 GPF. EXTRA HEAVY DUTY 1000LB BARIATRIC WATER CLOSET	1-1/4	-	4	2
	FLUSH VALVE BEDPAN WASHER	SLOAN BPW-8000	FLUSH VALVE, DIVERTER VALVE ASSEMBLY WITH SPRAY ARM, DIVERTER VALVE WALL SUPPORT, 1.6 GPF, CHROME PLATED, SCREWDRIVER STOP, INTEGRAL VACUUM BREAKER. BATTERY POWERED, SENSOR OPERATED.				
	SEAT		BARIATRIC EXTRA LARGE AND ELONGATED SEAT. ERGONOMIC EXTRA WIDE SEAT. PROVIDED INTERGRAL WITH WATER CLOSET.				
P-9	SINK	ELKAY LRAD-2219-65	STAINLESS STEEL, COUNTERTOP, SINGLE BOWL, 22" x 19-1/2" x 6-1/2" DEEP. SOUND DEADENING, SELF-RIMMING, 18 GAUGE, 3-HOLE PUNCH, SATIN FINISH.	1/2	1/2	2	1-1/2
	FAUCET	CHICAGO 1201-HA8-317-E29VP	DECK MOUNTED, SWING SPOUT, LAMINAR FLOW OUTLET, VANDAL RESISTANT, CHROME FINISH, 4" WRIST BLADE HANDLES.				
	DRAIN	ELKAY LK-35	STAINLESS STEEL. CRUMB CUP STRAINER, 1-1/2 CHROME PLATED TAILPIECE.				

FLOWSETTER SCHEDULE


NUMBER	UNIT SERVED	LOCATION	DESIGN GPM	SETTER SIZE (INCHES)
P-383	HWR PIPING	CORRIDOR 3300K	1.1	1/2
P-384	HWR PIPING	CORRIDOR 3300K	1.1	1/2

PLUMBING FIXTURE SCHEDULE (CONT'D)

MARK	ITEM	MFR/ MODEL	DESCRIPTION	COLD WATER (IN)	HOT WATER (IN)	WASTE (IN)	VENT (IN)
P-32	SHOWER	CHICAGO 1900VOC-151	PRESSURE BALANCING SHOWER VALVE, 1/2" IPS FEMALE INLET AND OUTLET, CHROME PLATED, HAND HELD SHOWER FITTING, 24" SLIDE BAR, 60" CHROME PLATED HOSE, IN-LINE VACUUM BREAKER. POLISHED CHROME FINISH.	1/2	1/2	-	-
P-33	SHOWER	CHICAGO 1900VOC-151	PRESSURE BALANCING SHOWER VALVE, 1/2" IPS FEMALE INLET AND OUTLET, CHROME PLATED, HAND HELD SHOWER FITTING, 24" SLIDE BAR, 96" CHROME PLATED HOSE, IN-LINE VACUUM BREAKER. POLISHED CHROME FINISH.	1/2	1/2	-	-
P-34	LAVATORY	AMERICAN STANDARD 0958.00	WALL HUNG, VITREOUS CHINA, 22" x 18" x 34", CONCEALED ARMS, 8" CENTERS, OVERFLOW, ADA COMPLIANT, VITREOUS CHINA SHROUD AND HANGERS.	1/2	1/2	1-1/4	1-1/4
	FAUCET	SPEAKMAN S-9129	BATTERY POWERED SENSOR OPERATED GOOSENECK LAVATORY FAUCET WITH UNDER THE COUNTER THERMOSTATIC MIXING VALVE. WITH LAMINAR FLOW CONTROL OUTLET. PROVIDE 2 COMPLETE SPARE FAUCETS.				
	DRAIN	CHICAGO 327A	1-1/4" CHROME TAILPIECE WITH NON- REMOVABLE GRID STRAINER. LOCATE HEIGHT OF FIXTURE RIM 2'-4" ABOVE FINISHED FLOOR FOR ADA PURPOSES. SEE TPV-2 REQUIREMENTS FOR TAIL PIECE IF APPLICABLE.				
P-43	LAVATORY	AMERICAN STANDARD 0498	COUNTERTOP LAVATORY, SELF- SELF-RIMMING, 20-1/2"x17-1/2", ENAMELED CAST IRON, 8" CENTERS.	1/2	1/2	1-1/2	1-1/2
	FAUCET	SPEAKMAN S-9129	BATTERY POWERED, SENSOR OPERATED, MANUAL OVERRIDE GOOSENECK LAVATORY FAUCET WITH ABOVE COUNTER MIXER, UNDER THE COUNTER THERMOSTATIC MIXING VALVE. WITH LAMINAR FLOW CONTROL OUTLET. PROVIDE 2 SPARE COMPLETE FAUCETS.				
TPV-1	TRAP PRIMER VALVES	PPP PR500	PRESSURE ACTIVATED	1/2	-	-	-
TPV-2	TRAP PRIMER VALVES	JR SMITH PRIME-EZE	GRAVITY ACTIVATED. FIXTURES WITH TPV-2 REQUIRE TAIL PIECE WITH INTEGRAL TRAP PRIMING CONNECTION. COORDINATE REQUIREMENTS WITH TRAP PRIMER SPECIFICATION.	1/2	-	-	-
D-1	FLOOR DRAIN	J.R. SMITH 2005-AU/ 2010-AU-P050	DUCO CAST IRON BODY AND FLASHING COLLAR, ROUND NICKEL BRONZE ADJUSTABLE STRAINER HEAD WITH 6" DIAMETER ROUND TOP, VANDAL RESISTANT SECURED HEEL-PROOF SQUARE HOLE GRATE, 1/2" TRAP PRIMER CONNECTION.	-	-	2	1-1/2
D-2	FLOOR SINK	J.R. SMITH 3320Y-12	CAST IRON FLANGED RECEPTOR, 6"x12"x8" DEEP WITH ACID RESISTANT COATED INTERIOR, NICKEL BRONZE RIM W/ 1/2 GRATE, ALUMINUM DOME BOTTOM STRAINER, FLASHING CLAMP.	-	-	2	1-1/2

GENERAL NOTES:

1. FOR LOCATION OF DECK-MOUNTED LAVATORIES SEE ARCHITECTURAL CASEWORK ELEVATIONS. FOR TYPICAL WALL-MOUNTED FIXTURES SEE SHEET A5.01 FOR LOCATIONS.
2. SEE SPECIFICATIONS FOR ADDITIONAL INFORMATION.

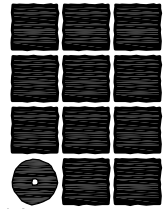

Jensen
Yorba
Lott
Inc.

522 West 10th Street
Juneau, Alaska 99801
phone 907-586-1070
fax 907-586-3959
jensenyorbalott.com

MURRAY &
ASSOCIATES P.C.

P.O. BOX 21081
Juneau, Alaska 99802-1081

phone 907-780-6151
fax 907-780-6182

www.murraypc.com



City & Borough of Juneau
Bartlett Regional Hospital
Medical / Surgical East Wing Renovation
CBJ Contract No. E10-221
Juneau, Alaska


CONSTRUCTION
DOCUMENTS





SHEET TITLE
PLUMBING
SCHEDULES

DATE: July 1, 2010
JOB #: 10-256

P001

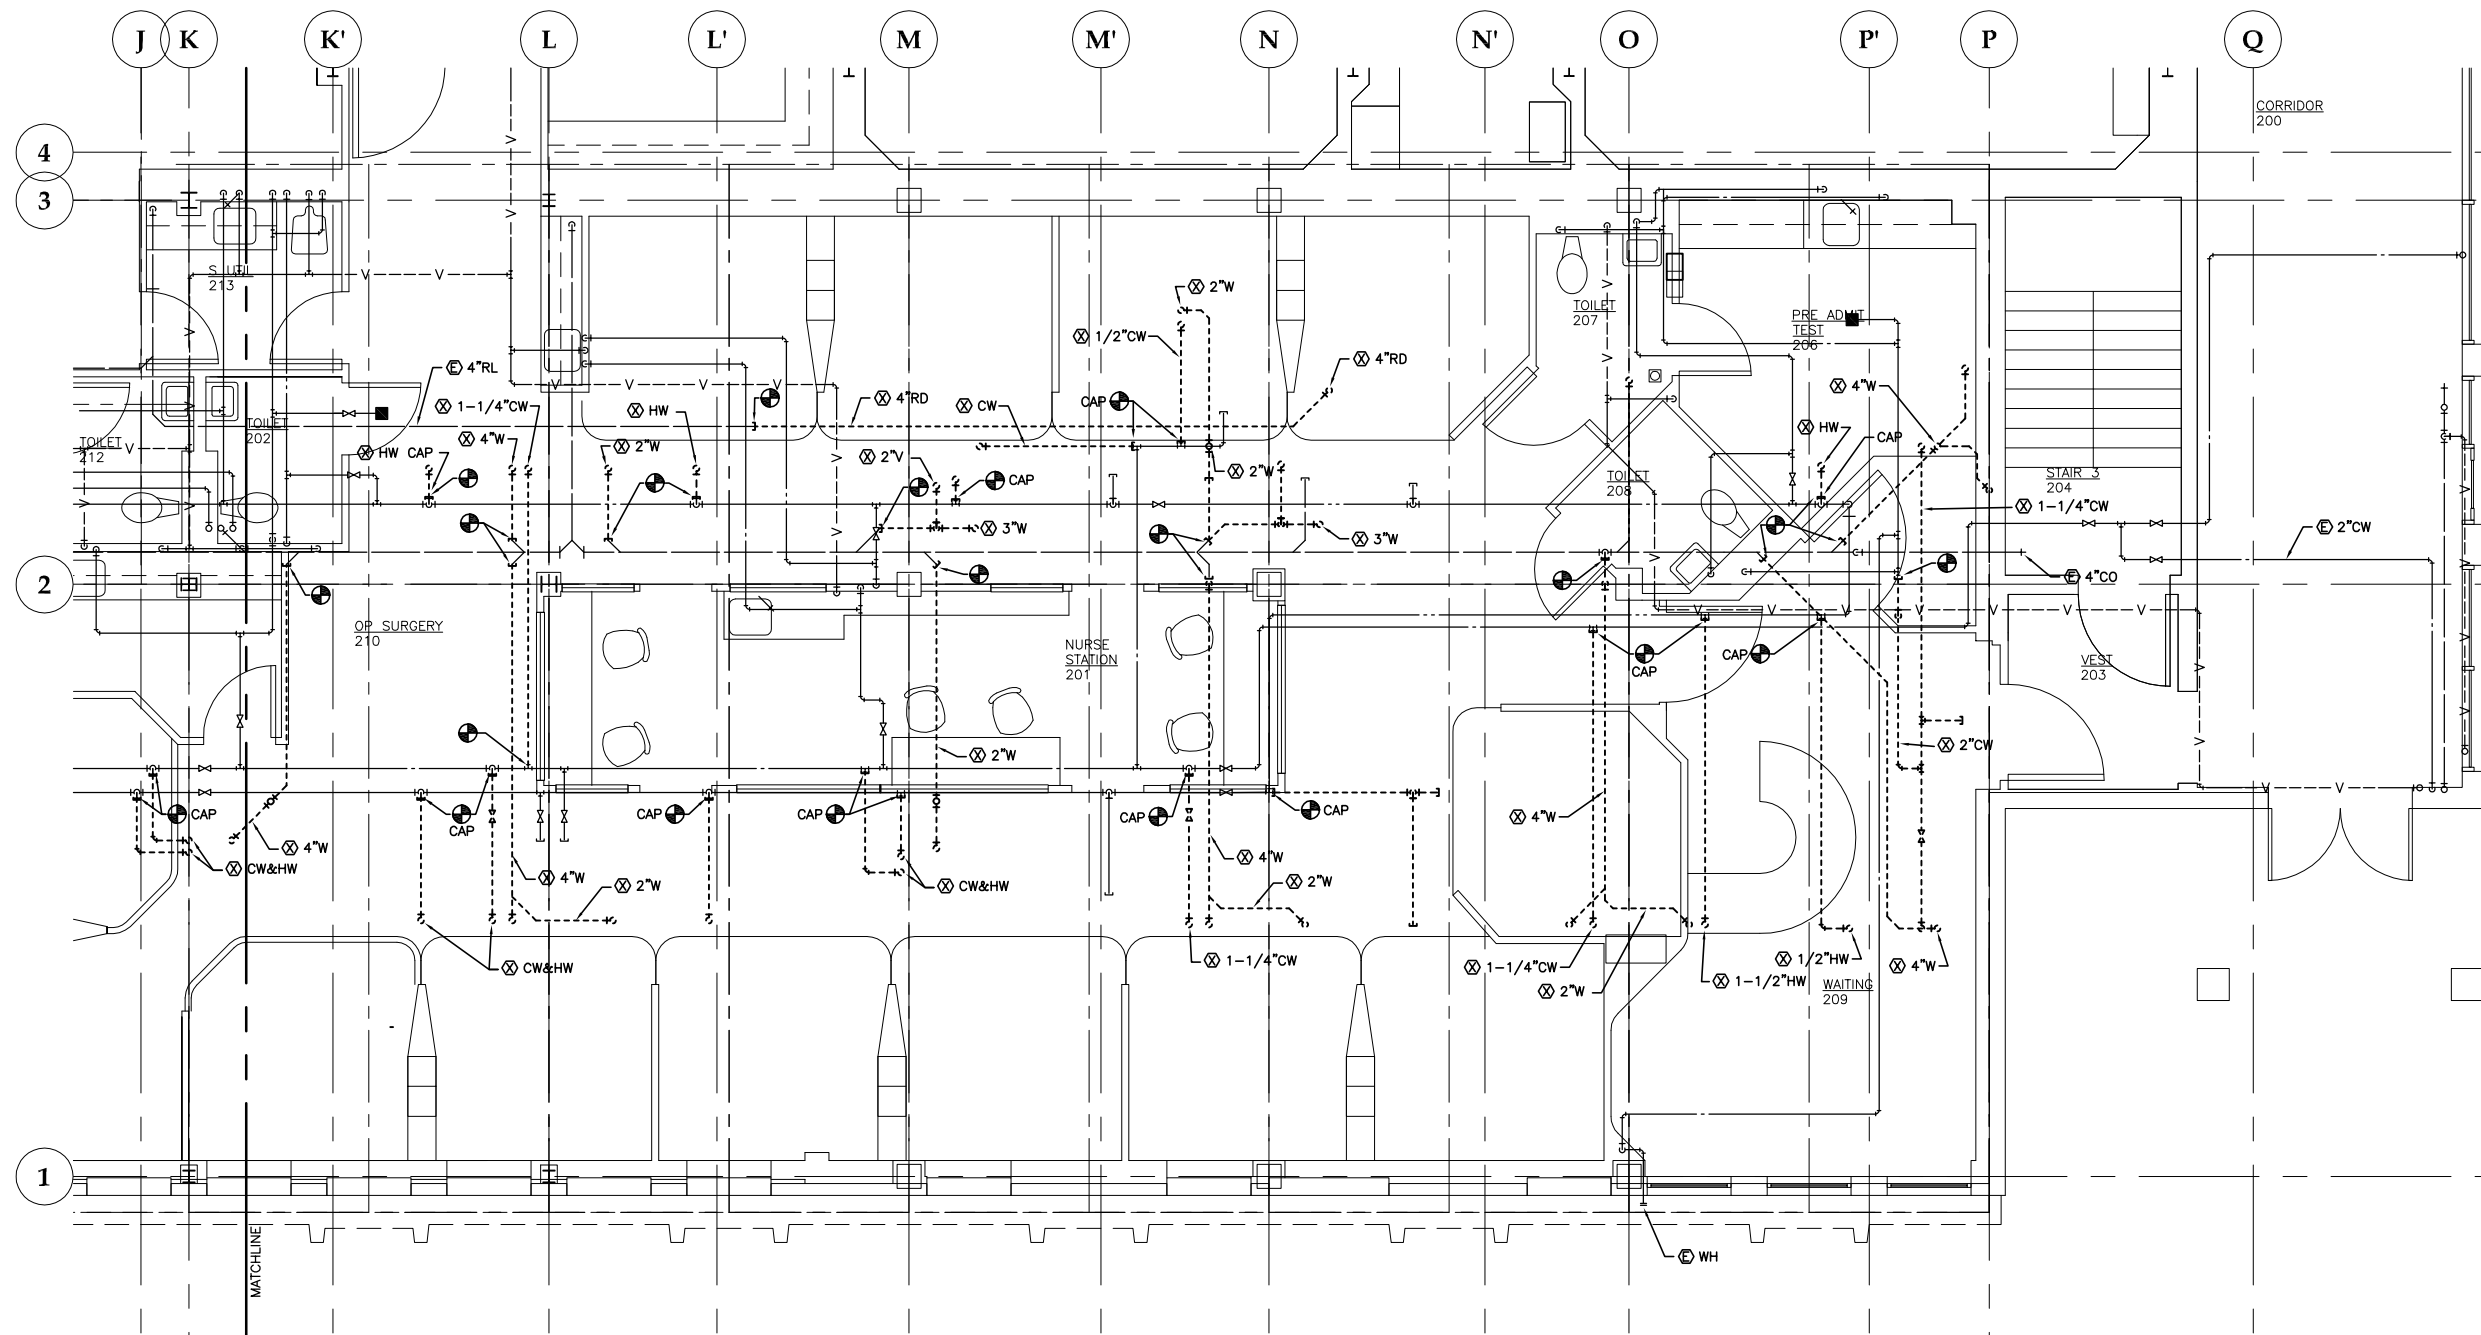

 
1 DEMOLITION FLOOR PLAN: LEVEL 2 NORTH - PLUMBING

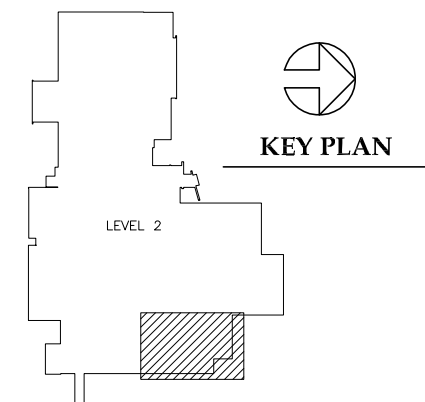

Jensen Yorba Lott Inc.

522 West 10th Street
Juneau, Alaska 99801
phone 907-586-1070
fax 907-586-3959
jensenyorbalott.com


MURRAY & ASSOCIATES P.C.
P.O. BOX 21081
Juneau, Alaska 99802-1081
phone 907-780-6151
fax 907-780-6182
www.murraypc.com

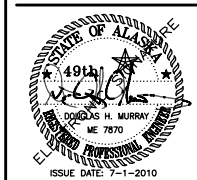

City & Borough of Juneau
Bartlett Regional Hospital
Medical / Surgical East Wing Renovation
CBJ Contract No. E10-221
Juneau, Alaska



CONSTRUCTION DOCUMENTS	
REVISIONS	
△	
△	
△	
SHEET TITLE	
DEMOLITION FLOOR PLAN LEVEL 2 - NORTH PLUMBING	
DATE: July 1, 2010	
JOB #: 10-256	

P1202

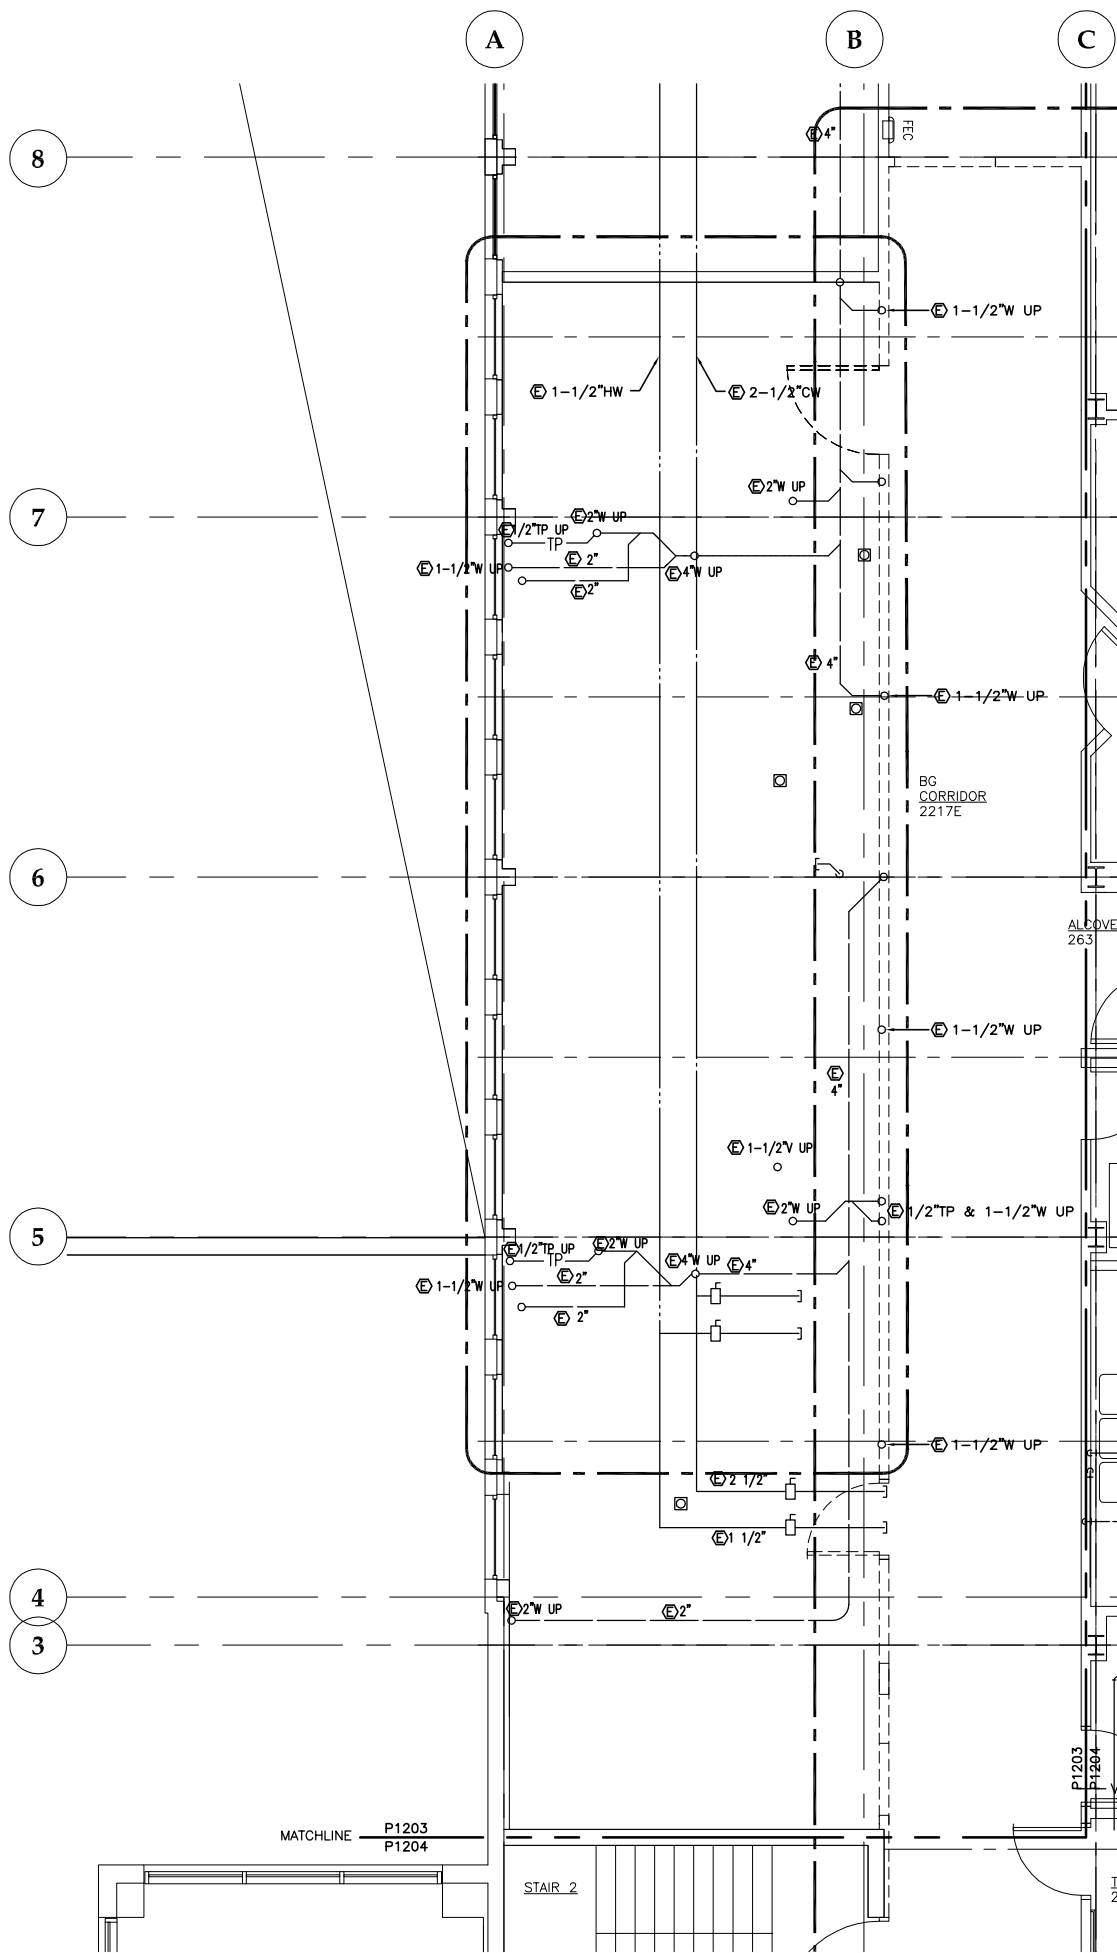

1 DEMOLITION FLOOR PLAN : LEVEL 2 CORRIDOR PLUMBING

SCALE: 0 2' 4' 8'

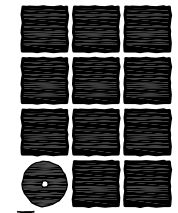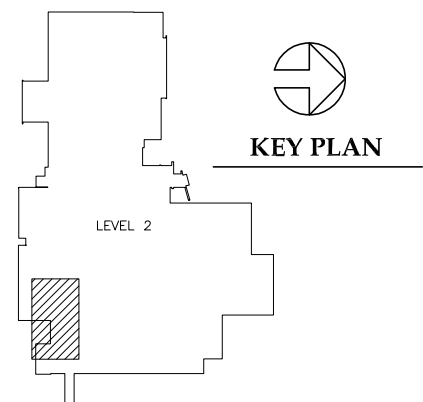

**Jensen
Yorba
Lott
Inc.**

522 West 10th Street
Juneau, Alaska 99801
phone 907-586-1070
fax 907-586-3959
jensenyorbalott.com

MURRAY &
ASSOCIATES P.C.

P.O. BOX 21081
Juneau, Alaska 99802-1081

phone 907-780-6151
fax 907-780-6182

www.murraypc.com



City & Borough of Juneau
Bartlett Regional Hospital
Medical / Surgical East Wing Renovation
CBJ Contract No. E10-221
Juneau, Alaska


CONSTRUCTION
DOCUMENTS

REVISIONS
△
△
△


SHEET TITLE
DEMOLITION
FLOOR PLAN
LEVEL 2 - CORRIDOR
PLUMBING

DATE: July 1, 2010
JOB #: 10-256

P1203


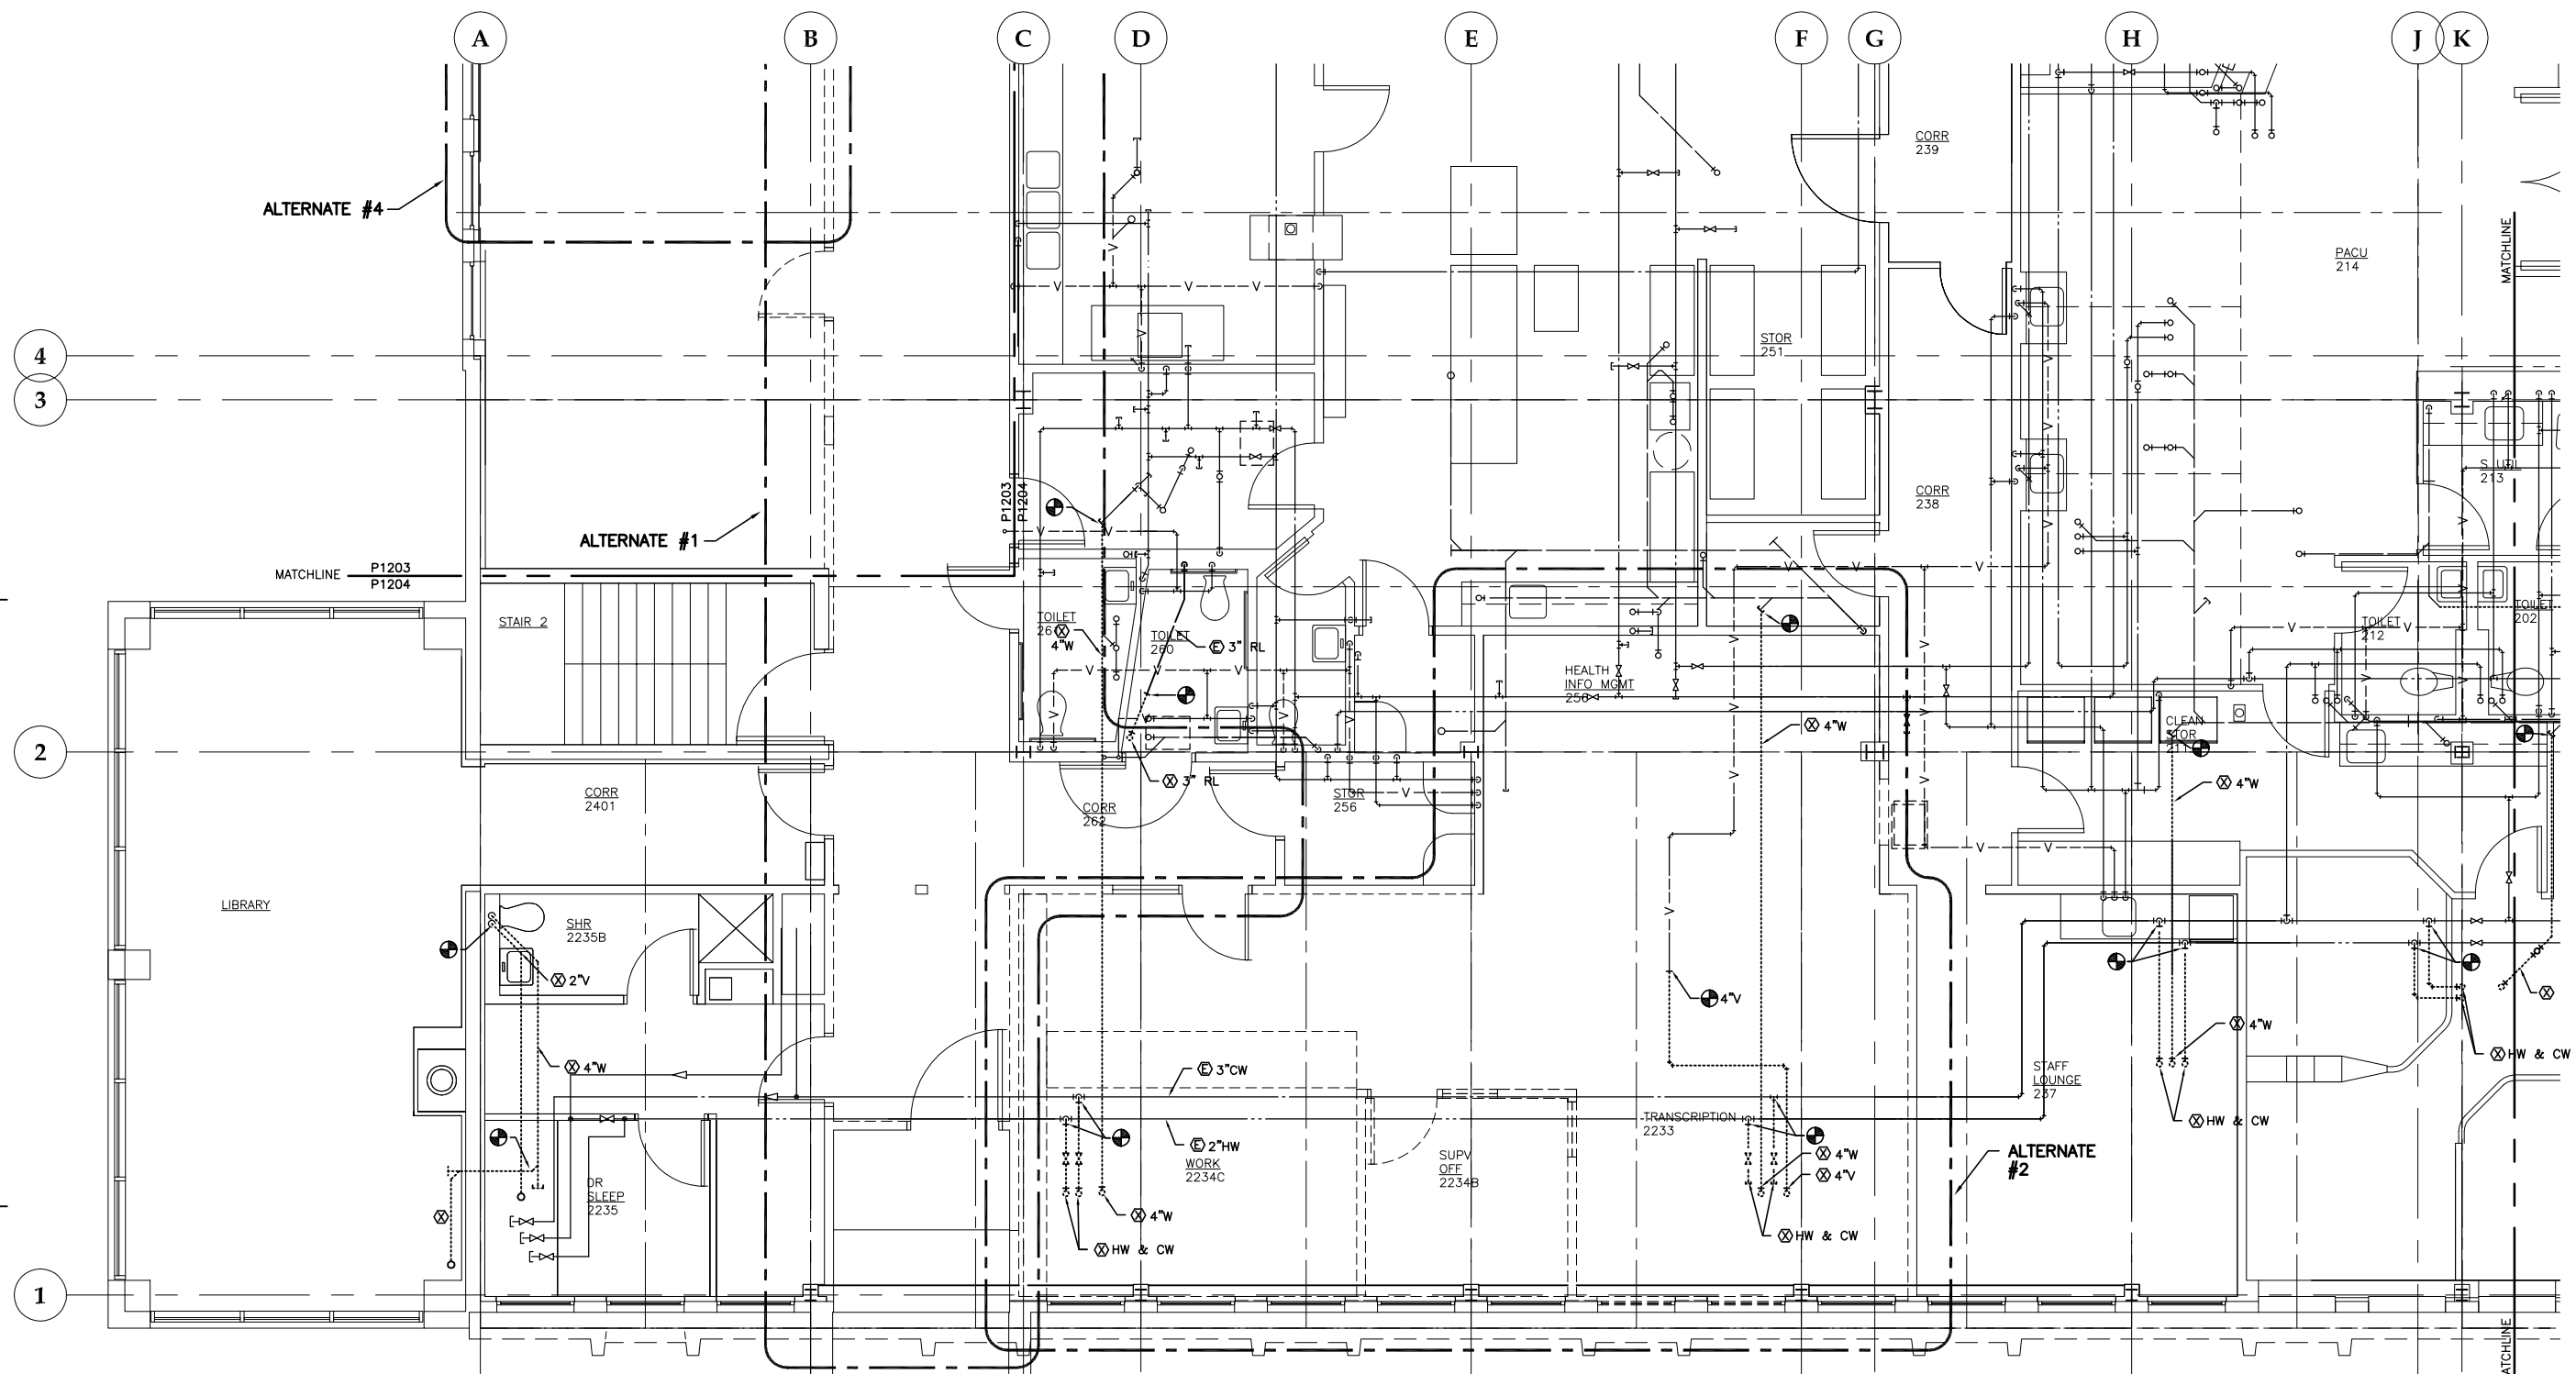


 1 DEMOLITION FLOOR PLAN: LEVEL 2 SOUTH - PLUMBING



DEMOLITION NOTES:

- ⚠ MV IS TYPICALLY 1-1/4" - 1-1/2" SIZE, O2 IS TYPICALLY 3/4" - 1" SIZE.

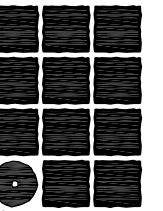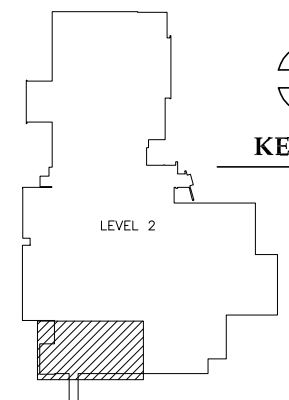

**Jensen
Yorba
Lott
Inc.**


522 West 10th Street
Juneau, Alaska 99801
phone 907-586-1070
fax 907-586-3959
jensenyorbalott.com

MURRAY &
ASSOCIATES P.C.

P.O. BOX 21081
Juneau, Alaska 99802-1081

phone 907-780-6151
fax 907-780-6182

www.murraypc.com

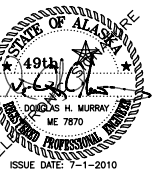

**City & Borough of Juneau
Bartlett Regional Hospital
Medical / Surgical East Wing Renovation
CBJ Contract No. E10-221
Juneau, Alaska**


CONSTRUCTION
DOCUMENTS

REVISIONS
△
△
△

SHEET TITLE
DEMOLITION
FLOOR PLAN
LEVEL 2 - SOUTH
PLUMBING

DATE: July 1, 2010
JOB #: 10-256


P1204

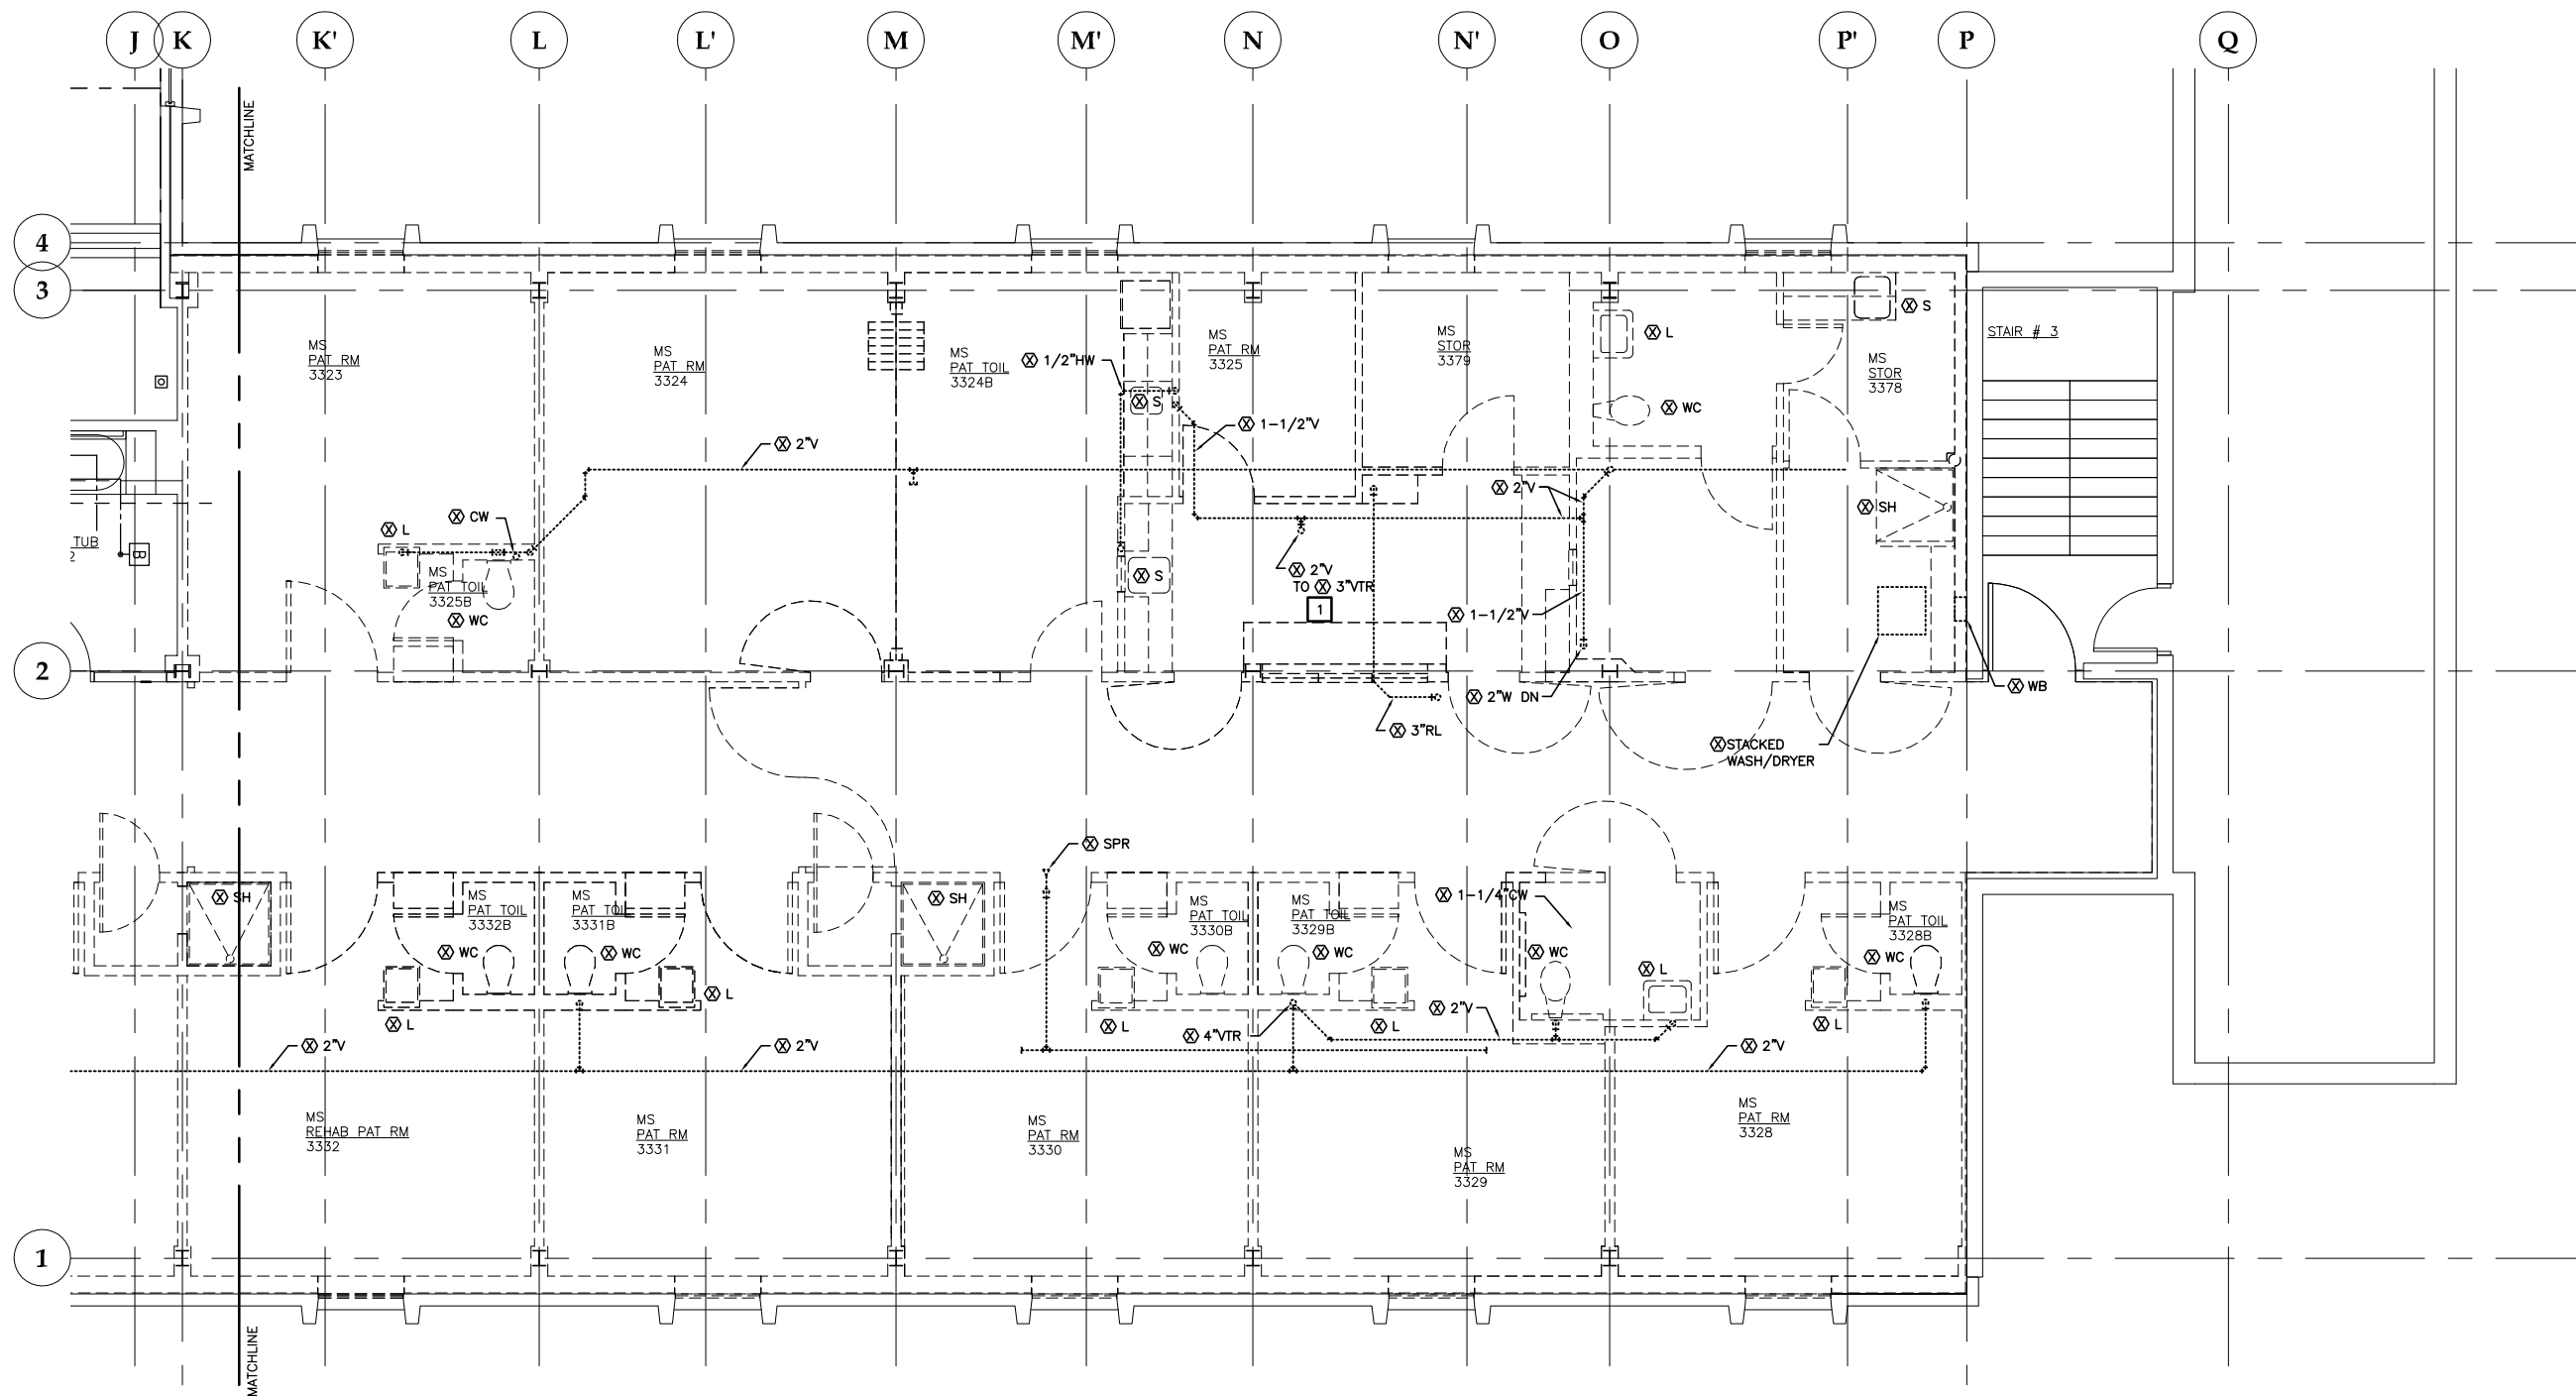

1 DEMOLITION FLOOR PLAN: LEVEL 3 - NORTH PLUMBING

SCALE: 0 2' 4' 8'

- DEMOLITION NOTES:**
- 1** REMOVE VENT AND FLASHING. ENLARGE PENETRATION IF NECESSARY.
 - 2** REMOVE VENT THROUGH ROOF. MODIFY ROOF PENETRATION FOR A 4\"/>

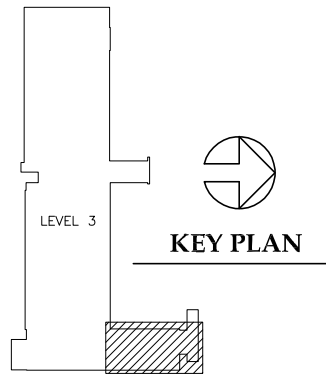


**Jensen
Yorba
Lott
Inc.**

522 West 10th Street
Juneau, Alaska 99801
phone 907-586-1070
fax 907-586-3959
jensenyorbalott.com

**MURRAY &
ASSOCIATES P.C.**

P.O. BOX 21081
Juneau, Alaska 99802-1081

phone 907-780-6151
fax 907-780-6182
www.murraypc.com

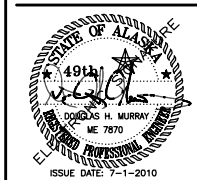

**City & Borough of Juneau
Bartlett Regional Hospital
Medical / Surgical East Wing Renovation
CBJ Contract No. E10-221
Juneau, Alaska**


**CONSTRUCTION
DOCUMENTS**

REVISIONS

- △ .
- △ .
- △ .

SHEET TITLE
**DEMOLITION
FLOOR PLAN
LEVEL 3 - NORTH
PLUMBING**

DATE: July 1, 2010
JOB #: 10-256

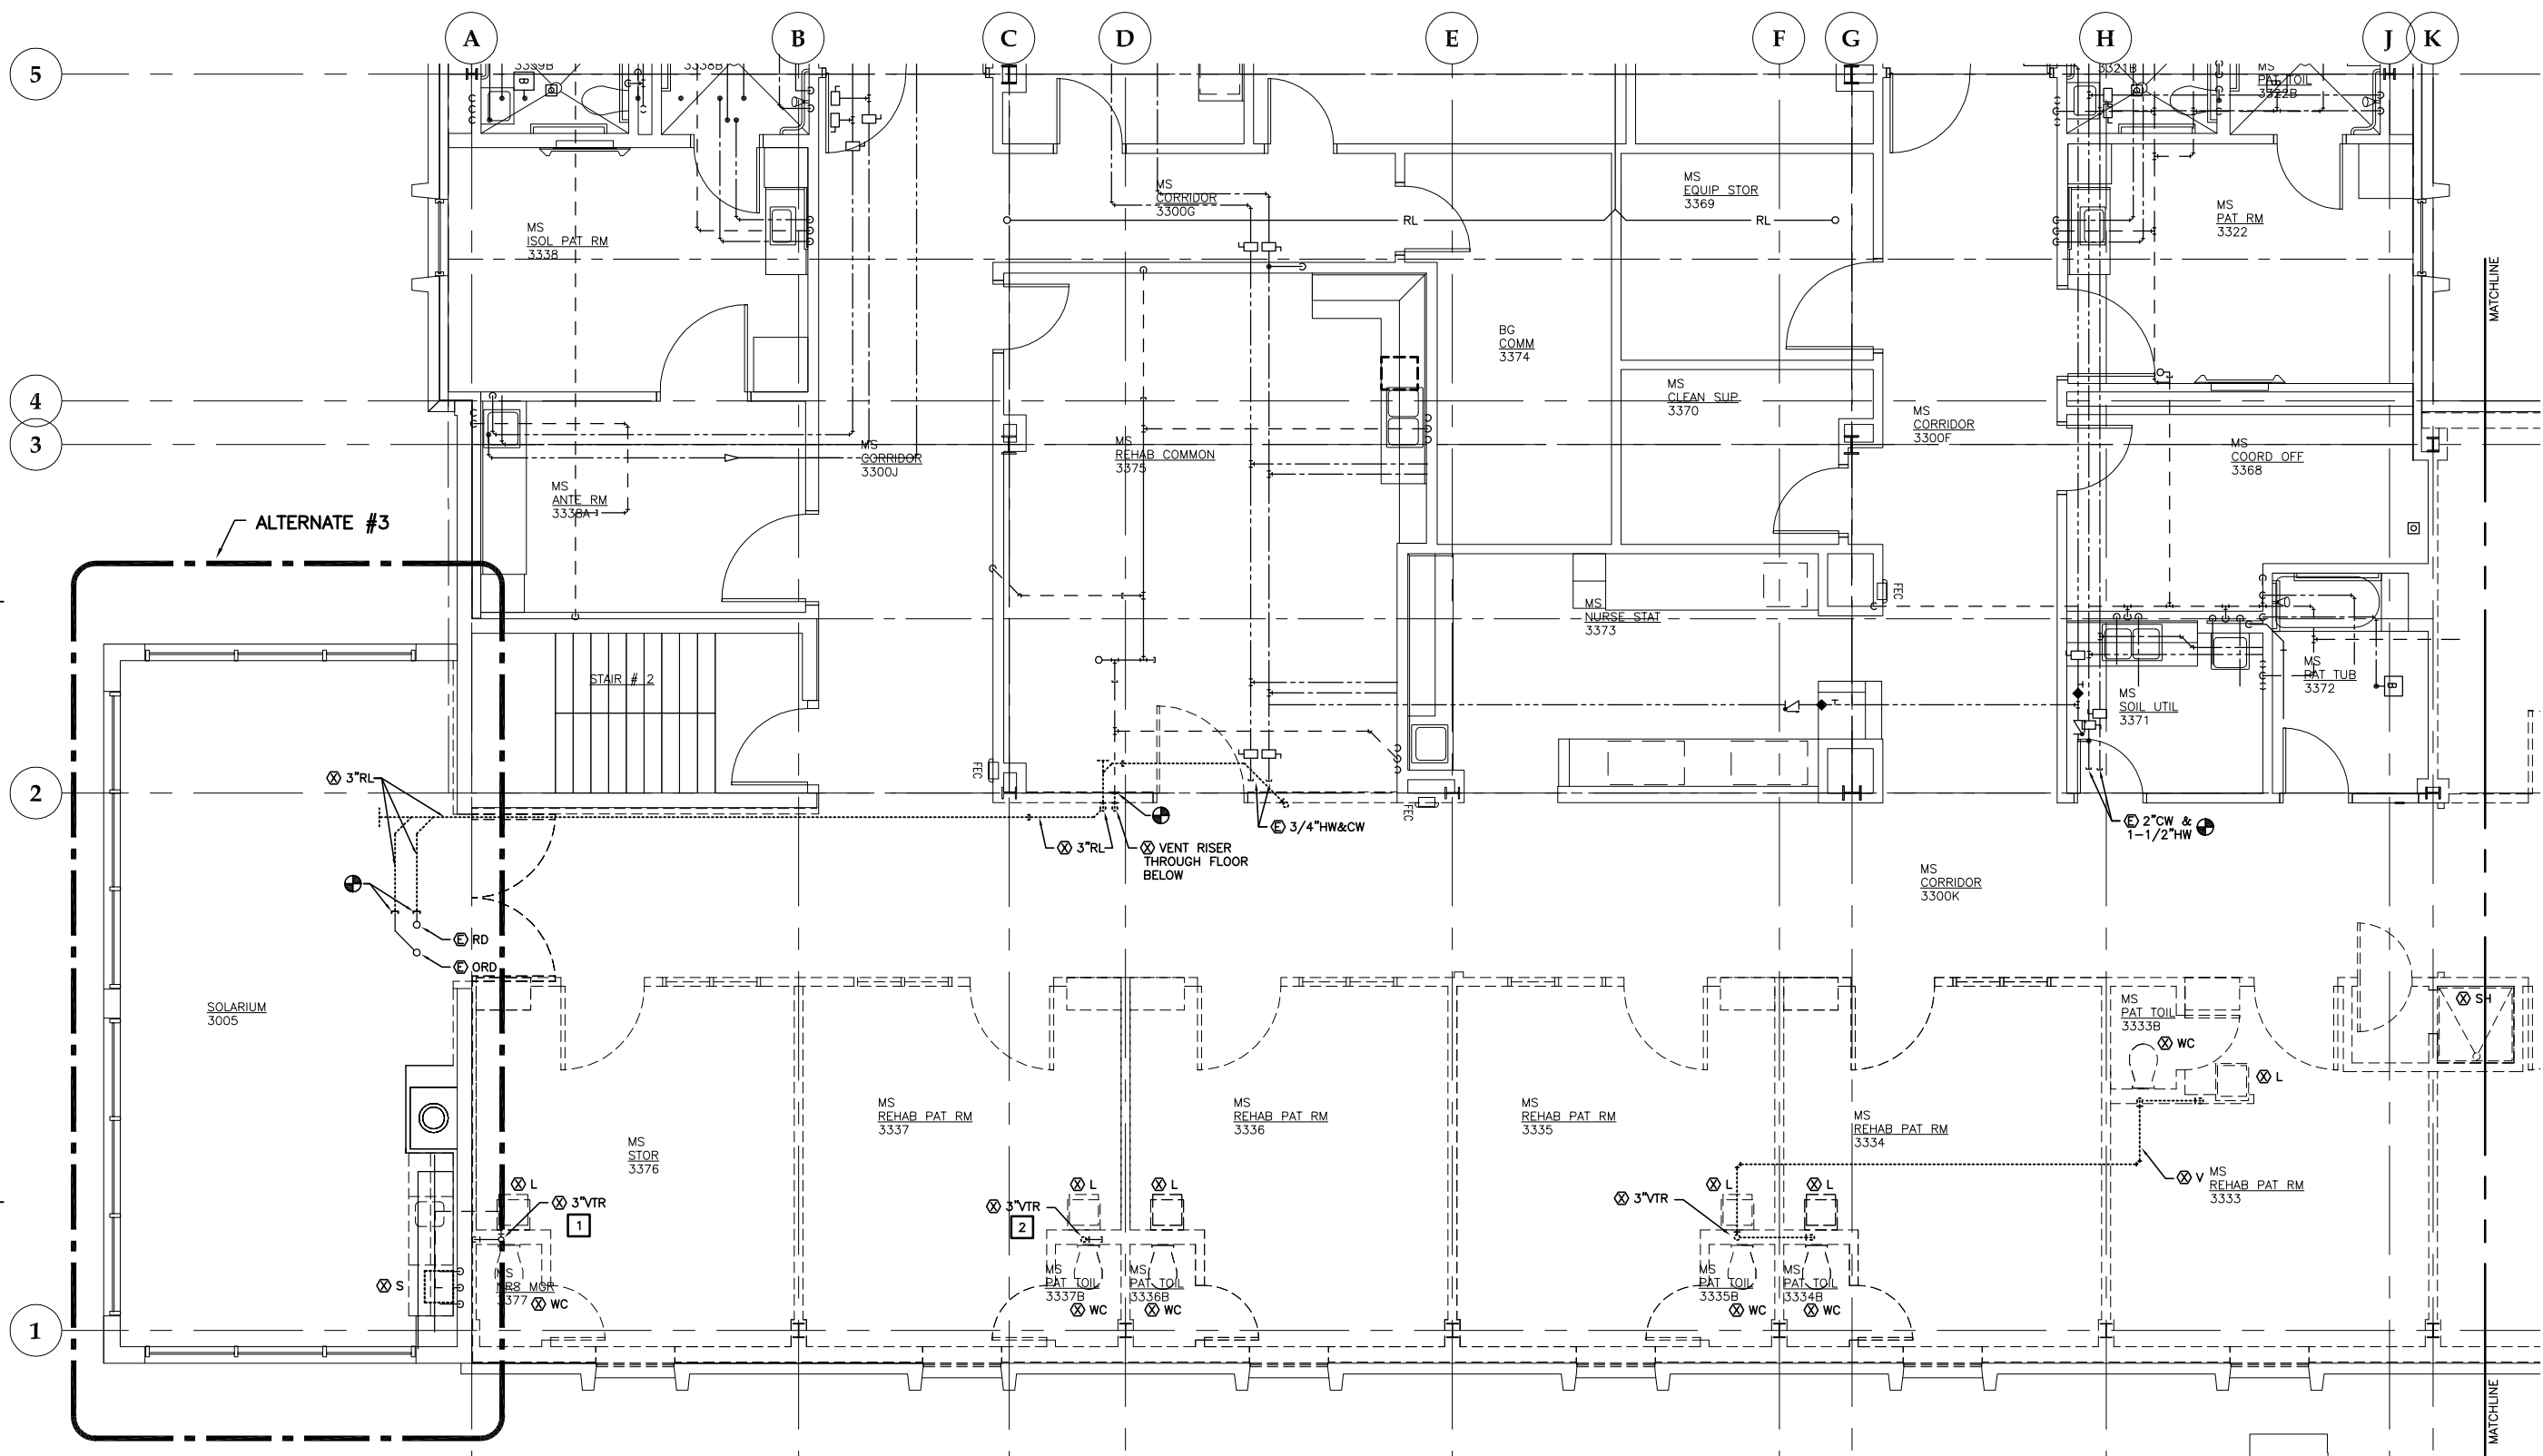


1 DEMOLITION FLOOR PLAN: LEVEL 3 SOUTH - PLUMBING

SCALE: 0 2' 4' 8'




DEMOLITION NOTES:

- 1 REMOVE VENT. CAP VENT THROUGH ROOF BELOW AND ABOVE ROOF WATER TIGHT.
- 2 REMOVE AND REPLACE VENT THROUGH ROOF, FLASHING, AND COUNTERFLASHING. MODIFY ROOF PENETRATION FOR A 4"VTR. COORDINATE WITH ROOF.

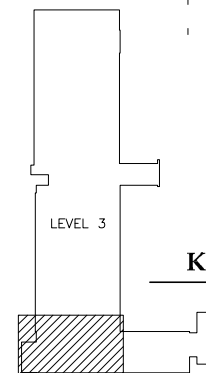

KEY PLAN

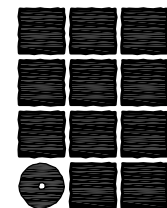

**Jensen
Yorba
Lott
Inc.**


522 West 10th Street
Juneau, Alaska 99801
phone 907-586-1070
fax 907-586-3959
jensenyorbalott.com

MURRAY &
ASSOCIATES P.C.

P.O. BOX 21081
Juneau, Alaska 99802-1081


phone 907-780-6151
fax 907-780-6182

www.murraypc.com

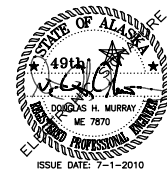

City & Borough of Juneau
Bartlett Regional Hospital
Medical / Surgical East Wing Renovation
CBJ Contract No. E10-221
Juneau, Alaska

 
CONSTRUCTION
DOCUMENTS




SHEET TITLE
DEMOLITION
FLOOR PLAN
LEVEL 3 - SOUTH
PLUMBING

DATE: July 1, 2010
JOB #: 10-256

P1206


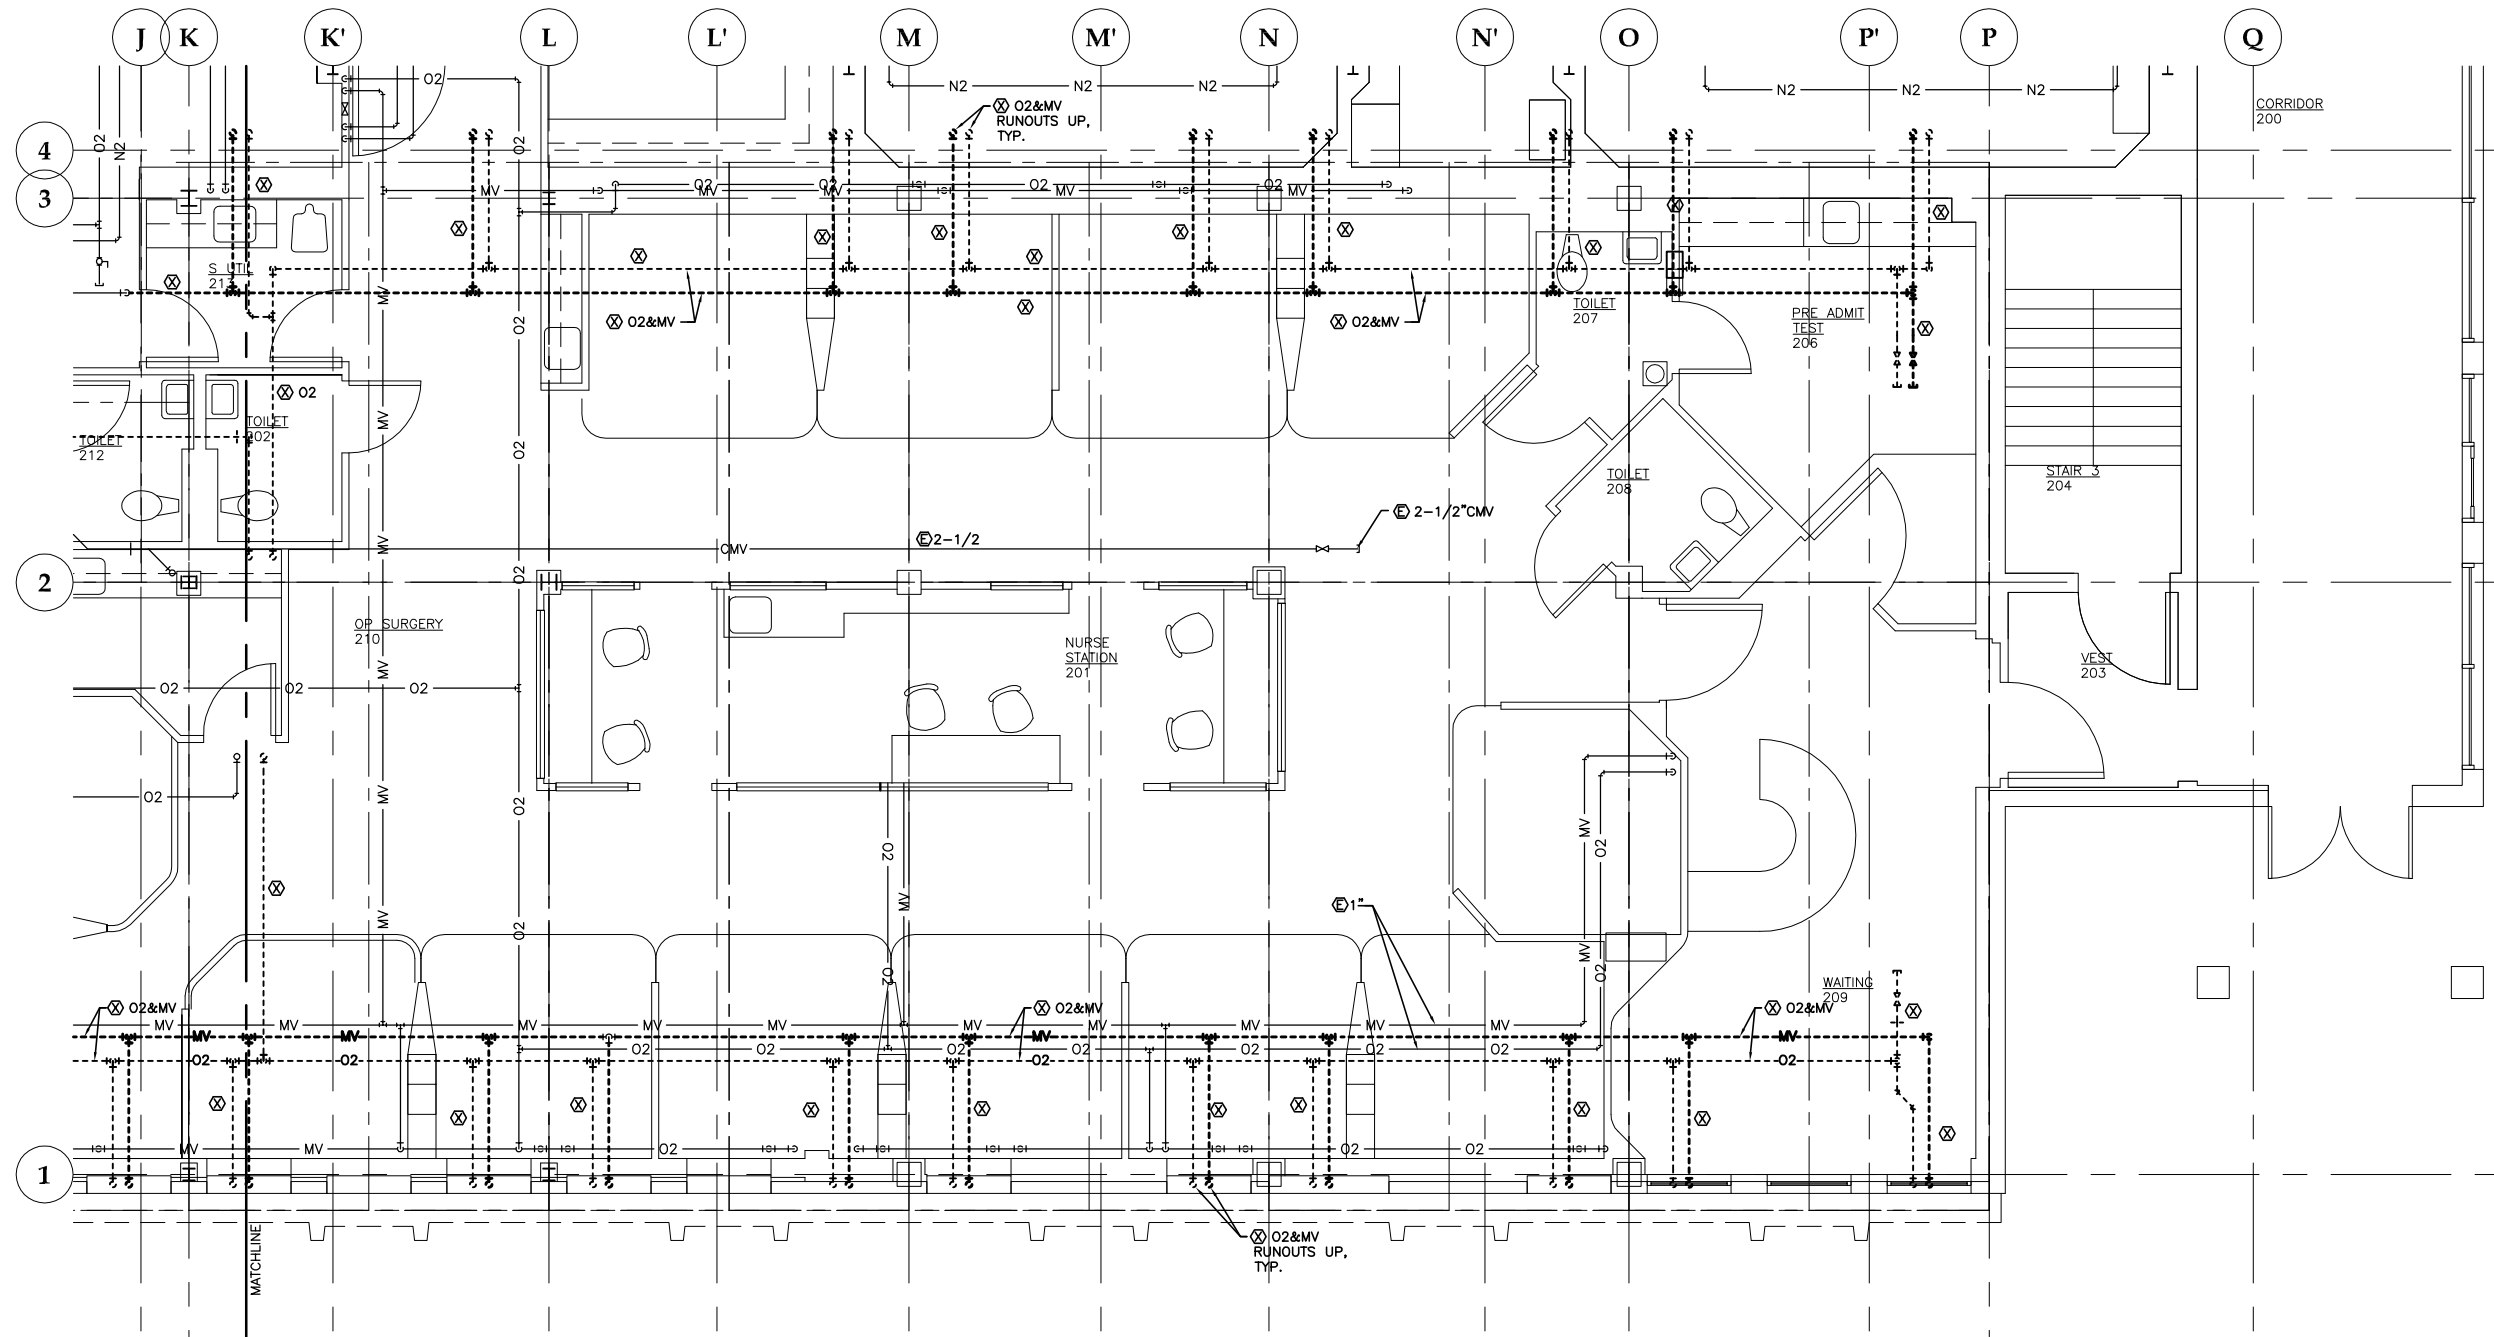


 1 DEMOLITION FLOOR PLAN: LEVEL 2 NORTH - MEDICAL GAS PIPING



DEMOLITION NOTES:

- △ MV IS TYPICALLY 1-1/4" - 1-1/2" SIZE, O2 IS TYPICALLY 3/4" - 1" SIZE.

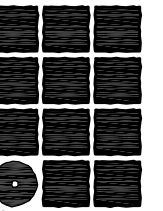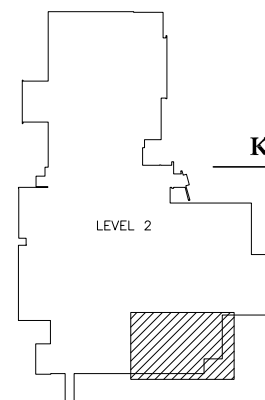

**Jensen
Yorba
Lott
Inc.**


522 West 10th Street
Juneau, Alaska 99801
phone 907-586-1070
fax 907-586-3959
jensenyorbalott.com

MURRAY &
ASSOCIATES P.C.

P.O. BOX 21081
Juneau, Alaska 99802-1081

phone 907-780-6151
fax 907-780-6182

www.murraypc.com

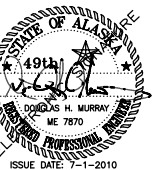

City & Borough of Juneau
Bartlett Regional Hospital
Medical / Surgical East Wing Renovation
CBJ Contract No. E10-221
Juneau, Alaska


CONSTRUCTION
DOCUMENTS

REVISIONS
△
△
△

SHEET TITLE
DEMOLITION
FLOOR PLAN
LEVEL 2 - NORTH
MED GAS PIPING

DATE: July 1, 2010
JOB #: 10-256

P1302

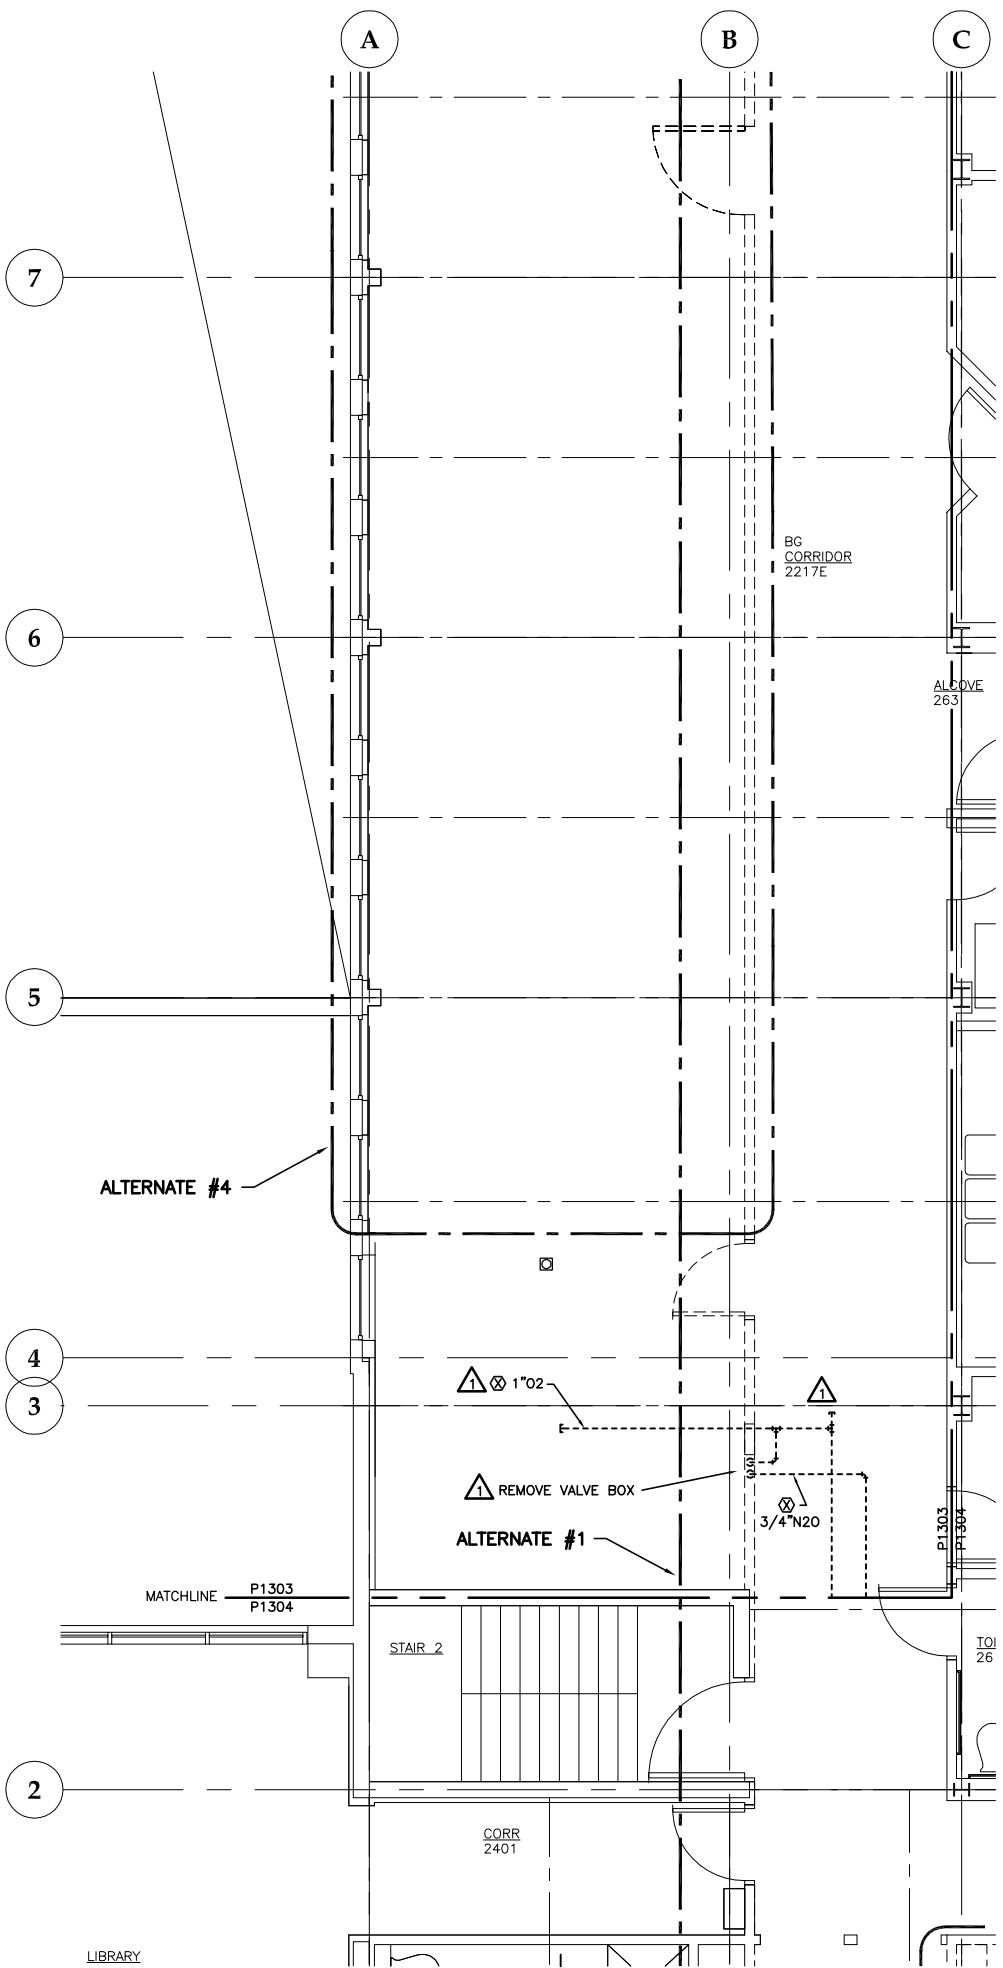


1 DEMOLITION FLOOR PLAN : LEVEL 2 CORRIDOR - MEDICAL GAS PIPING

SCALE: 0 2' 4' 8'


DEMOLITION NOTES:

- 1. COORDINATE VALVE BOX RELOCATION. REMOVE TEMPORARY CAP PROPRESS TYPE FITTING ON MED GAS PIPING. REPLACE CAP WITH PERMANENT; CAP. COORDINATE WORK WITH BRH MAINTENANCE STAFF.
- 2. 02 IS TYPICALLY 3/4" - 1" SIZE, N20 IS TYPICALLY 3/4" SIZE.

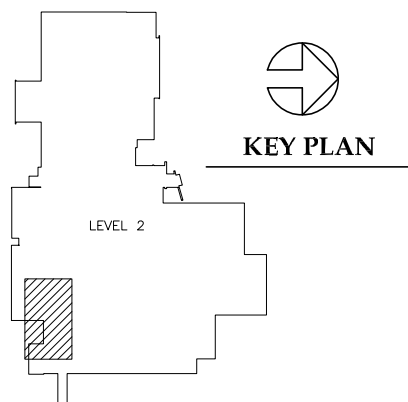

522 West 10th Street
Juneau, Alaska 99801
phone 907-586-1070
fax 907-586-3959
jensenyorbalott.com


MURRAY &
ASSOCIATES P.C.
P.O. BOX 21081
Juneau, Alaska 99802-1081
phone 907-780-6151
fax 907-780-6182
www.murraypc.com

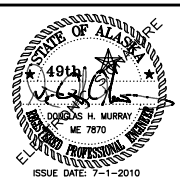


City & Borough of Juneau
Bartlett Regional Hospital
Medical / Surgical East Wing Renovation
CBJ Contract No. E10-221
Juneau, Alaska

CONSTRUCTION DOCUMENTS	
REVISIONS	
1	
2	
3	
SHEET TITLE	
DEMOLITION FLOOR PLAN LEVEL 2 CORRIDOR MED GAS PIPING	
DATE: July 1, 2010	
JOB #: 10-256	

P1303


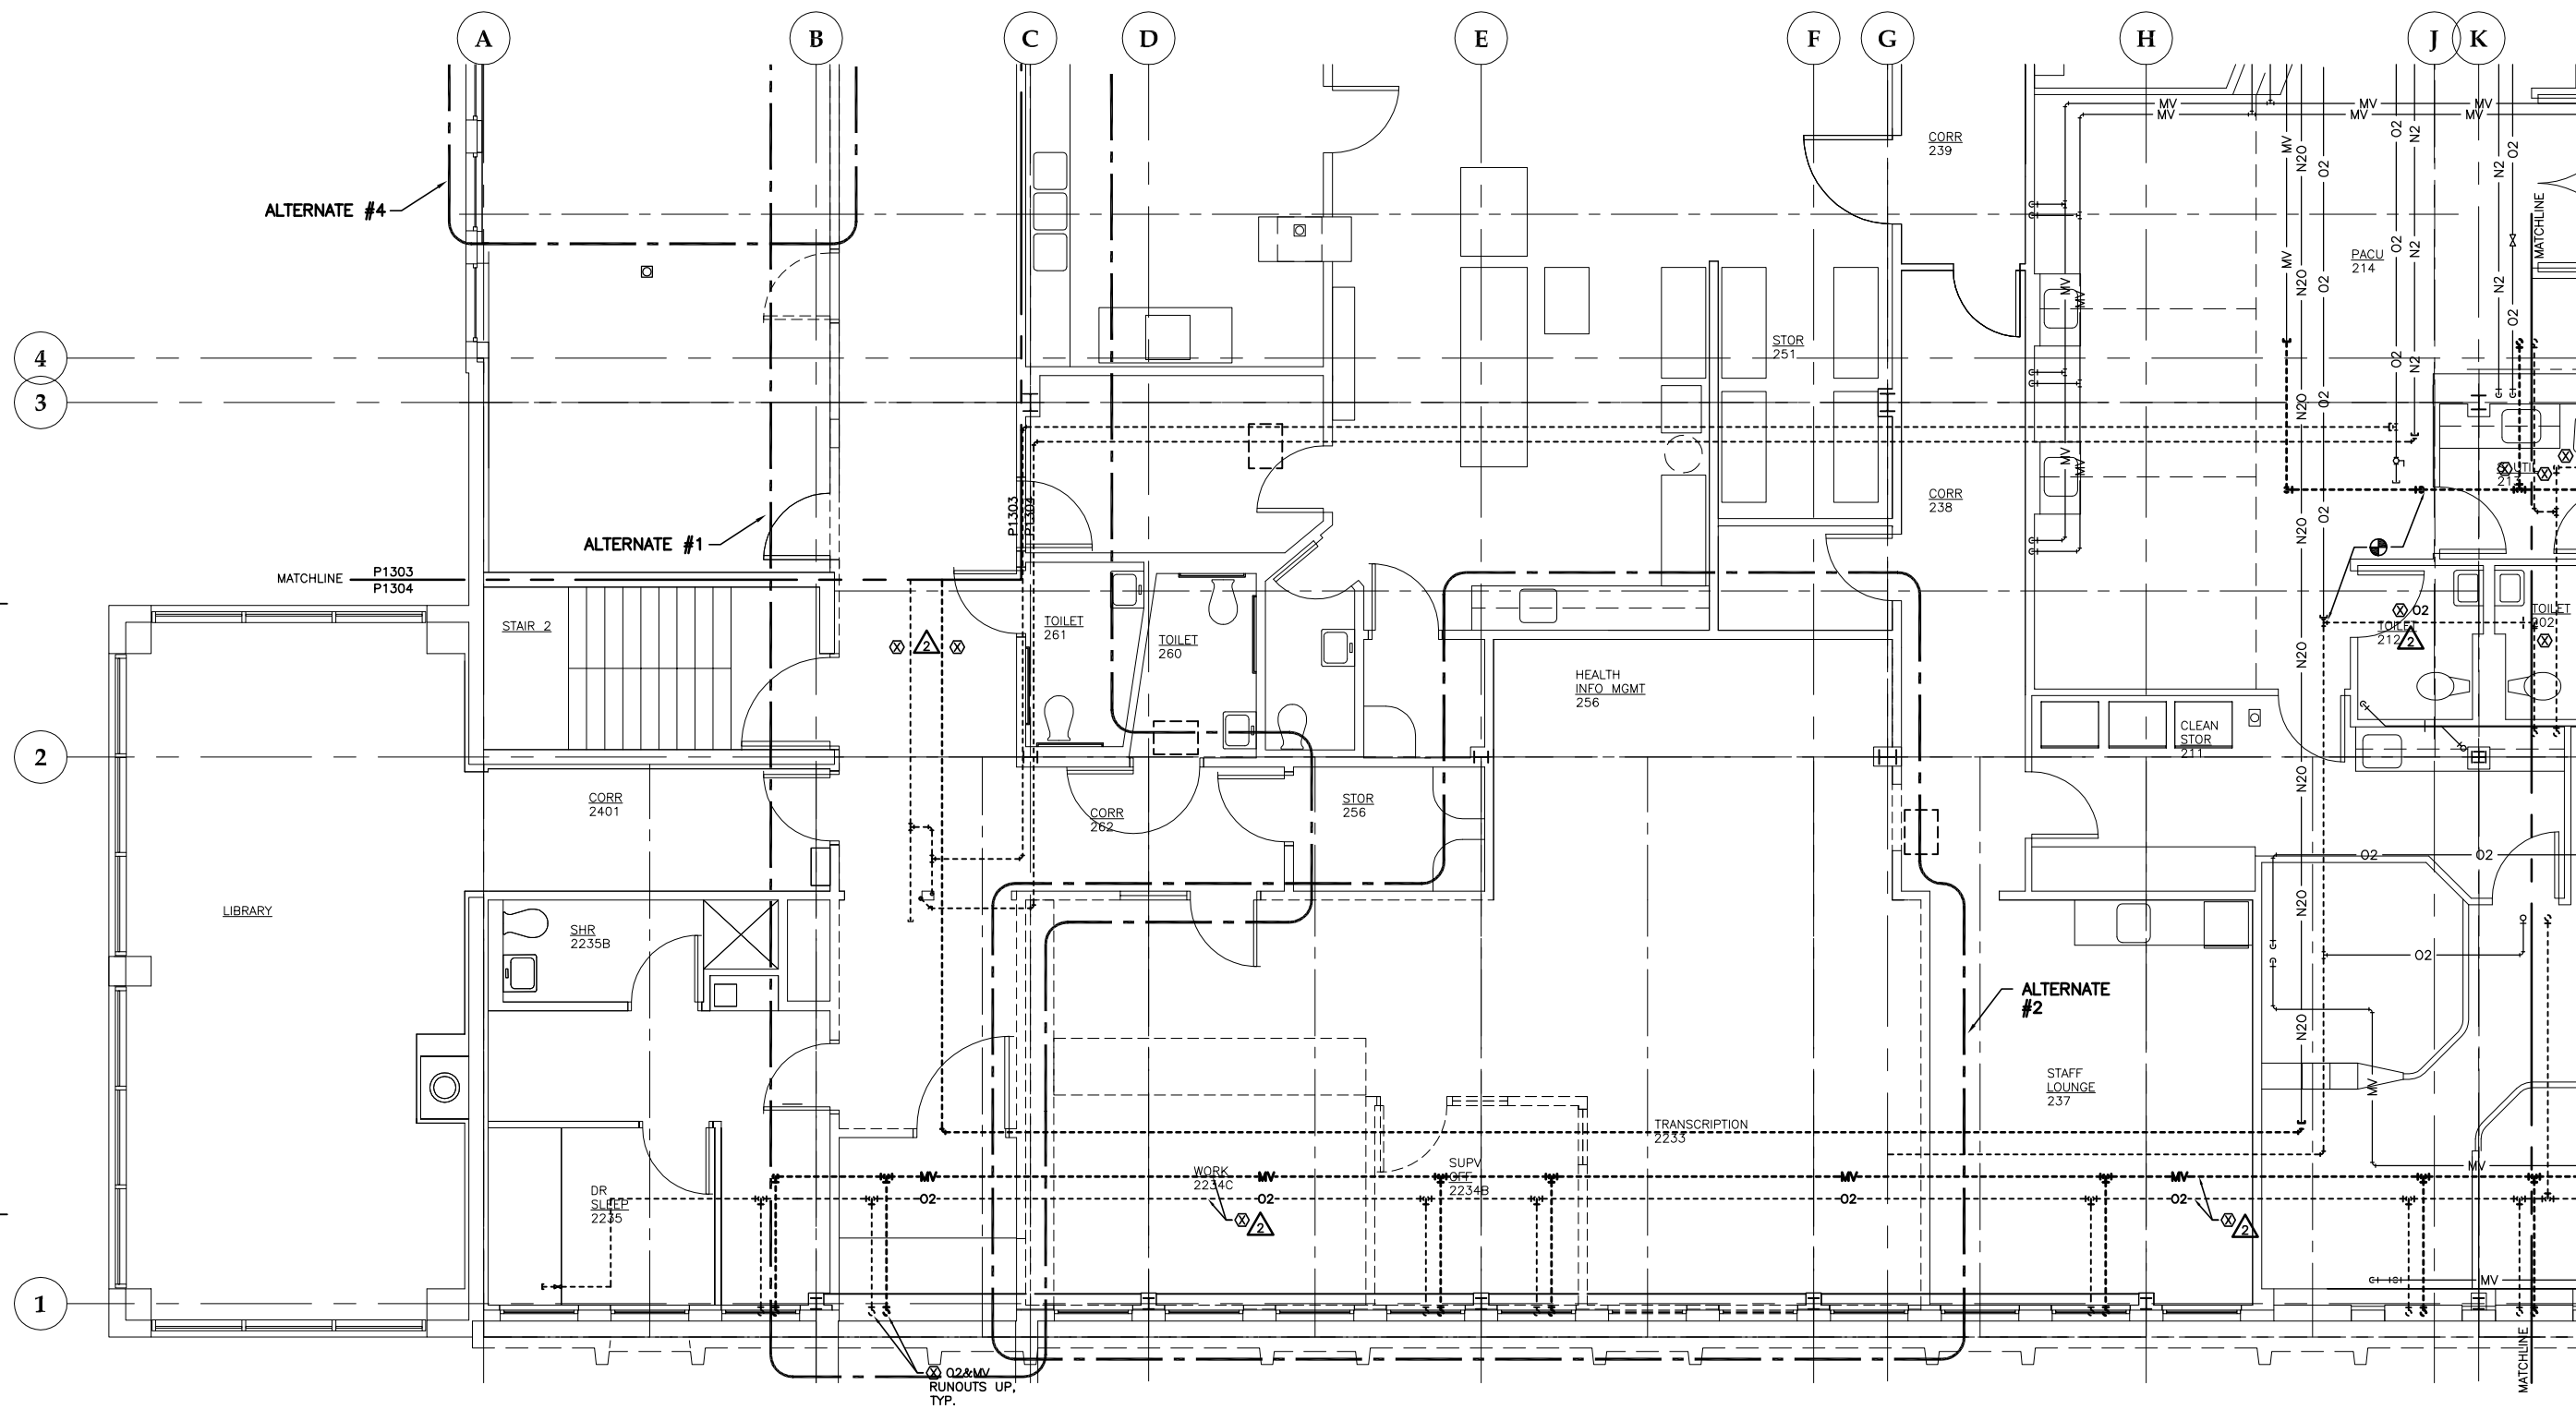


 1 DEMOLITION FLOOR PLAN: LEVEL 2 SOUTH - MEDICAL GAS PIPING



DEMOLITION NOTES:

- △ COORDINATE VALVE BOX RELOCATION. REMOVE TEMPORARY CAP PROPRESS TYPE FITTING ON MED GAS PIPING. REPLACE CAP WITH PERMANENT; CAP. COORDINATE WORK WITH BRH MAINTENANCE STAFF.
- △ MV IS TYPICALLY 1-1/4" - 1-1/2" SIZE, O2 IS TYPICALLY 3/4"-1" SIZE.

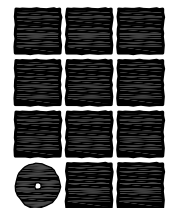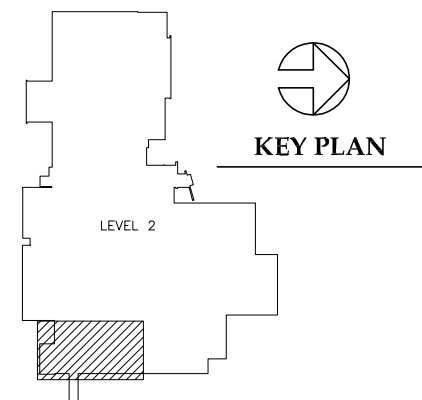

**Jensen
Yorba
Lott
Inc.**

522 West 10th Street
Juneau, Alaska 99801
phone 907-586-1070
fax 907-586-3959
jensenyorbalott.com

MURRAY &
ASSOCIATES P.C.

P.O. BOX 21081
Juneau, Alaska 99802-1081

phone 907-780-6151
fax 907-780-6182

www.murraypc.com



City & Borough of Juneau
Bartlett Regional Hospital
Medical / Surgical East Wing Renovation
CBJ Contract No. E10-221
Juneau, Alaska


CONSTRUCTION
DOCUMENTS

REVISIONS
△
△
△

SHEET TITLE
DEMOLITION
FLOOR PLAN
LEVEL 2 - SOUTH
MED GAS PIPING



DATE: July 1, 2010
JOB #: 10-256

P1304

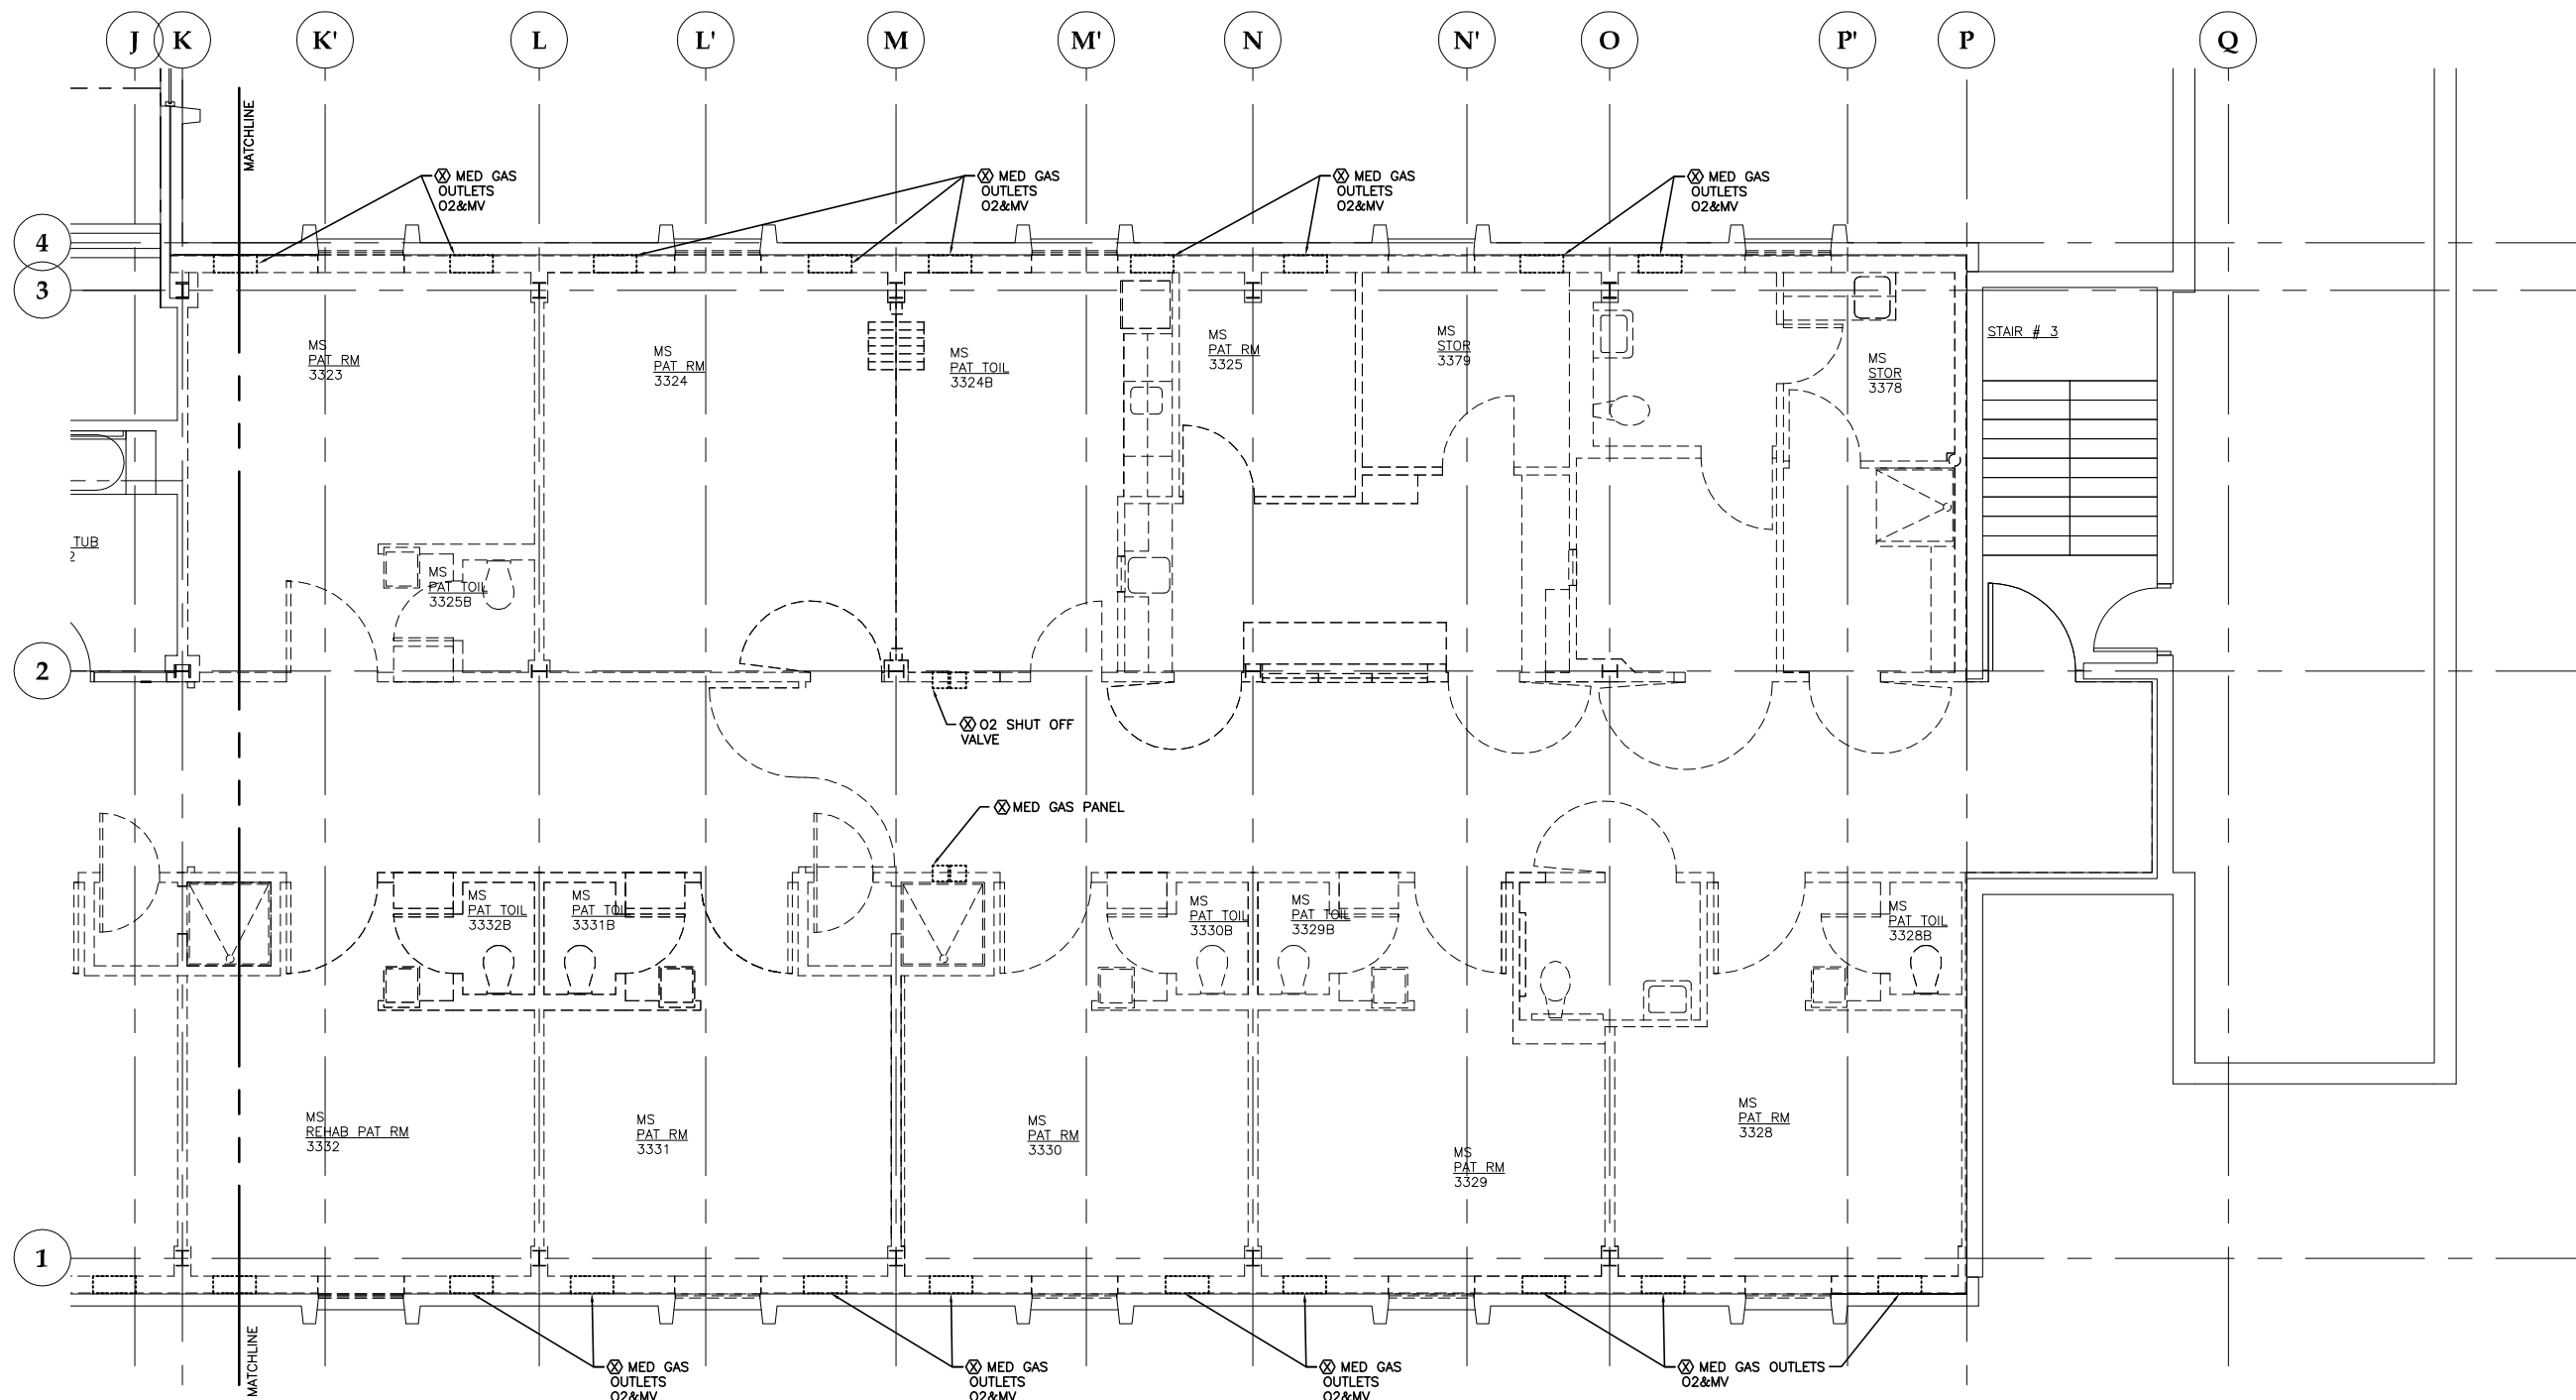

1 DEMOLITION FLOOR PLAN: LEVEL 3 NORTH - MEDICAL GAS PIPING

SCALE: 0 2' 4' 8'

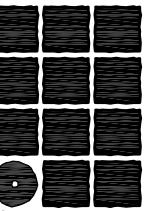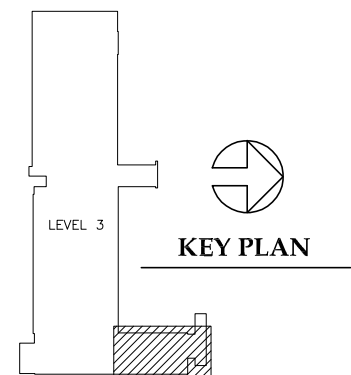

**Jensen
Yorba
Lott**
Inc.


522 West 10th Street
Juneau, Alaska 99801
phone 907-586-1070
fax 907-586-3959
jensenyorbalott.com

MURRAY &
ASSOCIATES P.C.

P.O. BOX 21081
Juneau, Alaska 99802-1081

phone 907-780-6151
fax 907-780-6182

www.murraypc.com

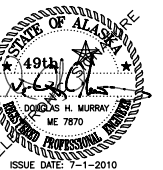

City & Borough of Juneau
Bartlett Regional Hospital
Medical / Surgical East Wing Renovation
CBJ Contract No. E10-221
Juneau, Alaska


CONSTRUCTION
DOCUMENTS

REVISIONS
△
△
△

SHEET TITLE
DEMOLITION
FLOOR PLAN
LEVEL 3 - NORTH
MED GAS PIPING

DATE: July 1, 2010
JOB #: 10-256

P1305

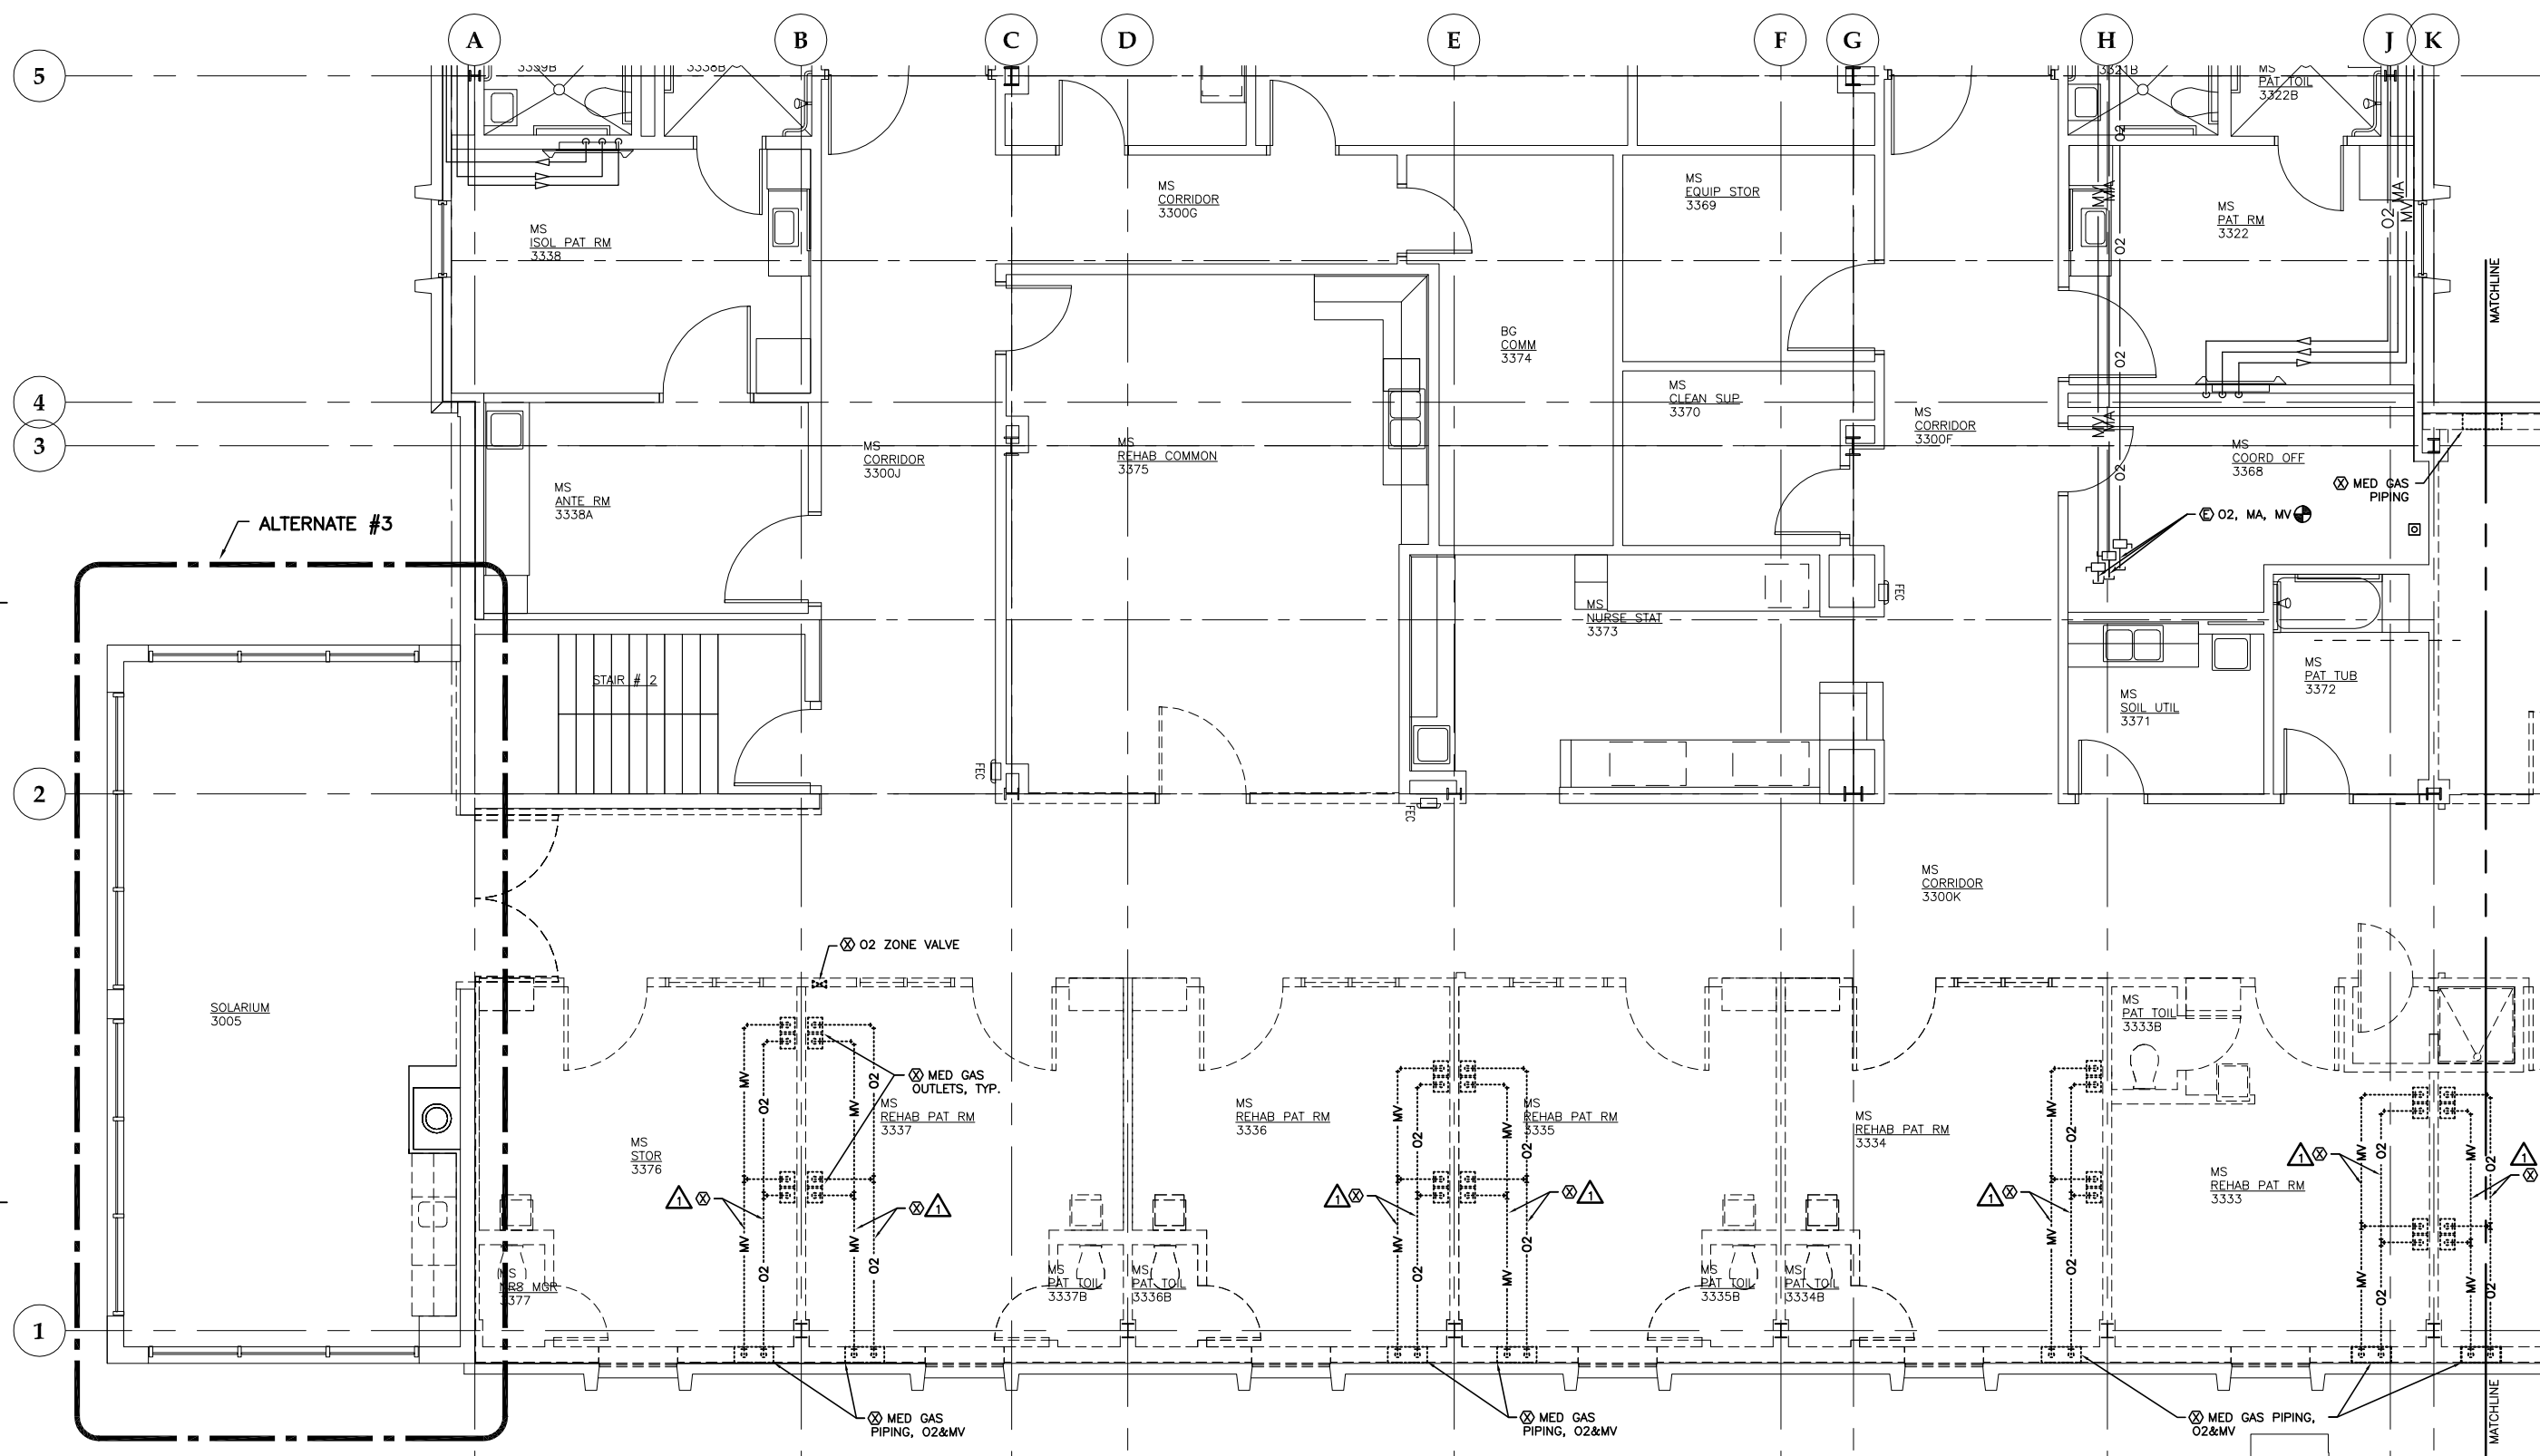



1 DEMOLITION FLOOR PLAN: LEVEL 3 SOUTH - MEDICAL GAS PIPING

SCALE: 0 2' 4' 8'




DEMOLITION NOTES:

 △ MV IS TYPICALLY 1-1/4" - 1-1/2" SIZE, O2 IS TYPICALLY 3/4" - 1" SIZE.

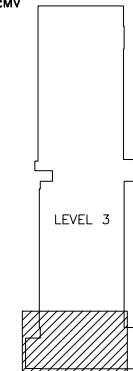

KEY PLAN

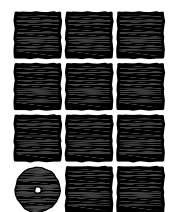


**Jensen
Yorba
Lott
Inc.**

522 West 10th Street
Juneau, Alaska 99801
phone 907-586-1070
fax 907-586-3959
jensenyorbalott.com

MURRAY &
ASSOCIATES P.C.

P.O. BOX 21081
Juneau, Alaska 99802-1081
phone 907-780-6151
fax 907-780-6182
www.murraypc.com

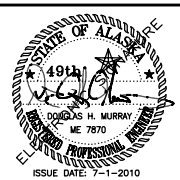

City & Borough of Juneau
Bartlett Regional Hospital
Medical / Surgical East Wing Renovation
CBJ Contract No. E10-221
Juneau, Alaska


CONSTRUCTION
DOCUMENTS

REVISIONS
△
△
△



SHEET TITLE
DEMOLITION
FLOOR PLAN
LEVEL 3 - SOUTH
MED GAS PIPING

DATE: July 1, 2010
JOB #: 10-256

P1306

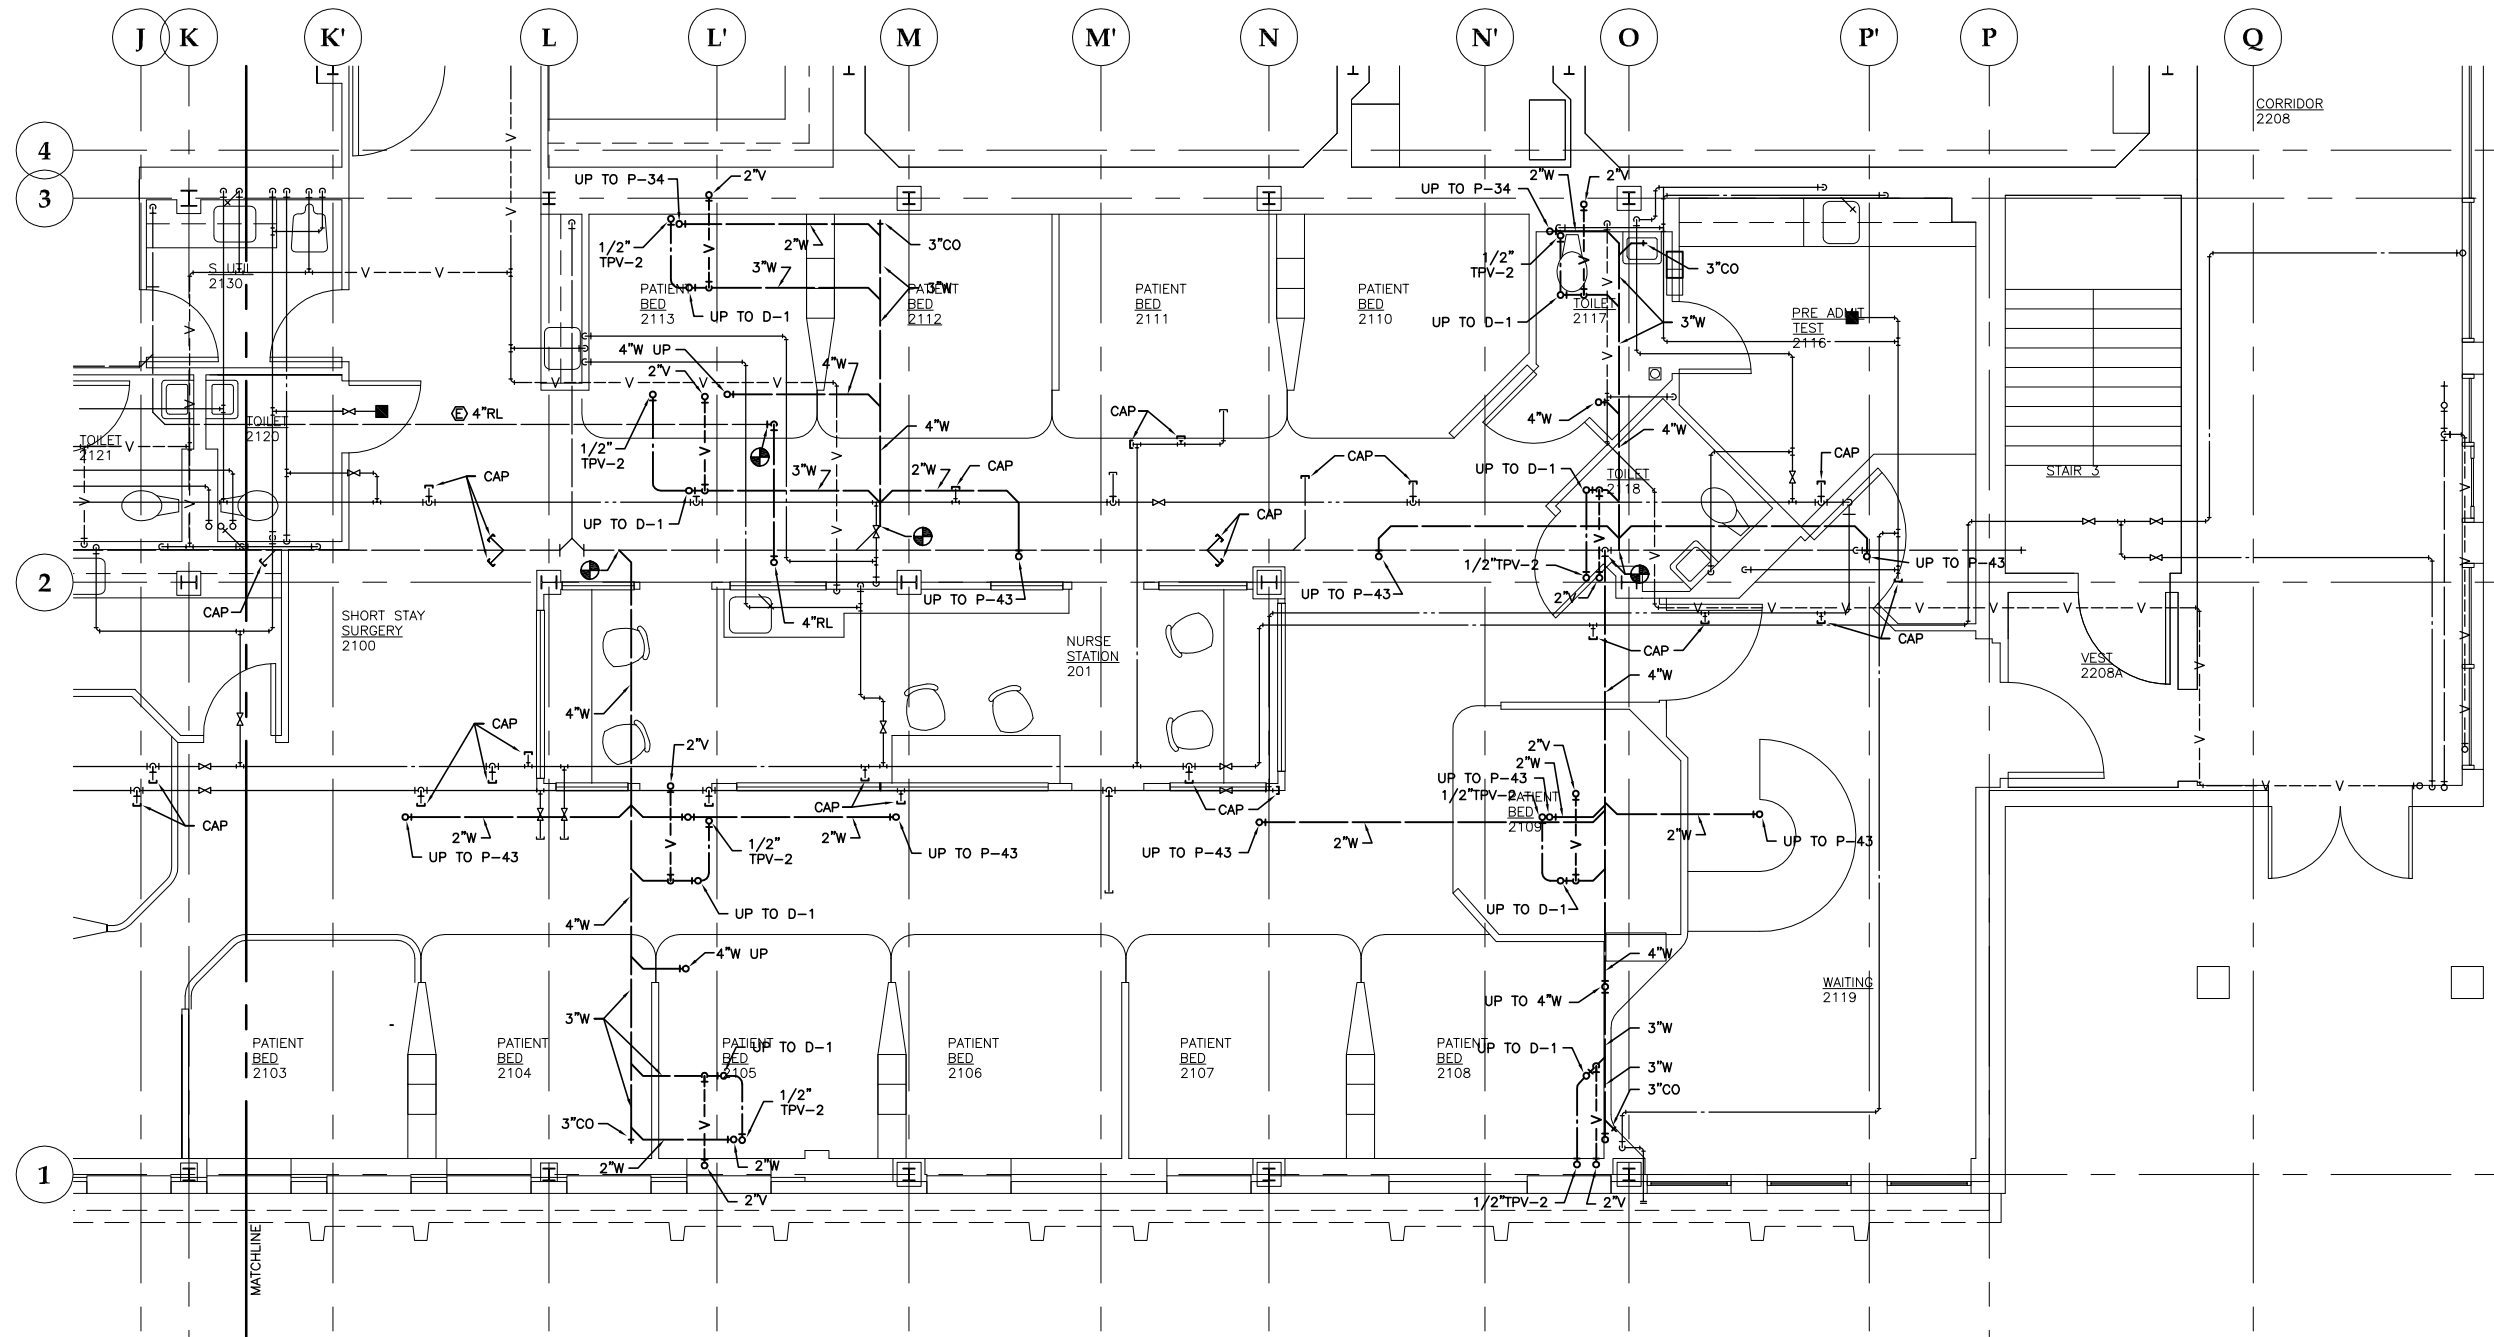

1 FLOOR PLAN: LEVEL 2 NORTH- PLUMBING

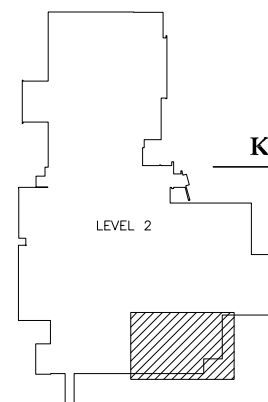 


KEY PLAN

Jensen Yorba Lott Inc.

522 West 10th Street
Juneau, Alaska 99801
phone 907-586-1070
fax 907-586-3959
jensenyorbalott.com

MURRAY & ASSOCIATES P.C.
P.O. BOX 21081
Juneau, Alaska 99802-1081
phone 907-780-6151
fax 907-780-6182
www.murraypc.com

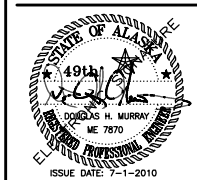

City & Borough of Juneau
Bartlett Regional Hospital
Medical/ Surgical East Wing Renovation
CBJ Contract No. E10-221
Juneau, Alaska

CONSTRUCTION DOCUMENTS


REVISIONS

△	
△	
△	



SHEET TITLE
FLOOR PLAN
LEVEL 2 - NORTH
PLUMBING

DATE: July 1, 2010
JOB #: 10-256


P202

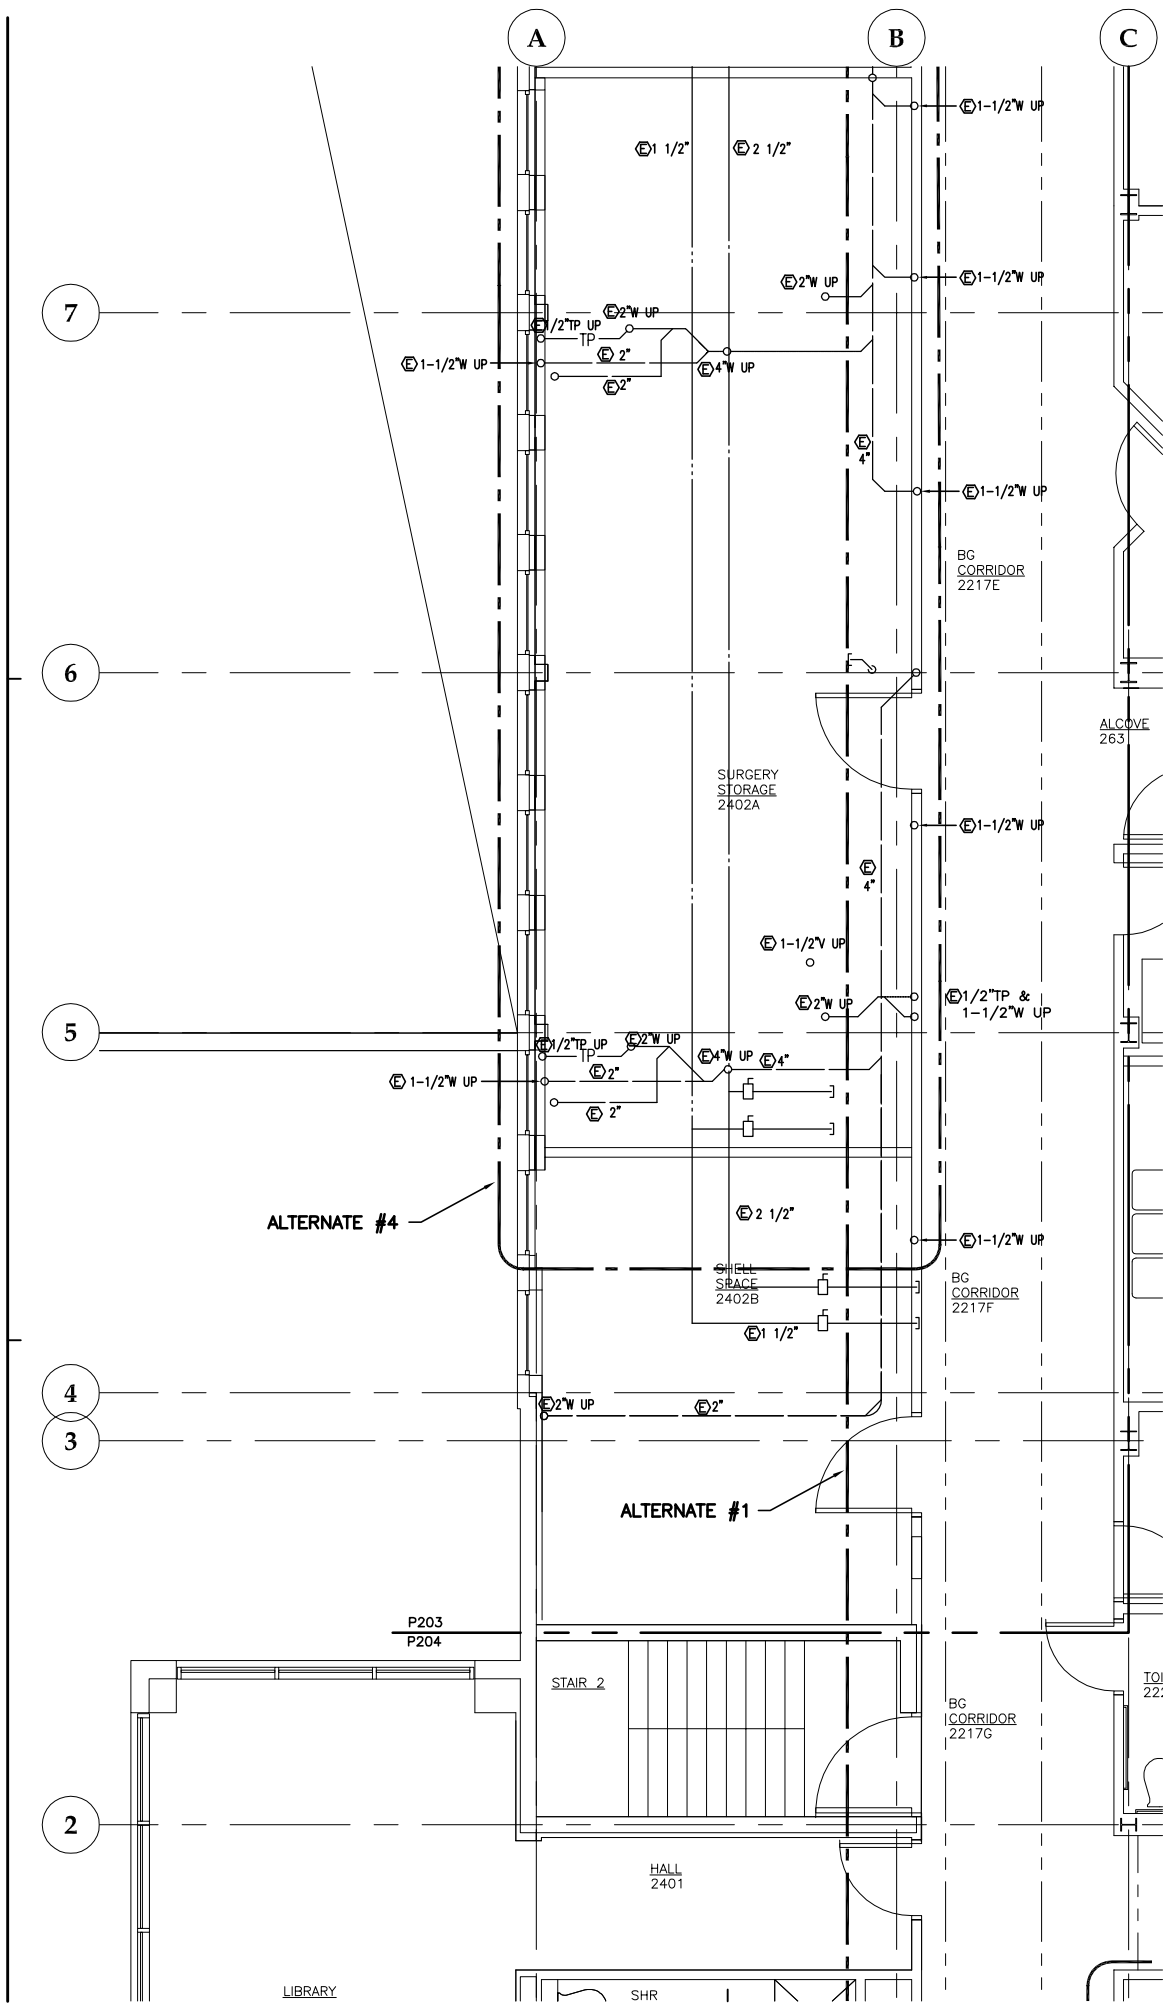

 1 FLOOR PLAN : LEVEL 2 CORRIDOR PLUMBING

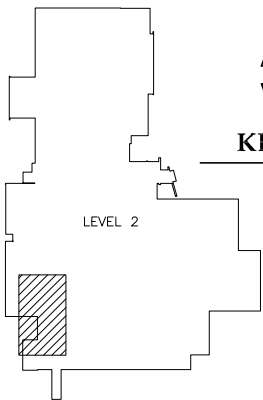

KEY PLAN

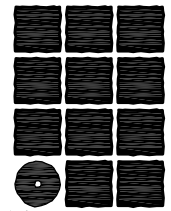

**Jensen
Yorba
Lott
Inc.**

522 West 10th Street
Juneau, Alaska 99801
phone 907-586-1070
fax 907-586-3959
jensenyorbalott.com

MURRAY &
ASSOCIATES P.C.

P.O. BOX 21081
Juneau, Alaska 99802-1081

phone 907-780-6151
fax 907-780-6182

www.murraypc.com



City & Borough of Juneau
Bartlett Regional Hospital
Medical / Surgical East Wing Renovation
CBJ Contract No. E10-221
Juneau, Alaska


CONSTRUCTION
DOCUMENTS






SHEET TITLE
FLOOR PLAN
LEVEL 2 - CORRIDOR
PLUMBING

DATE: July 1, 2010
JOB #: 10-256

P203

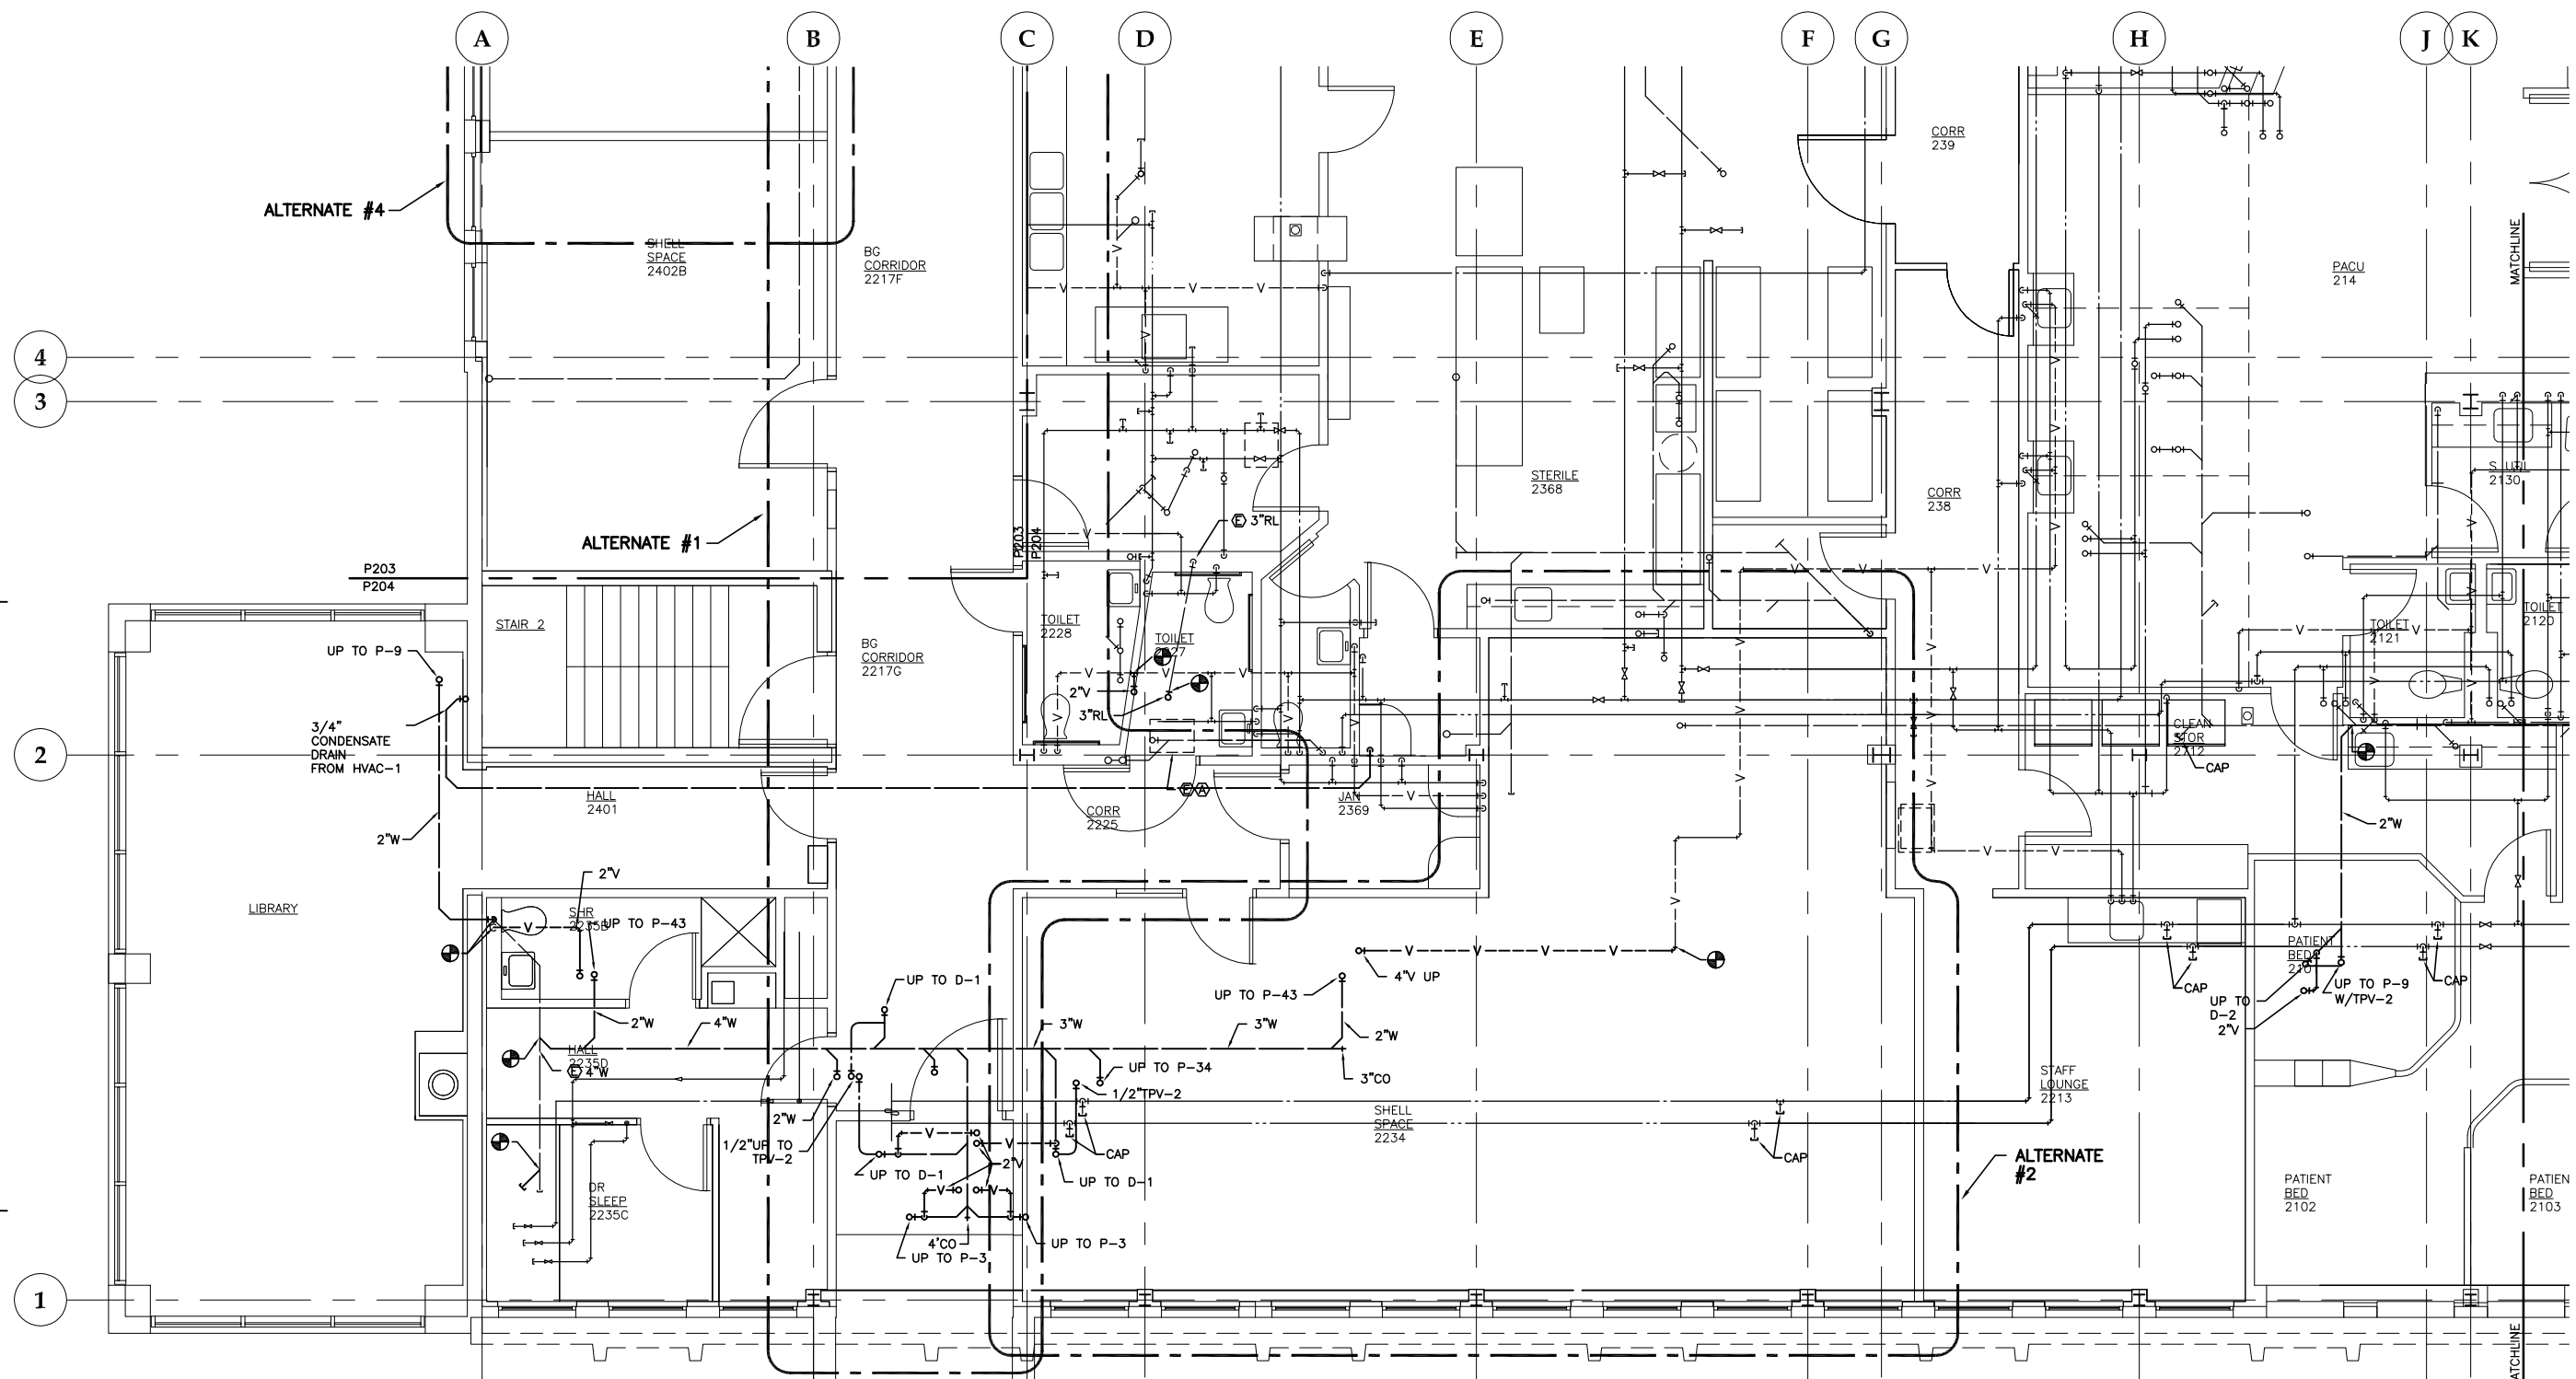

1 FLOOR PLAN: LEVEL 2 SOUTH - PLUMBING

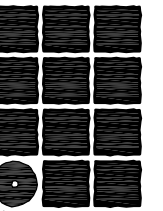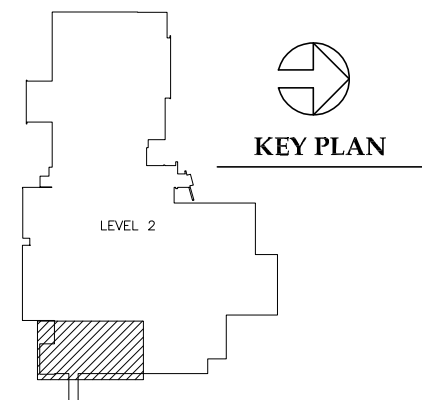 

**Jensen
Yorba
Lott
Inc.**


522 West 10th Street
Juneau, Alaska 99801
phone 907-586-1070
fax 907-586-3959
jensenyorbalott.com

MURRAY &
ASSOCIATES P.C.

P.O. BOX 21081
Juneau, Alaska 99802-1081


phone 907-780-6151
fax 907-780-6182

www.murraypc.com

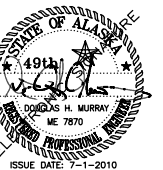

**City & Borough of Juneau
Bartlett Regional Hospital
Medical / Surgical East Wing Renovation
CBJ Contract No. E10-221
Juneau, Alaska**

 
CONSTRUCTION
DOCUMENTS




SHEET TITLE
FLOOR PLAN
LEVEL 2 - SOUTH
PLUMBING

DATE: July 1, 2010
JOB #: 10-256


P204

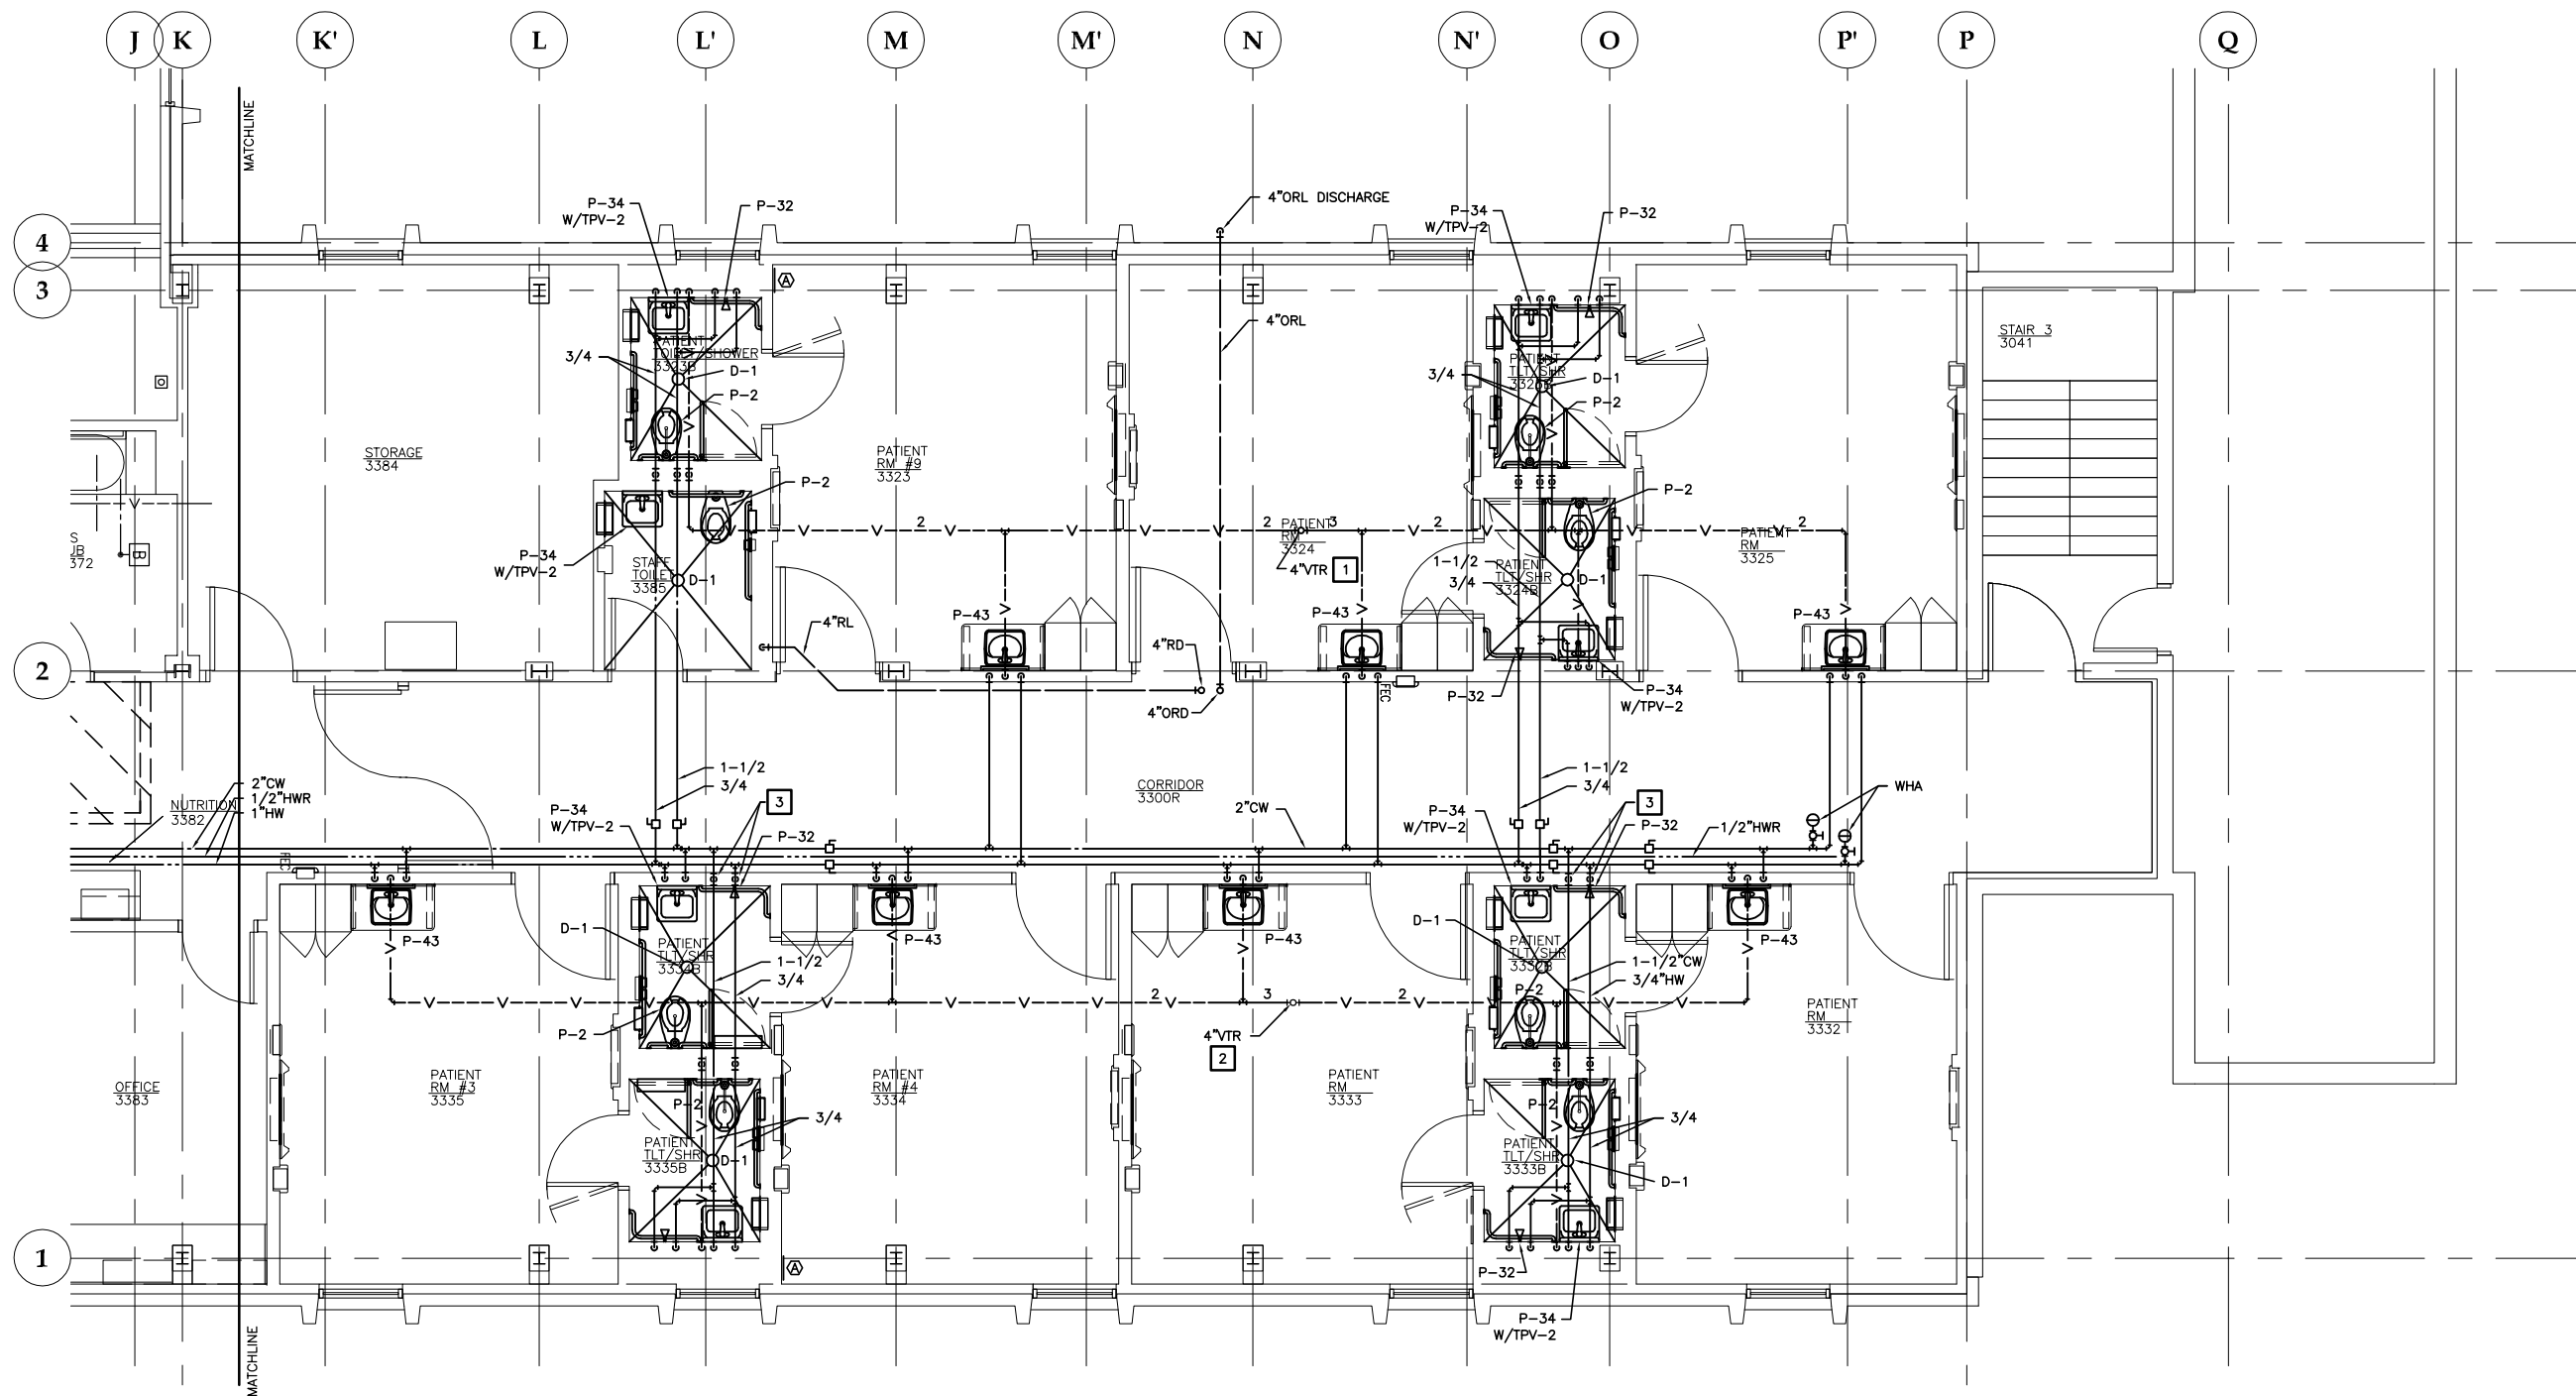

1 FLOOR PLAN: LEVEL 3 - NORTH PLUMBING

 

- CONSTRUCTION NOTES:**
- 1** REPLACE 3"VTR WITH 4"VTR, ROOF FLASHING, AND COUNTERFLASHING.
 - 2** REPLACE 4"VTR WITH 4"VTR, ROOF FLASHING, AND COUNTERFLASHING.
 - 3** INSTALL ISOLATION VALVE. ACCESSIBLE IN HALL.

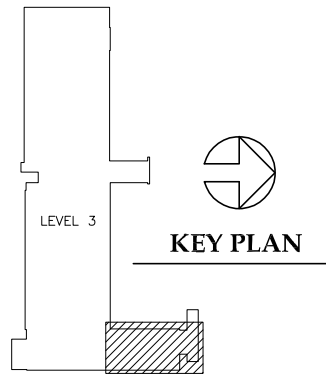


Jensen Yorba Lott Inc.

522 West 10th Street
Juneau, Alaska 99801
phone 907-586-1070
fax 907-586-3959
jensenyorbalott.com

MURRAY & ASSOCIATES P.C.

P.O. BOX 21081
Juneau, Alaska 99802-1081
phone 907-780-6151
fax 907-780-6182
www.murraypc.com

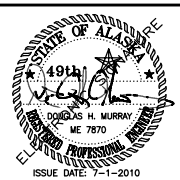

**City & Borough of Juneau
Bartlett Regional Hospital
Medical / Surgical East Wing Renovation
CBJ Contract No. E10-221
Juneau, Alaska**


CONSTRUCTION DOCUMENTS

REVISIONS


- △ .
- △ .
- △ .

SHEET TITLE
**FLOOR PLAN
LEVEL 3 - NORTH
PLUMBING**

DATE: July 1, 2010
JOB #: 10-256


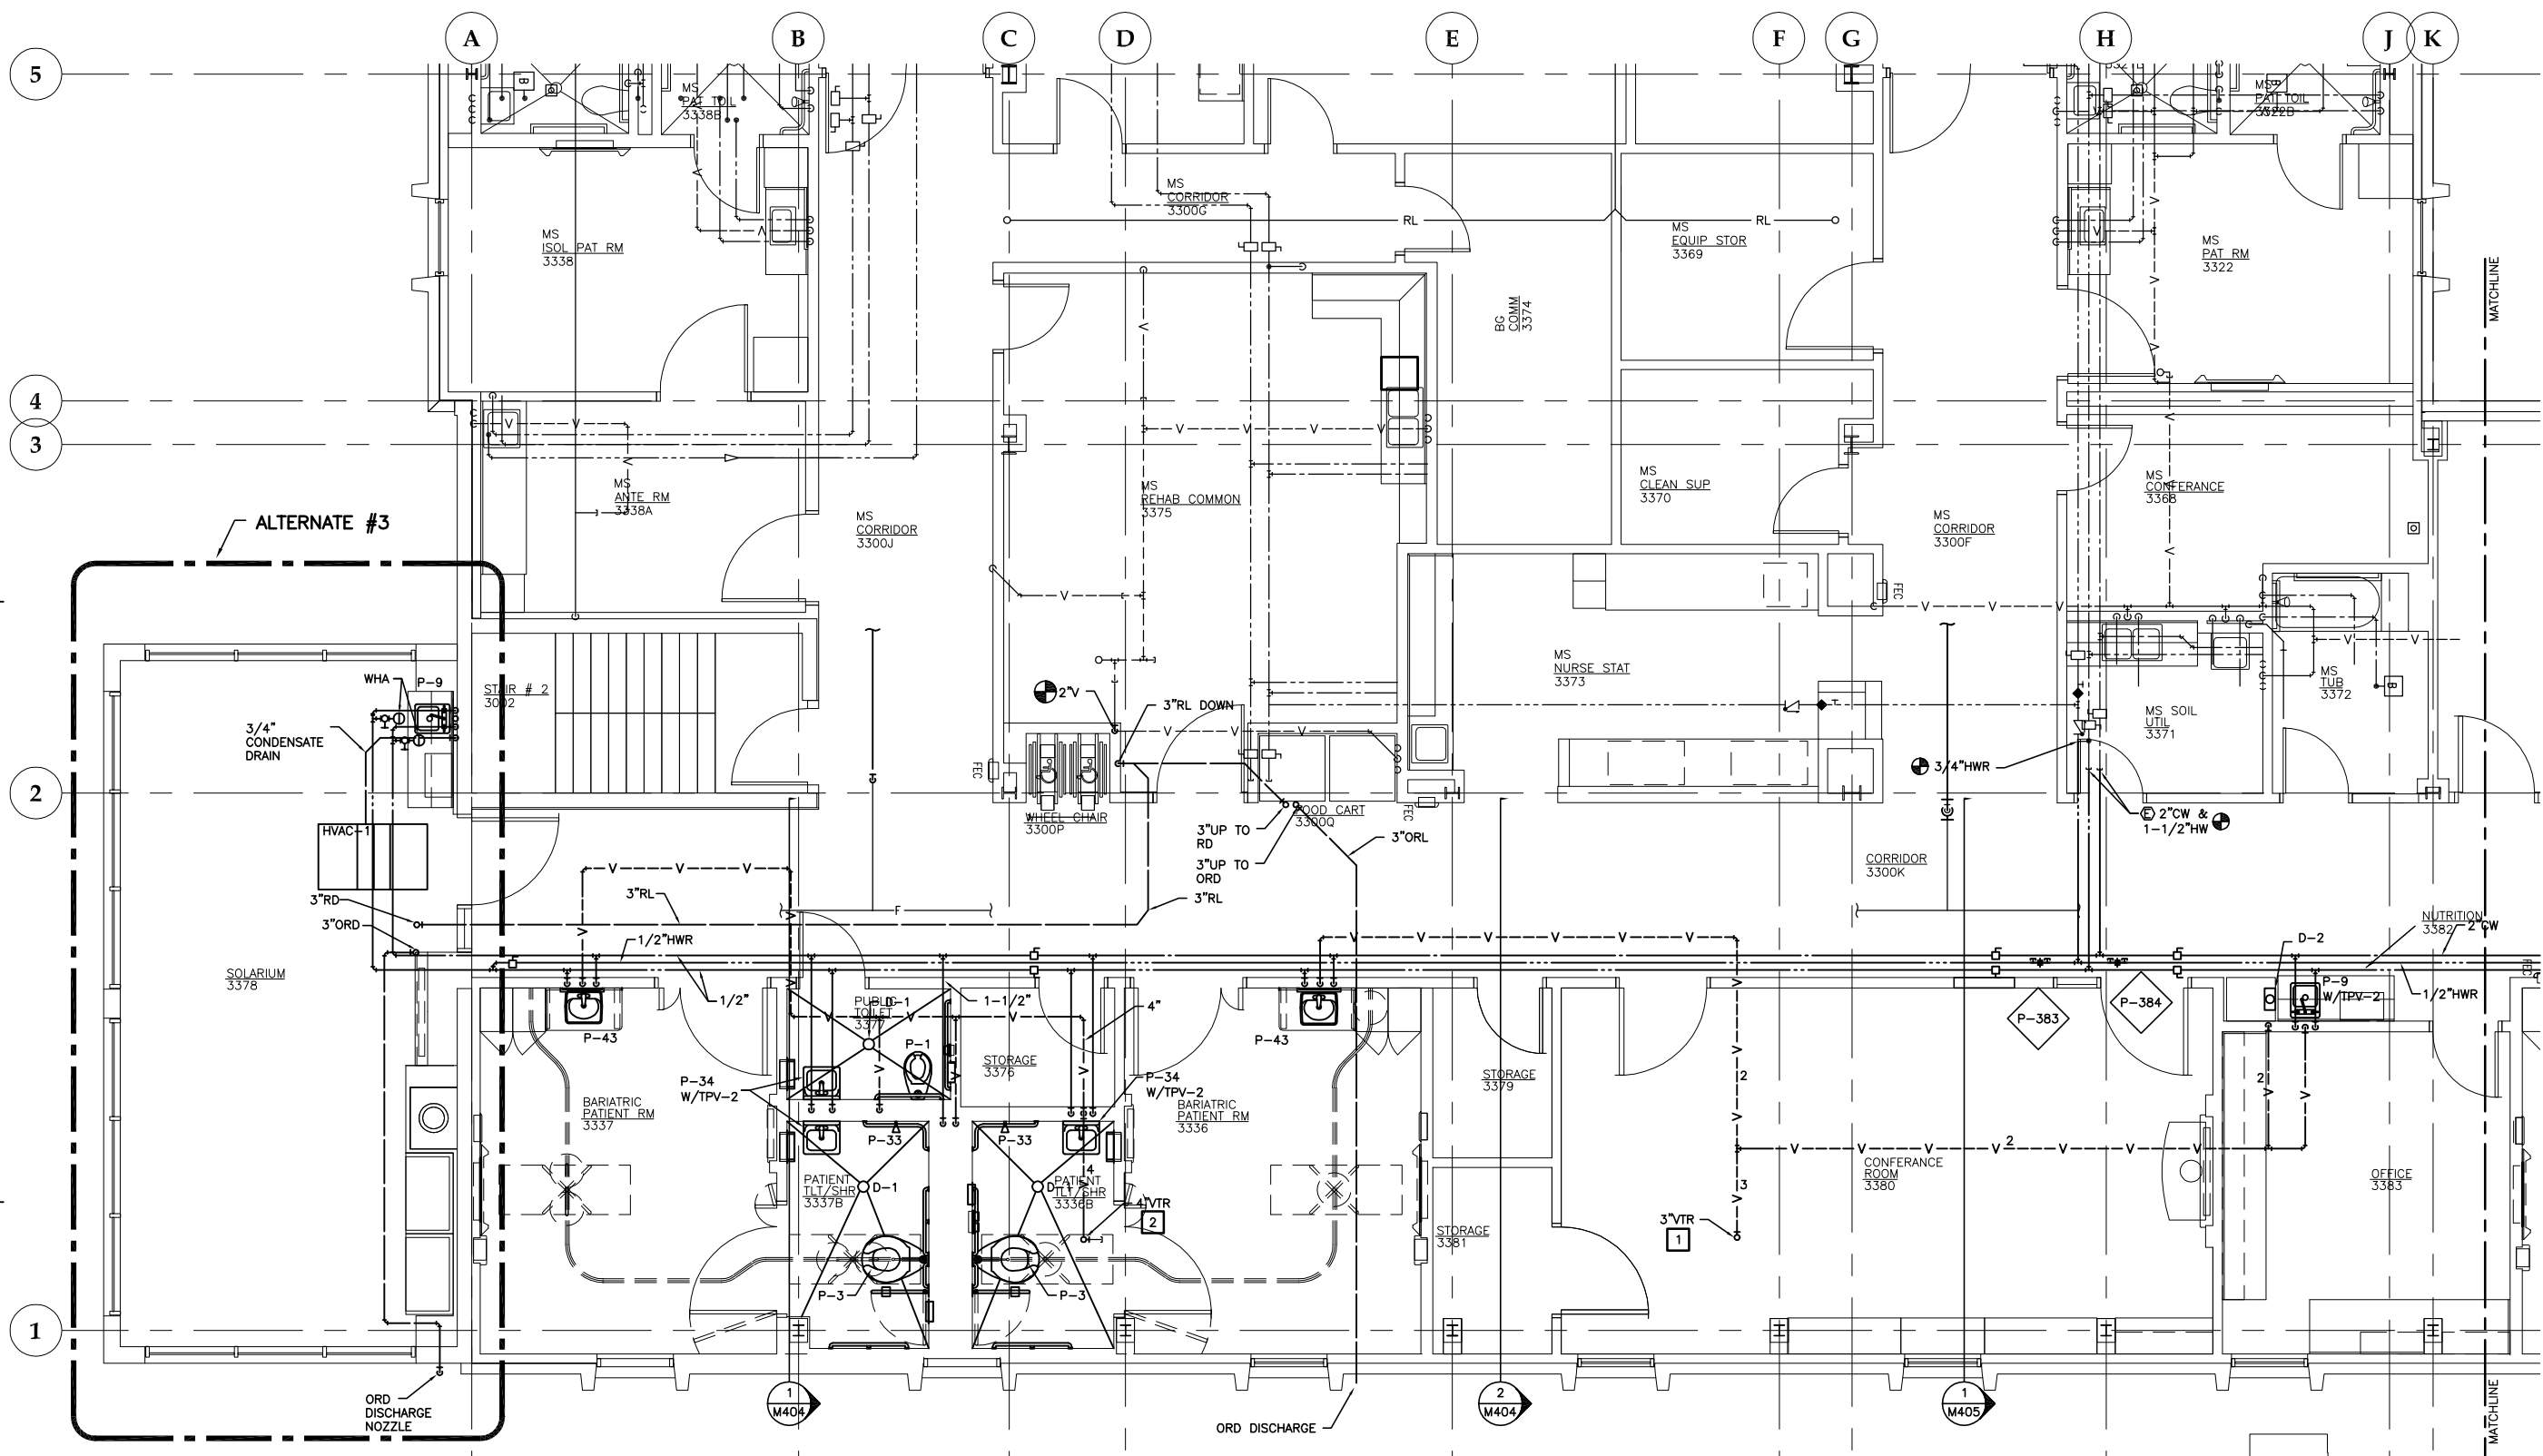


1 FLOOR PLAN: LEVEL 3 SOUTH - PLUMBING

 

CONSTRUCTION NOTES:

- 1 REPLACE 3"VTR WITH 3"VTR, ROOF FLASHING, AND COUNTERFLASHING.
- 2 REPLACE 4"VTR WITH 4"VTR, ROOF FLASHING, AND COUNTERFLASHING.

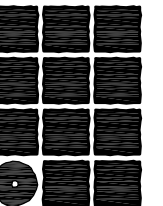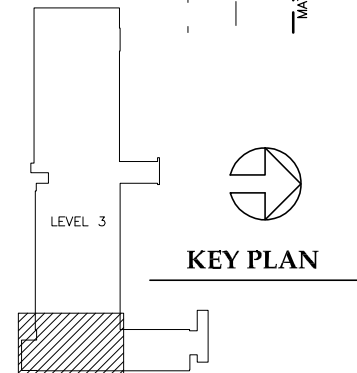


**Jensen
Yorba
Lott
Inc.**

522 West 10th Street
Juneau, Alaska 99801
phone 907-586-1070
fax 907-586-3959
jensenyorbalott.com

MURRAY &
ASSOCIATES P.C.

P.O. BOX 21081
Juneau, Alaska 99802-1081
phone 907-780-6151
fax 907-780-6182
www.murraypc.com

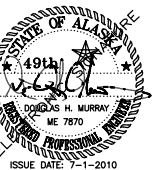

City & Borough of Juneau
Bartlett Regional Hospital
Medical / Surgical East Wing Renovation
CBJ Contract No. E10-221
Juneau, Alaska


CONSTRUCTION
DOCUMENTS



SHEET TITLE
FLOOR PLAN
LEVEL 3 - SOUTH
PLUMBING



DATE: July 1, 2010
JOB #: 10-256


P206

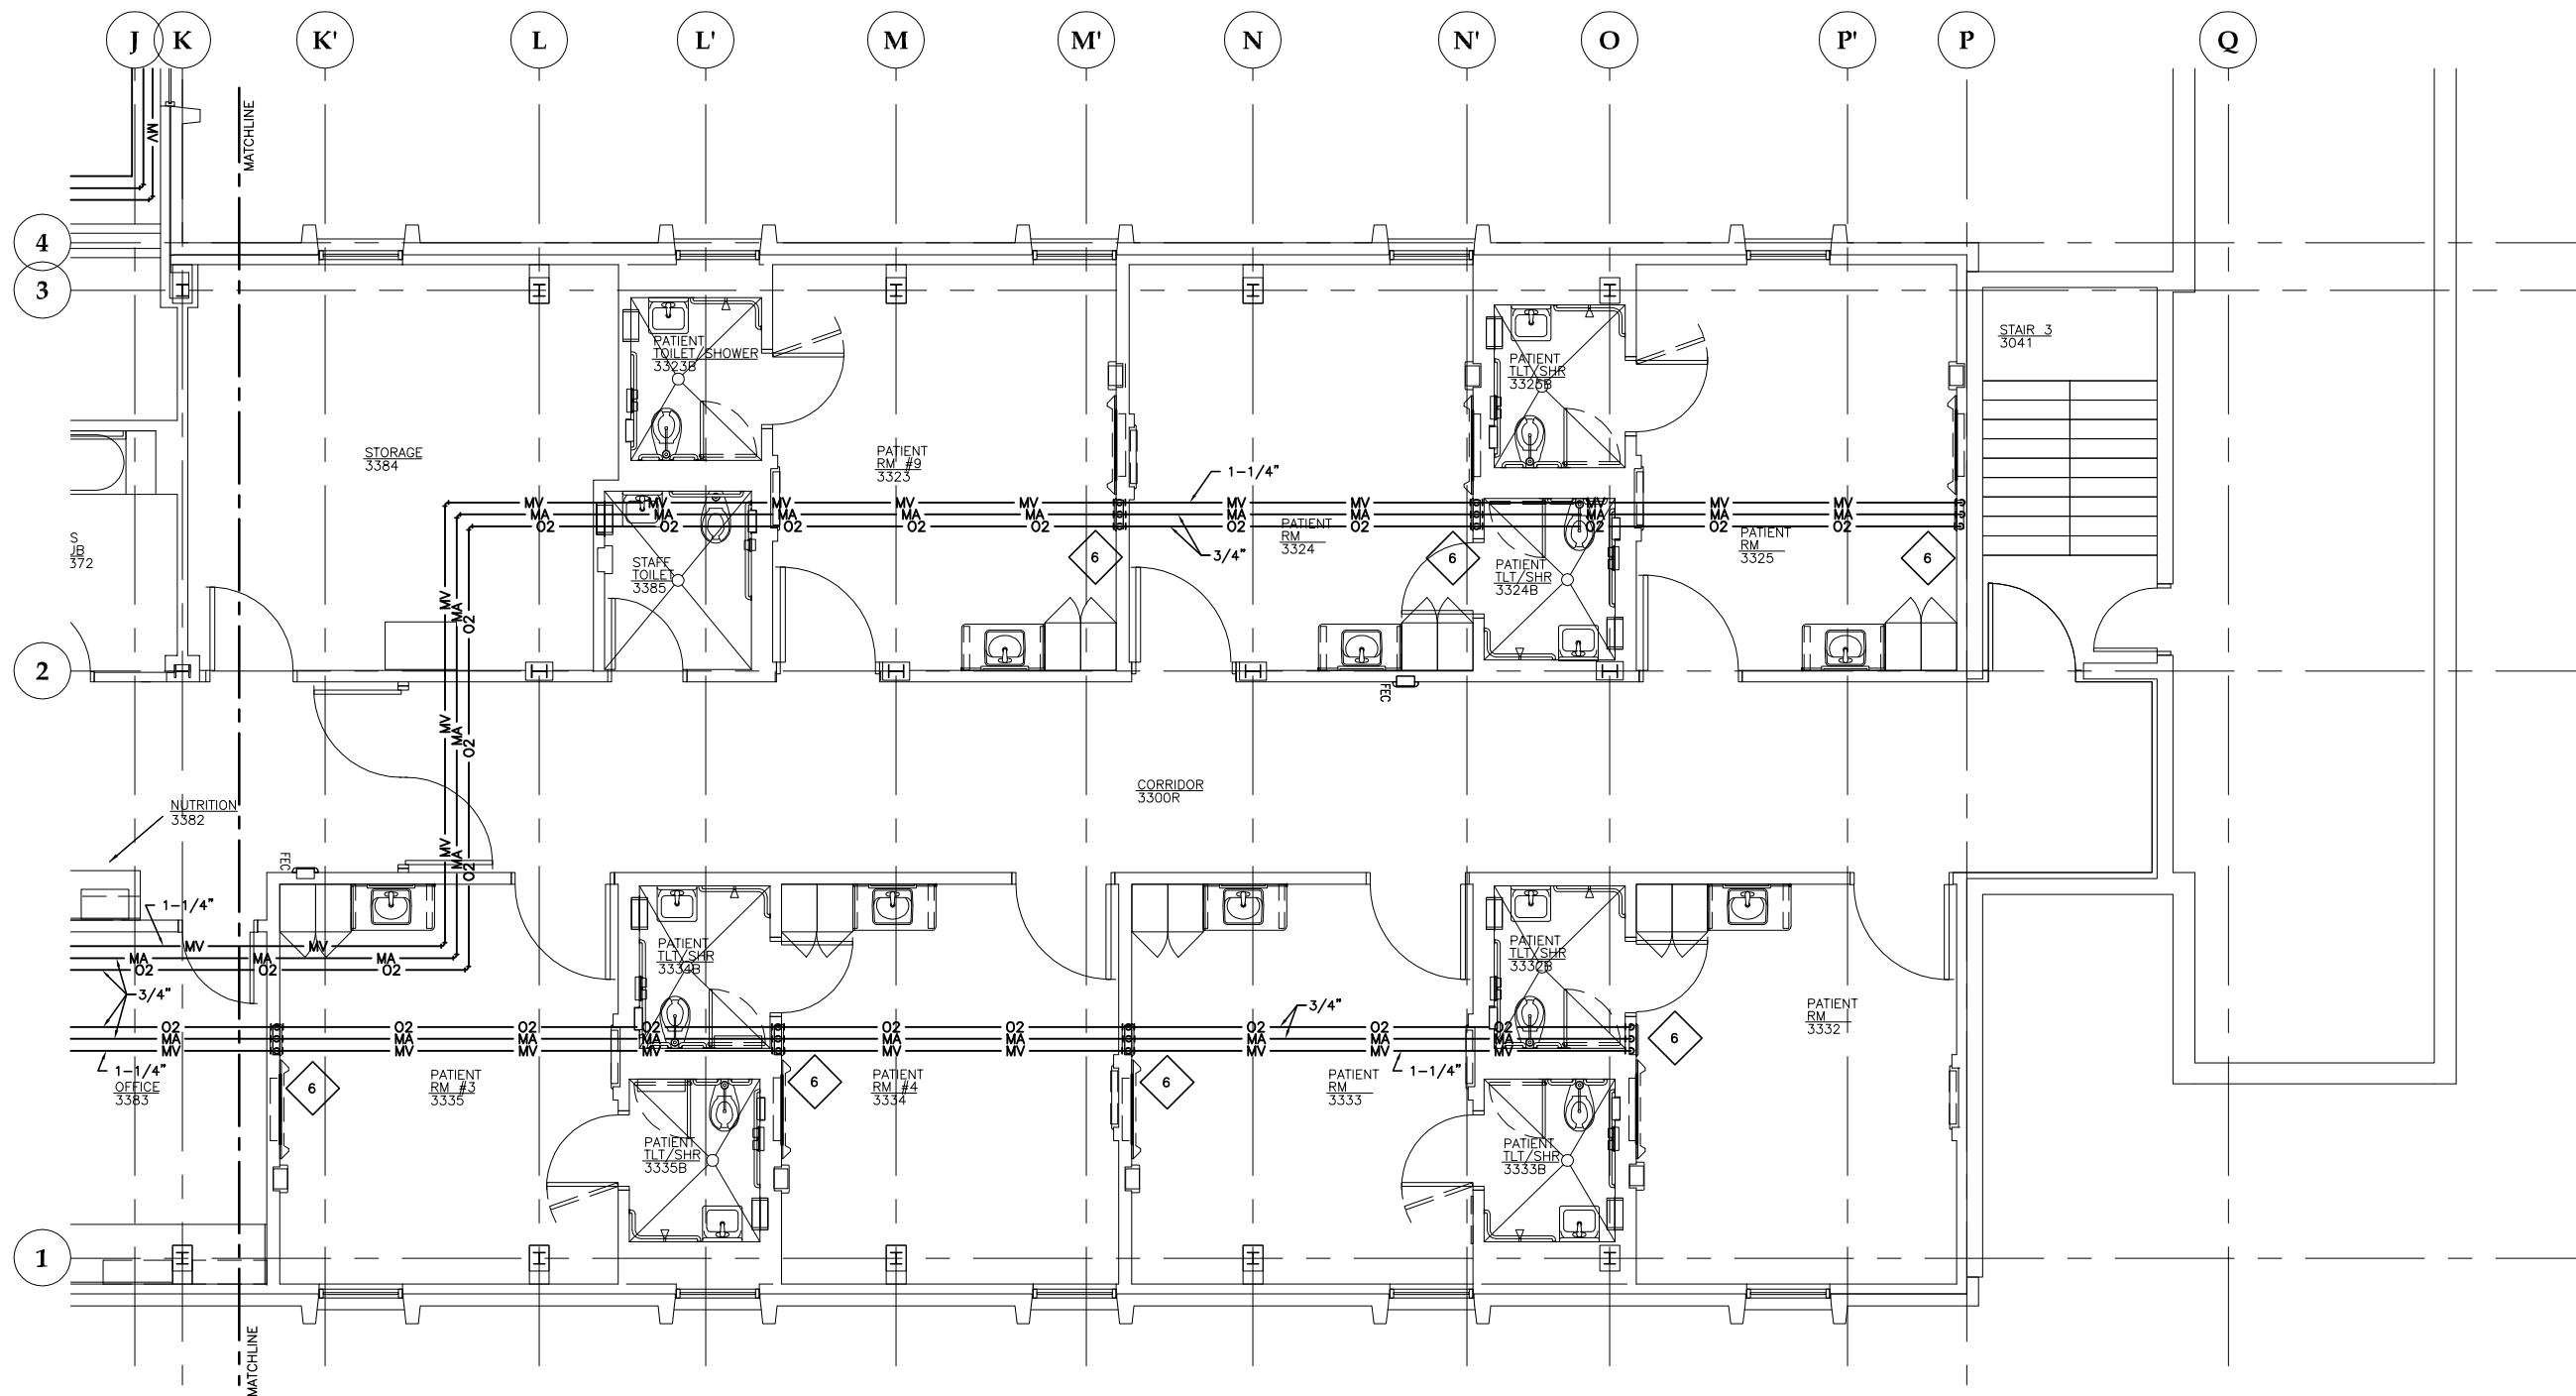



1 FLOOR PLAN: LEVEL 3 - NORTH MEDICAL GAS PIPING

SCALE: 0 2' 4' 8'

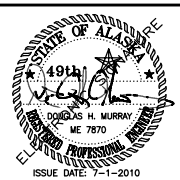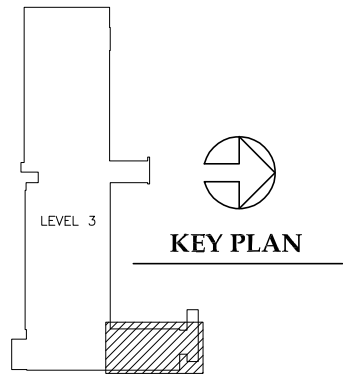

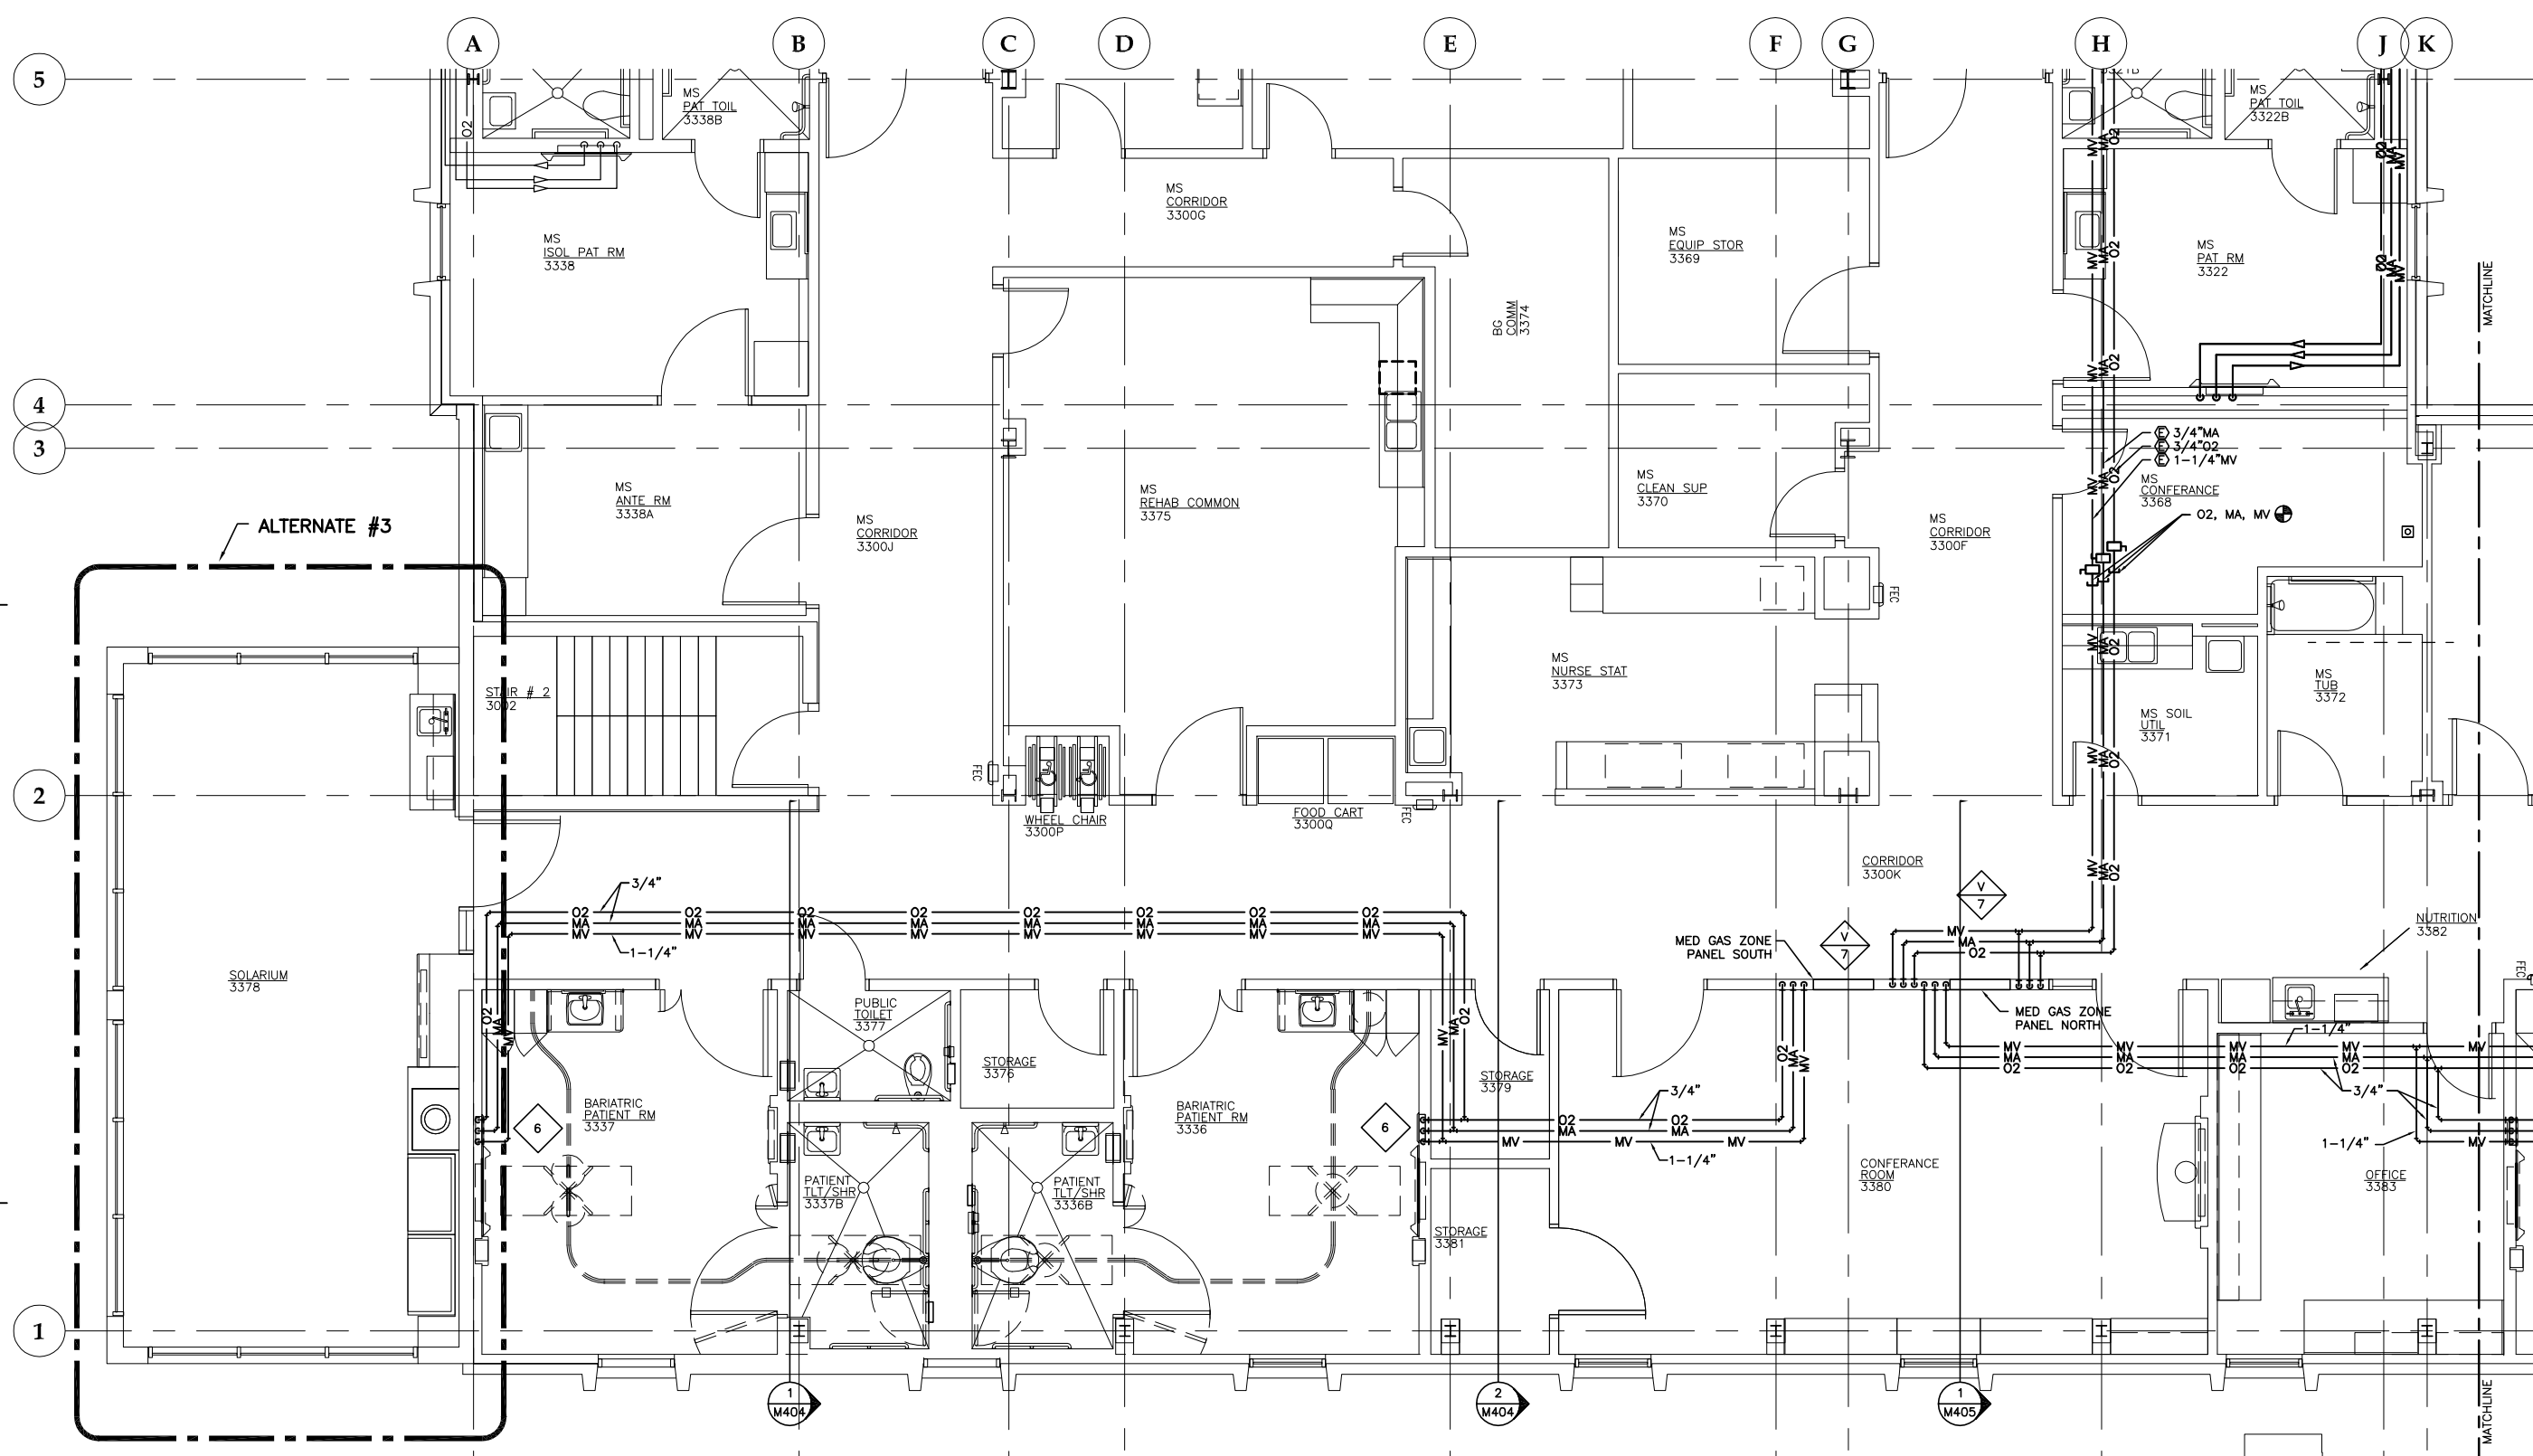

 1 FLOOR PLAN: LEVEL 3 SOUTH - MEDICAL GAS PIPING

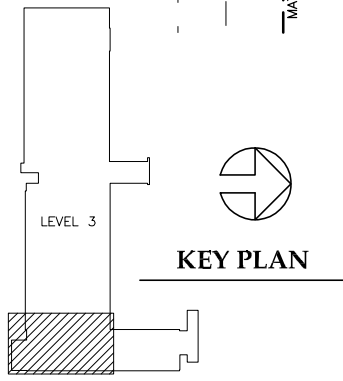


CONSTRUCTION
DOCUMENTS


REVISIONS
1
2
3

SHEET TITLE
FLOOR PLAN
LEVEL 3 - SOUTH
MED GAS PIPING

DATE: July 1, 2010
JOB #: 10-256

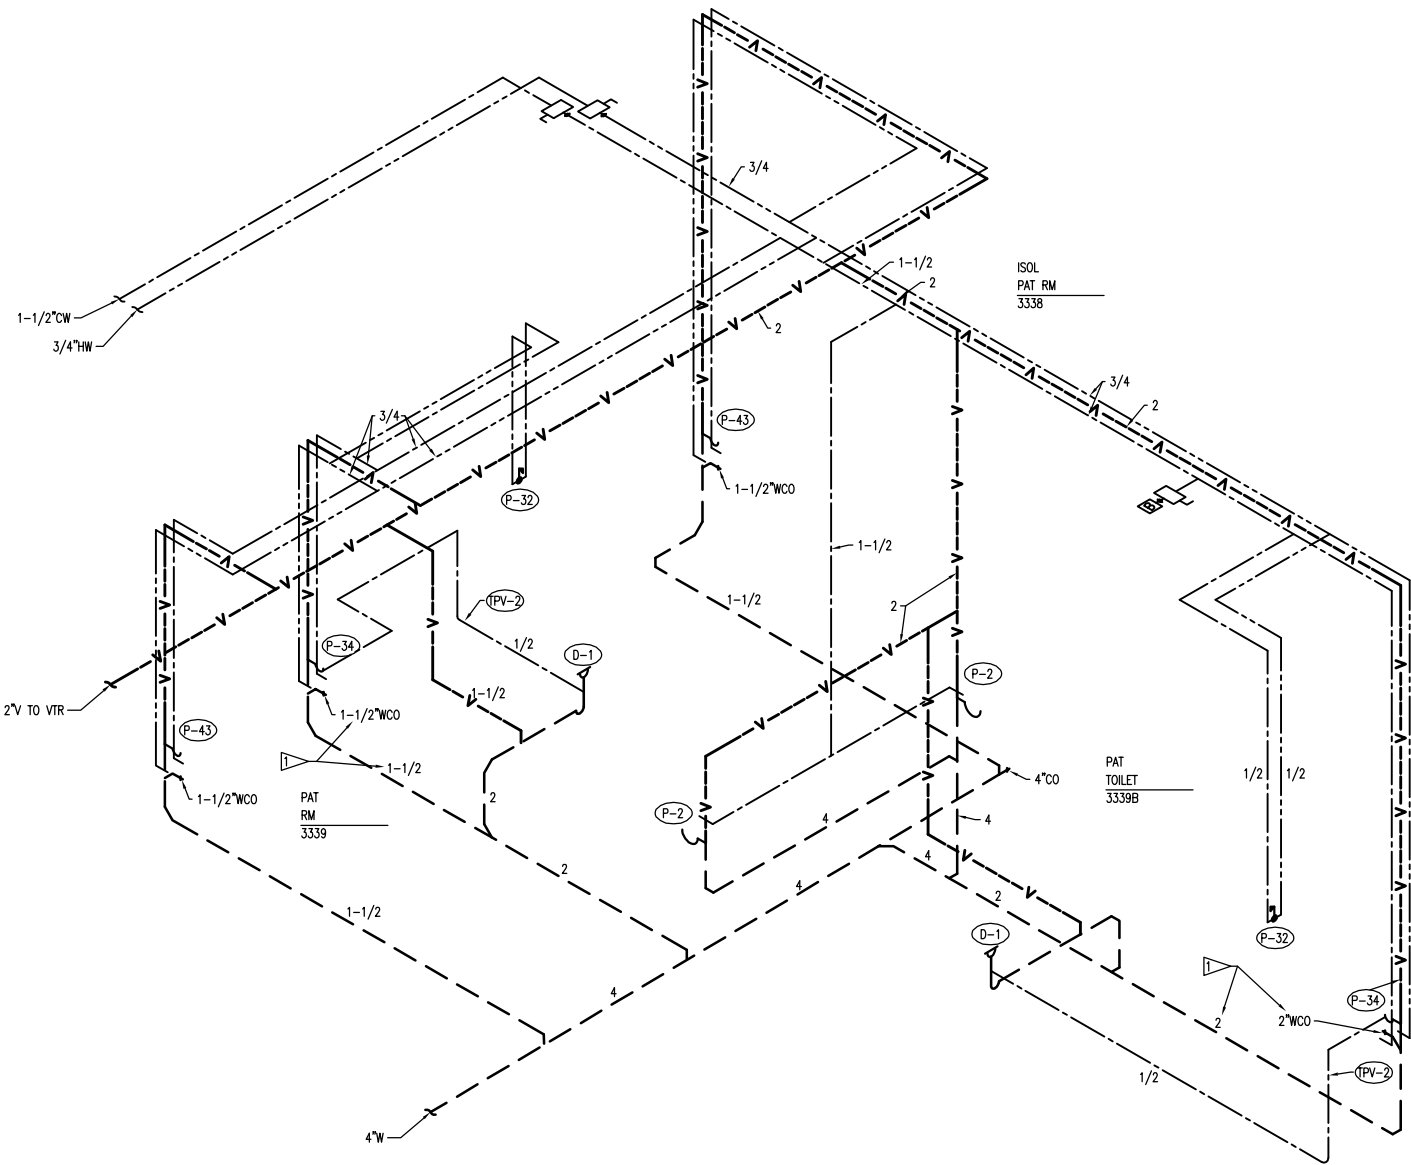


1 PATIENT TOILET ROOMS PLUMBING DIAGRAM - TYPICAL
 P7.01 P7.01 NONE

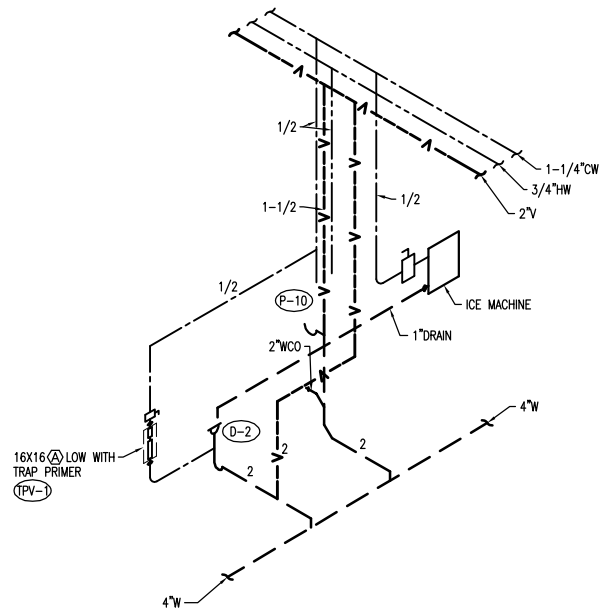

2 PLUMBING DIAGRAM - ICE MACHINE
 P7.01 P7.01 NONE


FLAG NOTES:

SEE PLANS FOR ACTUAL SIZE.

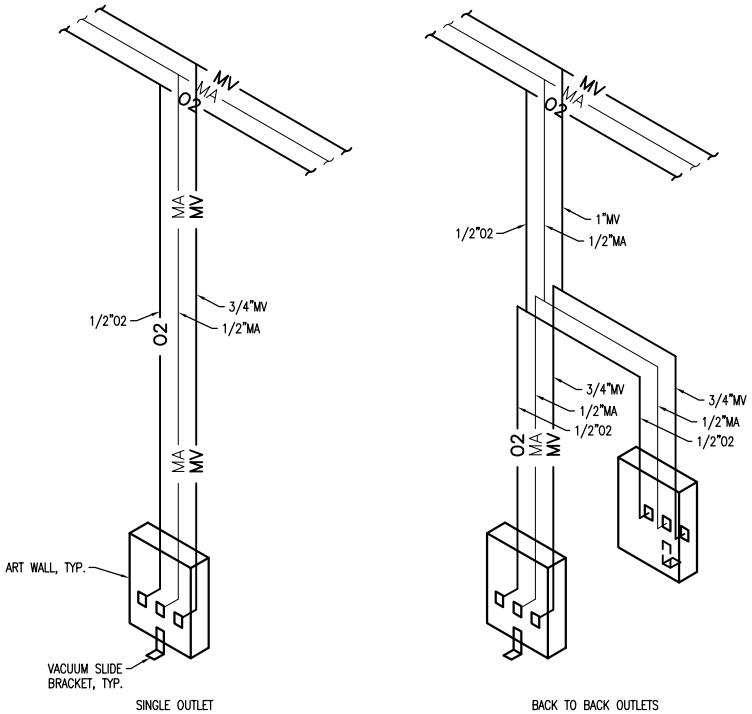


NOTE: SEE PLANS FOR ACTUAL ORDER AND LOCATION OF OUTLETS. INSTALL O2 OUTLET CLOSEST TO CORRIDOR ENTRY.

5 PATIENT ROOMS MEDICAL GAS DIAGRAM - TYPICAL
 P7.01 P7.01 NONE

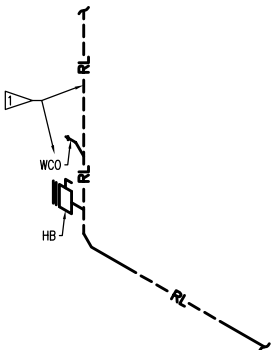

4 PLUMBING DIAGRAM - ROOF LEADER
 P7.01 P7.01 NONE

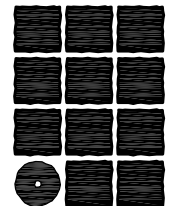

**Jensen
Yorba
Lott
Inc.**


522 West 10th Street
Juneau, Alaska 99801
phone 907-586-1070
fax 907-586-3959
jensenyorbalott.com

MURRAY &
ASSOCIATES P.C.

P.O. BOX 21081
Juneau, Alaska 99802-1081

phone 907-780-6151
fax 907-780-6182

www.murraypc.com

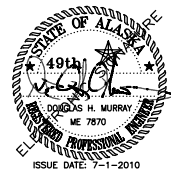

**City & Borough of Juneau
Bartlett Regional Hospital
Medical / Surgical East Wing Renovation
CBJ Contract No. E10-221
Juneau, Alaska**

**CONSTRUCTION
DOCUMENTS**

REVISIONS
△
△
△

SHEET TITLE
**DETAILS &
DIAGRAMS**

DATE: July 1, 2010
JOB #: 10-256

P401