


FLAG NOTES:


 
1. REPLACE SWITCH AND DIMMER WITH NEW WALL STATION.
2. REPLACE SWITCHES (21 EA) WITH NEW WALL STATION.
3. EXISTING SUSPENDED TUBE WITH LINEAR FLUORESCENT UP-LIGHT AND 2 CIRCUIT TRACK (CAPRI) ON BOTTOM. REPLACE TRACK (TYPE T).
4. 2 CIRCUIT TRACK - REPLACE (TYPE T).
5. COVE LIGHTING WITH LINEAR FLUORESCENT UP-LIGHT - EXISTING.
6. FLUORESCENT WALL WASH - EXISTING.

GENERAL NOTES:



1. ALL DEVICES, CIRCUITING, AND EQUIPMENT IS EXISTING UNLESS OTHERWISE NOTED.
2. UTILIZE EXISTING CIRCUITS FROM LUMINAIRES AND LIGHTING TRACK AS MUCH AS POSSIBLE.
3. PROVIDE A FLUSH JUNCTION BOX WITH TERMINAL BLOCKS IN THE WALL NEAR PANEL P1A. EXTEND CIRCUITS AND INTERFACE WITH THE NEW LIGHTING PANEL IN BASEMENT. TERMINATE ALL CIRCUITS ON TERMINAL BLOCKS.
4. COORDINATE CIRCUITING REQUIREMENTS WITH LIGHTING CONTROLS MANUFACTURER.

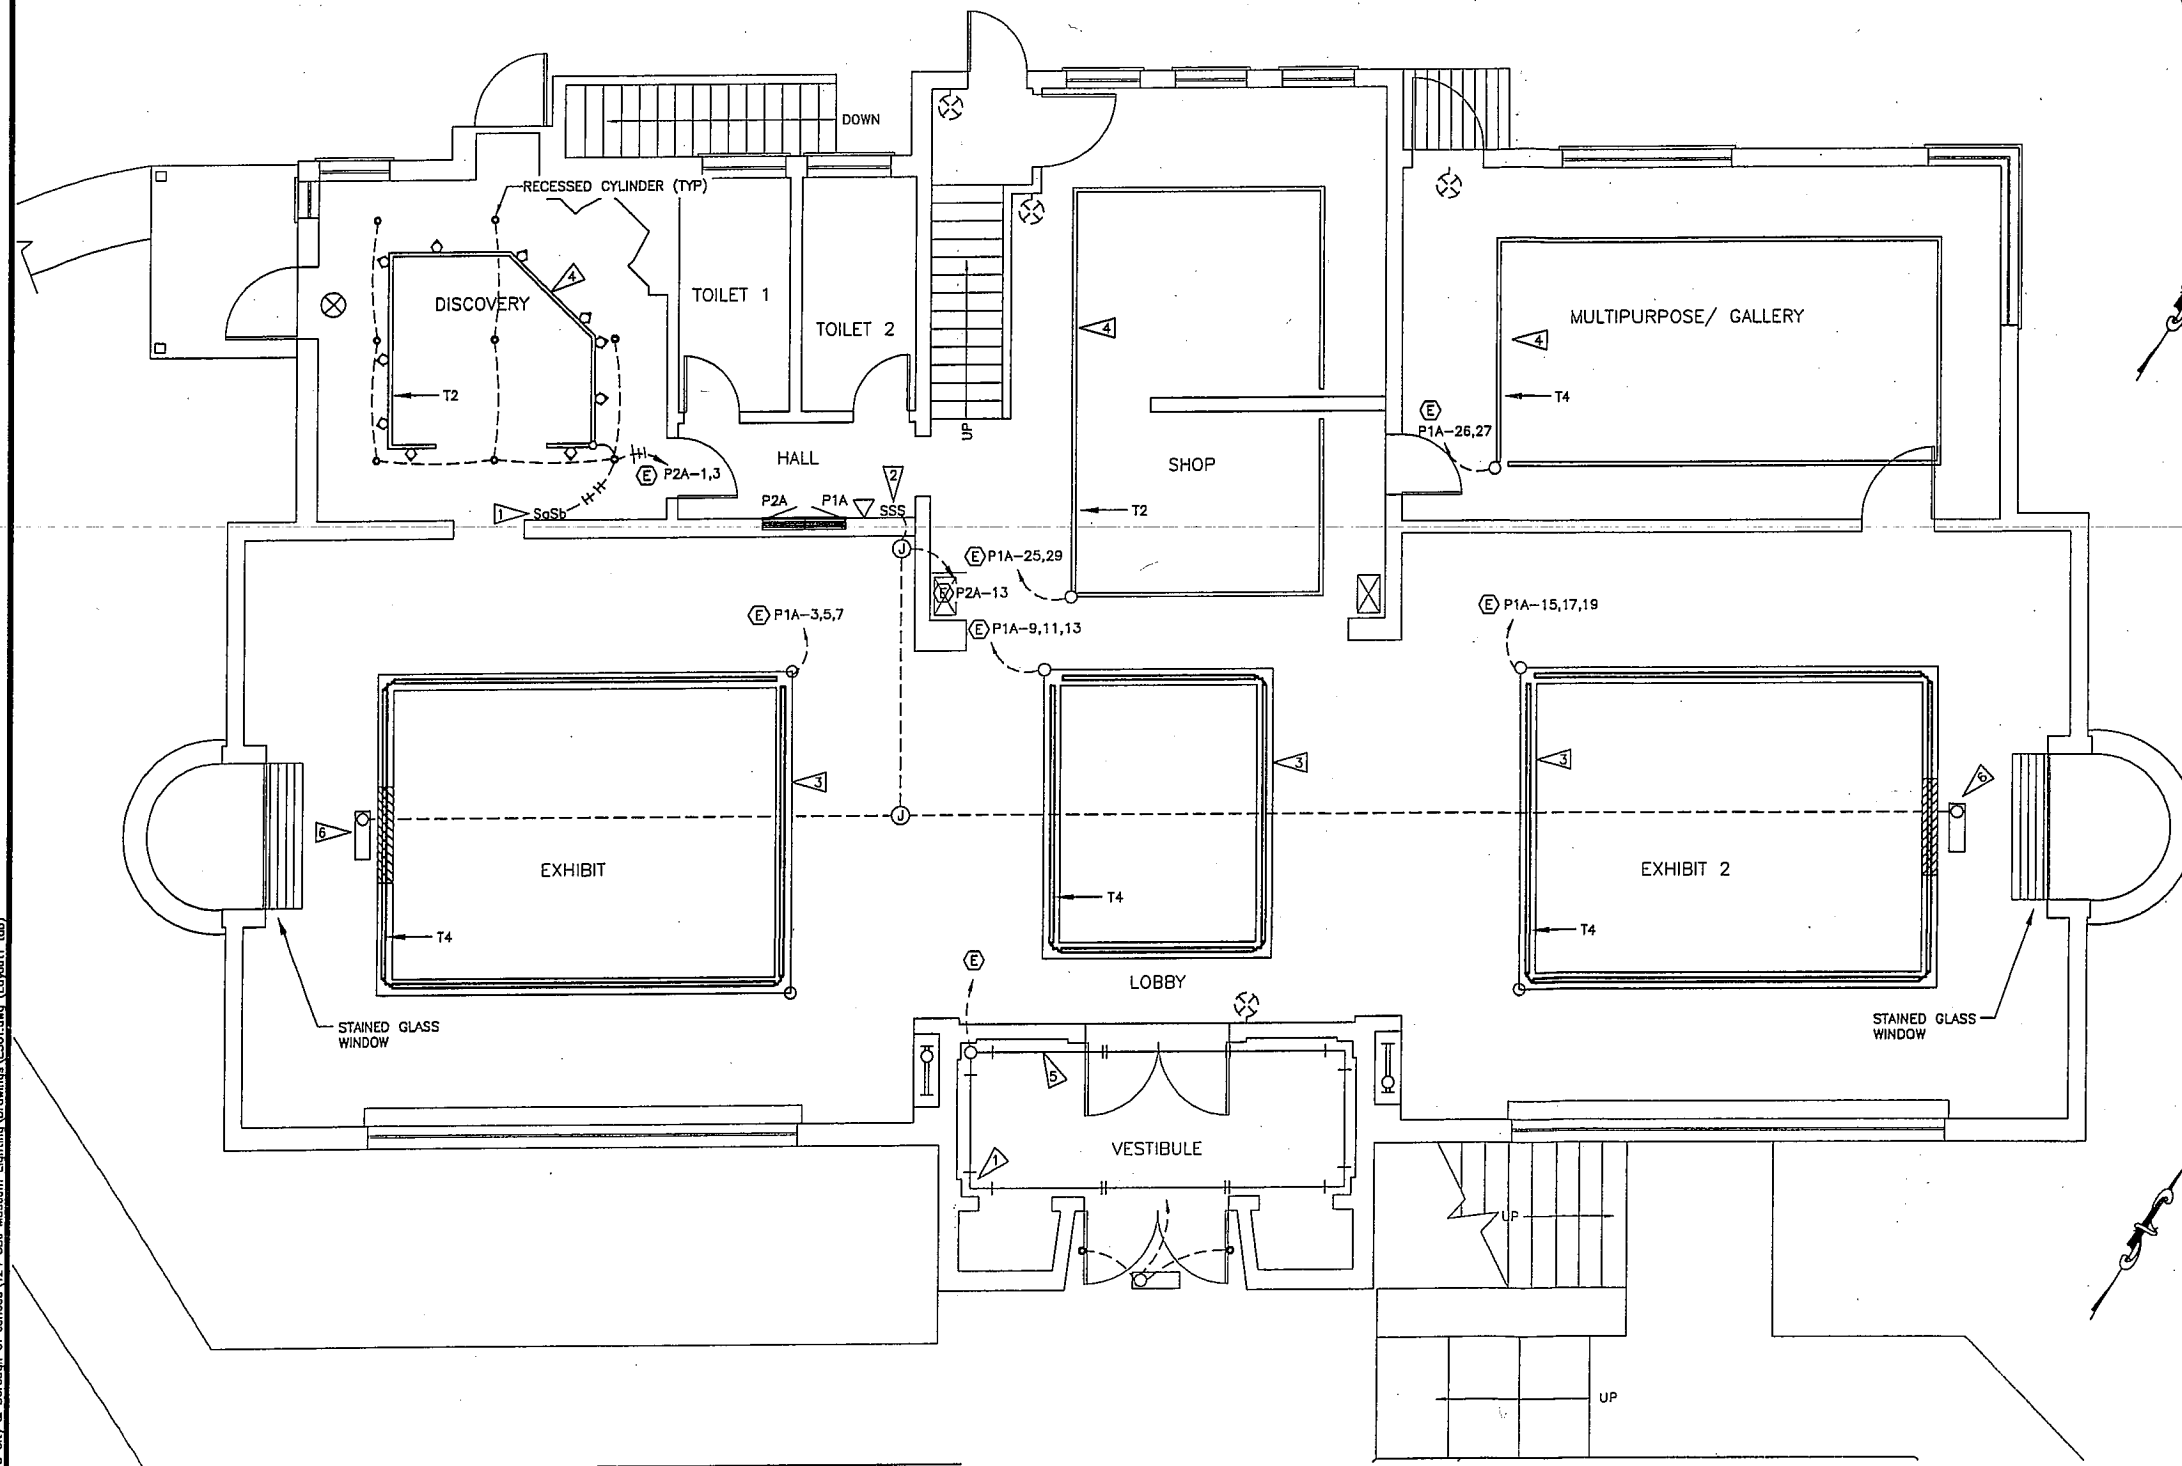

1 FIRST FLOOR PLAN

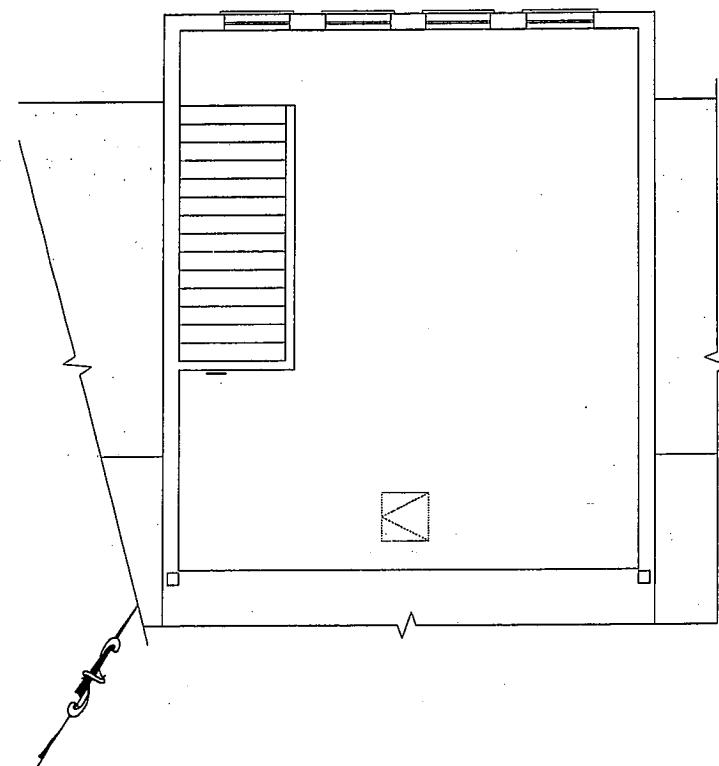

2 SECOND FLOOR PLAN

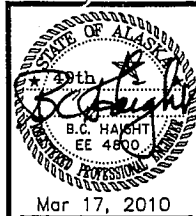 

HAIGHT & ASSOCIATES
CONSULTING ELECTRICAL ENGINEERS

526 Main Street
Juneau, Alaska 99801
(907) 586-9788

CITY & BOROUGH OF JUNEAU
MUSEUM LIGHTING UPGRADES
JUNEAU, ALASKA

LIGHTING PLANS:
FIRST & SECOND FLOORS


REVISION	DESCRIPTION	DATE

SHEET NUMBER

E301

SCALE: AS NOTED
DATE: JANUARY 2010


Mar 17, 2010 - 1:48pm
F:\Projects\118 City & Borough of Juneau\124 CBJ Museum Lighting\Drawings\E303.dwg (Layout 1 tab)

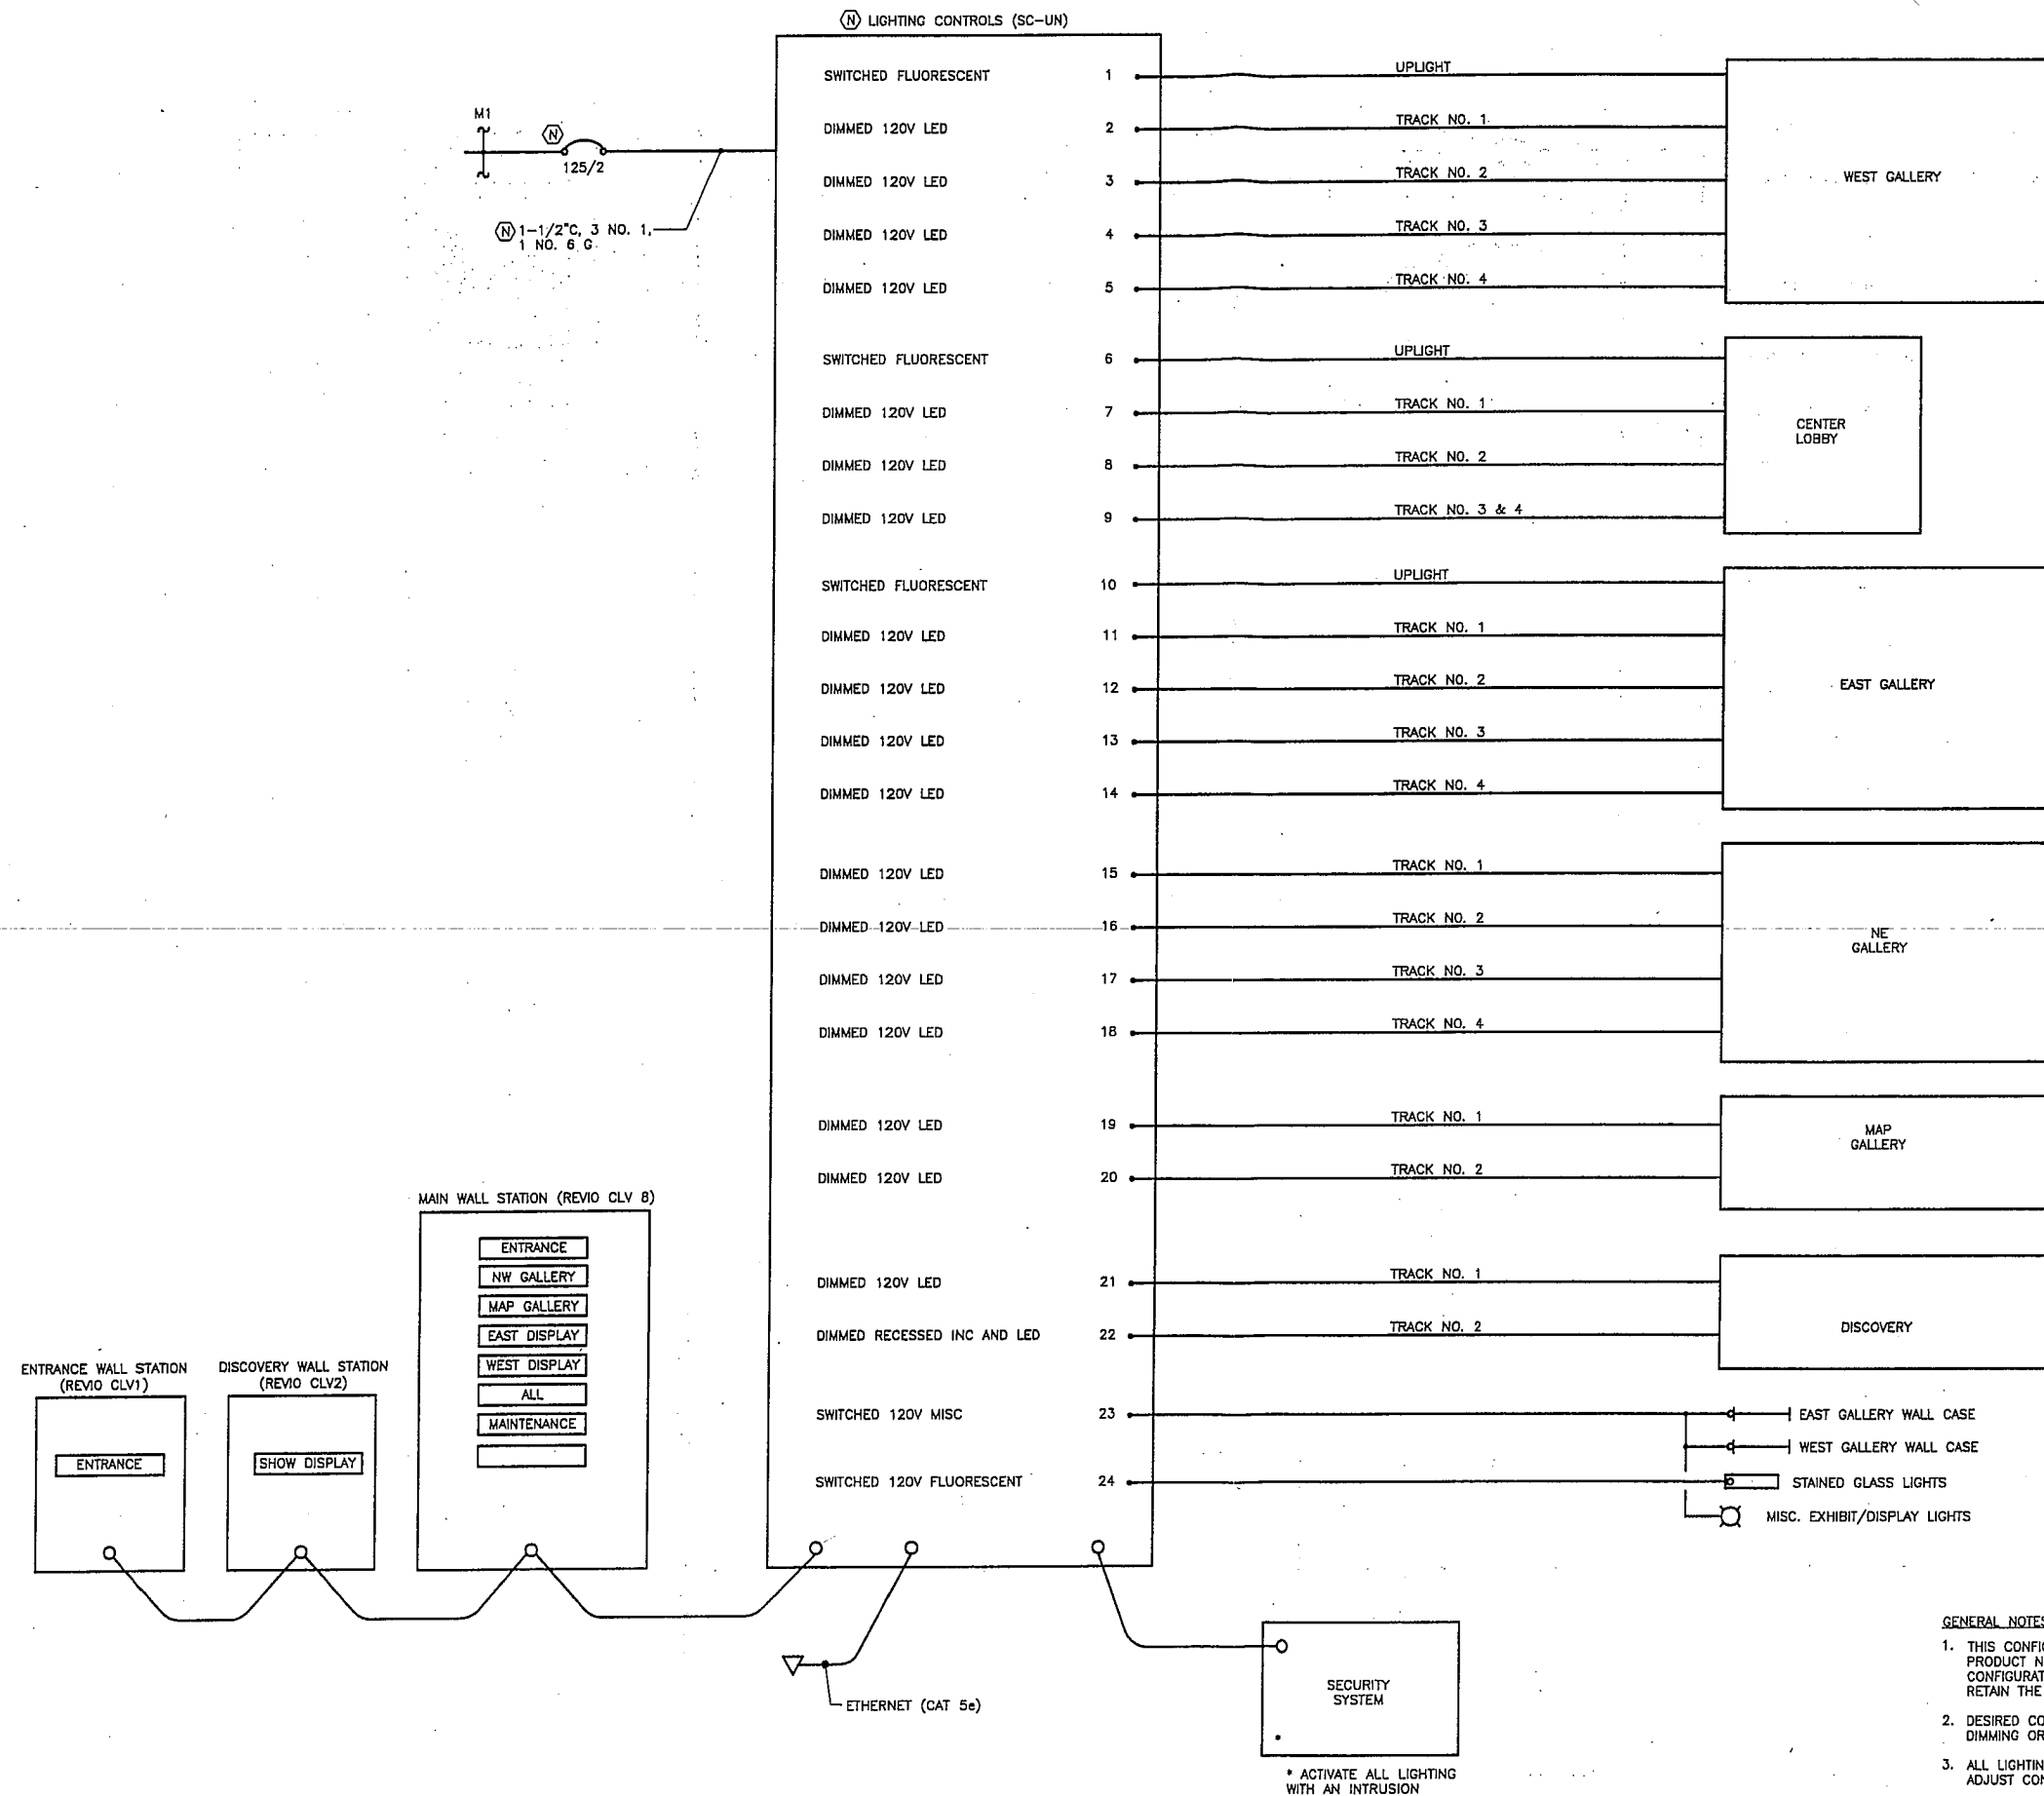

1 LINE DIAGRAM-LIGHTING CONTROLS

GENERAL NOTES:

1. THIS CONFIGURATION IS BASED ON A SYSTEM PROVIDED BY "ILUMIN". PRODUCT NUMBERS ARE IDENTIFIED ACCORDINGLY. ADJUST THE CONFIGURATION AS REQUIRED FOR A DIFFERENT MANUFACTURER, BUT RETAIN THE OPERATING FEATURES.
2. DESIRED CONTROL CHARACTERISTICS ARE IDENTIFIED. HOWEVER, ALLOW DIMMING OR SWITCH FEATURES TO BE SELECTABLE FOR EACH CIRCUIT.
3. ALL LIGHTING CIRCUITS SHALL BE RATED FOR 20 AMPS AT 120 VAC. ADJUST CONDUCTOR SIZE ACCORDING TO NEC FOR CONDUIT FILL.
4. CONDUIT SIZES AND QUANTITIES DEPENDENT ON ROUTING AND SPACE ALLOWANCE.

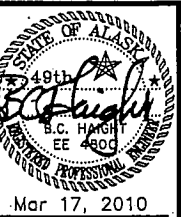

**HAIGHT
& ASSOCIATES**
CONSULTING
ELECTRICAL
ENGINEERS

526 Main Street
Juneau, Alaska 99801
(907) 586-9788

CITY & BOROUGH OF JUNEAU
MUSEUM LIGHTING UPGRADES
JUNEAU, ALASKA

LINE DIAGRAM


REVISION	DESCRIPTION	DATE

SHEET NUMBER



E303

SCALE: AS NOTED
DATE: JANUARY 2010

Mar 17, 2010 - 1:47pm
F:\Projects\18 City & Borough of Juneau\124 CBJ Museum Lighting Drawings\E302.dwg (Layout tab)

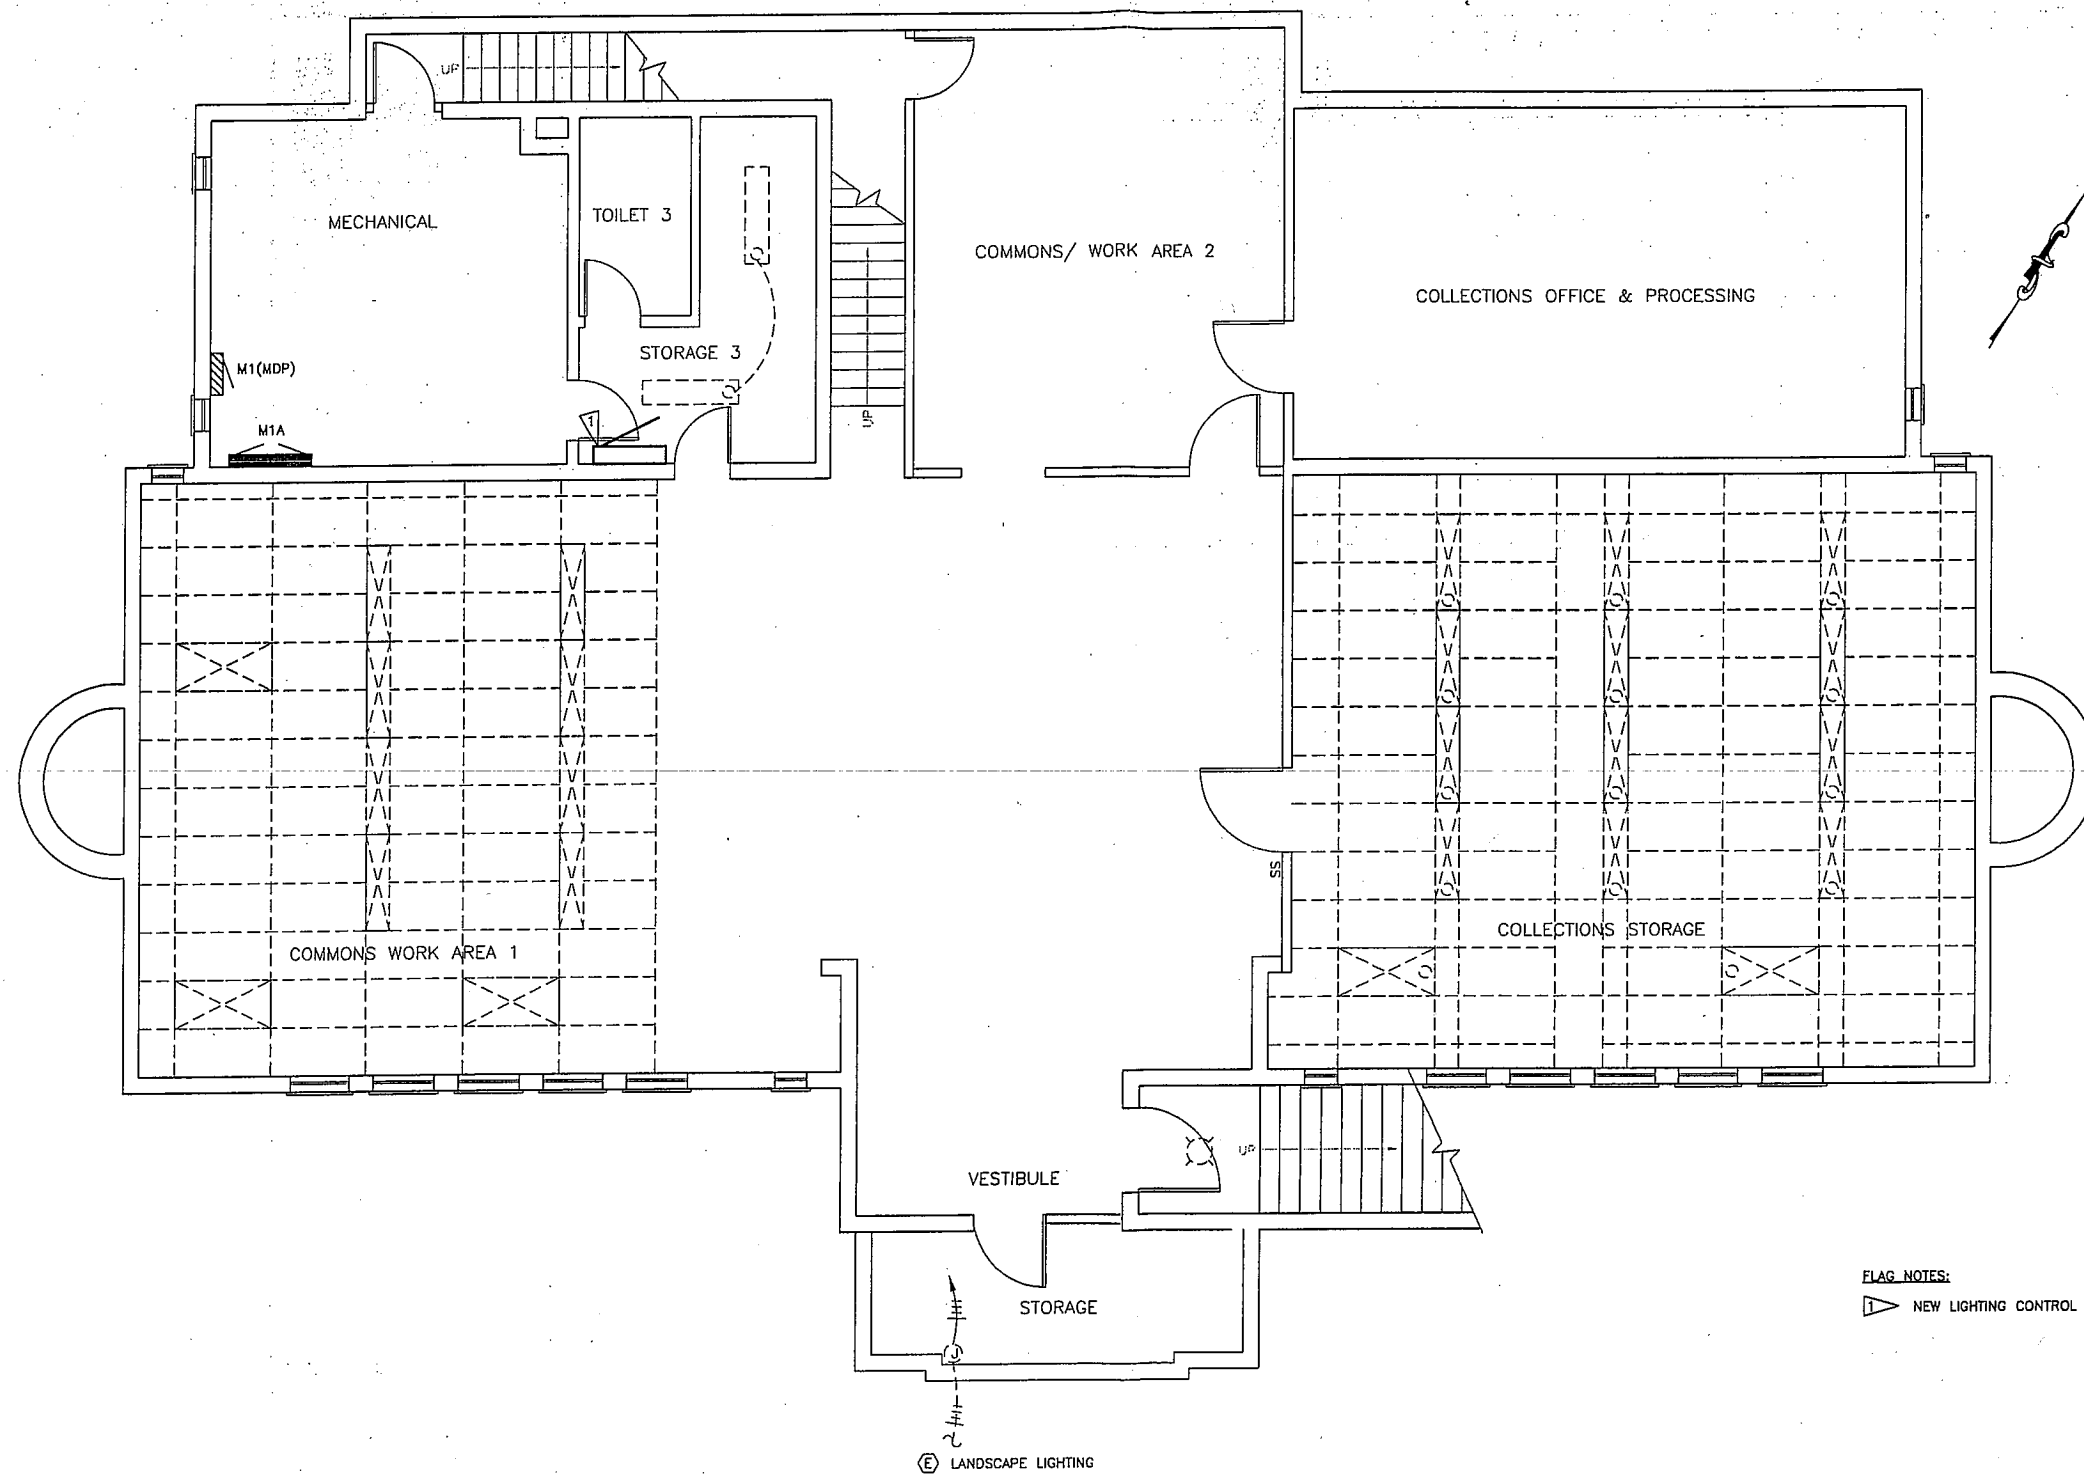

1 BASEMENT FLOOR PLAN

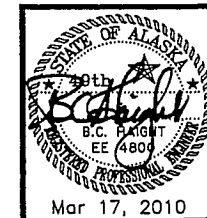 

526 Main Street
Juneau, Alaska 99801
(907) 586-9788

CITY & BOROUGH OF JUNEAU
MUSEUM LIGHTING UPGRADES
JUNEAU, ALASKA

LIGHTING PLANS:
BASEMENT

REVISION	DESCRIPTION	DATE

SHEET NUMBER

E302

SCALE: AS NOTED
DATE: JANUARY 2010