


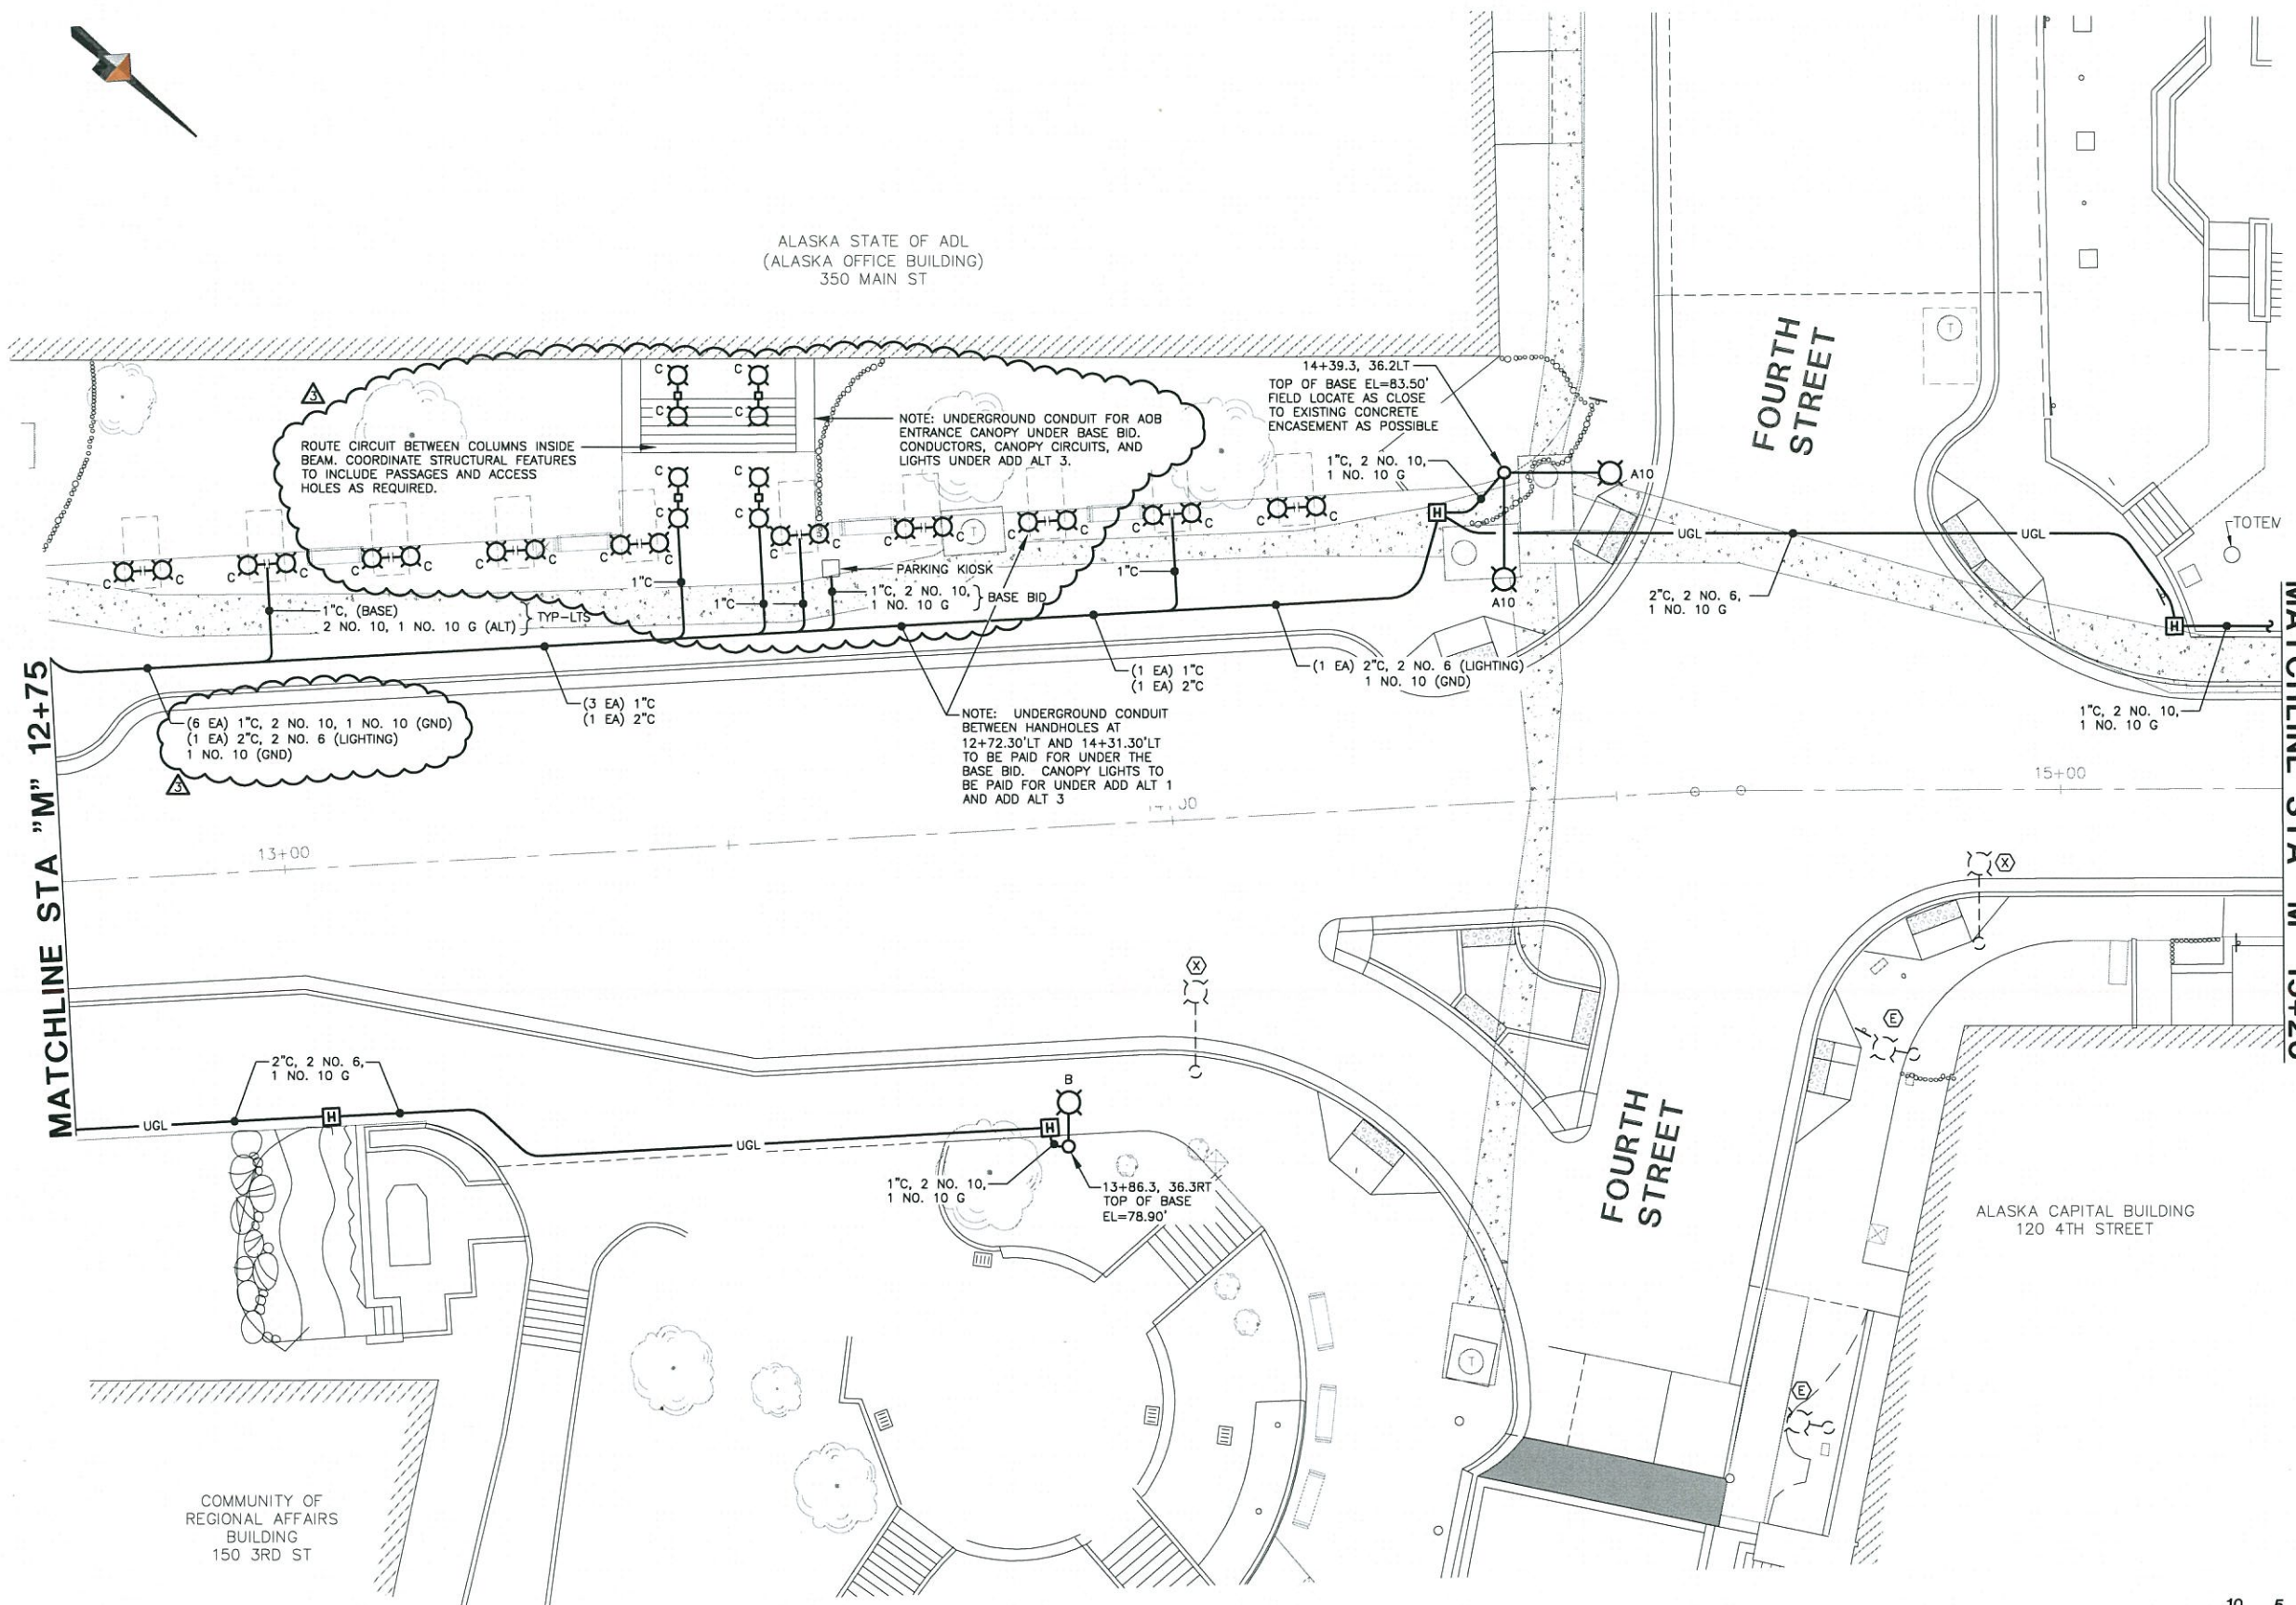

ALASKA STATE OF ADL  
(ALASKA OFFICE BUILDING)  
350 MAIN ST



MATCHLINE STA "M" 12+75

 
MATCHLINE STA "M" 15+26

FOURTH STREET

FOURTH STREET

ALASKA CAPITAL BUILDING  
120 4TH STREET

COMMUNITY OF  
REGIONAL AFFAIRS  
BUILDING  
150 3RD ST



**ADDENDUM No. THREE, May 25, 2012**

May 25, 2012

F:\Projects\119 DOWL\23 Main Street 2nd to 5th Drawings\Working\Addendum E.302.dwg 2012-5-25 16:32:47



**HAIGHT & ASSOCIATES**  
CONSULTING ELECTRICAL ENGINEERS  
528 Main Street, Juneau, AK 99801  
(907) 566-9788

**DOWL HKM**  
5368 Commercial Blvd Juneau, Alaska 99801  
PHONE (907) 780-3533 FAX (907) 780-3535

**CITY/BOROUGH OF JUNEAU**  
ALASKA'S CAPITAL CITY  
**DEPARTMENT OF ENGINEERING**

**MAIN STREET IMPROVEMENTS  
SECOND TO FIFTH STREET  
CONTRACT NO. E12-167**

**LIGHTING PLAN - MAIN STREET  
STA "M" 12+75 TO STA "M" 15+26**

SHEET NO.  
**E.302**  
34 of 44

JOB NO: J70456 DRAWN BY: PEL DESIGNED BY: BCH, PEL CHECKED BY: BCH DATE: APRIL 2012