
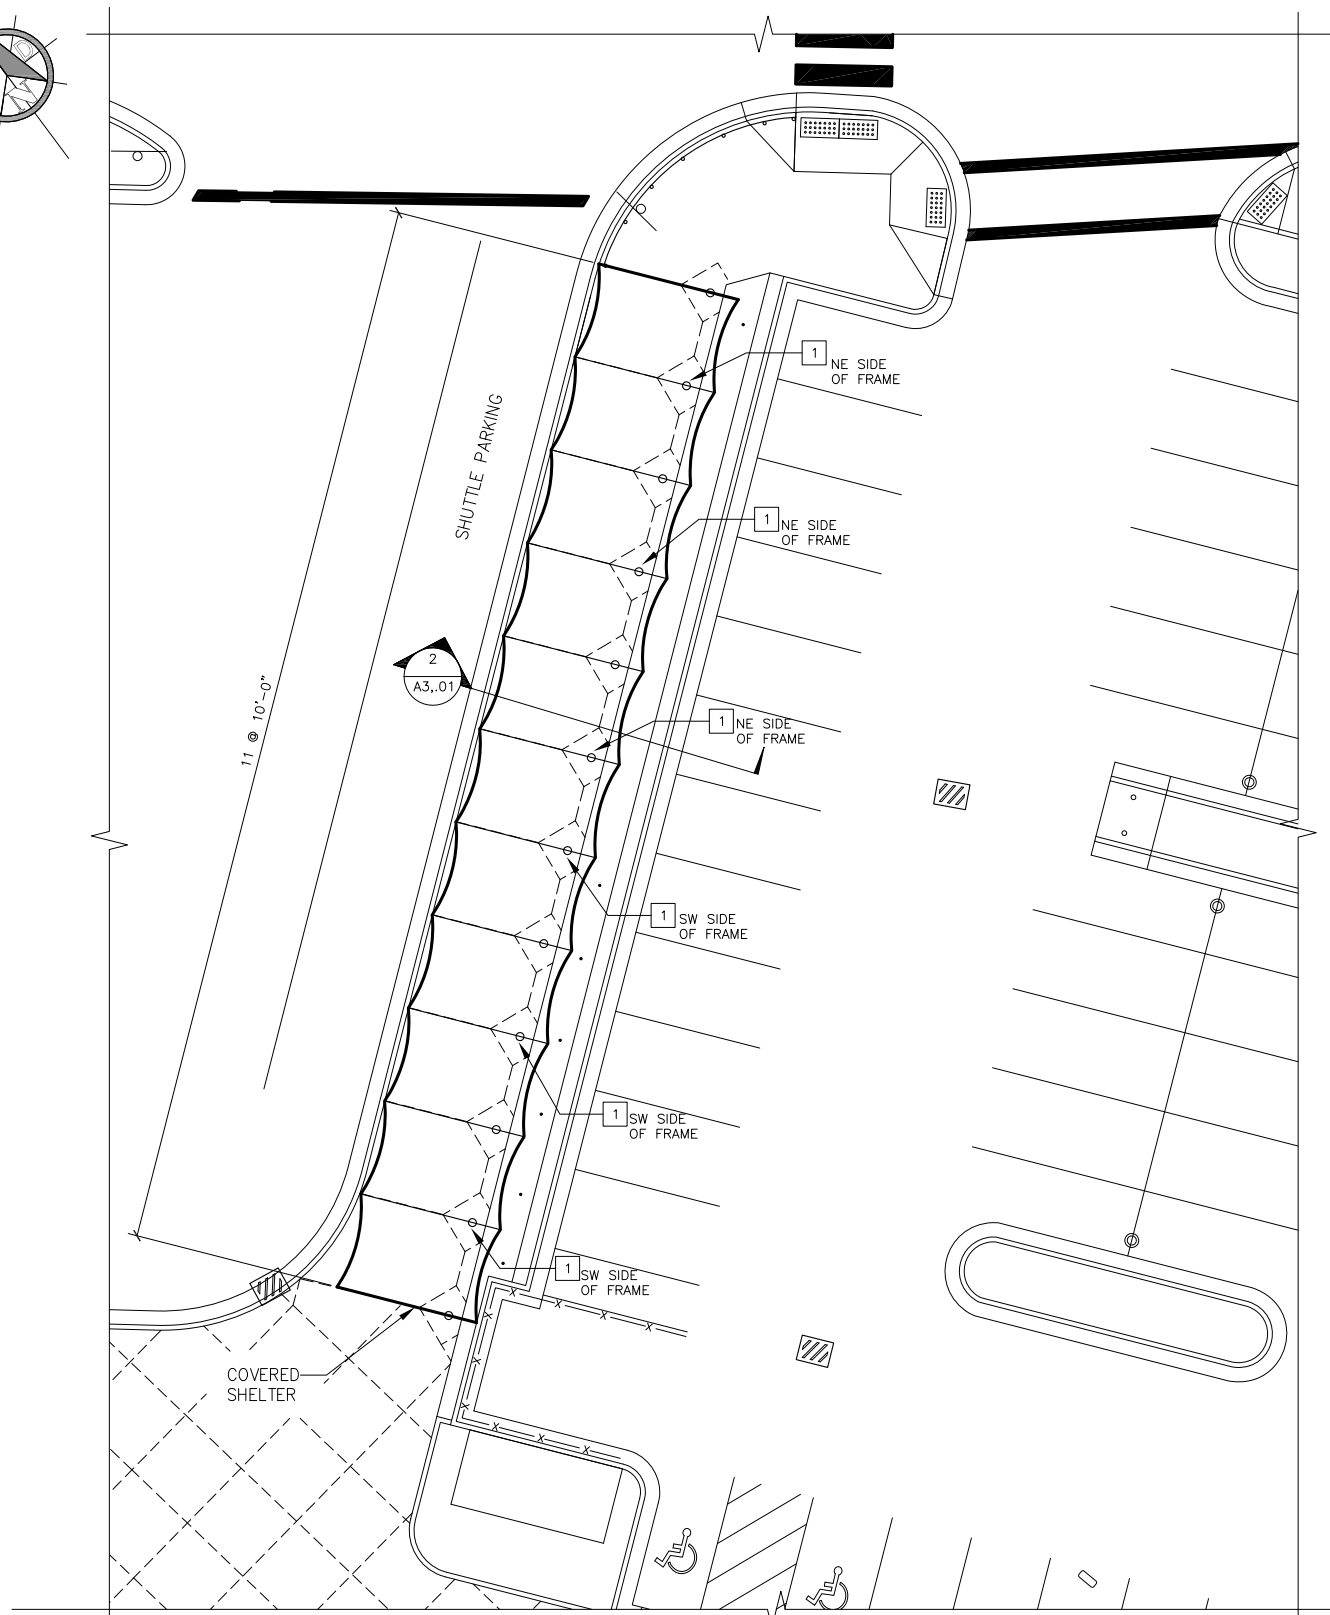


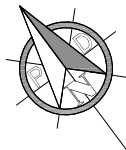


1 ENLARGED SITE PLAN - SHUTTLE PARKING CANOPY

SCALE: 0' 5' 10' 20'

KEY NOTES

1 LIGHTS

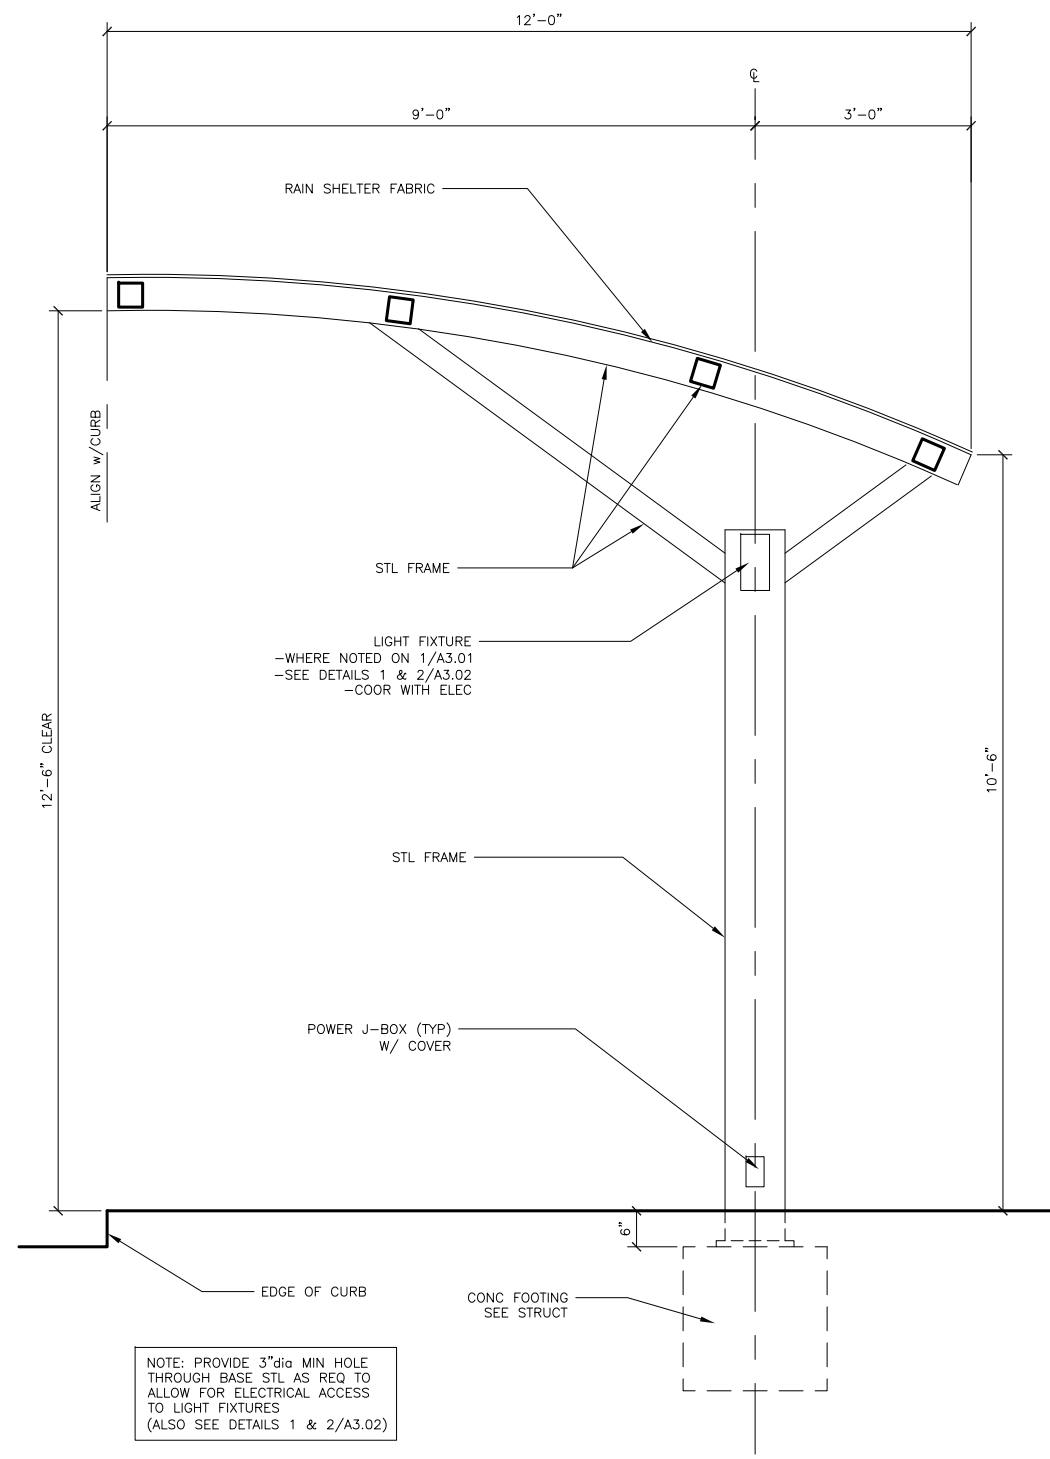

2 SHUTTLE PARKING CANOPY SECTION

10089/X_A4.2-2

SCALE: 0 1' 2' 4'



Jensen
Yorba
Lott
Inc.

ARCHITECTURE
INTERIORS
CONSTRUCTION
MANAGEMENT
522 West 10th Street, Juneau, Alaska 99801
Phone 907-586-1070 www.jensenyorbalott.com


REVISIONS					
REV.	DATE	DESCRIPTION	DWN.	CKD.	APP.

P N D
ENGINEERS, INC.

9360 Glacier Highway, Ste. 100
Juneau, Alaska 99801
Phone: 907-586-2093
Fax: 907-586-2099
www.pndengineers.com

DESIGN: JL CHECKED: ADG
DRAWN: ADG APPROVED: JL

SCALE:

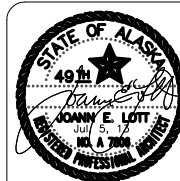

DATE: 7/8/13

CRUISE SHIP TERMINAL STAGING AREA
IMPROVEMENTS PHASE II
CONTRACT NO. DH13-017



SHEET TITLE:

SHUTTLE PARKING CANOPY
ENLARGED PLAN AND SECTION

PND PROJECT NO.: 102081

DWG. FILE:

A3.01
SHEET
34 OF 52

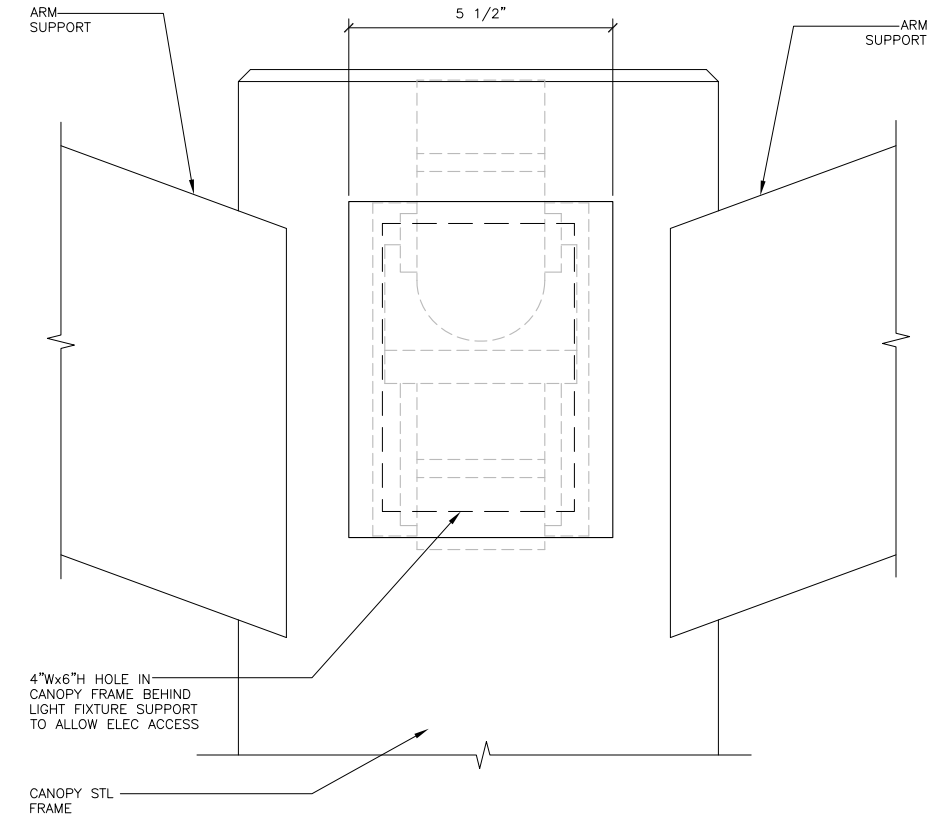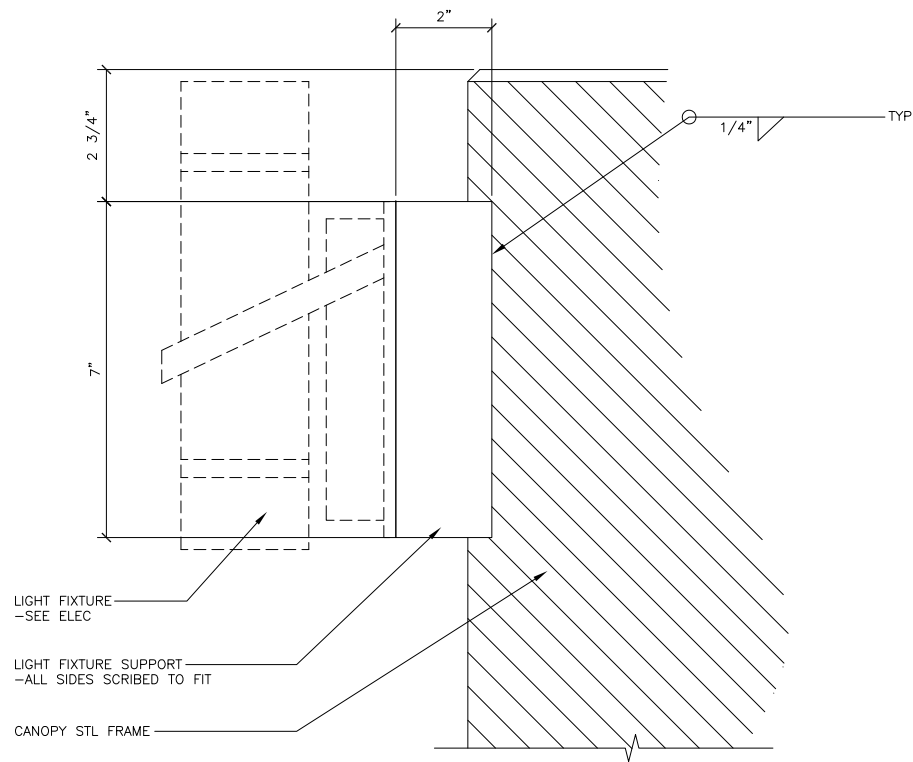

1 LIGHT FIXTURE SUPPORT (SIDE)
10089/X_A4.03-1

SCALE: 0 3" 6"

2 LIGHT FIXTURE SUPPORT (FRONT)
10089/X_A4.03-2

SCALE: 0 3" 6"



Jensen
Yorba
Lott
Inc.

ARCHITECTURE
INTERIORS
CONSTRUCTION
MANAGEMENT

522 West 10th Street, Juneau, Alaska 99801
Phone 907-586-1070 www.jensenyorbalott.com

REVISIONS					
REV.	DATE	DESCRIPTION	DWN.	CKD.	APP.


P | N | D
ENGINEERS, INC.

9360 Glacier Highway, Ste. 100
Juneau, Alaska 99801
Phone: 907-586-2093
Fax: 907-586-2099
www.pndengineers.com

DESIGN: JL
DRAWN: ADG

CHECKED: ADG
APPROVED: JL

SCALE: SCALE IN FEET
0 25 50 FT.


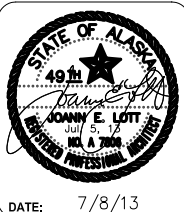


**CRUISE SHIP TERMINAL STAGING AREA
IMPROVEMENTS PHASE II
CONTRACT NO. DH13-017**

SHEET TITLE:
CANOPY DETAILS

PND PROJECT NO.: 102081 DWG. FILE:


A3.02
SHEET
35 OF 52

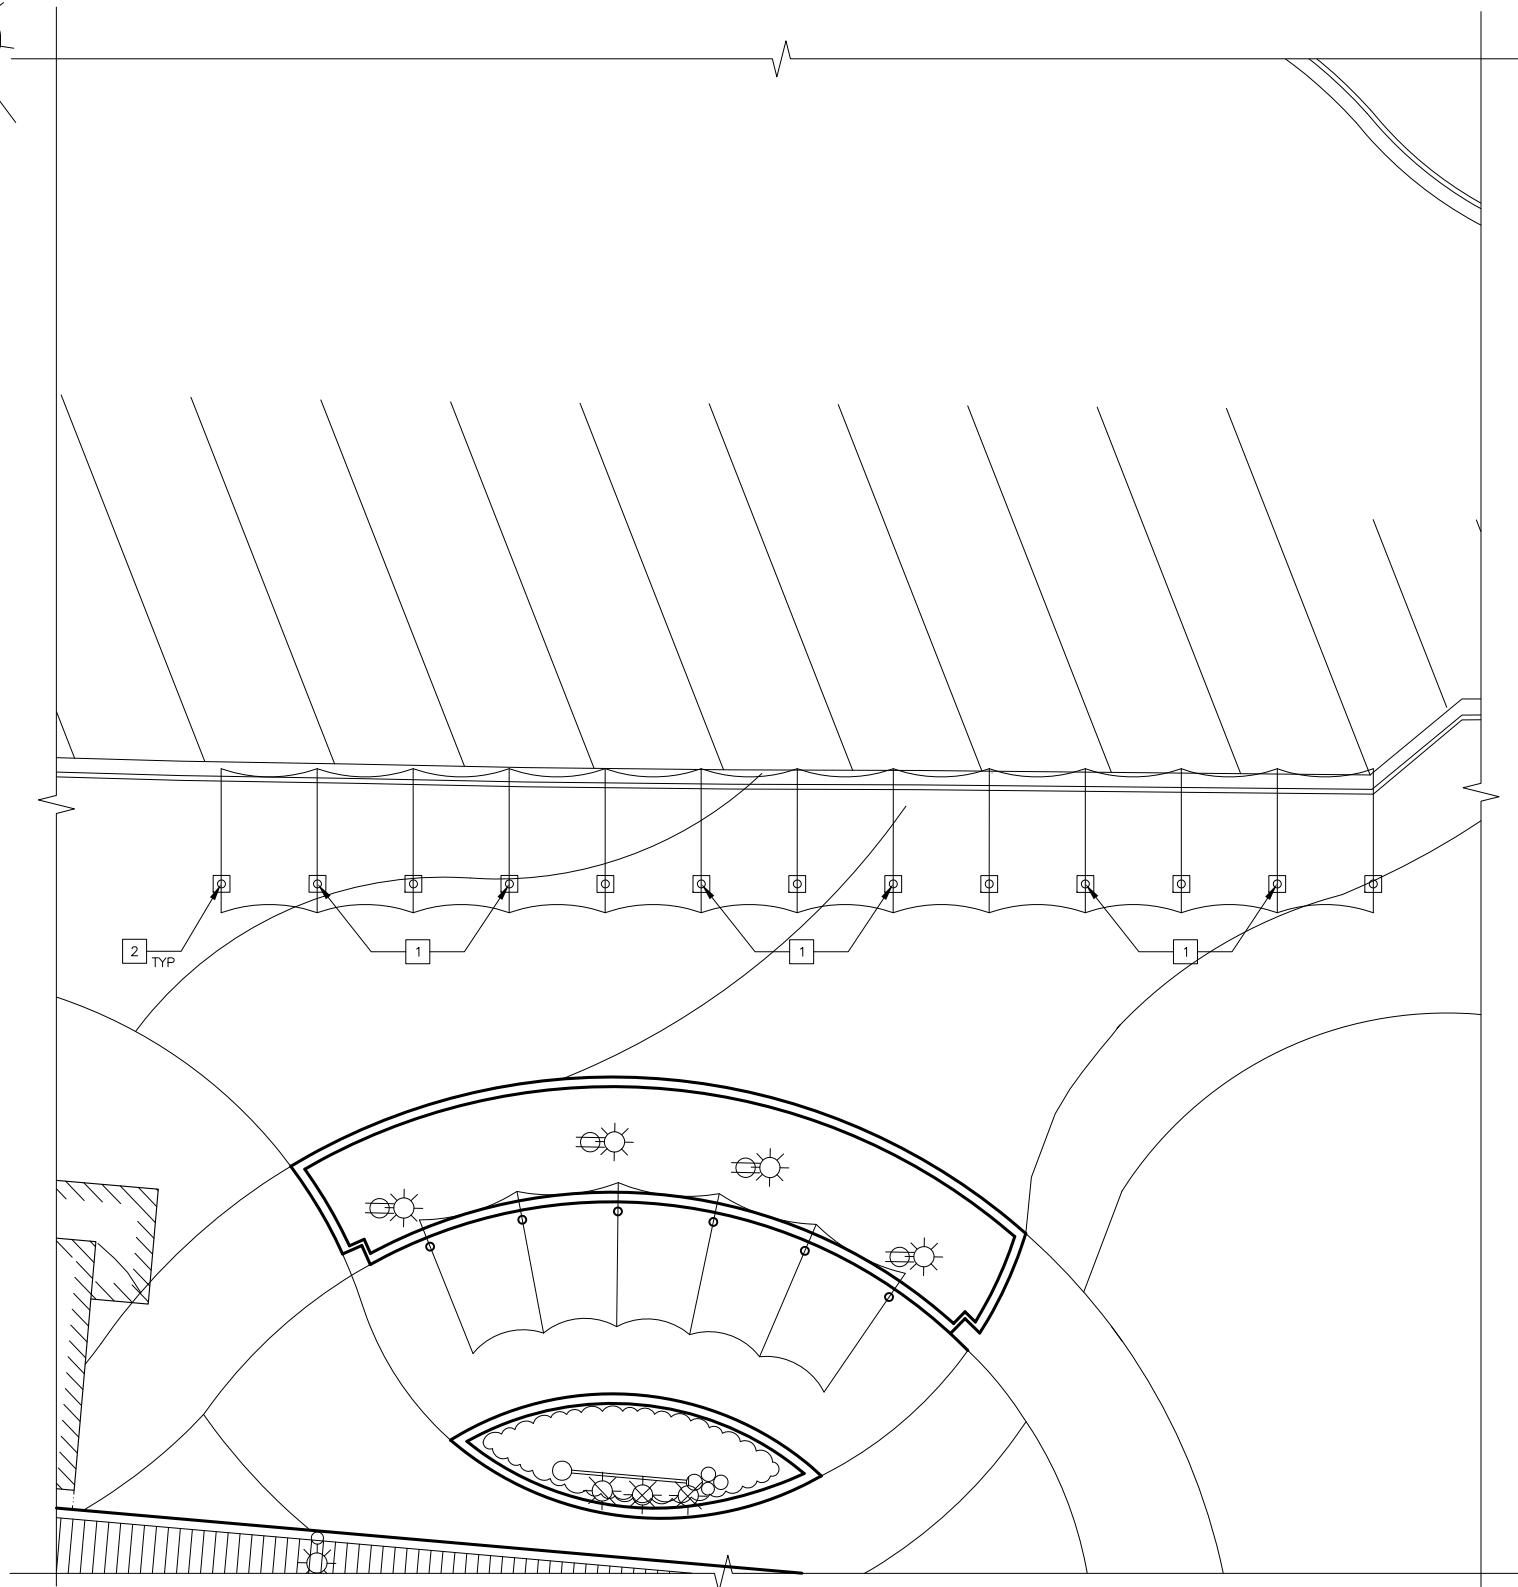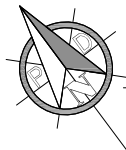

1 ENLARGED SITE PLAN - BUS CANOPY

KEY NOTES

- 1 EX LIGHT ON CANOPY FRAME
-(6) LOCATIONS
- 2 EX BUS CANOPY FRAME TO
RECEIVE REVISED EXTENSION
-(13) LOCATIONS
-SEE 2/A3.03

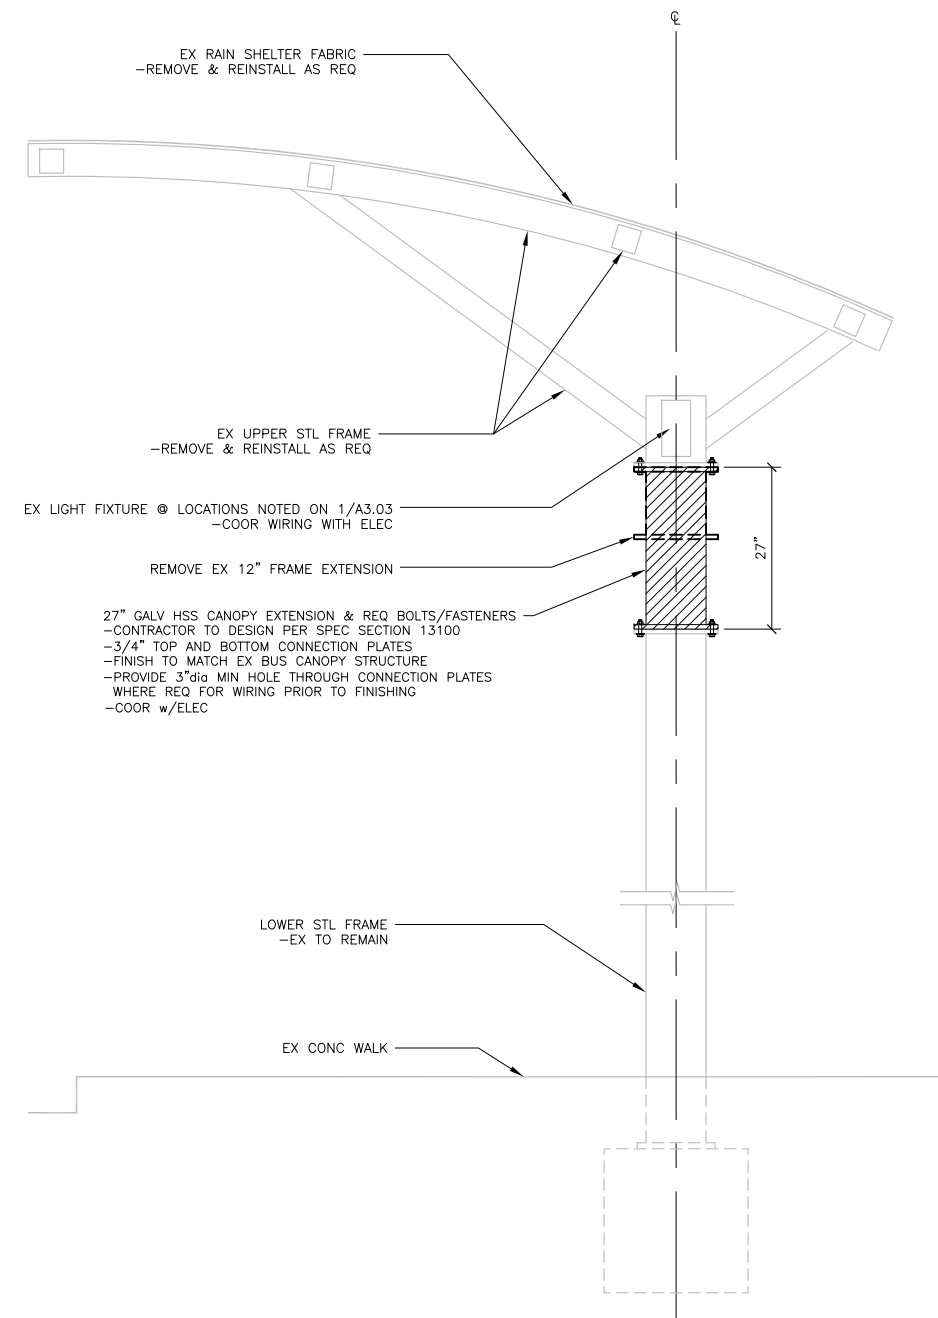

2 BUS CANOPY SECTION
10089/X_A3.03-2

SCALE: 0 1' 2' 4'



Jensen
Yorba
Lott
Inc.

ARCHITECTURE
INTERIORS
CONSTRUCTION
MANAGEMENT

522 West 10th Street, Juneau, Alaska 99801
Phone 907-586-1070 www.jensenyorbalott.com


REVISIONS					
REV.	DATE	DESCRIPTION	DWN.	CKD.	APP.

P | N | D
ENGINEERS, INC.

9360 Glacier Highway, Ste. 100
Juneau, Alaska 99801
Phone: 907-586-2093
Fax: 907-586-2099
www.pndengineers.com

DESIGN: JL CHECKED: ADG
DRAWN: ADG APPROVED: JL

SCALE:

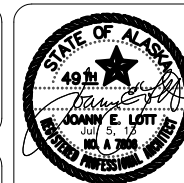

DATE: 7/8/13

CRUISE SHIP TERMINAL STAGING AREA
IMPROVEMENTS PHASE II
CONTRACT NO. DH13-017

SHEET TITLE:
**BUS CANOPY
ENLARGED PLAN AND SECTION**

PND PROJECT NO.: 102081 DWG. FILE:

A3.03
SHEET
36 OF 52