


Jul 08, 2013 - 2:27pm
F:\Projects\137 PNAD 800 Cruise Ship Terminal Upgrades Ph 1\Drawings\Working\E5.01.dwg (E6.01 tab)

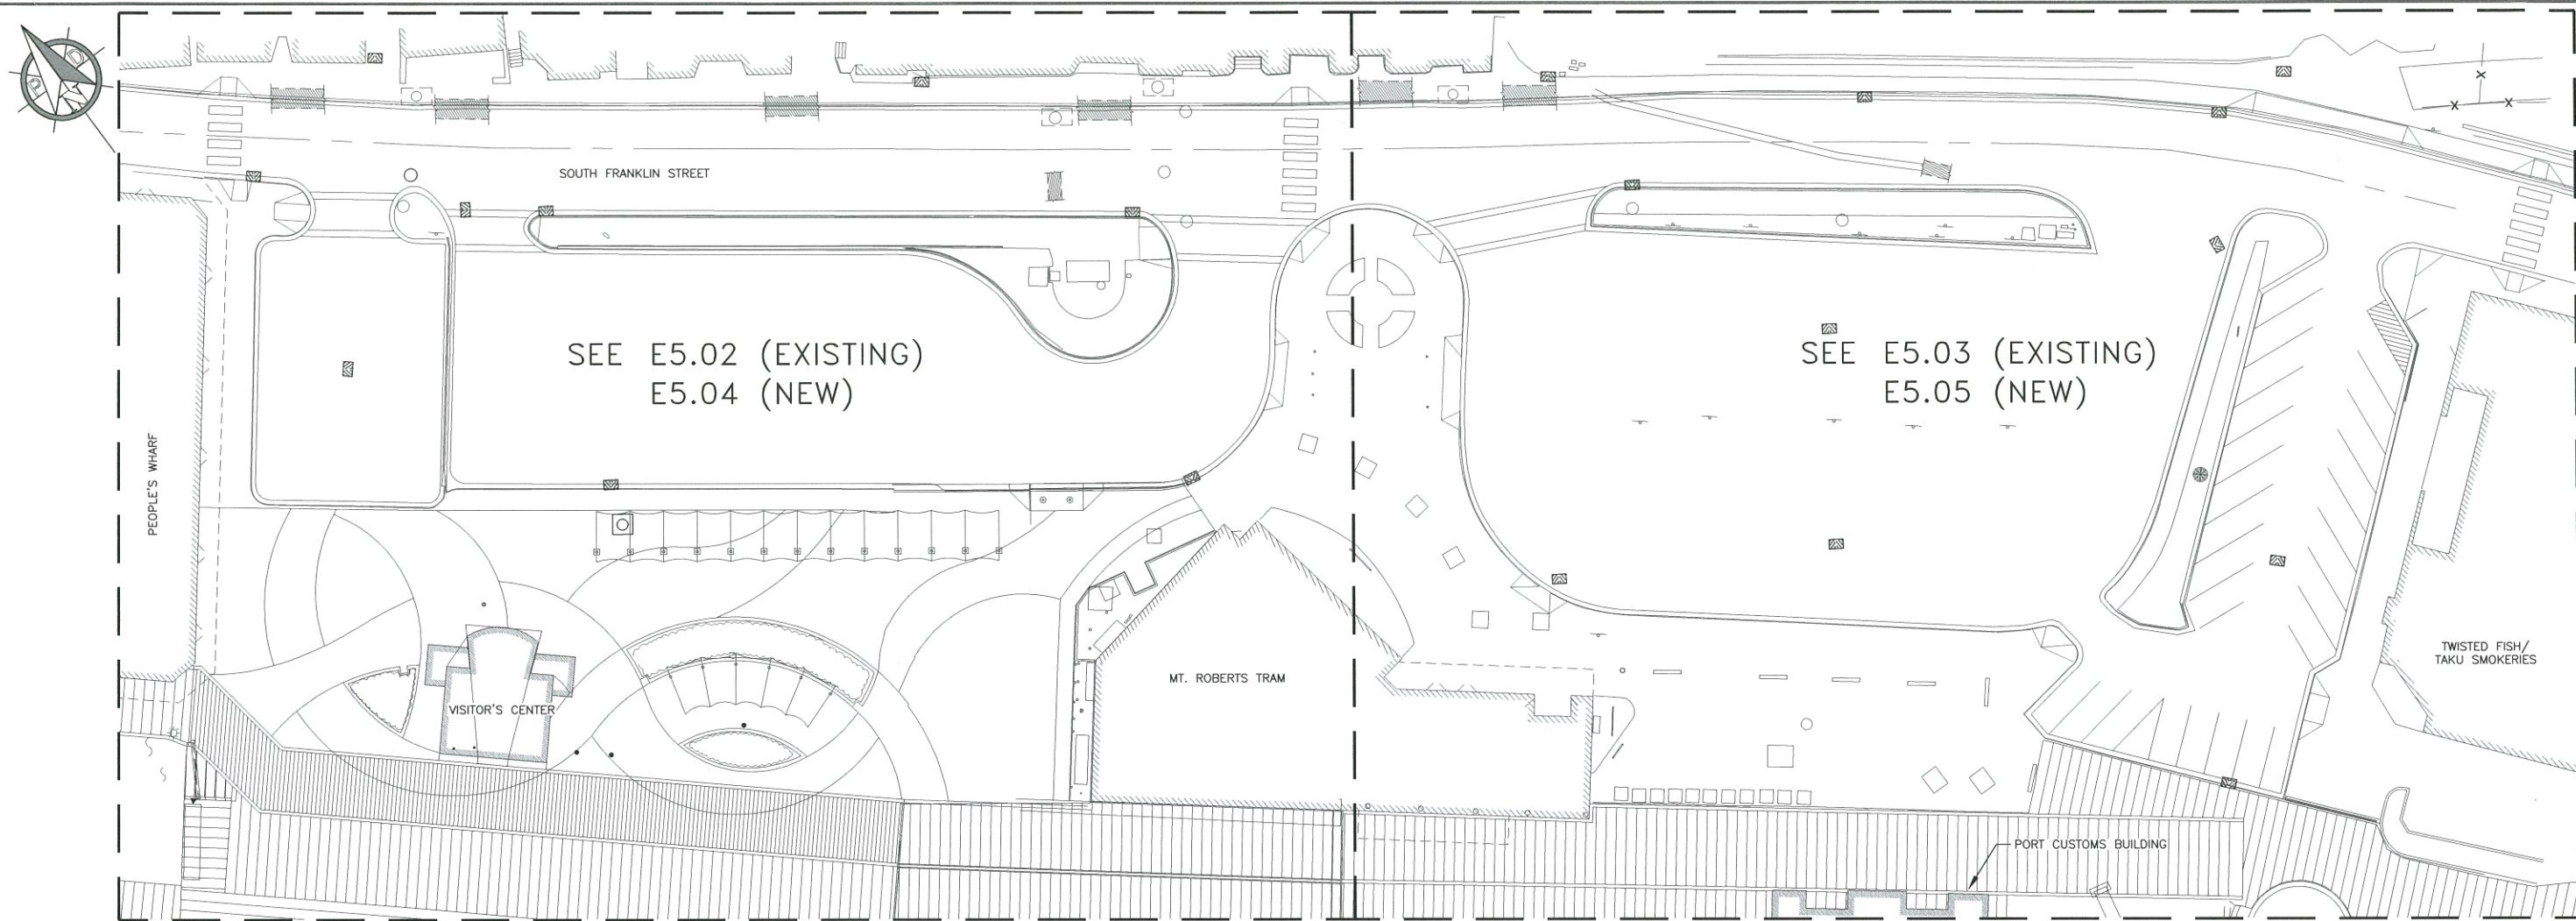

1 EXISTING OVERALL SITE PLAN
SCALE: AS NOTED

LEGEND

- ABBREVIATIONS:**
- TYP TYPICAL
 - UON UNLESS OTHERWISE NOTED
 - UGE UNDERGROUND ELECTRIC
 - XFMR TRANSFORMER
 - (E) EXISTING TO REMAIN
 - (N) NEW
 - (R) RELOCATE EXISTING
 - (X) REMOVE
- LIGHTING:**
- EXTERIOR POLE MOUNTED LUMINAIRE
 - EXTERIOR WALL MOUNTED LUMINAIRE
 - LIGHTING CONTACTOR
- POWER:**
- TRANSFORMER
 - JUNCTION BOX
 - HANDHOLE
 - BREAKER
 - CONTACT
 - PANEL
- LOW VOLTAGE:**
- SECURITY CAMERA
- GENERAL:**
- HOME RUN
 - CONDUIT: 1/2" UON.
 - UNGROUND CONDUCTORS (#12 AWG)
 - NEUTRAL: #10 WITH DOT
#12 OTHERWISE
 - GROUND CONDUCTOR
 - CONDUCTORS NOT SHOWN WHERE ONLY
#12 NEUTRAL AND UNGROUNDED
CONDUCTOR ARE REQUIRED



REVISIONS					
REV.	DATE	DESCRIPTION	DWN.	CKD.	APP.

PND
ENGINEERS, INC.

9360 Glacier Highway, Ste. 100
Juneau, Alaska 99801
Phone: 907-586-2093
Fax: 907-586-2099
www.pndengineers.com

DESIGN: BCH/KHD CHECKED: BCH
DRAWN: KHD APPROVED: BCH

SCALE: SCALE IN FEET
0 25 50 FT.




CRUISE SHIP TERMINAL STAGING AREA IMPROVEMENTS
CONTRACT NO. DH13-017

SHEET TITLE:
EXISTING OVERALL SITE PLAN

SHEET
43 OF 52

PND PROJECT NO.: 102081 DWG. FILE:

Jul 08, 2013 - 3:47pm
F:\Projects\137 PND\80a Cruise Ship Terminal Upgrades Ph. II\Drawings\Working\E5.02.dwg (E5.02 tab)

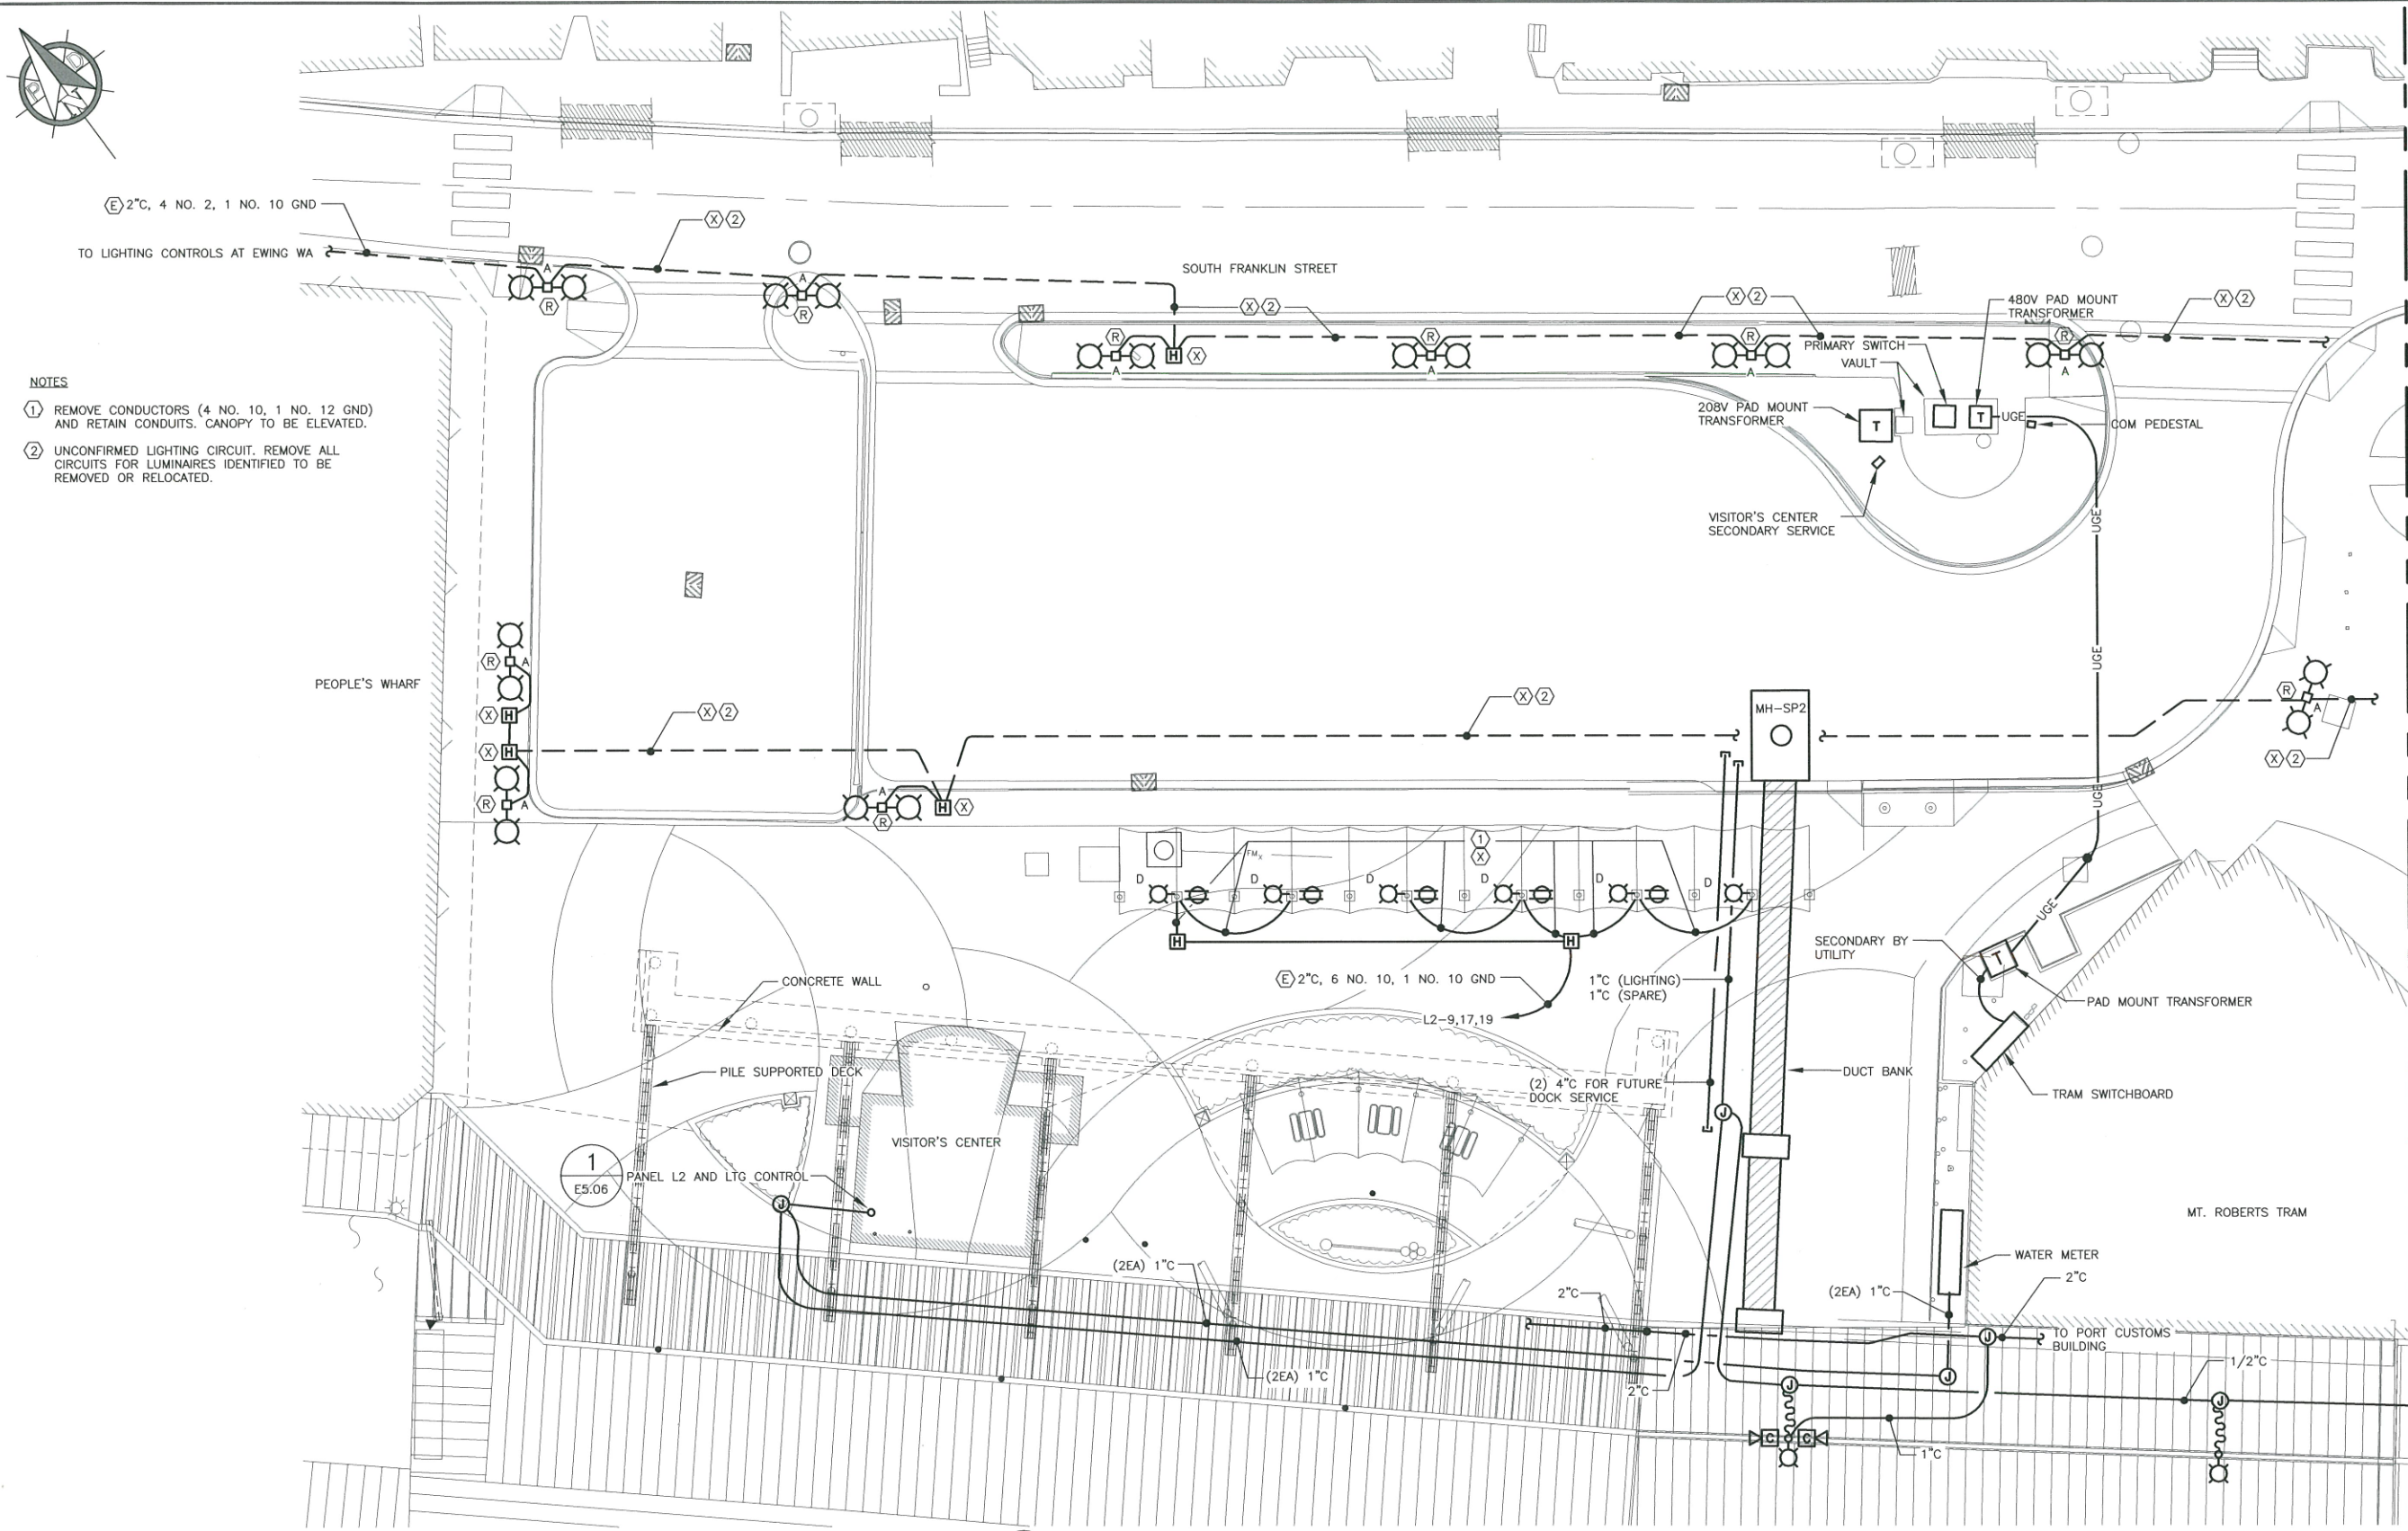

1 EXISTING PARTIAL SITE PLAN
SCALE: AS NOTED



HAIGHT & ASSOCIATES
CONSULTING ELECTRICAL ENGINEERS
525 Main Street, Juneau, AK 99901
(907) 586-9788

REVISIONS					
REV.	DATE	DESCRIPTION	DWN.	CKD.	APP.



9360 Glacier Highway, Ste. 100
Juneau, Alaska 99801
Phone: 907-586-2093
Fax: 907-586-2099
www.pndengineers.com

DESIGN: BCH/KHD
DRAWN: KHD
CHECKED: BCH
APPROVED: BCH

SCALE: SCALE IN FEET
0 15 30 FT.



CRUISE SHIP TERMINAL STAGING AREA IMPROVEMENTS
CONTRACT NO. DH13-017


SHEET TITLE: EXISTING PARTIAL SITE PLAN
PND PROJECT NO.: 102081
DWG. FILE:

E5.02
SHEET 44 OF 52

Jul 08, 2013 - 3:47pm
F:\Projects\137 PND\800 Cruise Ship Terminal Upgrade Ph 1\Drawings\Working\E5.03.dwg (E5.03 tab)



MATCHLINE SEE E5.02

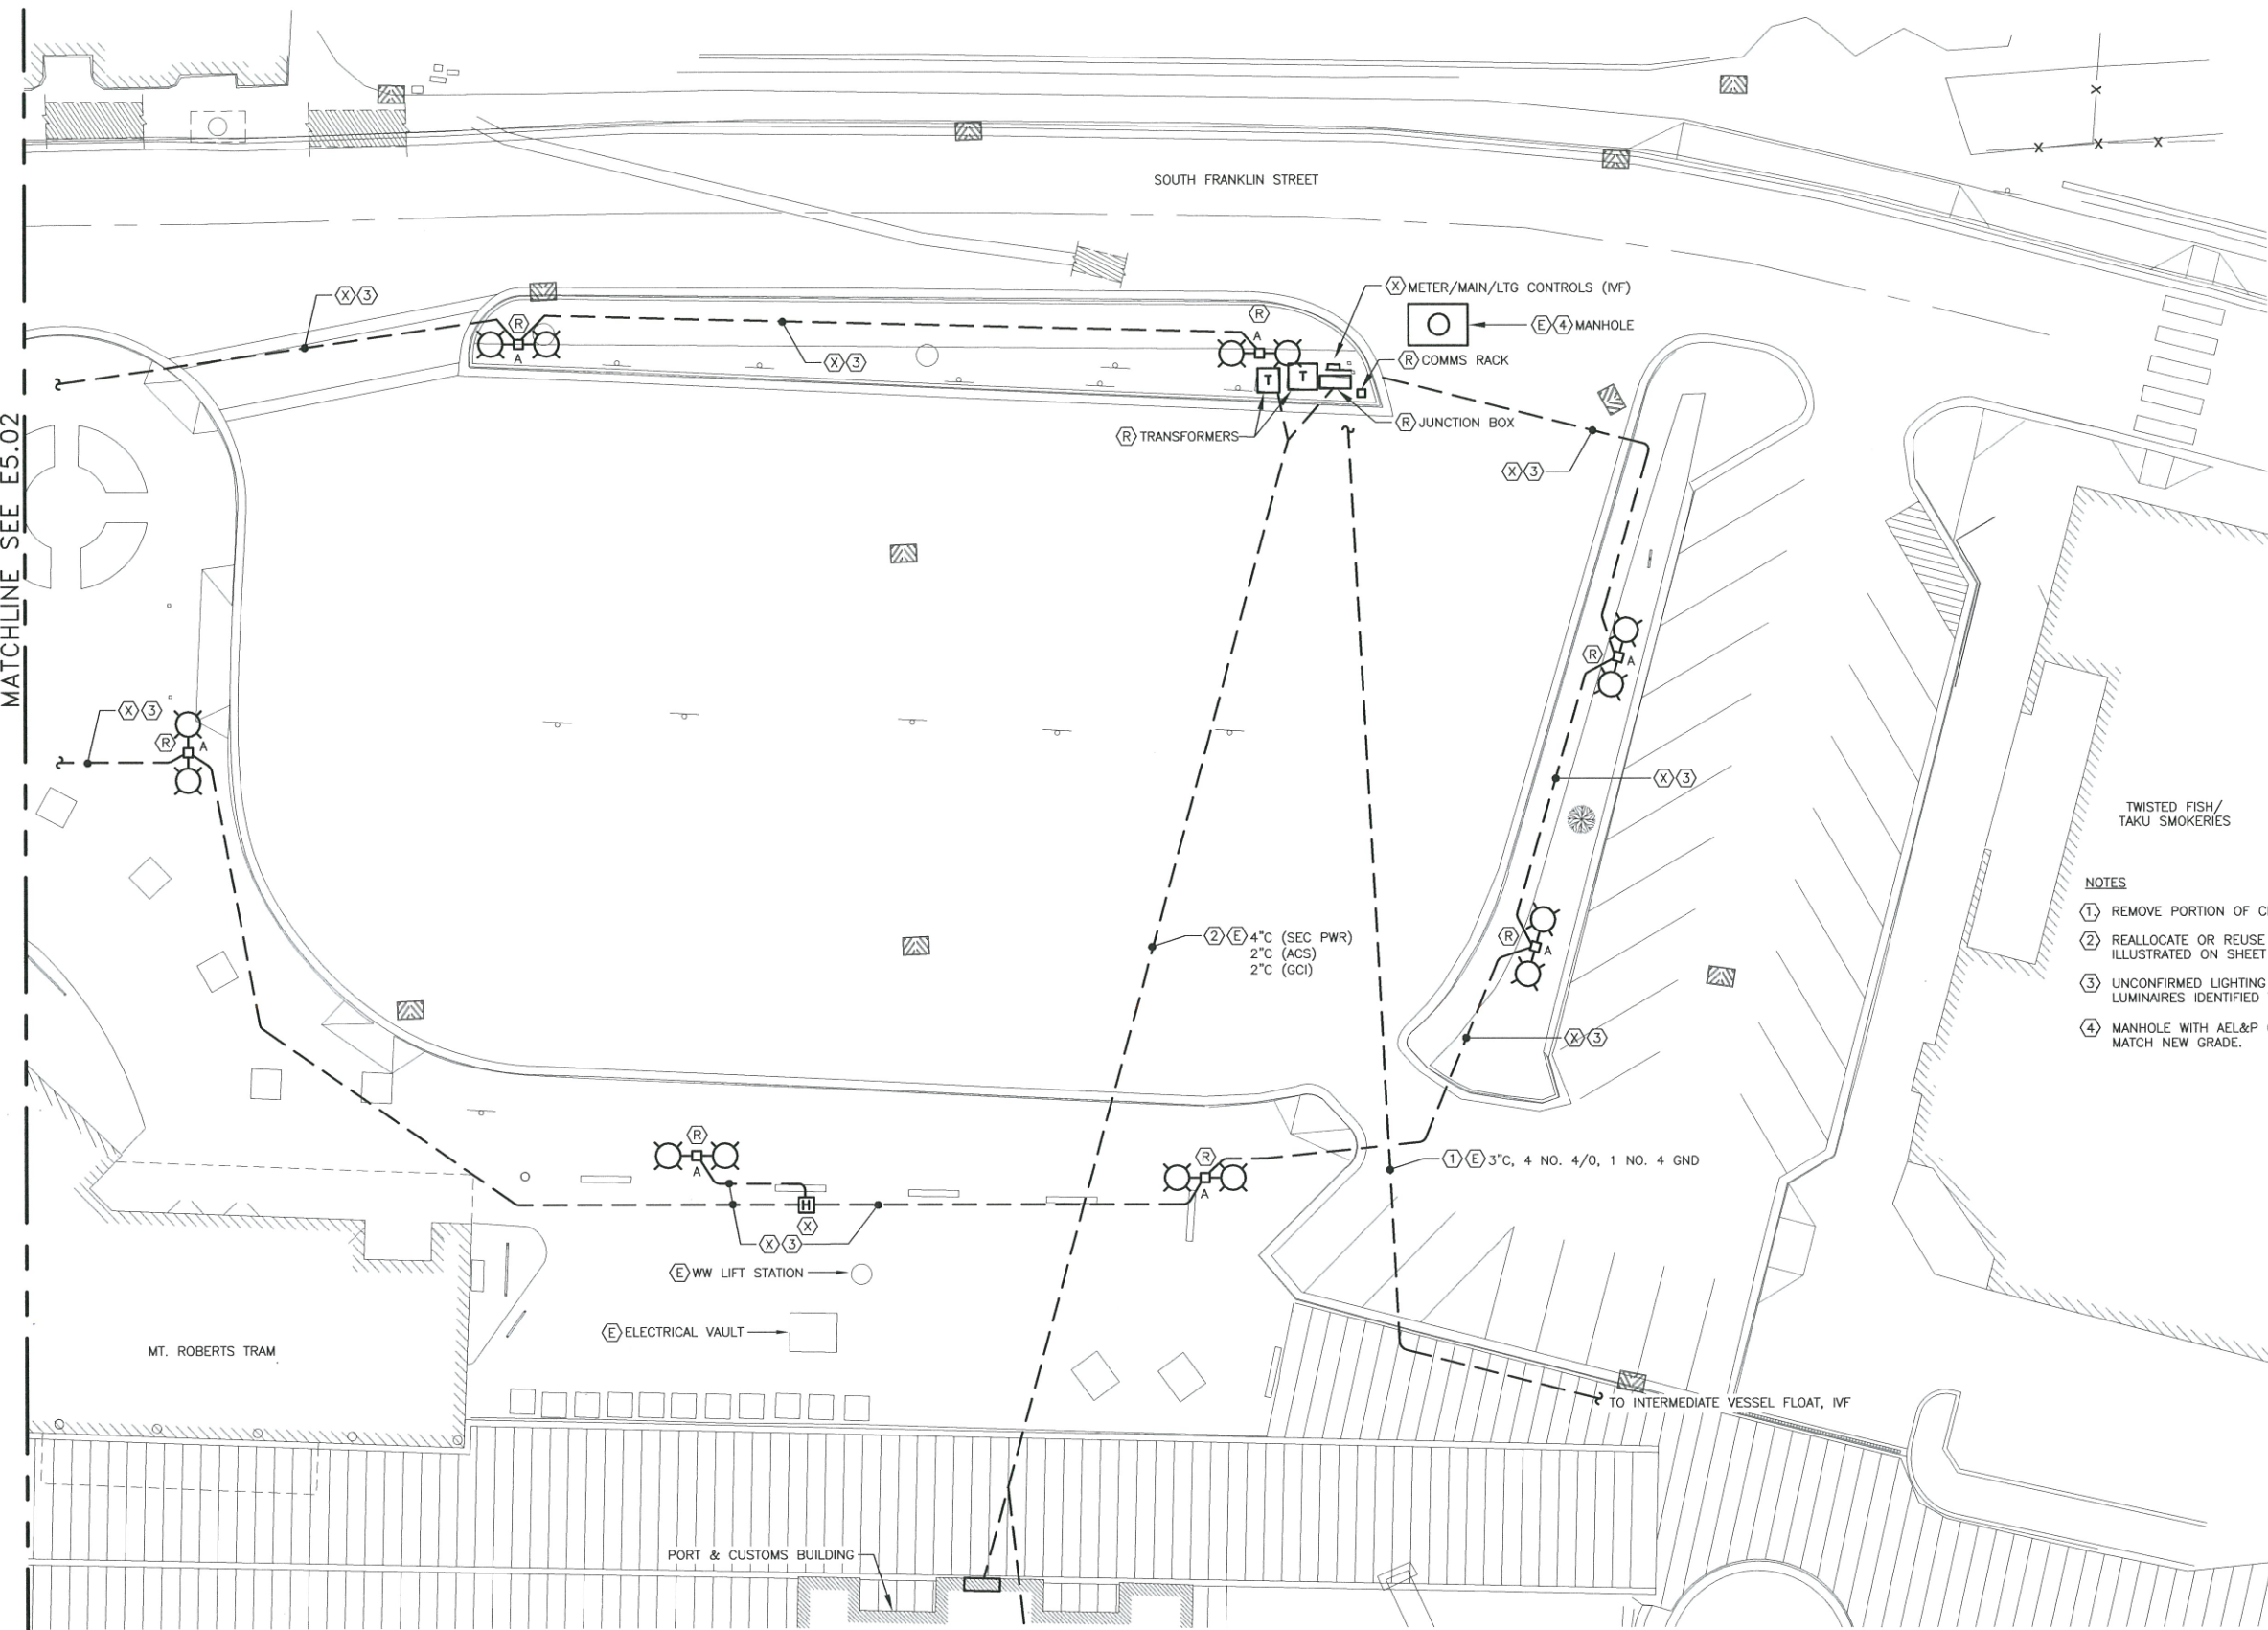

TWISTED FISH/
TAKU SMOKERIES

NOTES

- 1 REMOVE PORTION OF CIRCUIT AND REFEED IVF PER SHEET E5.05.
- 2 REALLOCATE OR REUSE CONDUITS TO COMPLETE INSTALLATION ILLUSTRATED ON SHEET E5.05 WHERE POSSIBLE.
- 3 UNCONFIRMED LIGHTING CIRCUIT. REMOVE ALL CIRCUITS FOR LUMINAIRES IDENTIFIED TO BE REMOVED OR RELOCATED.
- 4 MANHOLE WITH AEL&P CABLES: ADJUST ACCESS LID/RISERS TO MATCH NEW GRADE.

1 EXISTING PARTIAL SITE PLAN

SCALE: AS NOTED



HAIGHT & ASSOCIATES
CONSULTING
ELECTRICAL
ENGINEERS
526 Main Street, Juneau, AK 99801
(907) 586-9788


REVISIONS					
REV.	DATE	DESCRIPTION	DWN.	CKD.	APP.

P N D
ENGINEERS, INC.

9360 Glacier Highway, Ste. 100
Juneau, Alaska 99801
Phone: 907-586-2093
Fax: 907-586-2099
www.pndengineers.com

DESIGN: BCH/KHD CHECKED: BCH
DRAWN: KHD APPROVED: BCH

SCALE: SCALE IN FEET
0 15 30 FT.

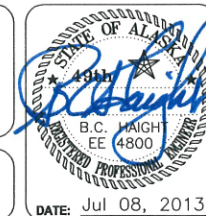

DATE: Jul 08, 2013

**CRUISE SHIP TERMINAL STAGING AREA
IMPROVEMENTS**
CONTRACT NO. DH13-017

SHEET TITLE:
EXISTING PARTIAL SITE PLAN

PND PROJECT NO.: 102081 DWG. FILE:

E5.03
SHEET
45 OF 52