
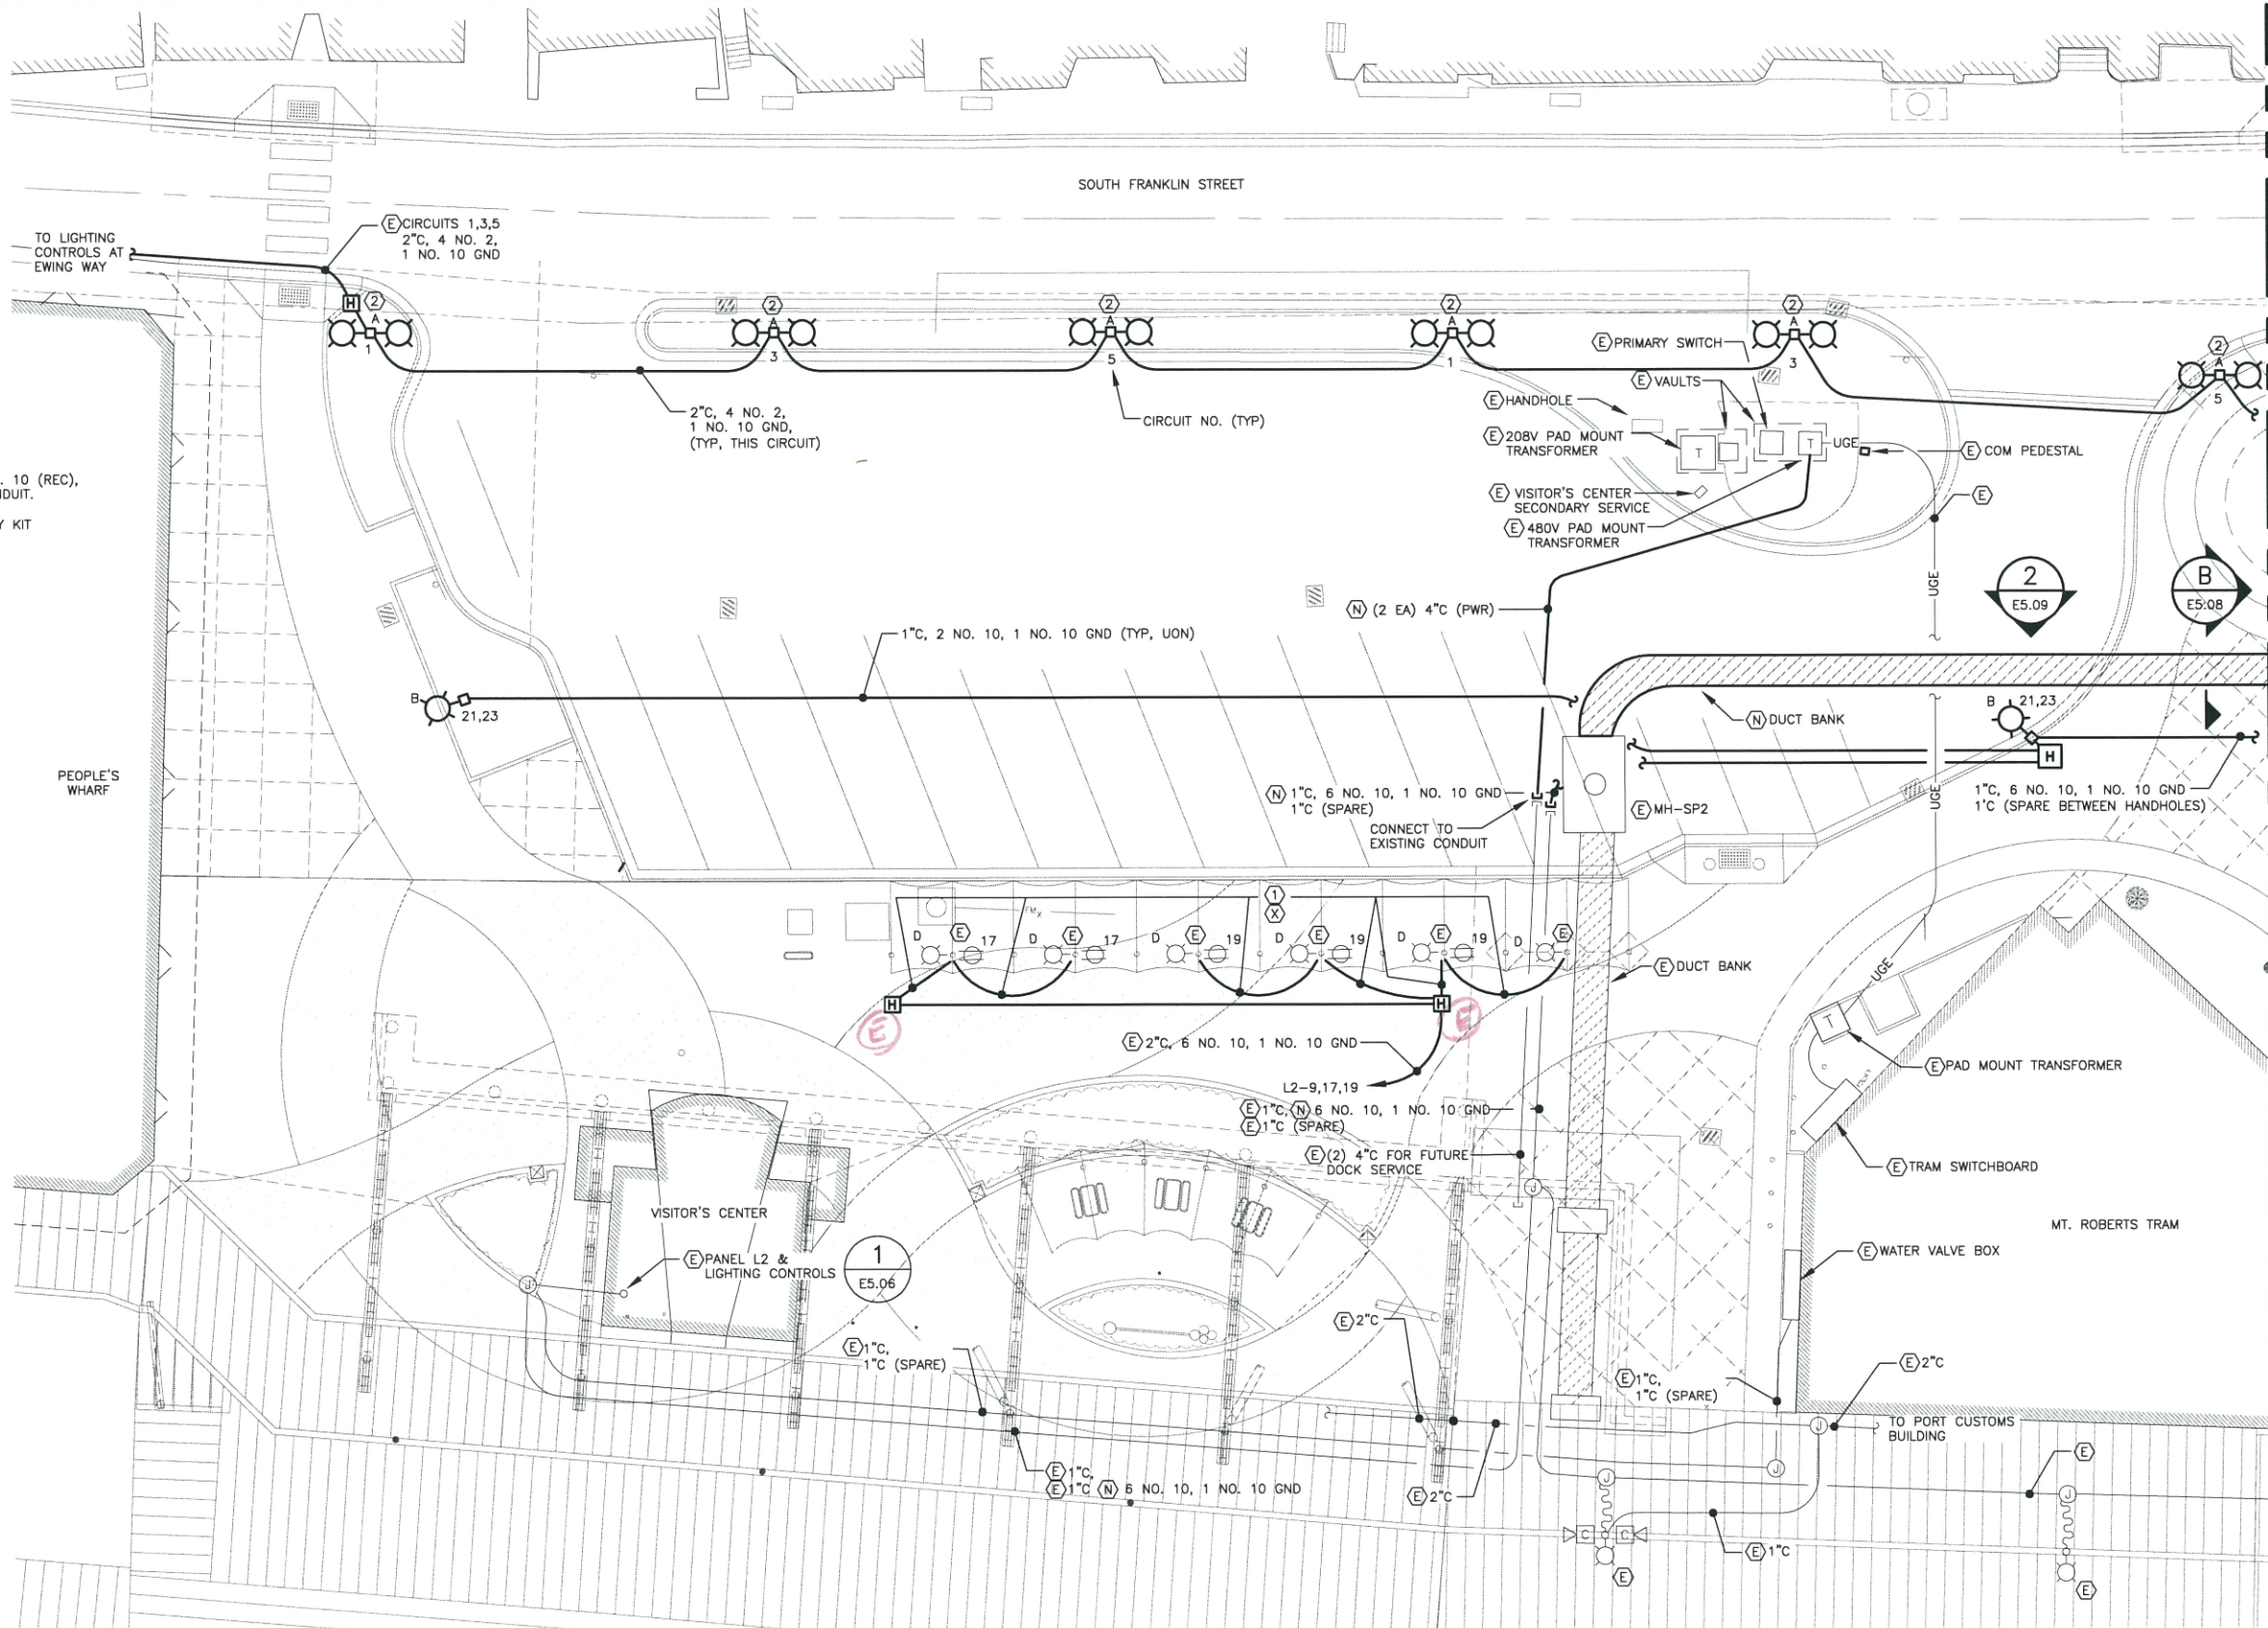


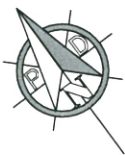

NOTES

- 1 PROVIDE NEW 2 NO. 10 (LTG), 2 NO. 10 (REC), AND 1 NO. 10 GND IN EXISTING CONDUIT.
- 2 PROVIDE MANUFACTURER'S BREAKAWAY KIT BENEATH EXISTING METAL SKIRT.

1 NEW PARTIAL SITE PLAN

SCALE: AS NOTED




| REVISIONS |      |             |      |      |      |
|-----------|------|-------------|------|------|------|
| REV.      | DATE | DESCRIPTION | DWN. | CKD. | APP. |
|           |      |             |      |      |      |
|           |      |             |      |      |      |
|           |      |             |      |      |      |
|           |      |             |      |      |      |
|           |      |             |      |      |      |



9360 Glacier Highway, Ste. 100  
Juneau, Alaska 99801  
Phone: 907-586-2093  
Fax: 907-586-2099  
www.pndengineers.com

DESIGN: BCH/KHD CHECKED: BCH  
DRAWN: KHD APPROVED: BCH

SCALE: SCALE IN FEET  
0 15 30 FT.

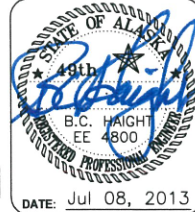


CRUISE SHIP TERMINAL STAGING AREA  
IMPROVEMENTS  
CONTRACT NO. DH13-017

SHEET TITLE:  
NEW PARTIAL SITE PLAN


PND PROJECT NO.: 102081 DWG. FILE:

E5.04  
SHEET  
46 OF 52

Jul 08, 2013 - 2:28pm  
F:\Projects\137 PN&D\80a Cruise Ship Terminal Uplands Ph II Drawings\Working\E5.05.dwg (E6.03 tab)

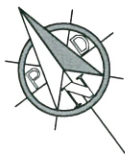

MATCHLINE SEE E5.04

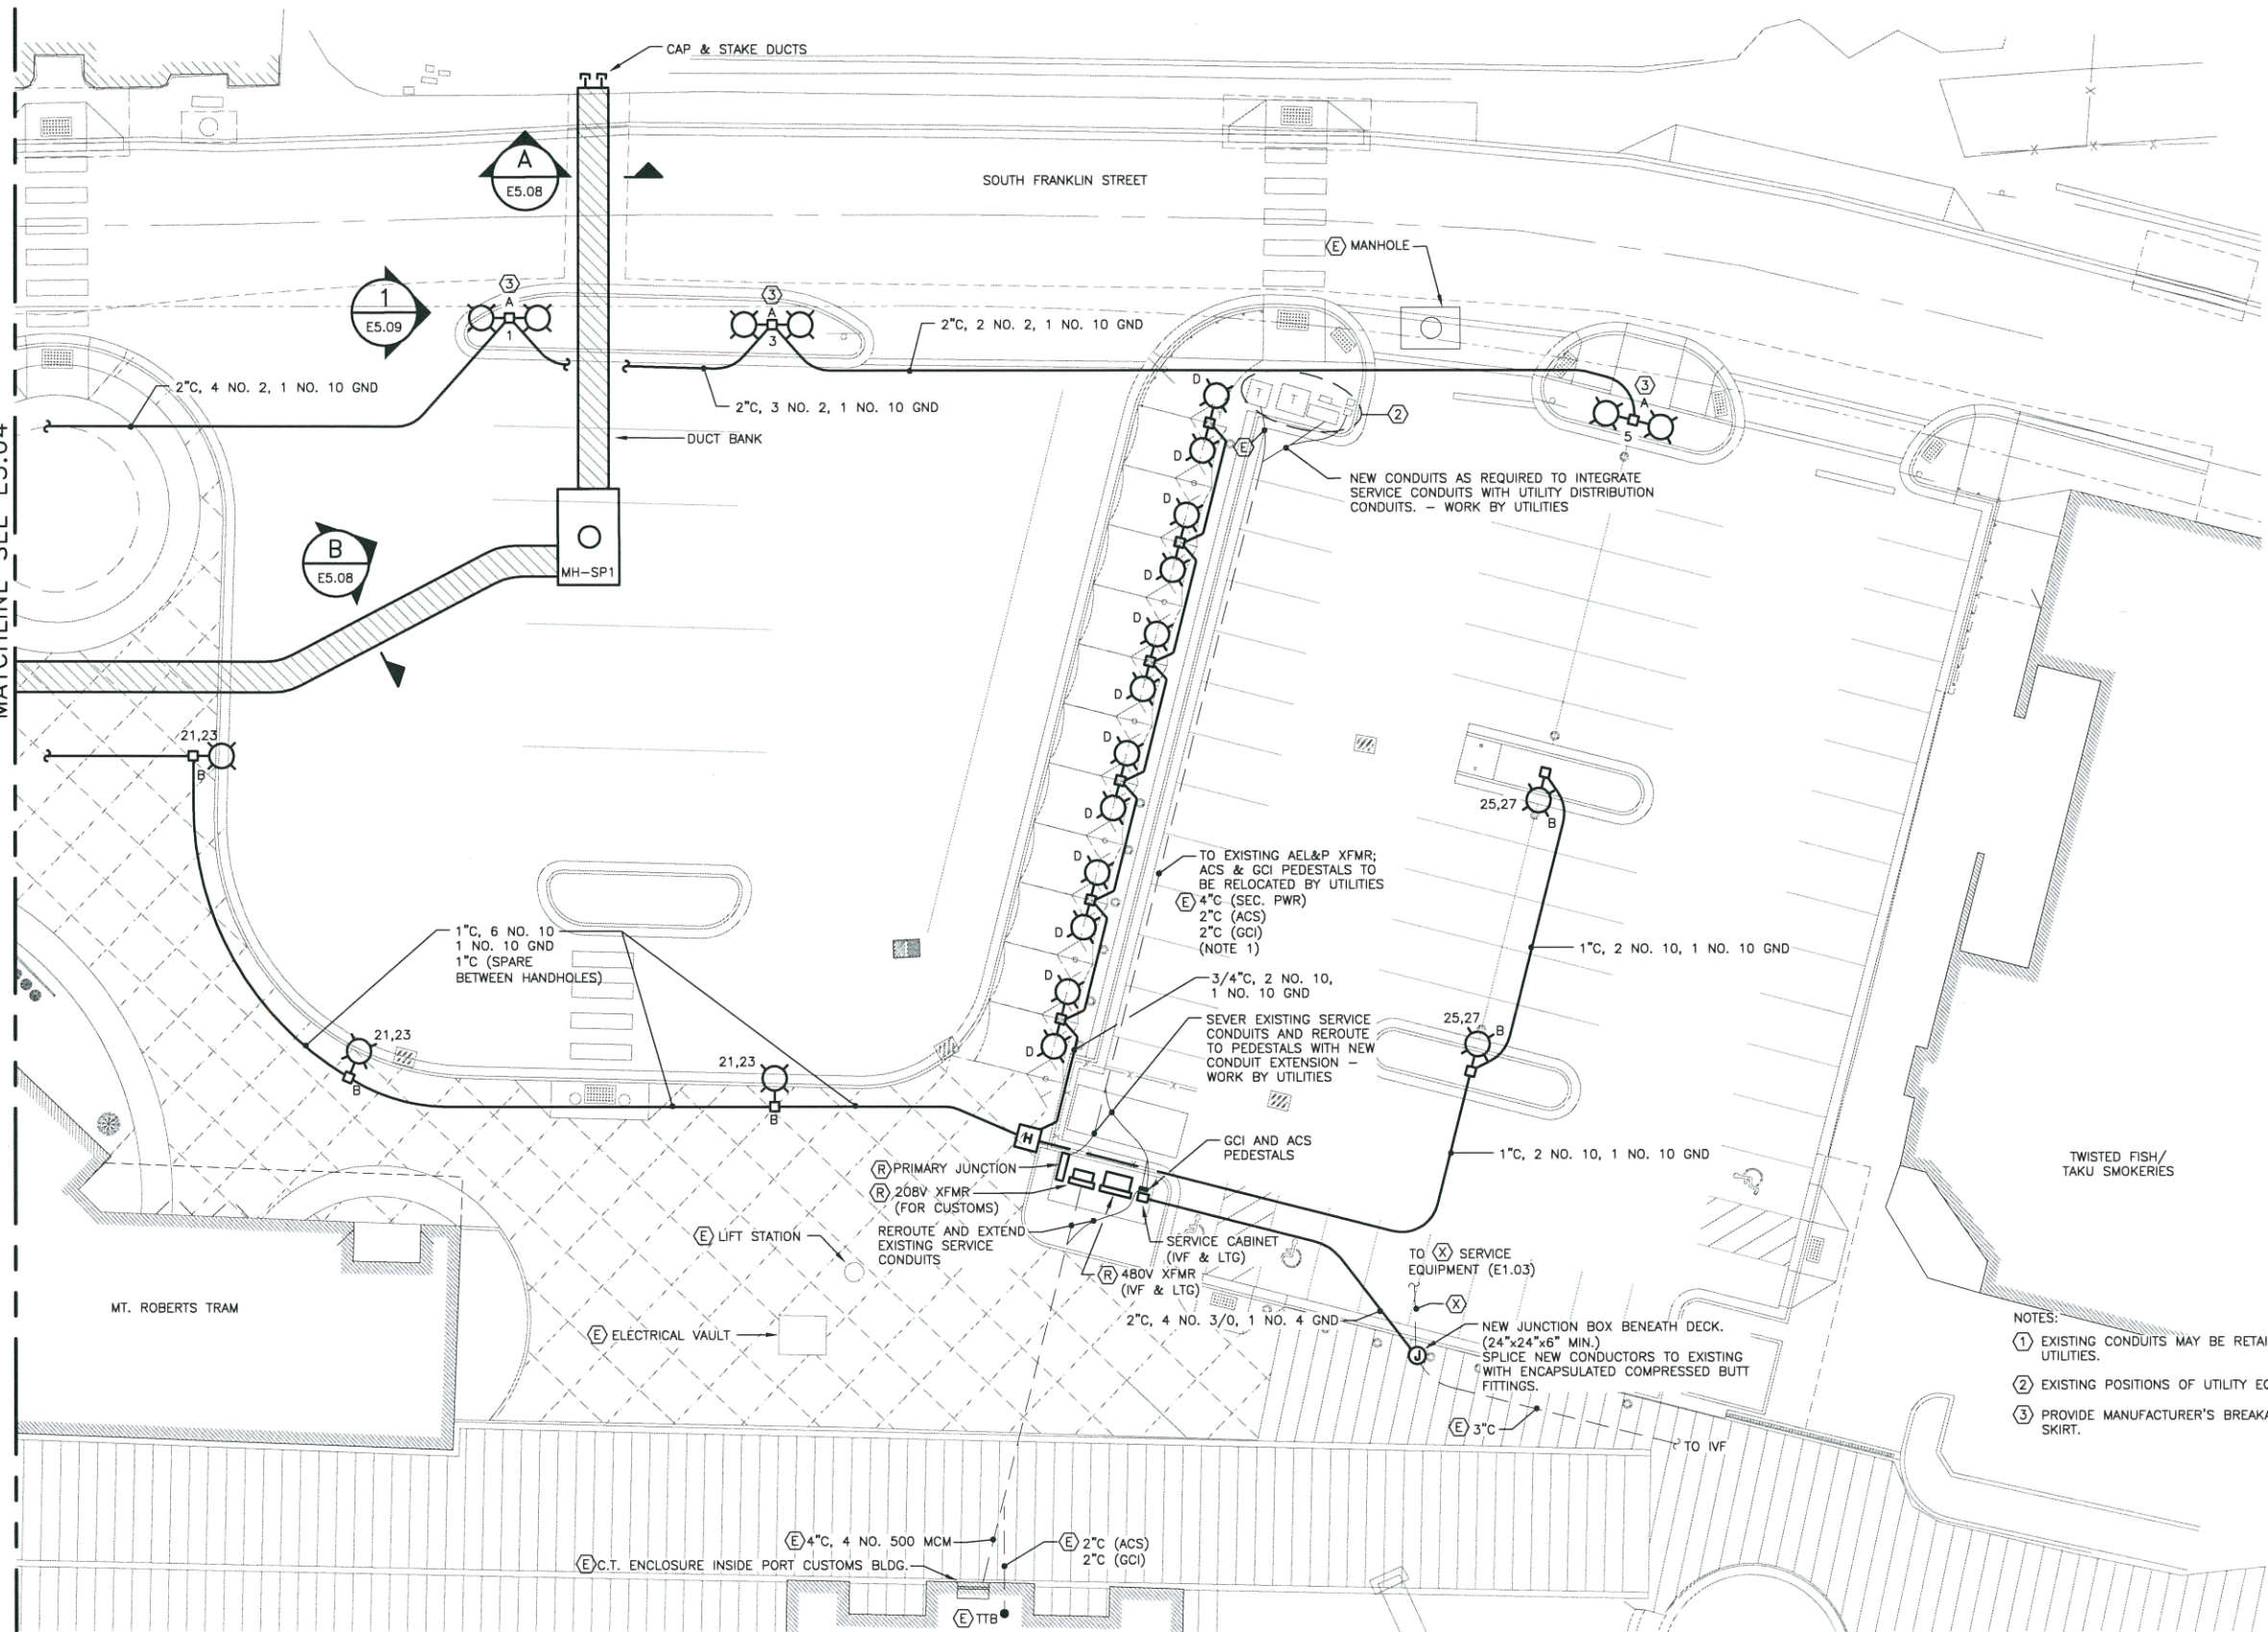

- NOTES:
- EXISTING CONDUITS MAY BE RETAINED AND REPURPOSED BY THE UTILITIES.
  - EXISTING POSITIONS OF UTILITY EQUIPMENT TO BE RELOCATED.
  - PROVIDE MANUFACTURER'S BREAKAWAY KIT BENEATH EXISTING METAL SKIRT.

1 NEW PARTIAL SITE PLAN

SCALE: AS NOTED




| REVISIONS |      |             |      |      |      |
|-----------|------|-------------|------|------|------|
| REV.      | DATE | DESCRIPTION | DWN. | CKD. | APP. |
|           |      |             |      |      |      |
|           |      |             |      |      |      |
|           |      |             |      |      |      |
|           |      |             |      |      |      |
|           |      |             |      |      |      |
|           |      |             |      |      |      |



9360 Glacier Highway, Ste. 100  
Juneau, Alaska 99801  
Phone: 907-586-2093  
Fax: 907-586-2099  
www.pndengineers.com

DESIGN: BCH/KHD  
CHECKED: BCH  
DRAWN: KHD  
APPROVED: BCH

SCALE: SCALE IN FEET  
0 15 30 FT.

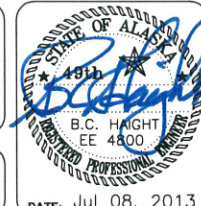


CRUISE SHIP TERMINAL STAGING AREA  
IMPROVEMENTS  
CONTRACT NO. DH13-017

SHEET TITLE:  
NEW PARTIAL SITE PLAN


PND PROJECT NO.: 102081 DWG. FILE:

E5.05  
SHEET  
47 OF 52

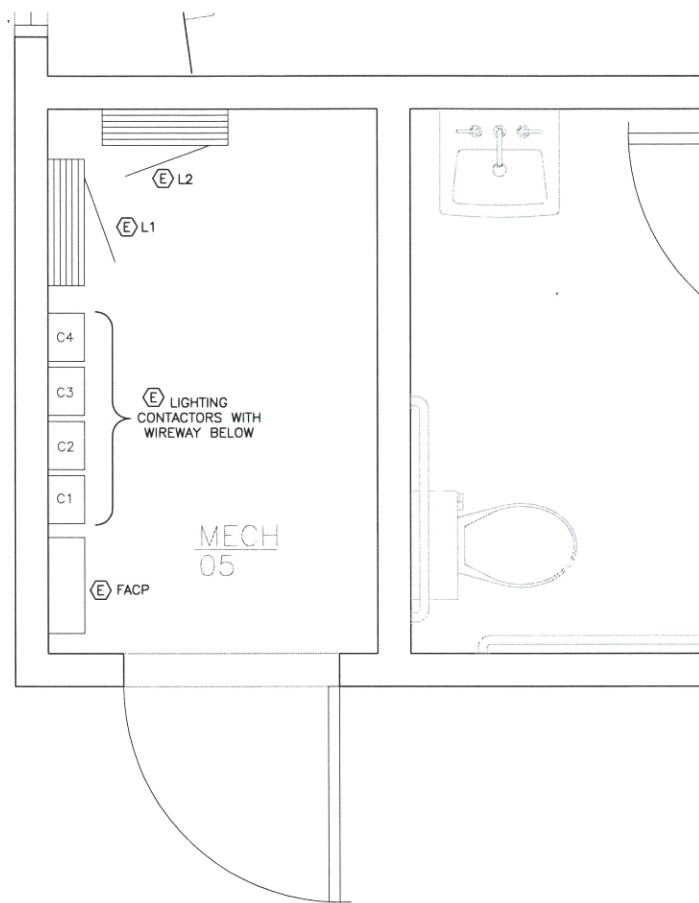


1 ENLARGED PLAN - VISITOR'S CENTER MECHANICAL 05


SCALE IN FEET  
0 1 2 FT.

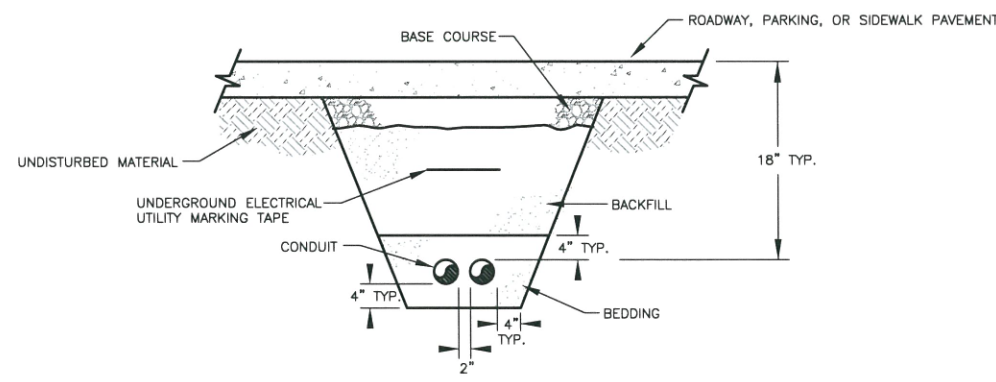

3 TRENCH - SECONDARY  
NO SCALE

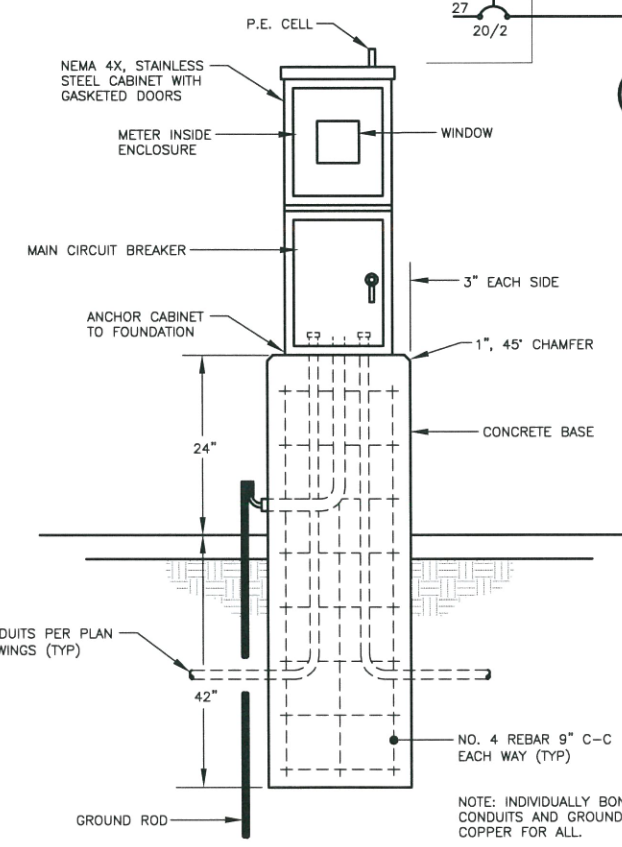


4 DETAIL - IVF SERVICE EQUIPMENT  
NO SCALE

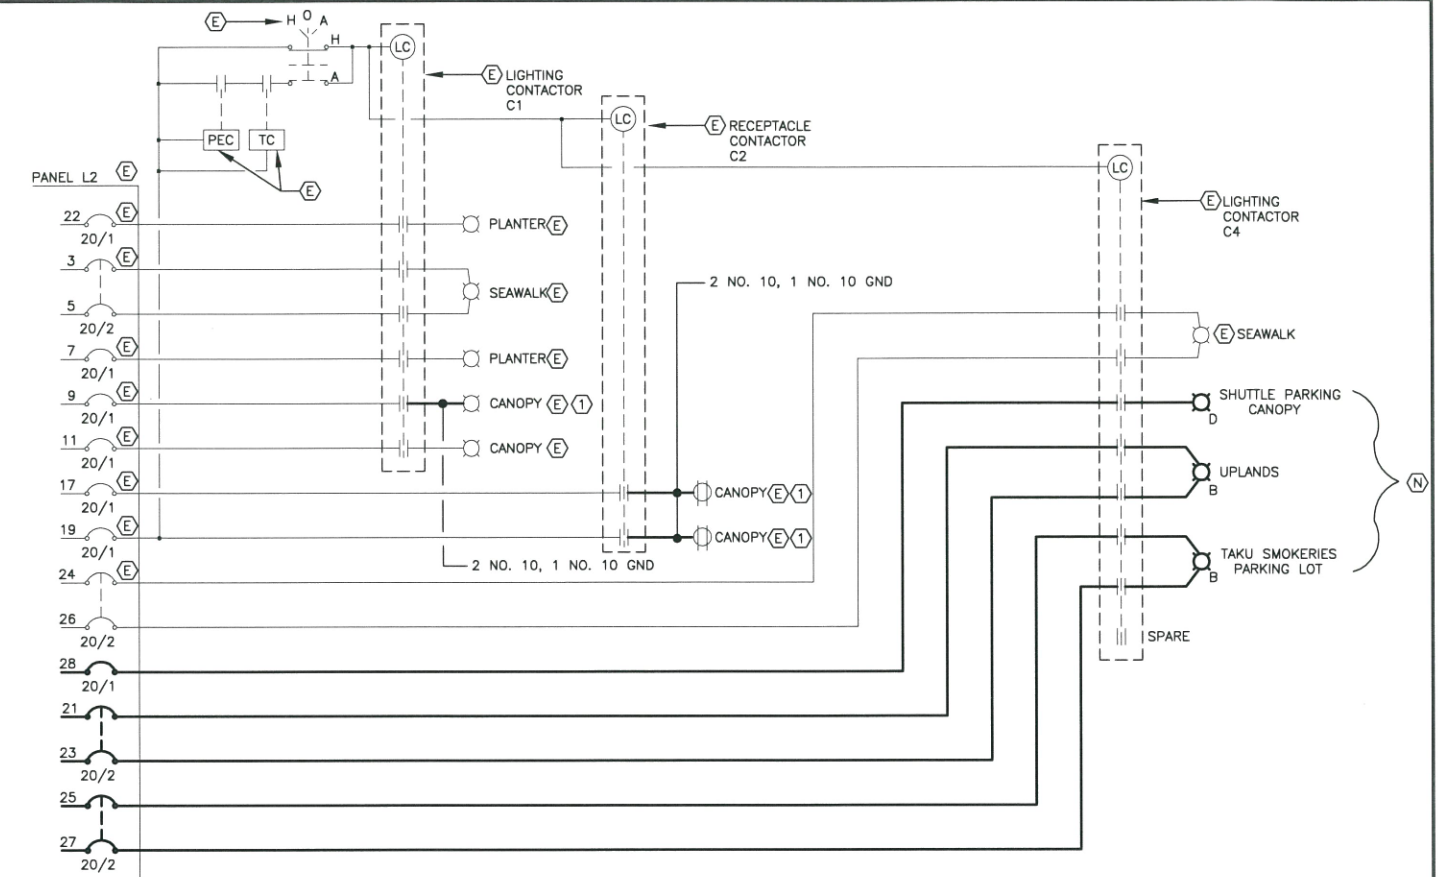

2 SCHEMATIC DIAGRAM - EXTERIOR LIGHTING CONTROLS  
NO SCALE

NOTES  
① REPLACE CIRCUITS AS REQUIRED TO ELEVATE THE CANOPY.

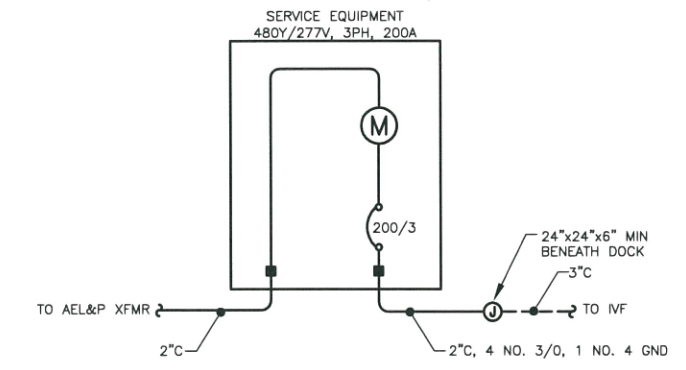

5 SINGLE LINE DIAGRAM - IVF SERVICE  
NO SCALE



| REVISIONS |      |             |      |      |      |
|-----------|------|-------------|------|------|------|
| REV.      | DATE | DESCRIPTION | DWN. | CKD. | APP. |
|           |      |             |      |      |      |
|           |      |             |      |      |      |
|           |      |             |      |      |      |
|           |      |             |      |      |      |
|           |      |             |      |      |      |
|           |      |             |      |      |      |
|           |      |             |      |      |      |



9360 Glacier Highway, Ste. 100  
Juneau, Alaska 99801  
Phone: 907-586-2093  
Fax: 907-586-2099  
www.pndengineers.com

DESIGN: BCH/KHD CHECKED: BCH  
DRAWN: KHD APPROVED: BCH

SCALE: AS NOTED



CRUISE SHIP TERMINAL STAGING AREA IMPROVEMENTS  
CONTRACT NO. DH13-017

SHEET TITLE: DETAILS  
PND PROJECT NO.: 102081 DWG. FILE:  
E5.06 SHEET 48 OF 52