


LEGEND

- ABBREVIATIONS:
- AFF ABOVE FIXED FLOOR
- UON UNLESS OTHERWISE NOTED
- JSD JUNEAU SCHOOL DISTRICT
- WP WEATHERPROOF
- (N) NEW
- (E) EXISTING TO REMAIN
- (R) RELOCATE EXISTING
- LOW VOLTAGE:
- △ WALL SPEAKER, 90° AFF, UON.
(TB = TALKBACK)
- ⊗ CEILING SPEAKER (TB = TALKBACK)

EQUIPMENT BASIS OF DESIGN LIST	
*CALL SWITCH	VALCOM V-2970
*SYSTEM CPU CARD	VALCOM V-CPU4
*TALKBACK STATION CARD	VALCOM V-TCM
ONE-WAY STATION CARD	VALCOM V-STX
*POWER SUPPLY	VALCOM V-C6124P
*19" RACK INSERT	VALCOM V-CRK
*PROGRAMMING TOOL	VALCOM V-MPT
*RIBBON CABLE	VALCOM VC40R-4
WALL TALKBACK SPEAKER	VALCOM V-1061-W
CEILING TALKBACK SPEAKER	VALCOM V-1060A

*EQUIPMENT AVAILABLE WITH VALCOM V-TR 48 PACKAGE.

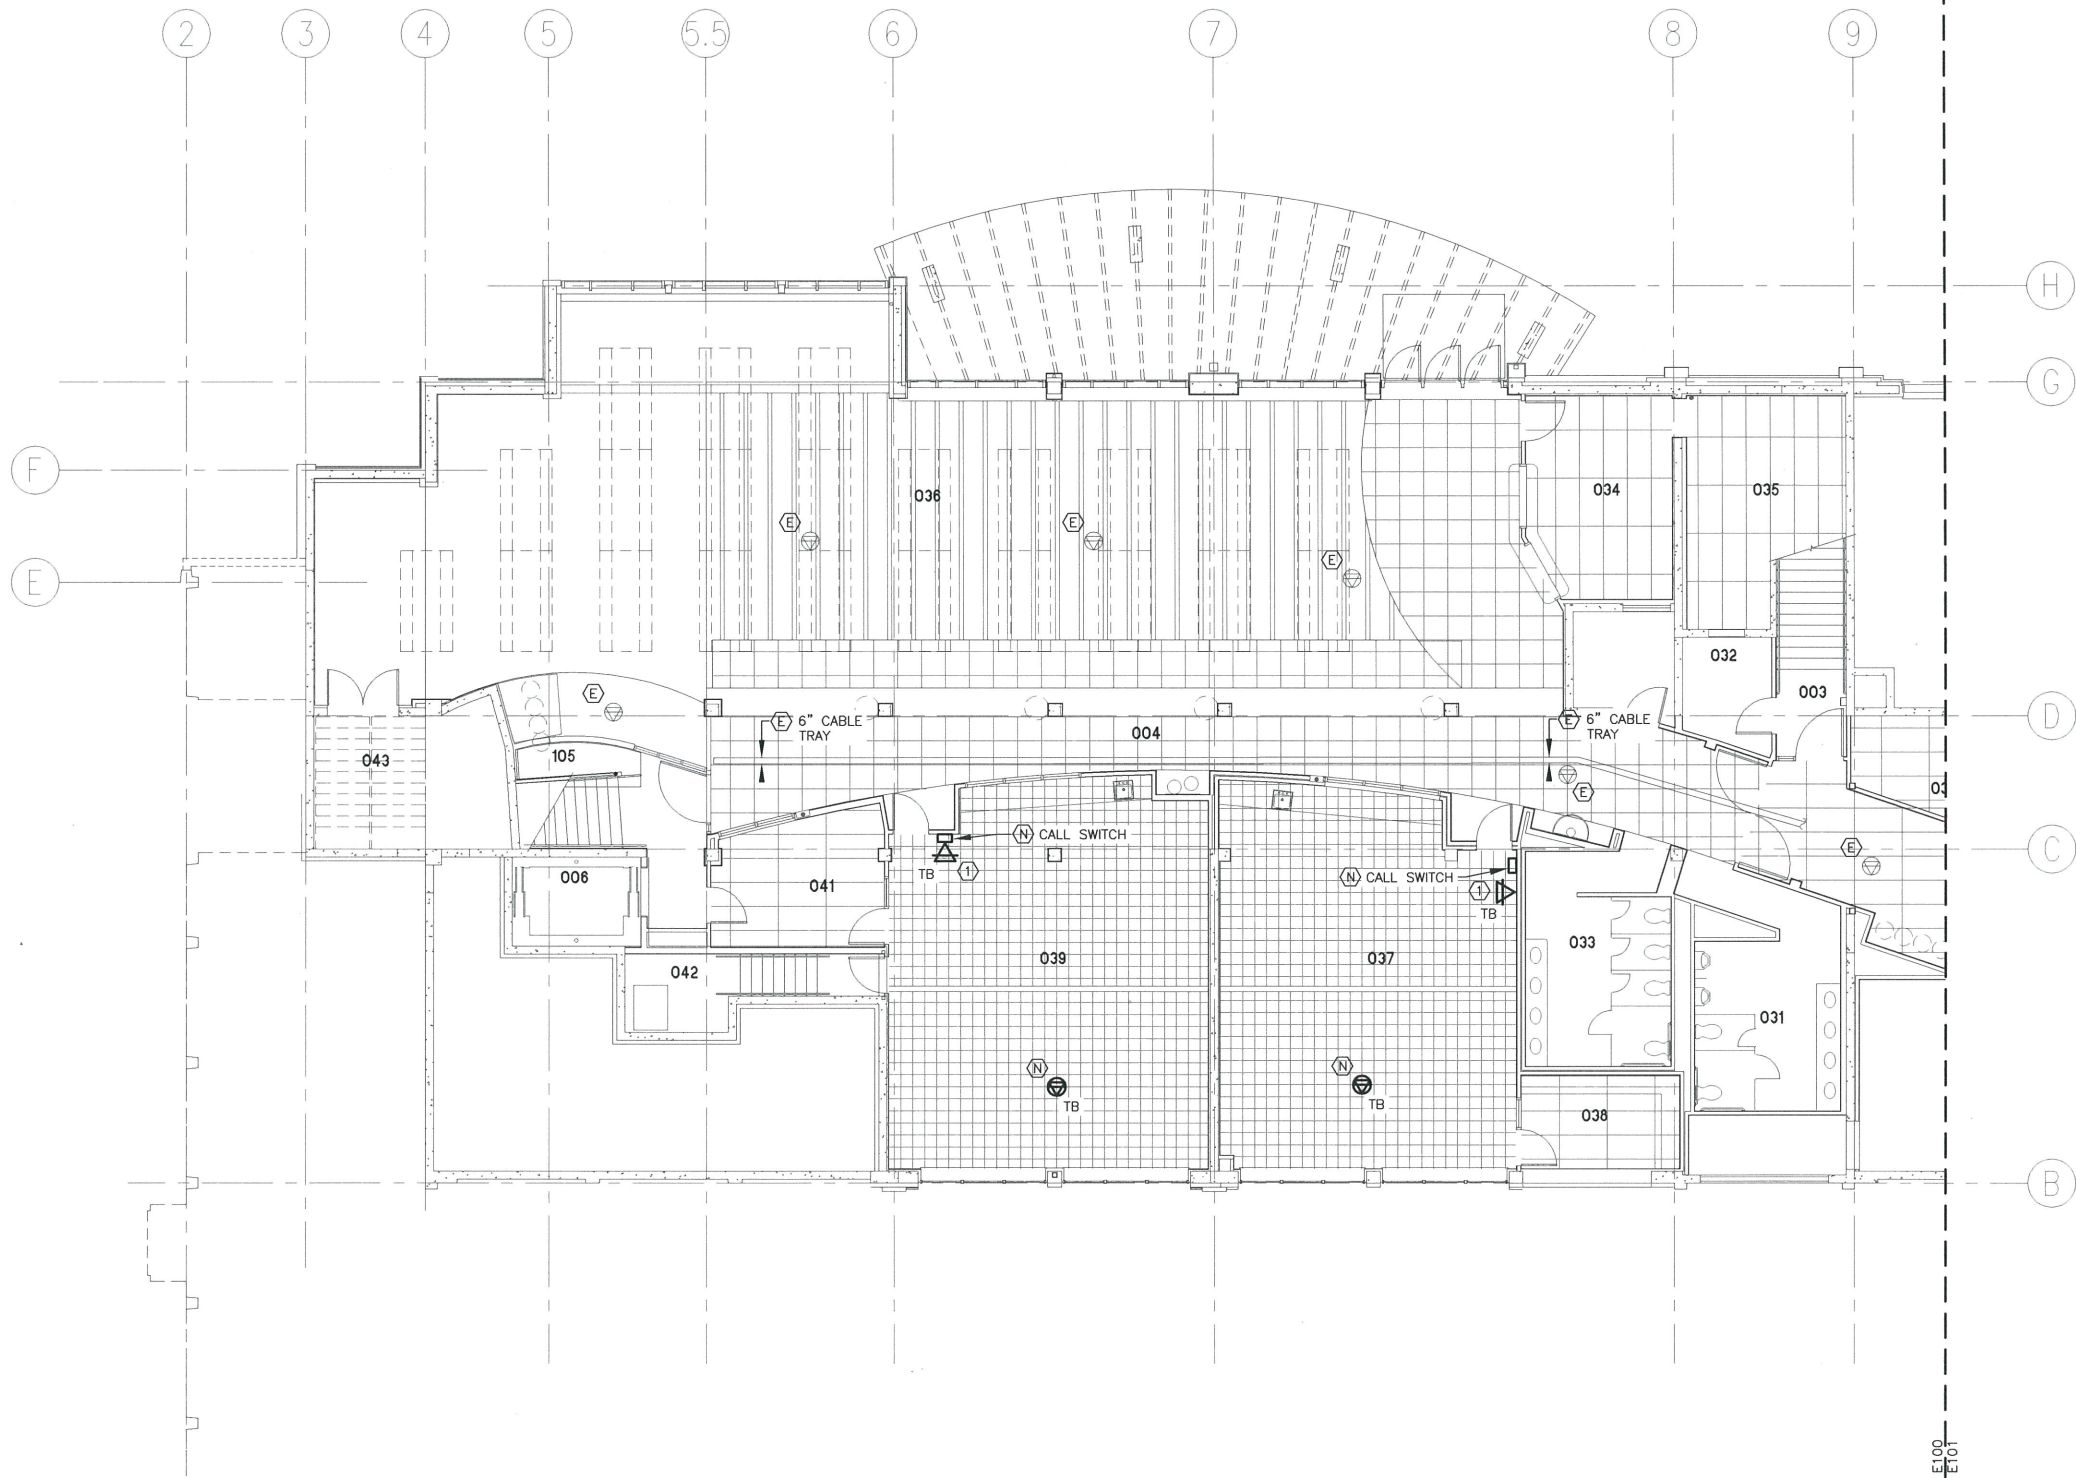


NOTES


① INDICATED EXISTING SPEAKERS TO BE REPLACED WITH NEW WALL MOUNTED TALKBACK SPEAKERS.

1 FLOOR PLAN - HARBORVIEW BASEMENT EAST

SCALE: 0' 4' 8' 16'

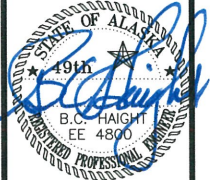

Jan 17, 2014

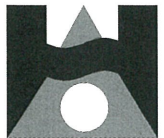

HAIGHT
& ASSOCIATES

CONSULTING
ELECTRICAL
ENGINEERS

526 Main Street
Juneau, Alaska 99801
(907) 586-9788

JSD - HARBORVIEW & GLACIER VALLEY
P/A SYSTEM REPLACEMENT
CONTRACT NO. E14-166
JUNEAU, ALASKA

FLOOR PLAN
HARBORVIEW BASEMENT
EAST


REVISION	DESCRIPTION	DATE
1	TITLE & LEGEND	12/03

SHEET NUMBER

E100


DATE: JANUARY 2014

Jan 17, 2014 - 1:21pm
F:\Projects\118_City & Borough of Juneau\139_Harborview & Glacier Valley PA_Systems\Drawings\Working\E101.dwg (Layout1 tab)

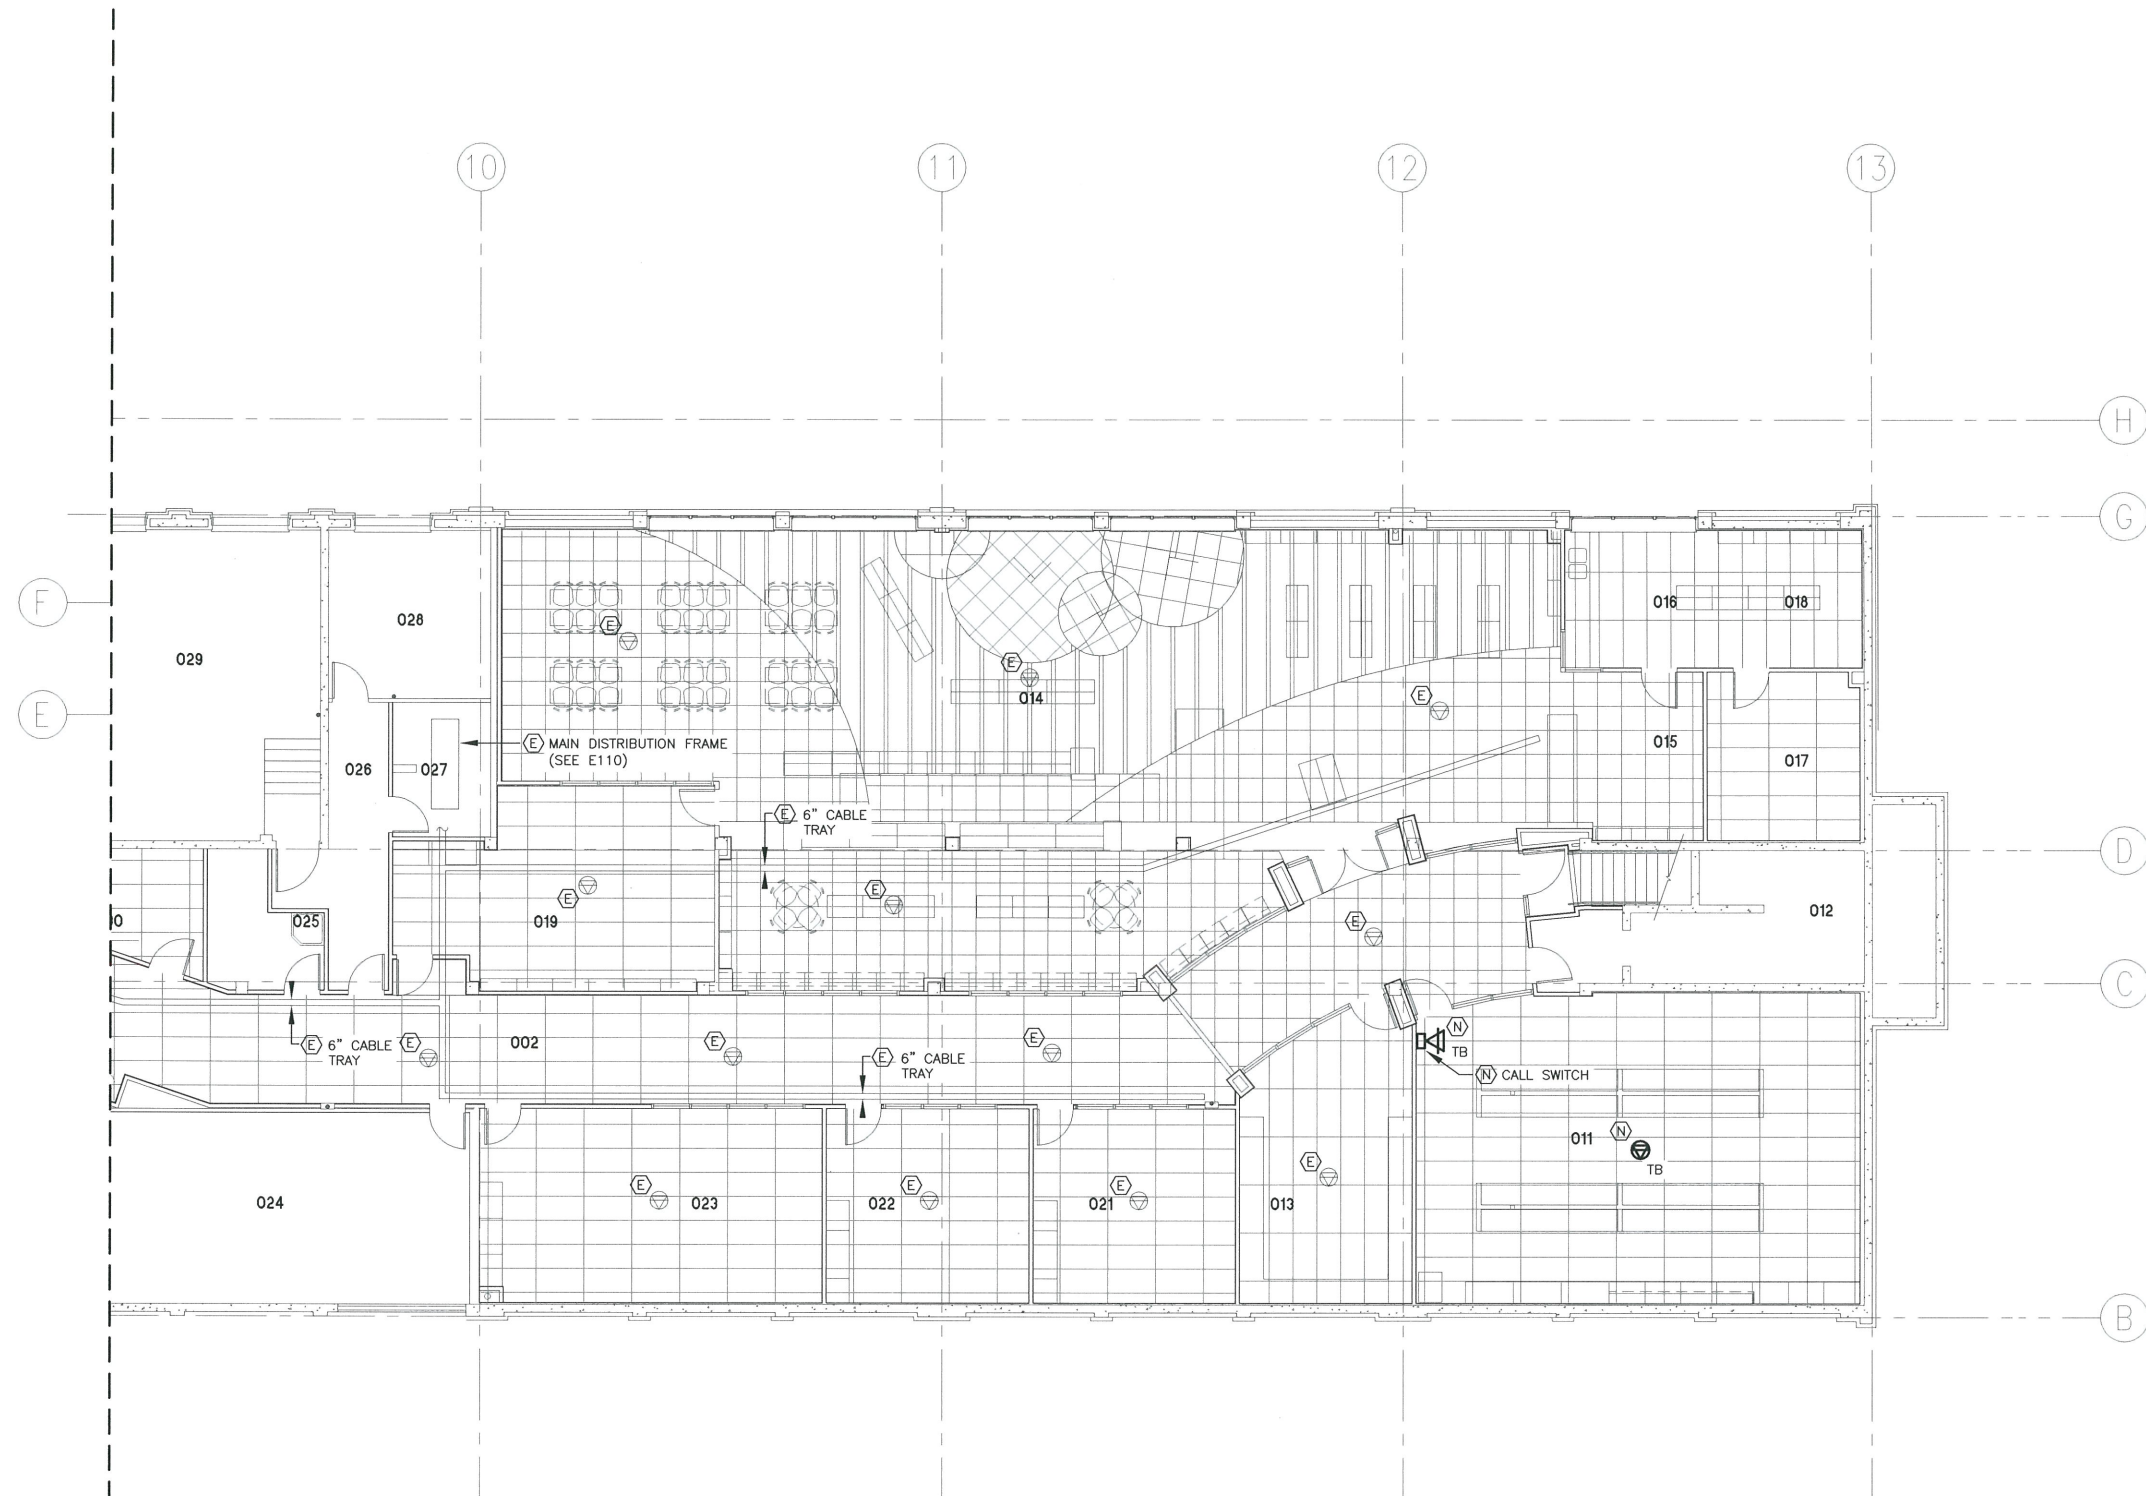

1 FLOOR PLAN - HARBORVIEW BASEMENT WEST

SCALE: 0' 4' 8' 16'

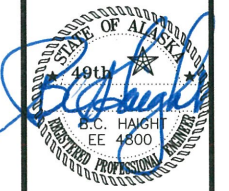

Jan 17, 2014



**HAIGHT
& ASSOCIATES**
CONSULTING
ELECTRICAL
ENGINEERS

526 Main Street
Juneau, Alaska 99801
(907) 586-9788

JSD - HARBORVIEW & GLACIER VALLEY
P/A SYSTEM REPLACEMENT
CONTRACT NO. E14-166
JUNEAU, ALASKA

FLOOR PLAN
HARBORVIEW BASEMENT
WEST

REVISION DESCRIPTION	DATE
TITLE REVISION	12/03

SHEET NUMBER

E101

DATE: JANUARY 2014



526 Main Street
uneau, Alaska 99801
(907) 586-9788

THE UNIVERSITY OF CHICAGO

P/A SYSTEM REPLACEMENT

CONTRACT NO. E14-166

JUNEAU, ALASKA

**FLOOR PLAN
HARBORVIEW
FLOOR EAST**

REVISION DESCRIPTION	DATE
TITLE REVISION	12/03
.	.
.	.
.	.
.	.

EET NUMBER

E102

TE: JANUARY 2014




① INDICATED EXISTING SPEAKERS TO BE REPLACED WITH NEW WALL MOUNTED TALKBACK SPEAKERS.

1 FLOOR PLAN - HARBORVIEW MAIN FLOOR EAST

SCALE: 0' 4' 8' 16'


Jan 17, 2014 - 1:22pm
F:\Projects\118 City & Borough of Juneau\139 Harborview & Glacier Valley PA Systems Drawings\Working\F102.dwg (Layout1 - tab)

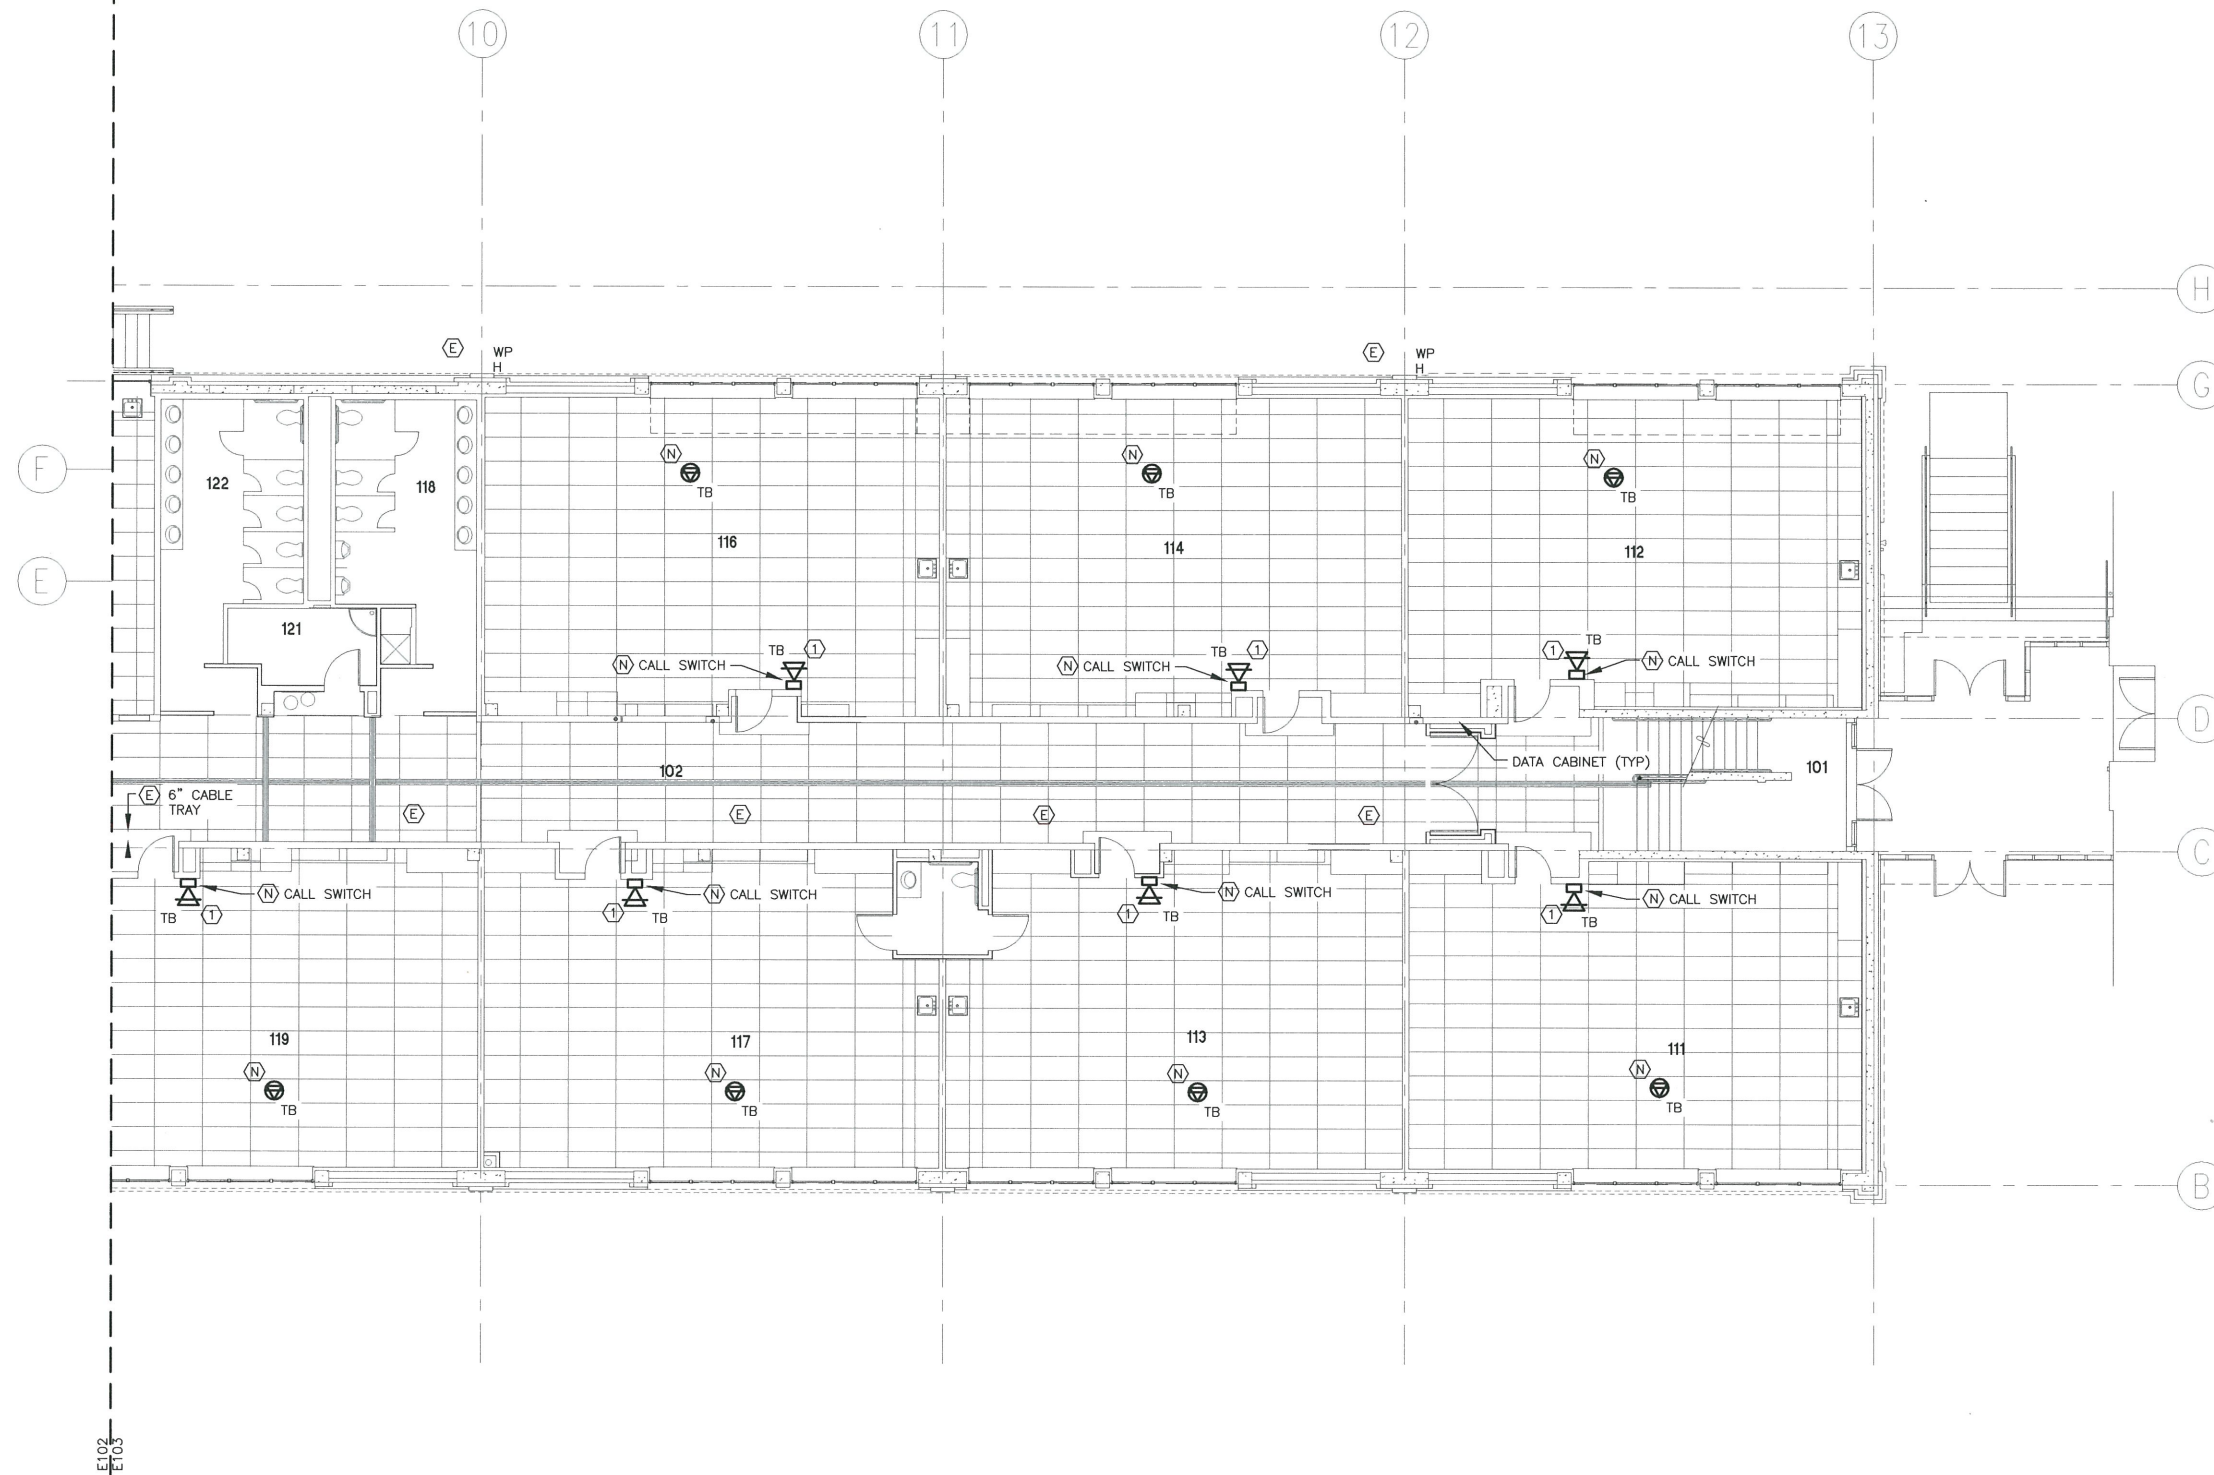


NOTES
① INDICATED EXISTING SPEAKERS TO BE REPLACED WITH NEW WALL MOUNTED TALKBACK SPEAKERS.

1 FLOOR PLAN – HARBORVIEW MAIN FLOOR WEST

SCALE: 0' 4' 8' 16'

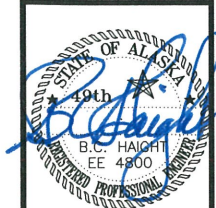

Jan 17, 2014

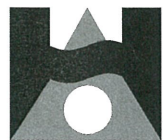

HAIGHT & ASSOCIATES
CONSULTING ELECTRICAL ENGINEERS

526 Main Street
Juneau, Alaska 99801
(907) 586-9788

JSD – HARBORVIEW & GLACIER VALLEY
P/A SYSTEM REPLACEMENT
CONTRACT NO. E14-166
JUNEAU, ALASKA

FLOOR PLAN
HARBORVIEW MAIN
FLOOR WEST


REVISION DESCRIPTION	DATE
TITLE REVISION	12/03

SHEET NUMBER

E103

DATE: JANUARY 2014

Jan 17, 2014 - 1:22pm
F:\Projects\118 City & Borough of Juneau\139 Harborview & Glacier Valley PA Systems\Drawings\Working\E104.dwg (Layout 1 tab)

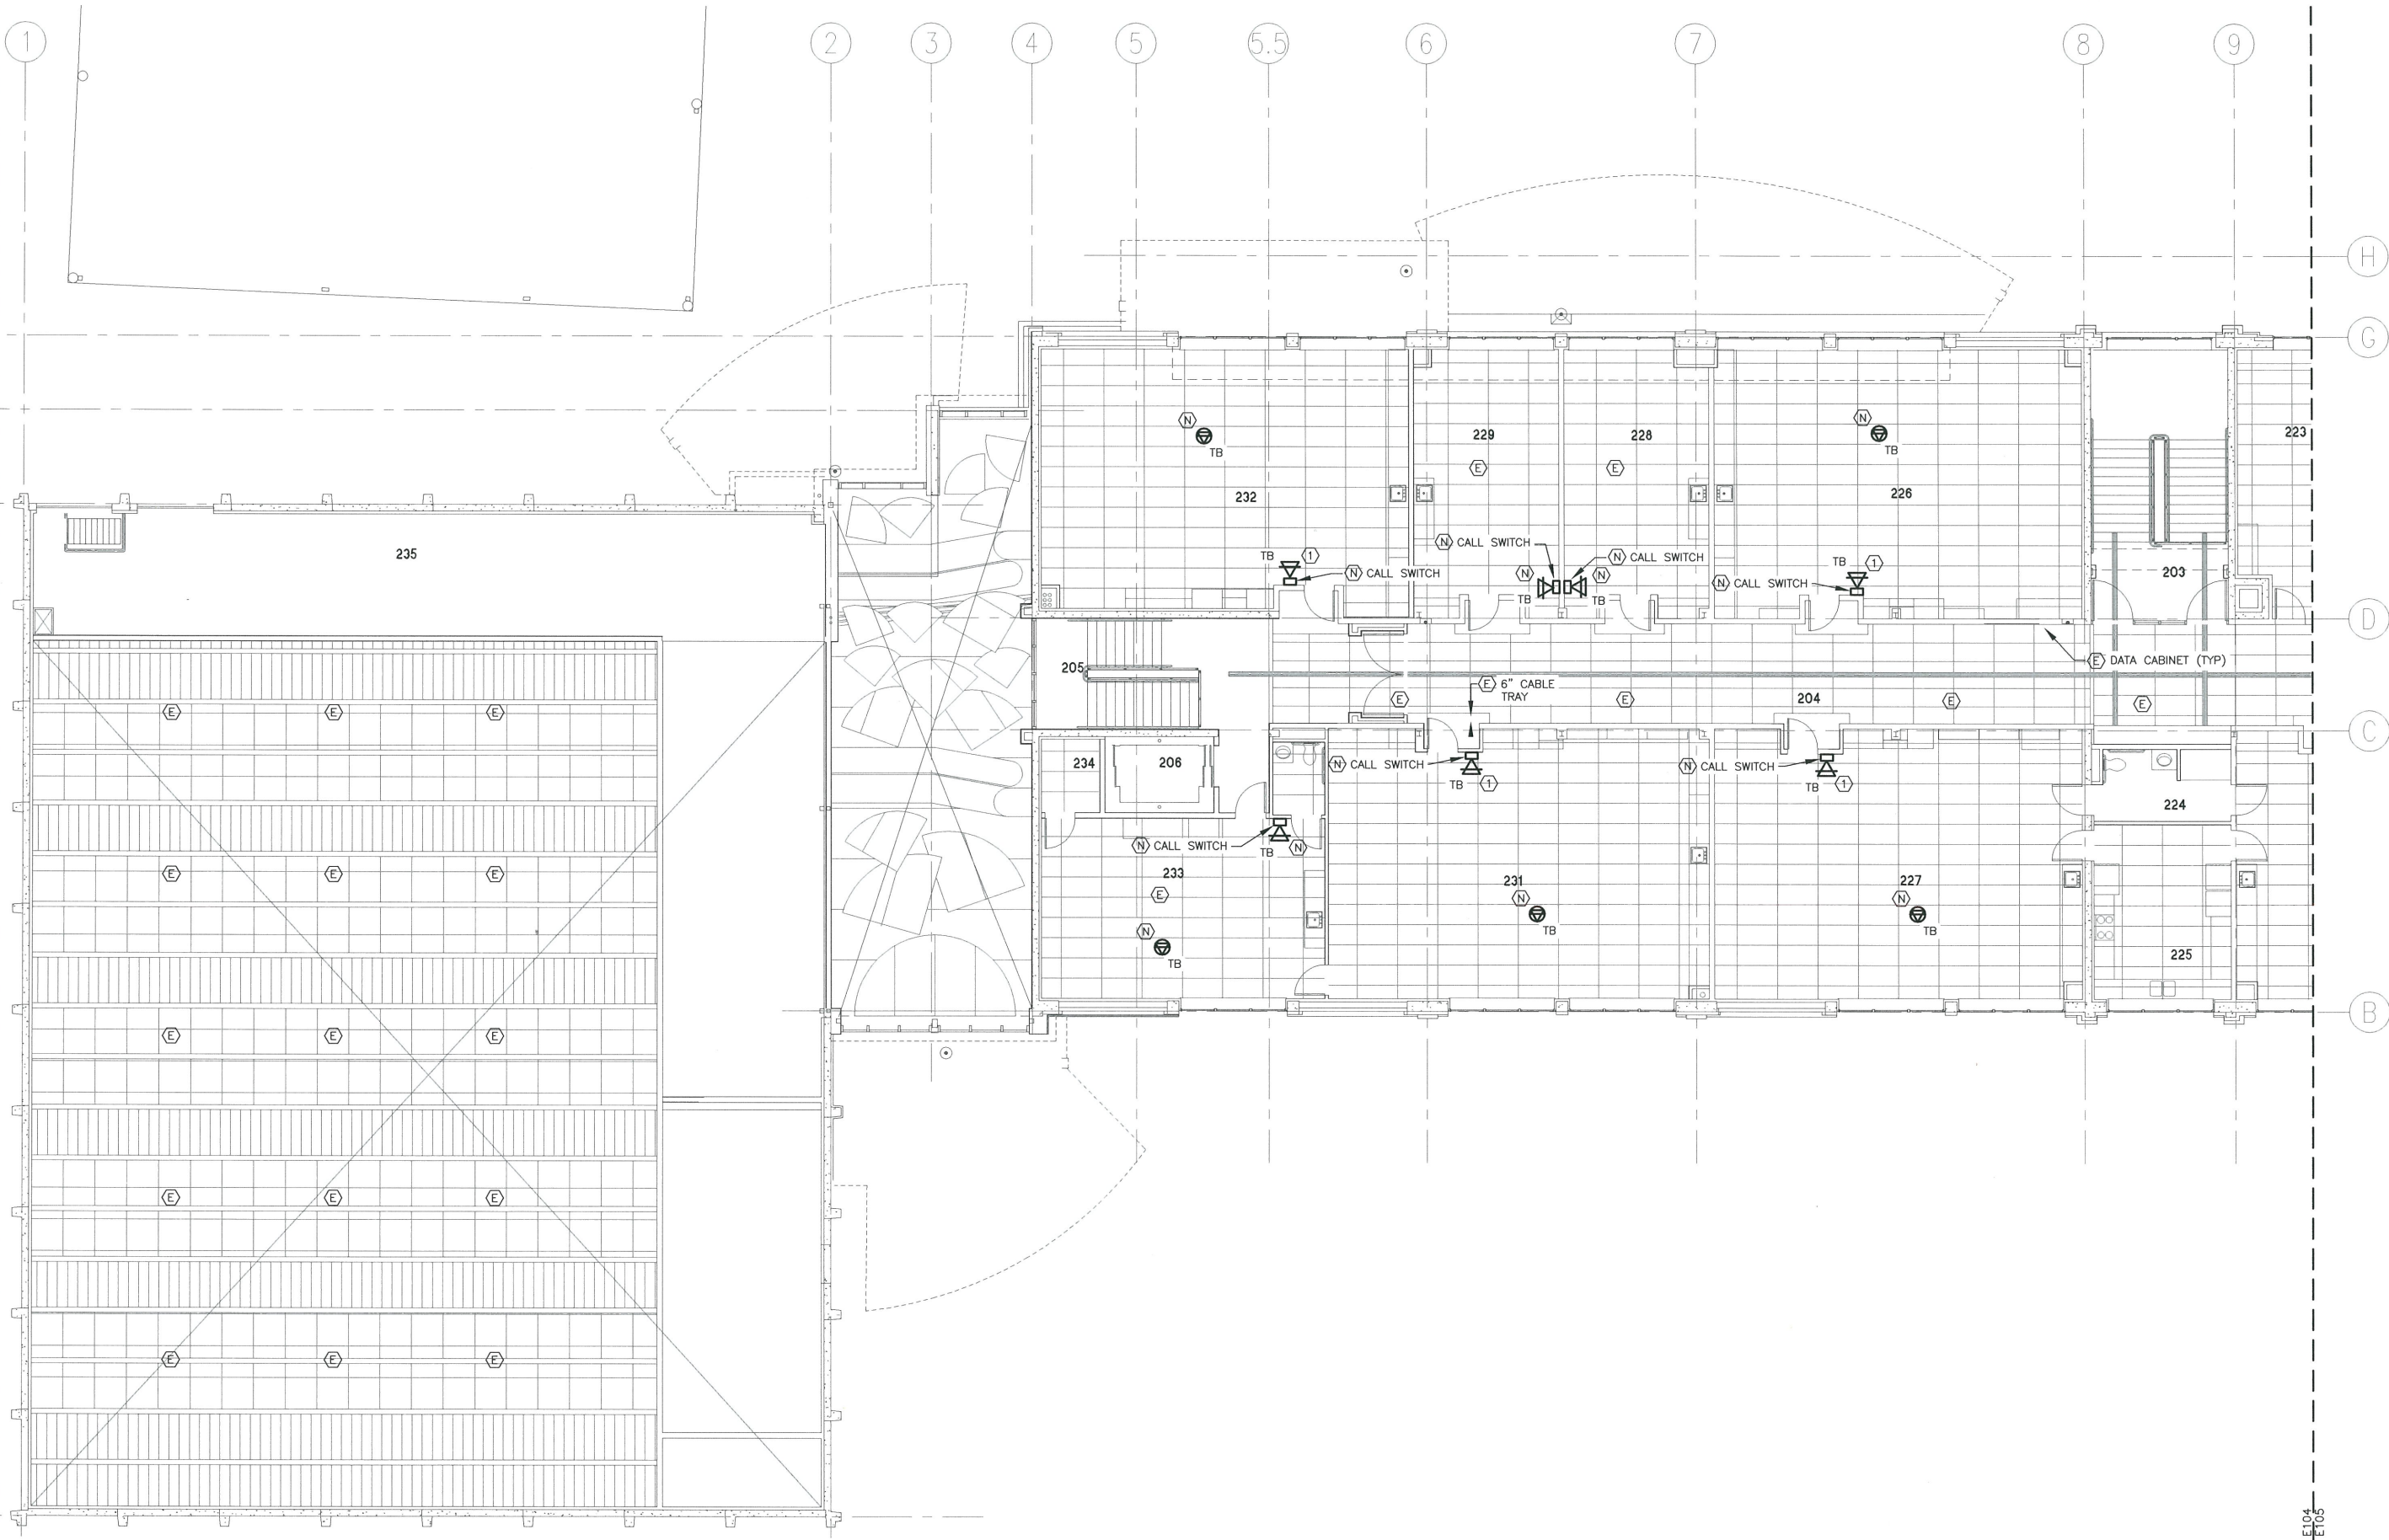


NOTES

① INDICATED EXISTING SPEAKERS TO BE REPLACED WITH NEW WALL MOUNTED TALKBACK SPEAKERS.


1

FLOOR PLAN - HARBORVIEW TOP FLOOR EAST

SCALE: 0' 4' 8' 16'

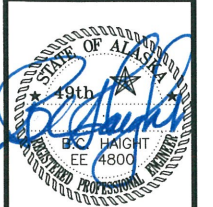

Jan 17, 2014

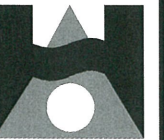

**HAIGHT
& ASSOCIATES**
CONSULTING
ELECTRICAL
ENGINEERS

526 Main Street
Juneau, Alaska 99801
(907) 586-9788

JSD - HARBORVIEW & GLACIER VALLEY

P/A SYSTEM REPLACEMENT

CONTRACT NO. E14-166
JUNEAU, ALASKA

FLOOR PLAN
HARBORVIEW TOP
FLOOR EAST
...


REVISION DESCRIPTION	DATE
TITLE REVISION	12/03

SHEET NUMBER

E104

DATE: JANUARY 2014

Jan 17, 2014 - 1:23pm
C:\Projects\118 City & Borough of Juneau\118 Harborview & Glacier Valley PA Systems\Drawings\Working\E105.dwg (Layout1.tbl)

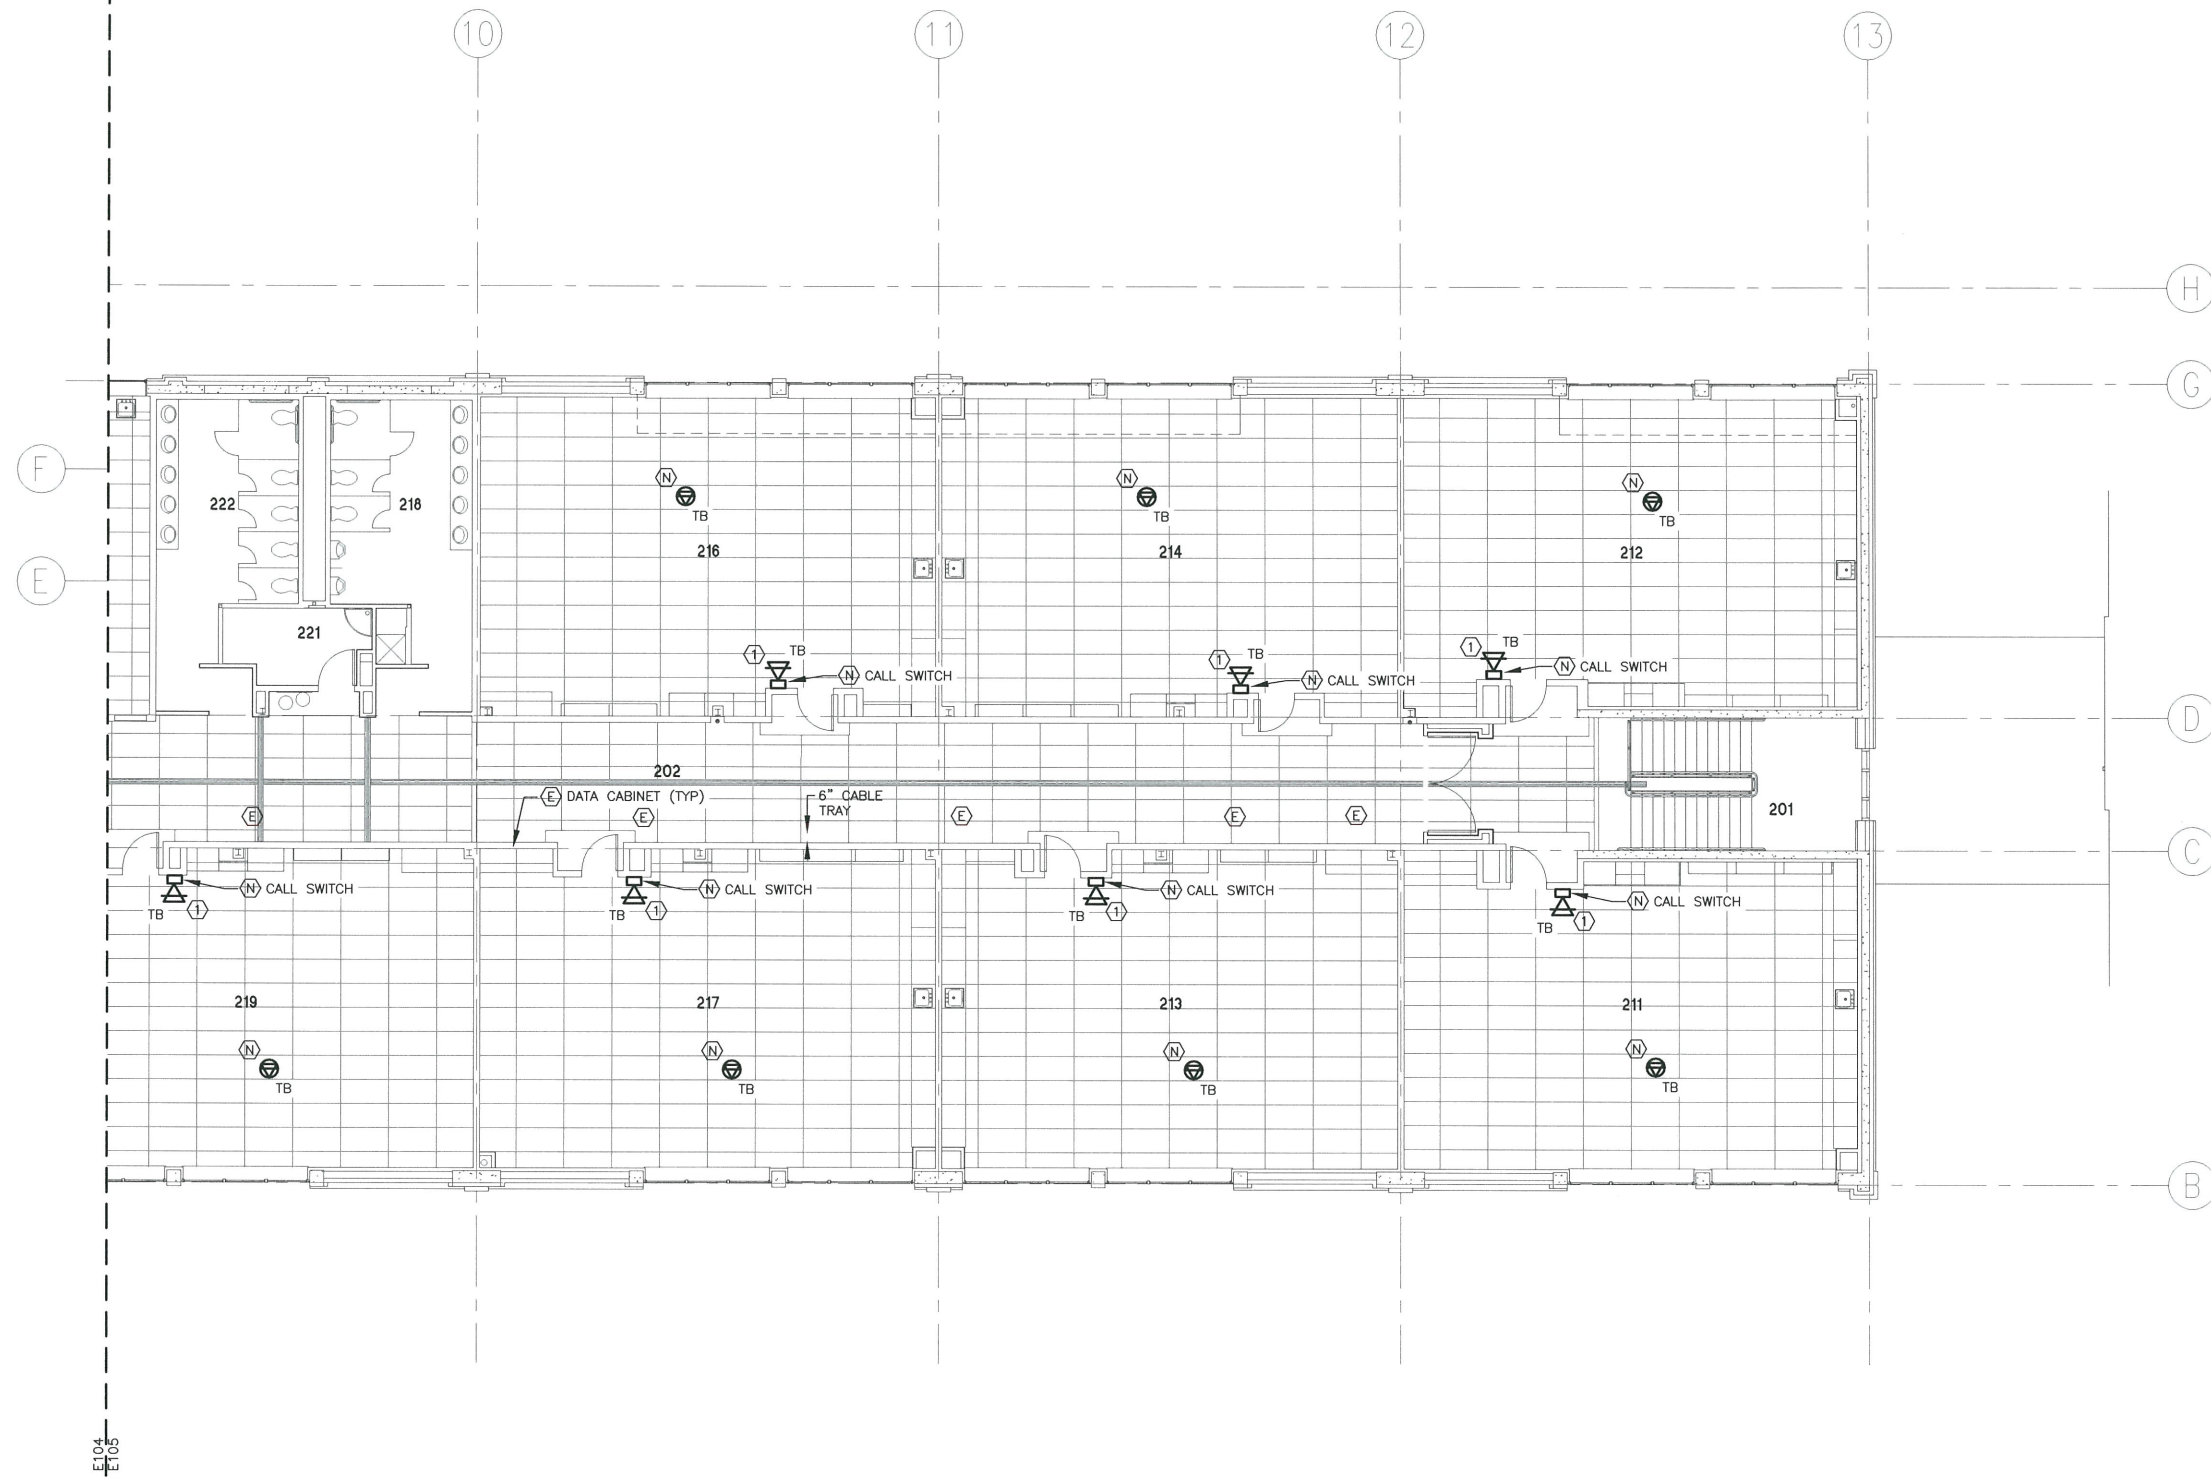


NOTES


- ① INDICATED EXISTING SPEAKERS TO BE REPLACED WITH NEW WALL MOUNTED TALKBACK SPEAKERS.

1 FLOOR PLAN - HARBORVIEW TOP FLOOR WEST

SCALE: 0' 4' 8' 16'

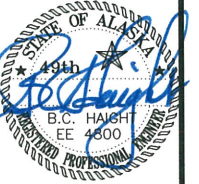

Jan 17, 2014

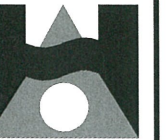

**HAIGHT
& ASSOCIATES**
CONSULTING
ELECTRICAL
ENGINEERS

526 Main Street
Juneau, Alaska 99801
(907) 586-9788

JSD - HARBORVIEW & GLACIER VALLEY

P/A SYSTEM REPLACEMENT

CONTRACT NO. E14-166

JUNEAU, ALASKA

FLOOR PLAN
HARBORVIEW TOP FLOOR
WEST

REVISION DESCRIPTION	DATE
TITLE REVISION	12/03

SHEET NUMBER

E105

DATE: JANUARY 2014