

JUNEAU INTERNATIONAL AIRPORT CONCESSIONS EXPANSION



VOLUME II OF II

Contract No. E15-195

File No. 1382.80



City & Borough of Juneau
Juneau International Airport
CONCESSIONS EXPANSION
CBJ Contract No. E15-195
Juneau, Alaska
FEBRUARY 27, 2015 BID SET

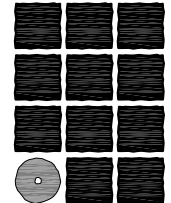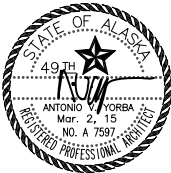ARCHITECT JENSEN YORBA LOTT, INC 522 WEST 10TH STREET JUNEAU, ALASKA 99801 (907) 586-1070 FAX (907) 586-3959	MECHANICAL ENGINEER MURRAY & ASSOCIATES, P.C. P.O. BOX 21081 JUNEAU, AK 99802 (907) 780-6151 FAX (907) 780-6182	ELECTRICAL ENGINEER HAIGHT & ASSOCIATES, INC. 526 MAIN STREET JUNEAU, ALASKA 99801 (907) 586-9788 FAX (907) 586-5774	KITCHEN LAYOUT JUNEAU AIRPORT PROJECT OFFICE 1873 SHELL SIMMONS DRIVE JUNEAU, ALASKA 99801 (907) 789-7821 FAX (907) 789-1227	
SHEET INDEX				
A001 COVER A002 ABBREVIATIONS, CODE SUMMARY, SCHEDULES & SYMBOLS A101 SITE & KEY PLAN AD201 DEMOLITION FLOOR PLAN AD601 DEMOLITION CEILING PLAN A201 FLOOR PLAN A202 FINISH PLAN A501 INTERIOR ELEVATIONS A502 INTERIOR ELEVATIONS A601 CEILING PLAN A901 DETAILS A902 DETAILS	M001 SYMBOLS & NOTES M101 DEMO PARTIAL 1ST FLOOR PIPING M102 DEMO PARTIAL 2ND FLOOR PIPING M103 DEMO PARTIAL 2ND FLOOR DUCTWORK M201 PARTIAL 1ST FLOOR PIPING M202 PARTIAL 2ND FLOOR PIPING M203 PARTIAL 2ND FLOOR DUCTWORK	ED201 PARTIAL SECOND FLOOR PLAN DEMOLITION POWER E201 PARTIAL SECOND FLOOR PLAN POWER E202 SCHEDULES ED301 PARTIAL SECOND FLOOR PLAN DEMOLITION LIGHTING E301 PARTIAL SECOND FLOOR PLAN LIGHTING ED401 PARTIAL SECOND FLOOR PLAN DEMOLITION LOW VOLTAGE E401 PARTIAL SECOND FLOOR PLAN LOW VOLTAGE	K001 EQUIPMENT LEGEND/PLAN	
 Jensen Yorba Lott Inc. 522 West 10th Street Juneau, Alaska 99801 phone 907-586-1070 fax 907-586-3959 jensenyorbalott.com FILE: 11050 A001				

CODE SUMMARY

CODE: 2009 IBC, AS AMENDED BY CBJ
CONSTRUCTION: EXISTING TYPE II-A, SPRINKLERED, EXISTING
OCCUPANCY: A-2

BAR 50 NSF @ 15/NSF = 33 OCCUP LOAD (A-2)

KITCHEN 517 GSF @ 200/GSF = 3 OCCUP LOAD (A-2)

PREVIOUS USE:
OFFICE (B) 995 GSF @ 100/GSF = 10 OCCUP LOAD

OCCUPANTS ≤50, 1 EXIT REQUIRED

NO REQUIRED OCCUPANCY SEPARATION.

PARTITION SCHEDULE

A FULL HEIGHT PARTITION

DOOR SCHEDULE

DOOR SCHEDULE									
No.	Type	Size	Mat/Fin.	Mat/Fin.	GLASS	DETAILS	HW	REMARKS	
1	A	3'-0"x7'-0"	WD/CLR	HM	PT	1/4" CLR		1 FINISHES TO MATCH EX	
2	B	3'-0"x7'-0"	WD/CLR	HM	PT	1/4" CLR		2 FINISHES TO MATCH EX	
3								EX	
4	C	3'-0"x7'-0"	WD/PT	HM	PT			4 PT DR & FRAME P3	
5		13'-4"x8'-0"						OFCI SECURITY GRILL	

NOTE: REUSE SLAVAGED EX DOORS & FRAMES WHERE POSSIBLE.

DOOR TYPES

B PARTIAL HEIGHT PARTITION

C C6 THRU CLG PARTITION

D SECURITY GRILL POCKET

ABBREVIATIONS

Z	ANGLE	EMER	EMERGENCY	LAM	LAMINATE	RH	ROBE HOOK	VEST	VESTIBULE
AC	ASPHALT CONCRETE	ENCL	ENCLOSURE	LAV	LAVATORY	RL	RAIN LEADER	VR	VAPOR RETARDER
ACM	ASBESTOS CONTAINING MATERIAL	EPDM	ETHYLENE PROPYLENE DIANE MONOMER	LB	FOUND LIGHT	RM	ROUGH OPENING	VTR	VENT THROUGH ROOF
ACP	ACOUSTICAL CEILING PANEL			LT		RO	RUBBER		
ADJ	ADJUSTABLE	EPS	EXPANDED POLYSTYRENE	MIR	MIRROR	RUB		WB	WEATHER BARRIER
AFF	ABOVE FINISH FLOOR	EQ	EQUAL EQUIPMENT	MAX	MAXIMUM	SASU	SELF ADHERING SHEET	WC	WATER CLOSET
AIB	AIR INFILTRATION BARRIER	EQP		MDO	MEDIUM DENSITY OVERLAID	WD	UNDERLAYMENT	WP	WOOD
AL	ALUMINUM	EX	EXISTING EXTERIOR	MECH	MECHANICAL	WR	SEAT COVER DISPENSER	WP	WATERPROOF
APPROX	APPROXIMATE	EXT		MEMB	MEMBRANE	WSC	SCHEDULE	WT	WASTE RECEPTACLE
ARCH	ARCHITECTURAL	FA	FIRE ALARM	MFR	MANUFACTURER	SCHED	SCHEDULE	WTC	WAINSCOT
ASB	ASBESTOS	FD	FLOOR DRAIN	MH	MANHOLE	SF	SQUARE FOOT	WT	WEIGHT
		FDN	FOUNDATION	MIN	MINIMUM	SFRM	SPRAYED FIRE-RESISTIVE MATERIAL	WWF	WELDED WIRE FABRIC
BD	BOARD	FEC	FIRE EXTINGUISHER CABINET	MISC	MISCELLANEOUS	SHR	SHOWER		
BLDG	BUILDING	FF	FINISH FLOOR	MTD	MOUNTED	SHTH	SHEATHING		
BLKG	BLOCKING	FHC	FIRE HOSE CABINET	MTL	METAL	SIM	SIMILAR		
BM	BEAM	FIN	FINISH FLASHING	MUL	MULLION	SND	SANITARY NAPKIN DISPENSER		
BOT	BOTTOM	FLR	FLOOR	NIC	NOT IN CONTRACT	SNR	SANITARY NAPKIN RECEPTACLE		
		FOC	FACE OF CONCRETE/CURB	NO OR #	NUMBER	SPEC	SPECIFICATIONS		
CAB	CABINET	FOF	FACE OF FINISH	NOM	NOMINAL	SQ	SQUARE		
CB	CATCH BASIN	FOS	FACE OF STUD	NTS	NOT TO SCALE	SQFT	SQUARE FOOT		
CEM	CEMENT	FRP	(GLASS) FIBER REINFORCED PLASTIC	OA	OVERALL	SOYD	SQUARE YARD		
CG	CORNER GUARD	FR	FIRE RETARDANT	OC	ON CENTER	STA	STATION		
CI	CAST IRON	FT	FOOT OR FEET	OD	OUTSIDE DIAMETER	STC	SOUND TRANSMISSION CLASS STANDARD		
CLG	CEILING	FTG	FOOTING	OFCI	OWNER FURNISHED CONTRACTOR INSTALLED	STD	STEEL		
COL	COLUMN	FURR	FURRING	OFI	OWNER FURNISHED CONTRACTOR INSTALLED	STL	STORAGE		
CONC	CONCRETE			OFD	OFFICE	STRUC	STRUCTURAL		
CONT	CONTINUOUS			OFF	OFFICE	SS	STAINLESS STEEL		
CTR	CENTER			OPP	OPPOSITE	SUSP	SUSPENDED		
CTSK	COUNTERSUNK			OSB	ORIENTED STRAND BOARD	SY	SQUARE YARD		
		GA	GAUGE						
DBL	DOUBLE	GALV	GALVANIZED						
DEPT	DEPARTMENT	GB	GRAB BAR						
DF	DRINKING FOUNTAIN	GL	GLASS						
DET	DETAIL	GW	GYP						
DIA	DIAMETER	GYP	GYP						
DIM	DIMENSION								
DISP	DISPENSER	HB	HOSE BIBB						
DN	DOWN	HOWD	HOLLOW METAL						
DR	DOOR	HM	HORIZONTAL						
DS	DOWNSPOUT	HORIZ							
DWG	DRAWING	HR	HOUR						
DWR	DRAWER	HT	HEIGHT						
		HW	HOT WATER						
EA	EACH	ID	INSIDE DIAMETER						
EF	EXHAUST FAN	INT	INSULATION INTERIOR						
EFIS	EXTERIOR INSULATION & FINISH SYSTEM								
EJ	EXPANSION JOINT	JAN	JANITOR						
EL	ELEVATION	JT	JOINT						
ELEC	ELECTRICAL	LAB	LABORATORY						
ELEV	ELEVATOR								

SYMBOLS

BUILDING SECTION XX SECTION NUMBER SHEET NUMBER

EXTERIOR ELEVATION XX ELEVATION NUMBER SHEET NUMBER

WALL SECTION XX SECTION NUMBER SHEET NUMBER

DETAIL REFERENCE XX DETAIL NUMBER SHEET NUMBER

COLUMN GRID LINE A GRID NUMBER

INTERIOR ELEVATION A000 ELEVATION NUMBER SHEET NUMBER

PARTITION OR WALL TYPE XX PARTITION OR WALL TYPE

FINISH TYPE XX FINISH NAME

DOOR TYPE XX DOOR TYPE NUMBER

KEY NOTE XX KEY NOTE NUMBER

DEMO KEY SYM XX DEMO NOTE NUMBER

EQUIPMENT SYM XX EQUIPMENT NOTE NUMBER

REV SYM XX REVISION NOTE NUMBER

ROOM TITLE ROOM NAME 1 ROOM NAME 2 ROOM NUMBER

DOOR NUMBER (WHERE INDICATED) EXISTING RELITE/WINDOW

RATED WALL 1 HOUR 2 HOUR

DOOR TO REMOVE RELITE/WINDOW TO REMOVE

WALL TO REMOVE

DATUM

ASBESTOS DOCUMENT # ACM 007 SAMPLE #

City & Borough of Juneau
Juneau International Airport
CONCESSIONS EXPANSION
CBJ Contract No. E15-195
Juneau, Alaska

BID

REVISIONS




△ .
△ .
△ .

SHEET TITLE

ABBREVIATIONS,
CODE SUMMARY,
SCHEDULES &
SYMBOLS

DATE: February 27, 2015
FILE: 11050

A002

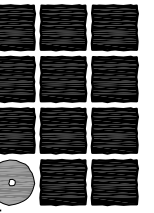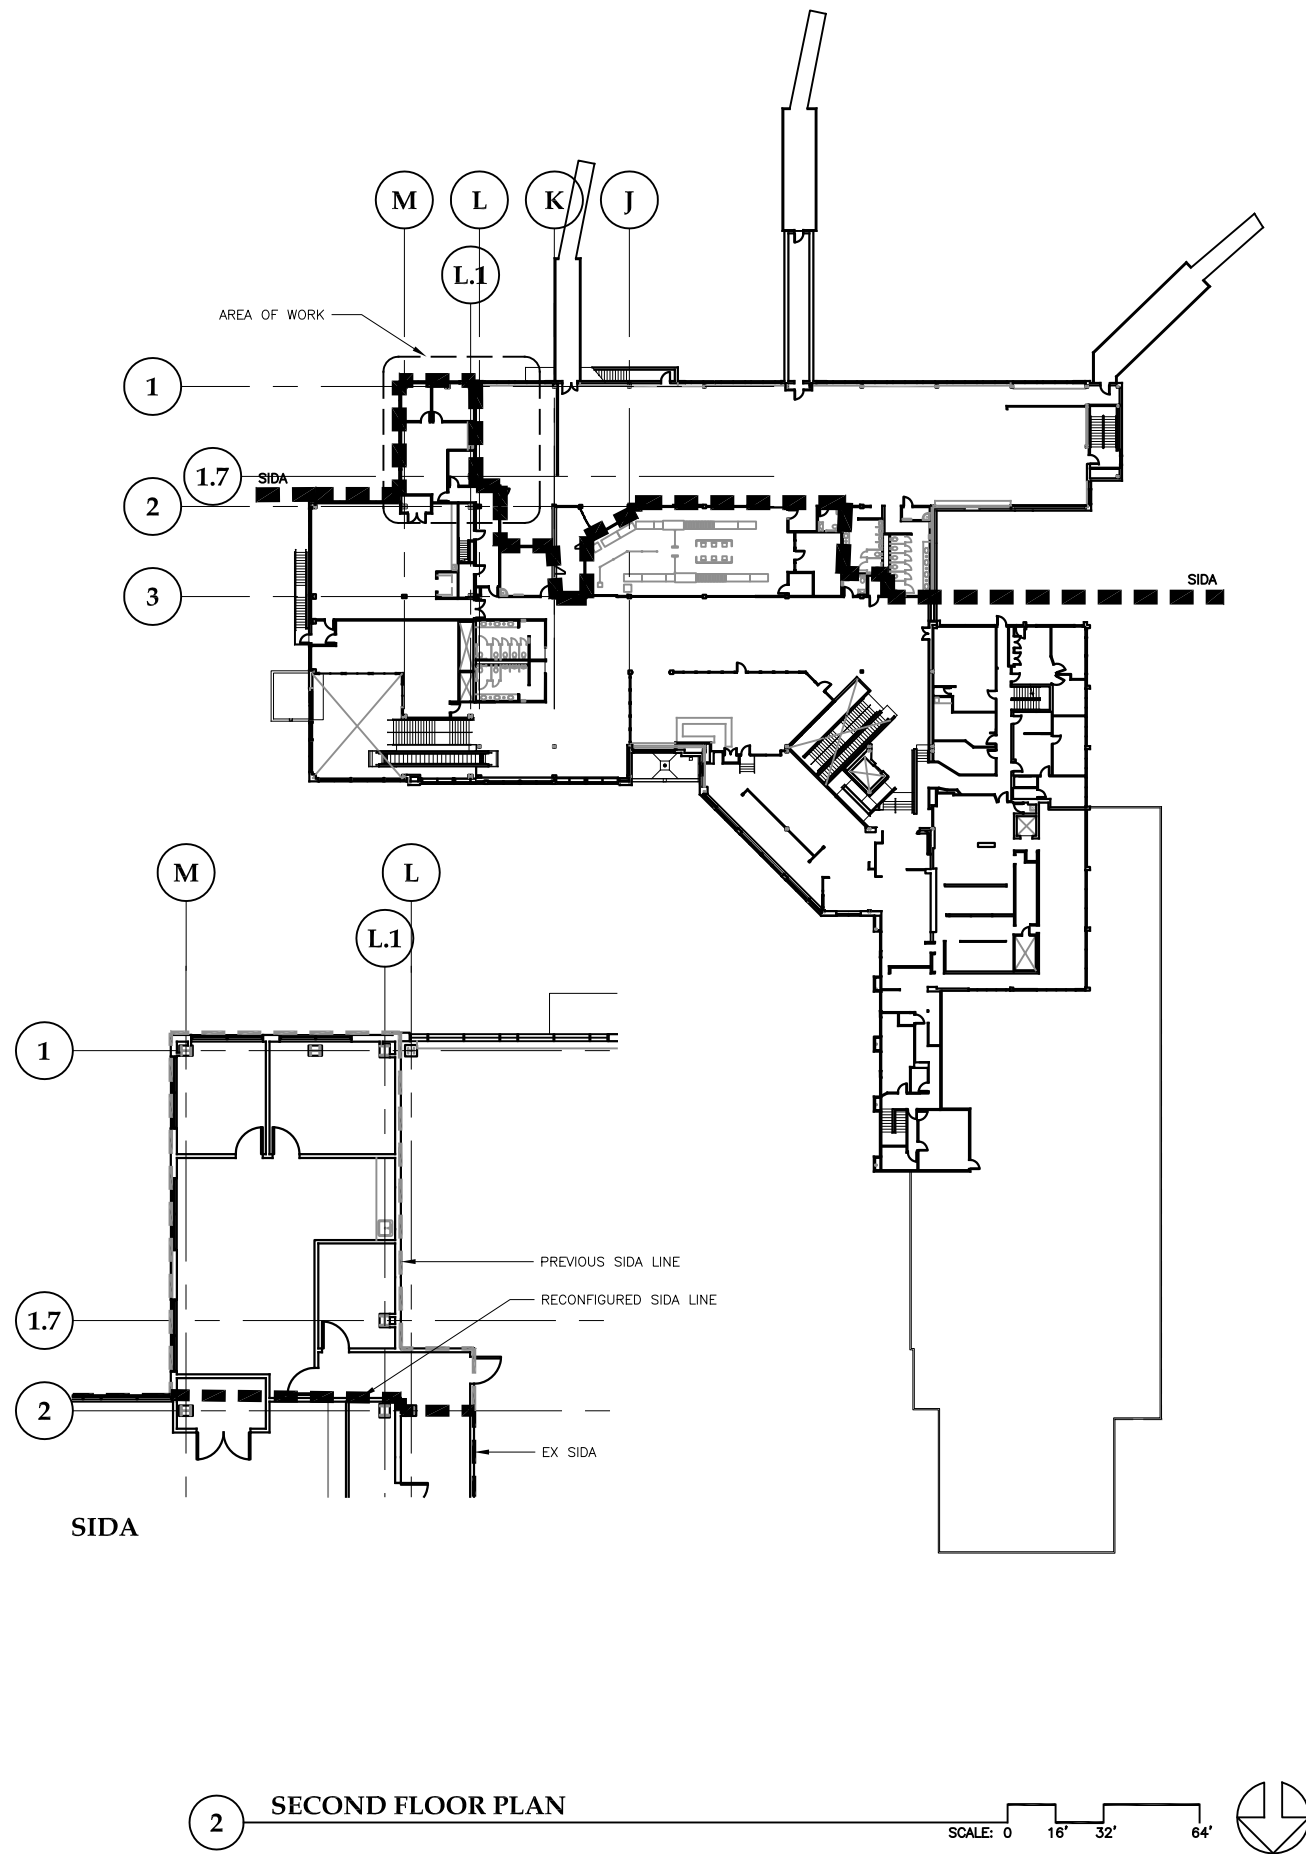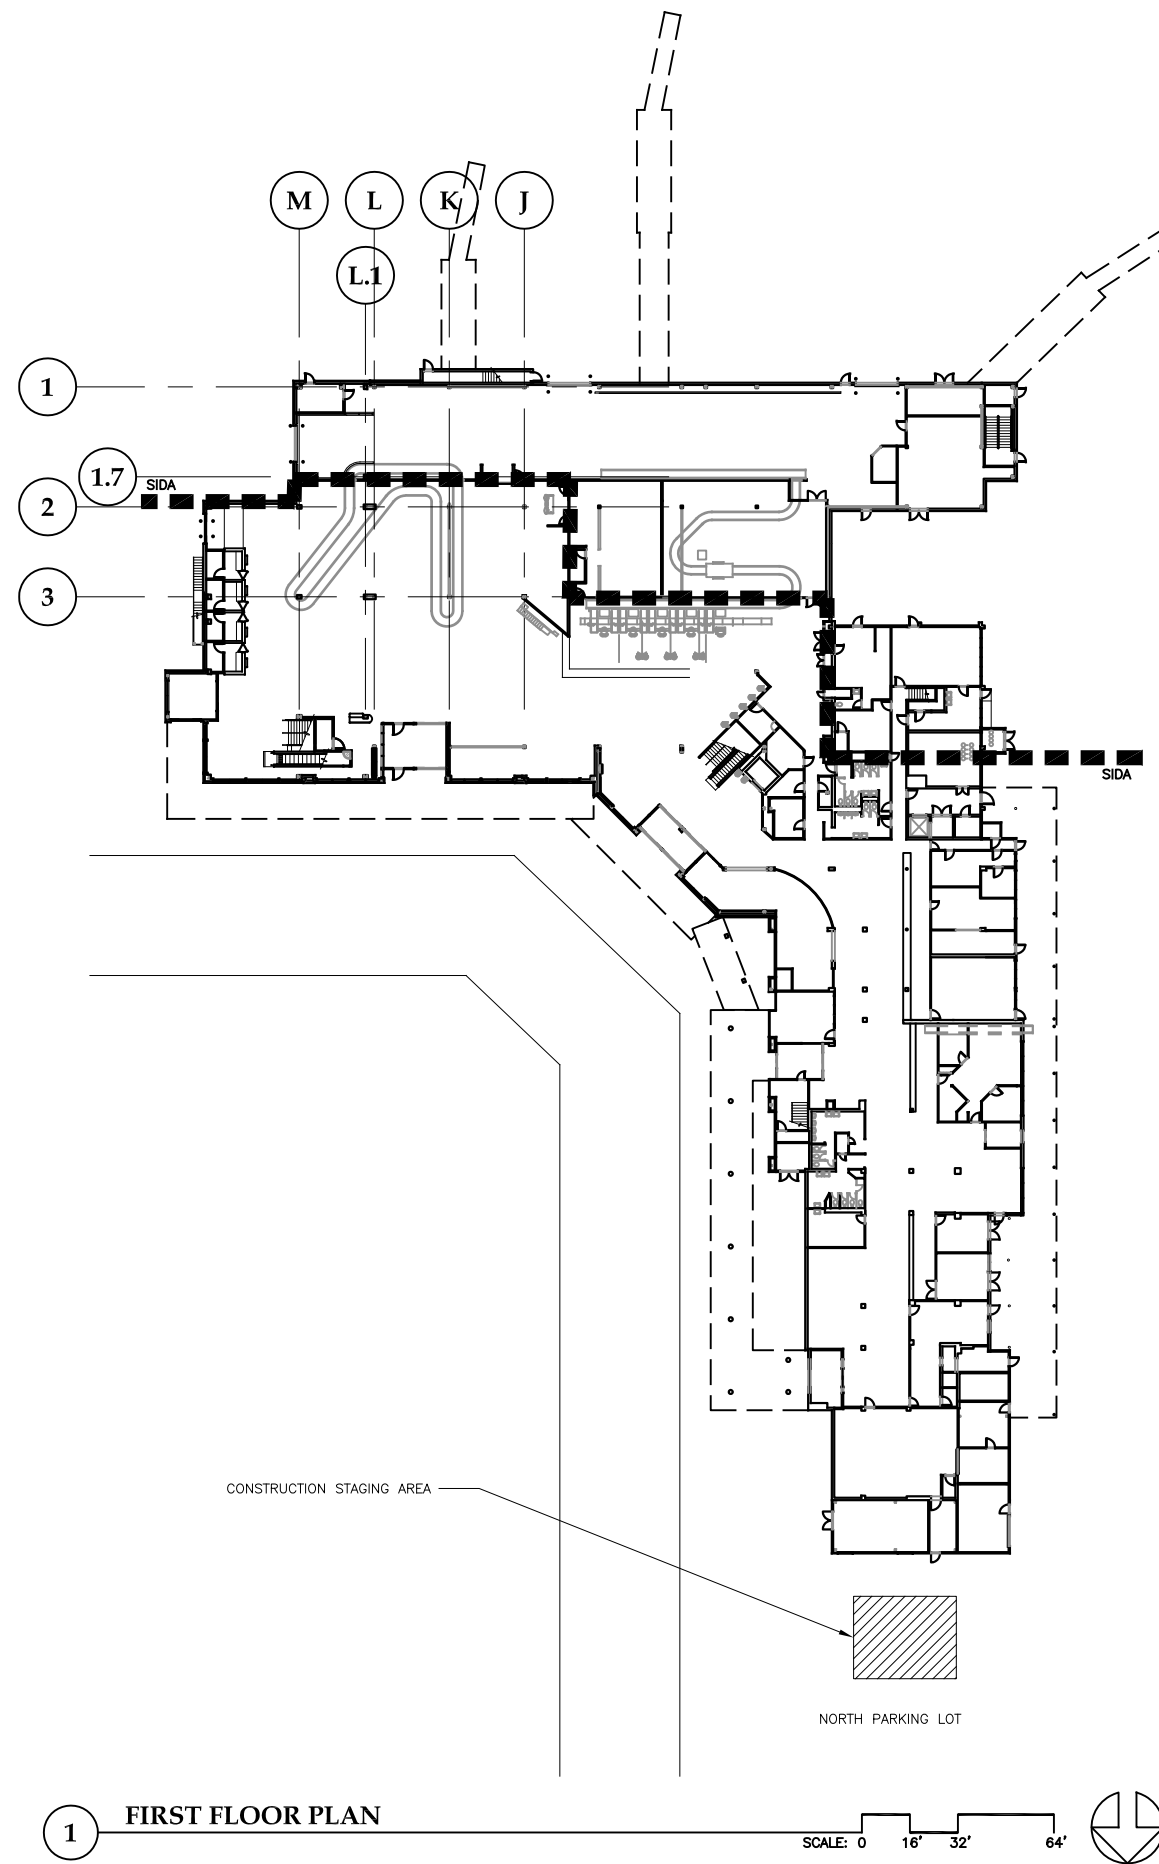

**Jensen
Yorba
Lott
Inc.**

522 West 10th Street
Juneau, Alaska 99801
phone 907-586-1070
fax 907-586-3959
jensenyorbalott.com



**City & Borough of Juneau
Juneau International Airport
CONCESSIONS EXPANSION
CBJ Contract No. E15-195
Juneau, Alaska**

BID

REVISIONS
△
△
△

SHEET TITLE
**SITE &
KEY PLAN**

DATE: February 27, 2015
FILE: 11050



A101

DEMOLITION GENERAL NOTES

- 1. SEE ELECTRICAL & MECHANICAL FOR FURTHER INFORMATION.
- 2. EX FINISHES @ WALLS TO REMAIN AND BE PATCHED AS NECESSARY.
- 3. PROTECT EX FINISHES TO REMAIN DURING WORK.
- 4. THE FOLLOWING WILL BE DEMOLISHED BY OWNER, VERIFY: PARTITIONS W/IN EX OFFICES, SALVAGABLE CEILING TILE AND GRID, CARPET, SINK AND CASEWORK W/IN EX OFFICES, LOW VOLTAGE CONTROLS, AND ELECTRICAL SWITCH AND OUTLET BOXES.

DEMOLITION KEY NOTES

- 1 EX CLG GRID AND TILES TO REMAIN
- 2 REMOVE EX CLG GRID & TILES WHERE WALLS ARE DEMOLISHED, PREPARE FOR PATCHING OF CLG
- 3 REMOVE EX CLG GRID & TILES – SALVAGE TILES FOR REUSE WHERE APPLICABLE
- 4 EX CLG GRID TO REMAIN, REMOVE CLG TILES AND SALVAGE FOR REUSE
- 5 EX WOOD CLG SYSTEM TO REMAIN
- 6 REMOVE EX WALL, DOOR & FRAME COMPLETE TO DECK – SALVAGE DOORS & FRAMES FOR REUSE, TURN OVER SURPLUS TO OWNER.
- 7 REMOVE EX WALL FOR DOOR OR SECURITY GRILL– VERIFY DIMENSIONS
- 8 REMOVE EX CASEWORK, COUNTER & SINK – SALVAGE & TURN OVER TO OWNER
- 9 REMOVE EX FLR – SALVAGE CPT TILES & TURN OVER TO OWNER
- 10 NOT USED
- 11 EX FLR TO REMAIN

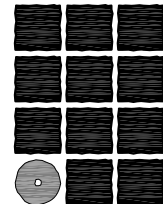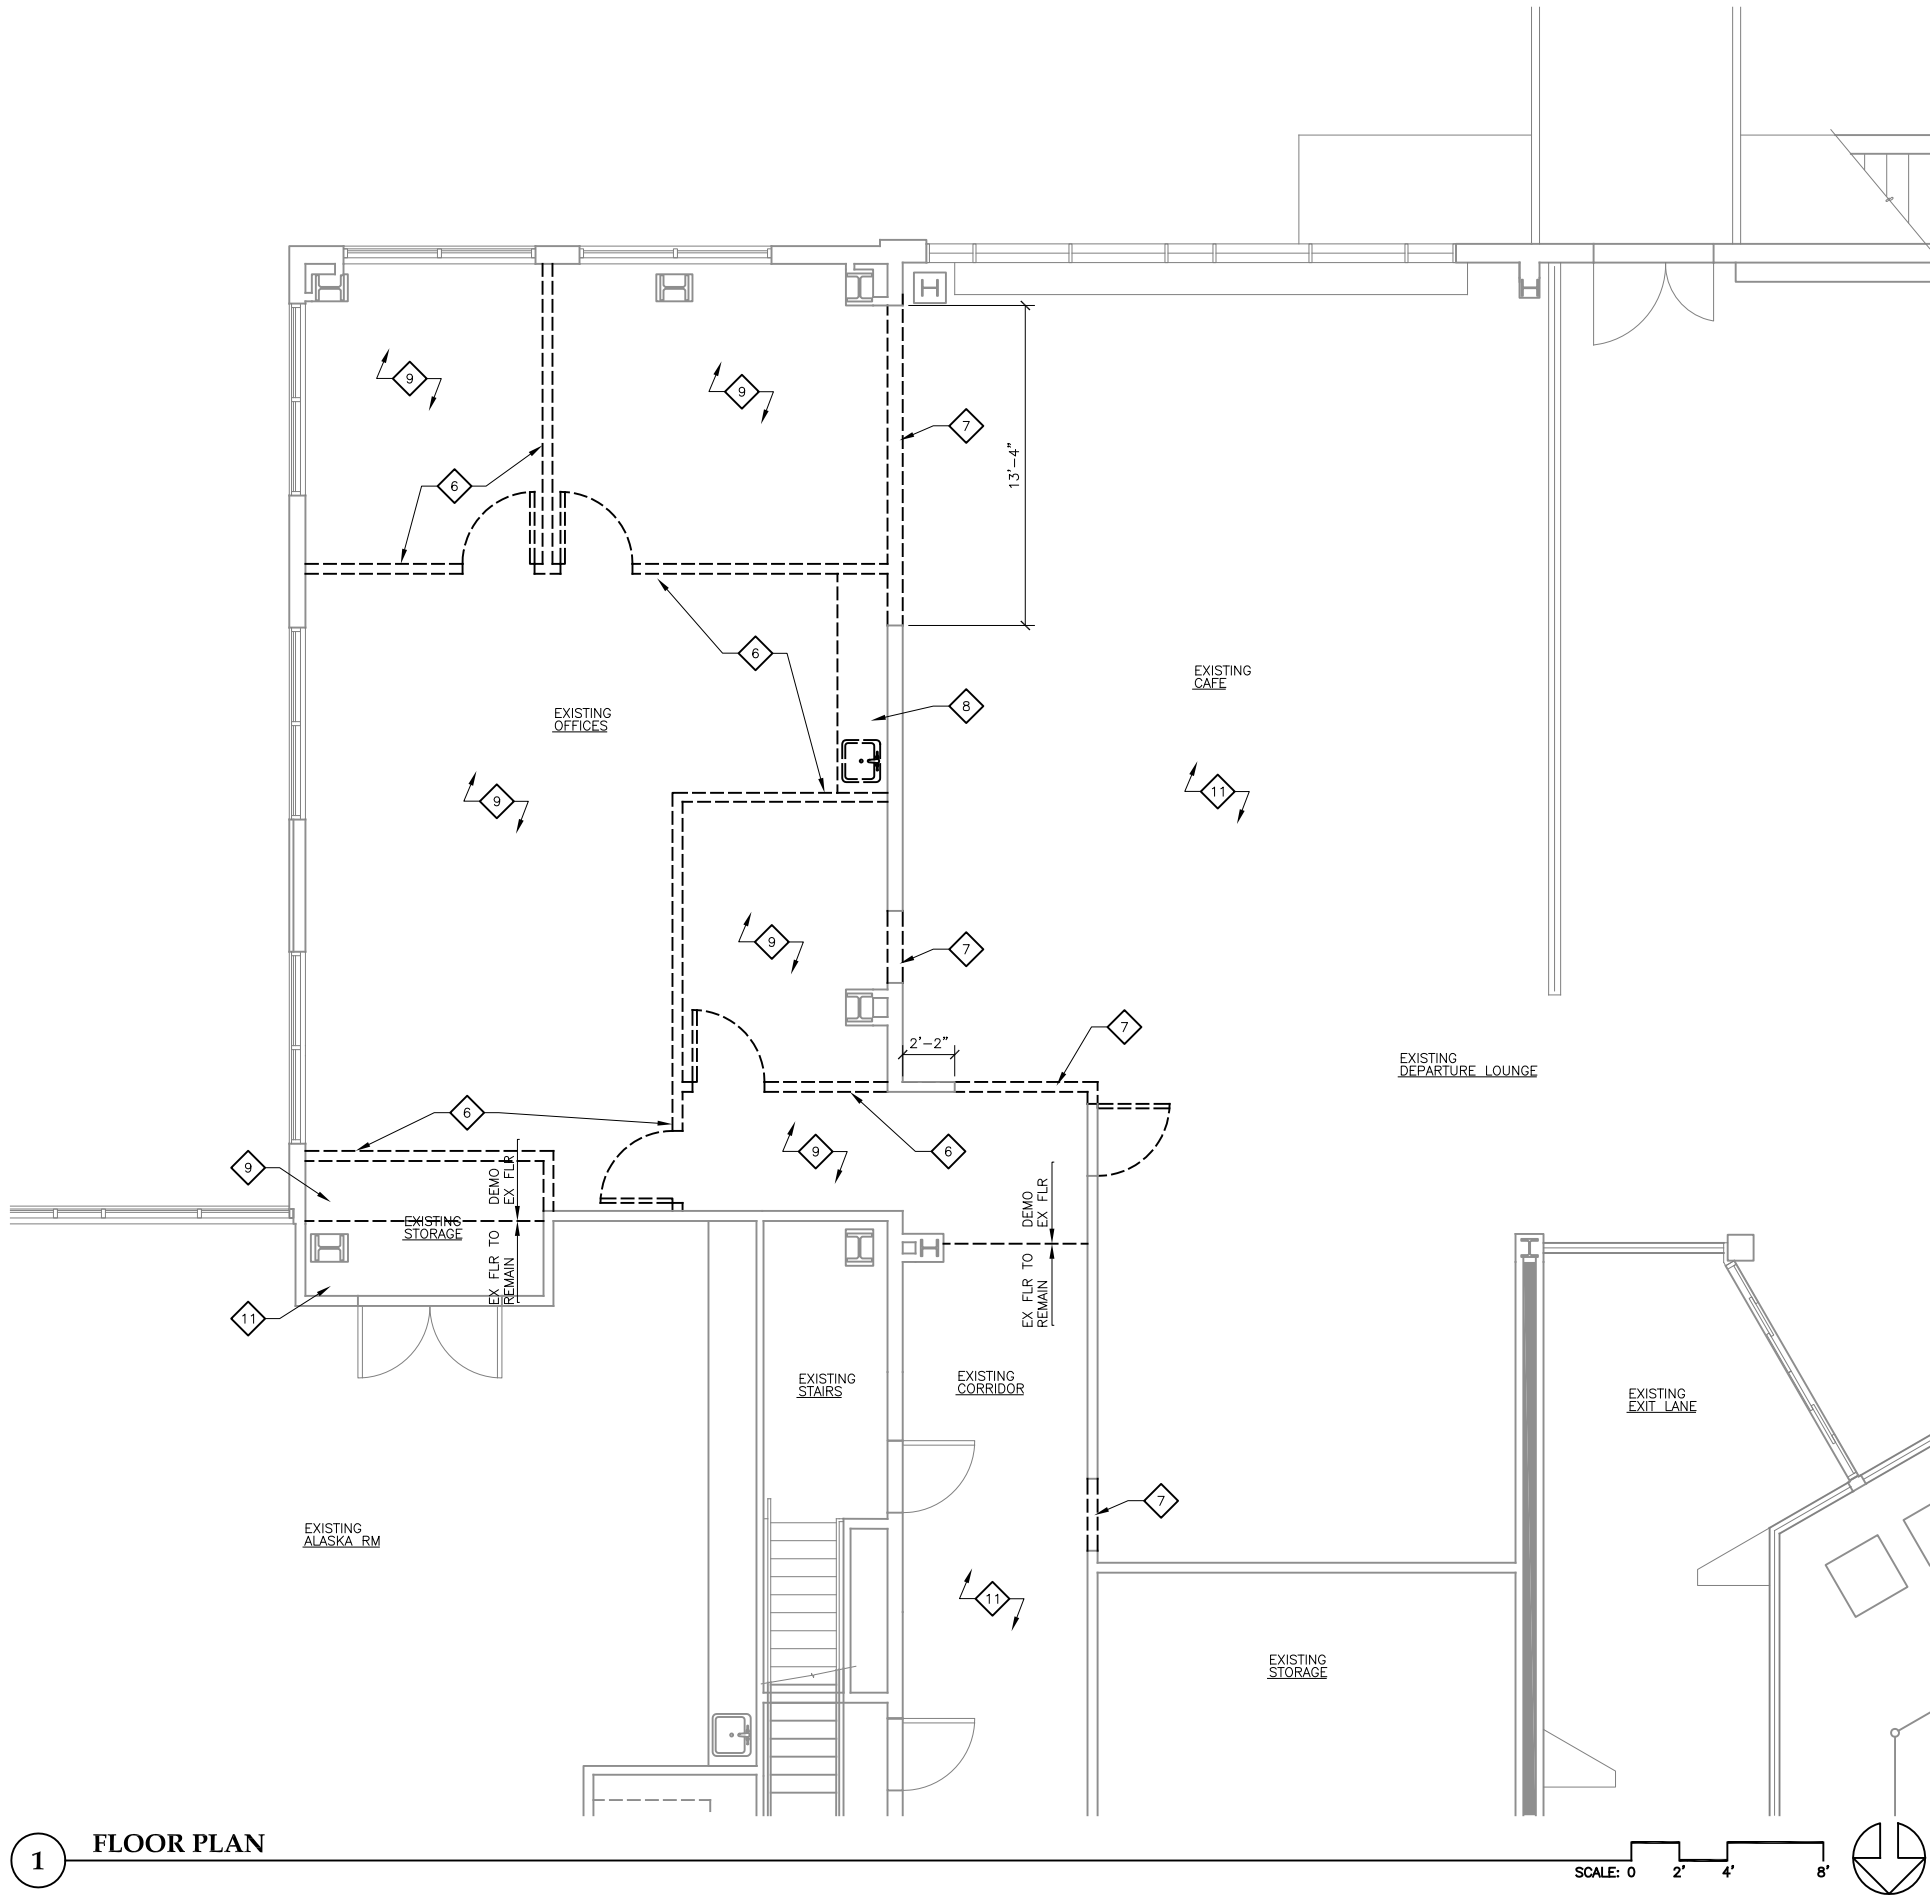

**Jensen
Yorba
Lott
Inc.**

522 West 10th Street
Juneau, Alaska 99801
phone 907-586-1070
fax 907-586-3959
jensenyorbalott.com



**City & Borough of Juneau
Juneau International Airport
CONCESSIONS EXPANSION
CBJ Contract No. E15-195
Juneau, Alaska**

BID

REVISIONS
△ .
△ .
△ .

SHEET TITLE
**DEMOLITION
FLOOR PLAN**

DATE: February 27, 2015
FILE: 11050


AD201


DEMOLITION GENERAL NOTES

- 1. SEE ELECTRICAL & MECHANICAL FOR FURTHER INFORMATION.
- 2. EX FINISHES @ WALLS TO REMAIN AND BE PATCHED AS NECESSARY.
- 3. PROTECT EX FINISHES TO REMAIN DURING WORK.
- 4. THE FOLLOWING WILL BE DEMOLISHED BY OWNER, VERIFY: PARTITIONS W/IN EX OFFICES, SALVAGABLE CEILING TILE AND GRID, CARPET, SINK AND CASEWORK W/IN EX OFFICES, LOW VOLTAGE CONTROLS, AND ELECTRICAL SWITCH AND OUTLET BOXES.

DEMOLITION KEY NOTES

- 1 EX CLG GRID AND TILES TO REMAIN
- 2 REMOVE EX CLG GRID & TILES WHERE WALLS ARE DEMOLISHED, PREPARE FOR PATCHING OF CLG
- 3 REMOVE EX CLG GRID & TILES – SALVAGE TILES FOR REUSE WHERE APPLICABLE
- 4 EX CLG GRID TO REMAIN, REMOVE CLG TILES AND SALVAGE FOR REUSE
- 5 EX WOOD CLG SYSTEM TO REMAIN
- 6 REMOVE EX WALL, DOOR & FRAME COMPLETE TO DECK – SALVAGE DOORS & FRAMES FOR REUSE, TURN OVER SURPLUS TO OWNER.
- 7 REMOVE EX WALL FOR DOOR OR SECURITY GRILL– VERIFY DIMENSIONS
- 8 REMOVE EX CASEWORK, COUNTER & SINK – SALVAGE & TURN OVER TO OWNER
- 9 REMOVE EX FLR – SALVAGE CPT TILES & TURN OVER TO OWNER
- 10 NOT USED
- 11 EX FLR TO REMAIN

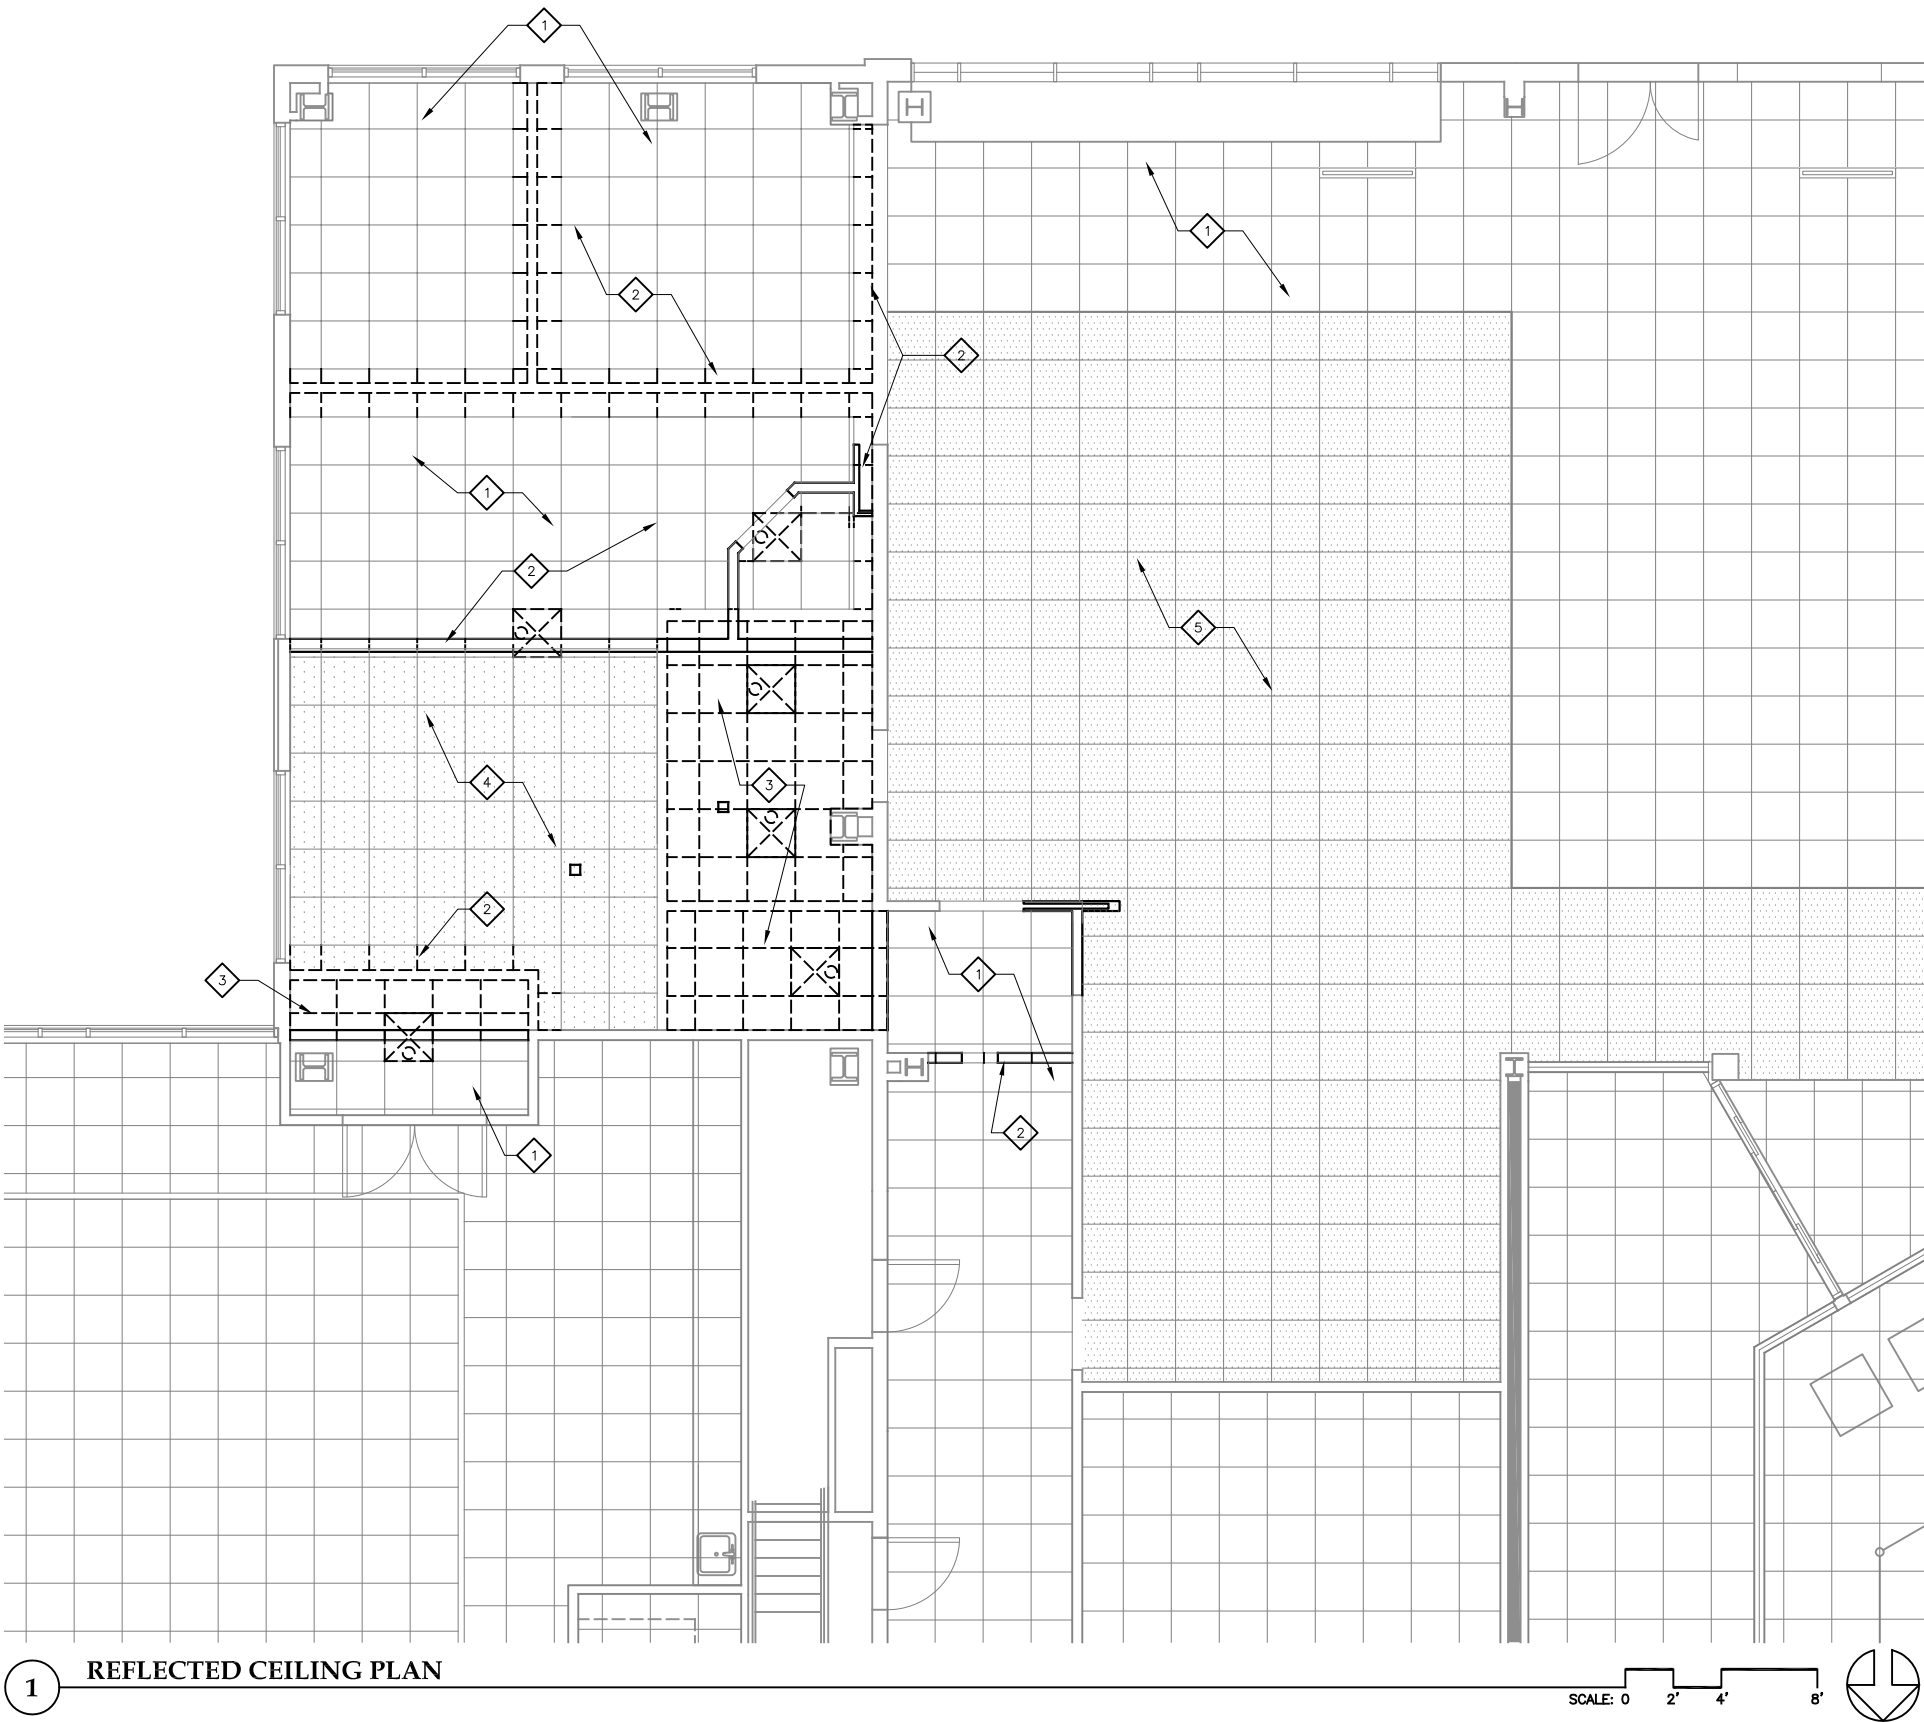

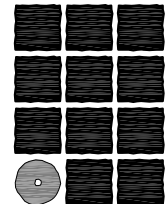

**Jensen
Yorba
Lott
Inc.**

522 West 10th Street
Juneau, Alaska 99801
phone 907-586-1070
fax 907-586-3959
jensenyorbalott.com



City & Borough of Juneau
Juneau International Airport
CONCESSIONS EXPANSION
CBJ Contract No. E15-195
Juneau, Alaska

BID

REVISIONS

- △ .
- △ .
- △ .

SHEET TITLE

**DEMOLITION
CEILING PLAN**


DATE: February 27, 2015
FILE: 11050

RENOVATION GENERAL NOTES

- 1. CEILING ELEVATIONS TO MATCH EXISTING.
- 2. PATCH EX FINISHES WHERE EX WALLS ARE REMOVED.
- 3. P1 PAINT, B1 BASE, C1 CEILING TILE TYPICAL, UON.
- 4. SEE MECH & ELECT FOR MORE INFORMATION. SEE K001 FOR EQUIPMENT LAYOUT.

RENOVATION KEY NOTES

- 1 EX CLG GRID AND TILES
- 2 PATCH EX CLG GRID & TILES, REUSE SALVAGED EX MEMBERS
- 3 CLG GRID TO MATCH EX
- 4 EX CLG GRID, C2 CLG TILES
- 5 EX WOOD CLG SYSTEM
- 6 WINDOW BEHIND COLUMN
- 7 ALIGN WALL WITH WINDOW MULLION
- 8 GWB WRAPPED FLR TO DECK POST @ END OF LOW WALL, COORDINATE LENGTHS WITH MECH & ELEC
- 9 24"w x36"h HM LITE -- HEAD @ 7'-0"
- 10 LOW WALL BELOW TOP BAR
- 11 TOP BAR
- 12 BREAK MTL PANEL TO WRAP AROUND CORNER
- 13 EX FINISHES
- 14 MATCH EX ADJACENT FINISHES & COLORS
- 15 SS CORNER GUARD
- 16 SIGNAGE BY OWNER
- 17 EX CAFE EQUIPMENT NOT SHOWN FOR CLARITY
- 18 PERFORATED MTL PANELS, SEE DETAILS

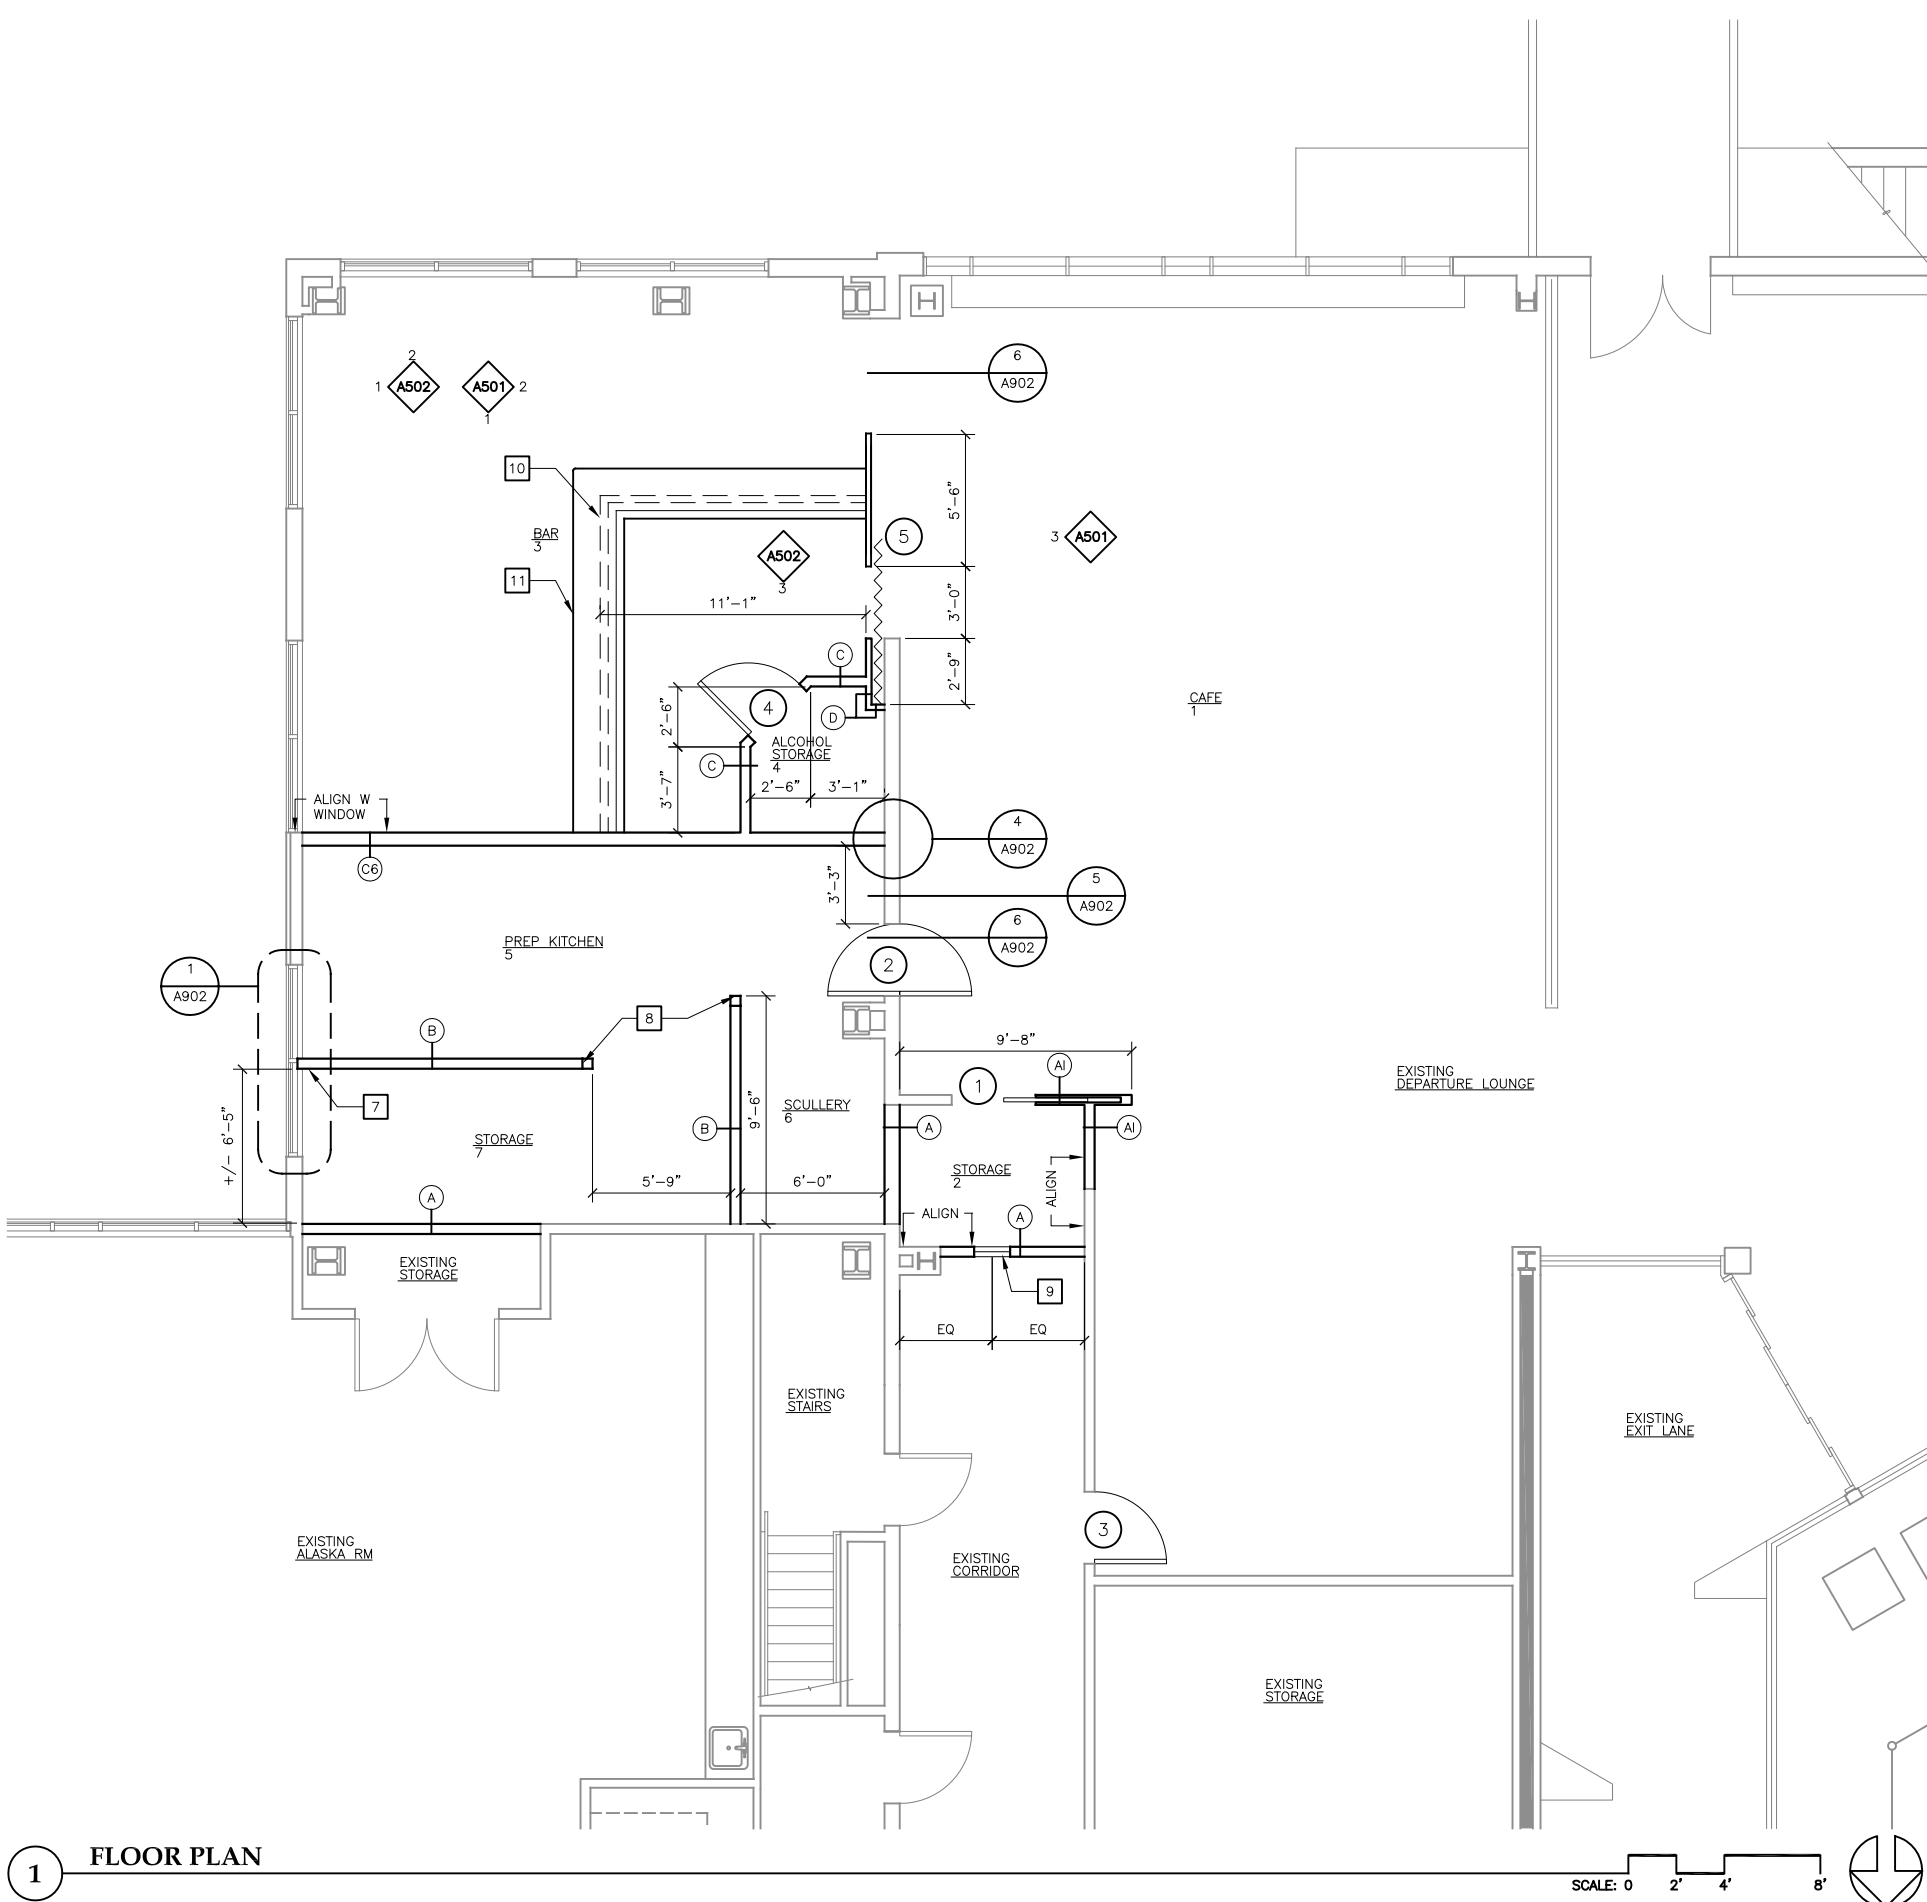

Jensen Yorba Lott Inc.

522 West 10th Street
Juneau, Alaska 99801
phone 907-586-1070
fax 907-586-3959
jensenyorbalott.com



City & Borough of Juneau
Juneau International Airport
CONCESSIONS EXPANSION
CBJ Contract No. E15-195
Juneau, Alaska

BID

REVISIONS

- △ .
- △ .
- △ .

SHEET TITLE

FLOOR PLAN

.
.
.

DATE: February 27, 2015
FILE: 11050

RENOVATION GENERAL NOTES

- 1. CEILING ELEVATIONS TO MATCH EXISTING.
- 2. PATCH EX FINISHES WHERE EX WALLS ARE REMOVED.
- 3. P1 PAINT, B1 BASE, C1 CEILING TILE TYPICAL, UON.
- 4. SEE MECH & ELECT FOR MORE INFORMATION. SEE K001 FOR EQUIPMENT LAYOUT.


RENOVATION KEY NOTES


- 1 EX CLG GRID AND TILES
- 2 PATCH EX CLG GRID & TILES, REUSE SALVAGED EX MEMBERS
- 3 CLG GRID TO MATCH EX
- 4 EX CLG GRID, C2 CLG TILES
- 5 EX WOOD CLG SYSTEM
- 6 WINDOW BEHIND COLUMN
- 7 ALIGN WALL WITH WINDOW MULLION
- 8 GWB WRAPPED FLR TO DECK POST @ END OF LOW WALL, COORDINATE LENGTHS WITH MECH & ELEC
- 9 24"w x36"h HM LITE -- HEAD @ 7'-0"
- 10 LOW WALL BELOW TOP BAR
- 11 TOP BAR
- 12 BREAK MTL PANEL TO WRAP AROUND CORNER
- 13 EX FINISHES
- 14 MATCH EX ADJACENT FINISHES & COLORS
- 15 SS CORNER GUARD
- 16 SIGNAGE BY OWNER
- 17 EX CAFE EQUIPMENT NOT SHOWN FOR CLARITY
- 18 PERFORATED MTL PANELS, SEE DETAILS

FINISH LEGEND

SEE SPECIFICATIONS FOR FURTHER INFORMATION


- CP CARPET TILE
- SV SHEET VINYL
- B1 WALL BASE -- TYPE 1, WOOD
- B2 WALL BASE -- TYPE 2, SHEET VINYL
- P1 PAINT -- COLOR 1
- P2 PAINT -- COLOR 2
- P3 PAINT -- COLOR 3
- P4 PAINT -- COLOR 4
- W1 WAINSCOT -- TYPE 1, WOOD
- W2 WAINSCOT -- TYPE 2, FRP
- C1 CEILING TILE -- TYPE 1
- C2 CEILING TILE -- TYPE 2, KITCHEN

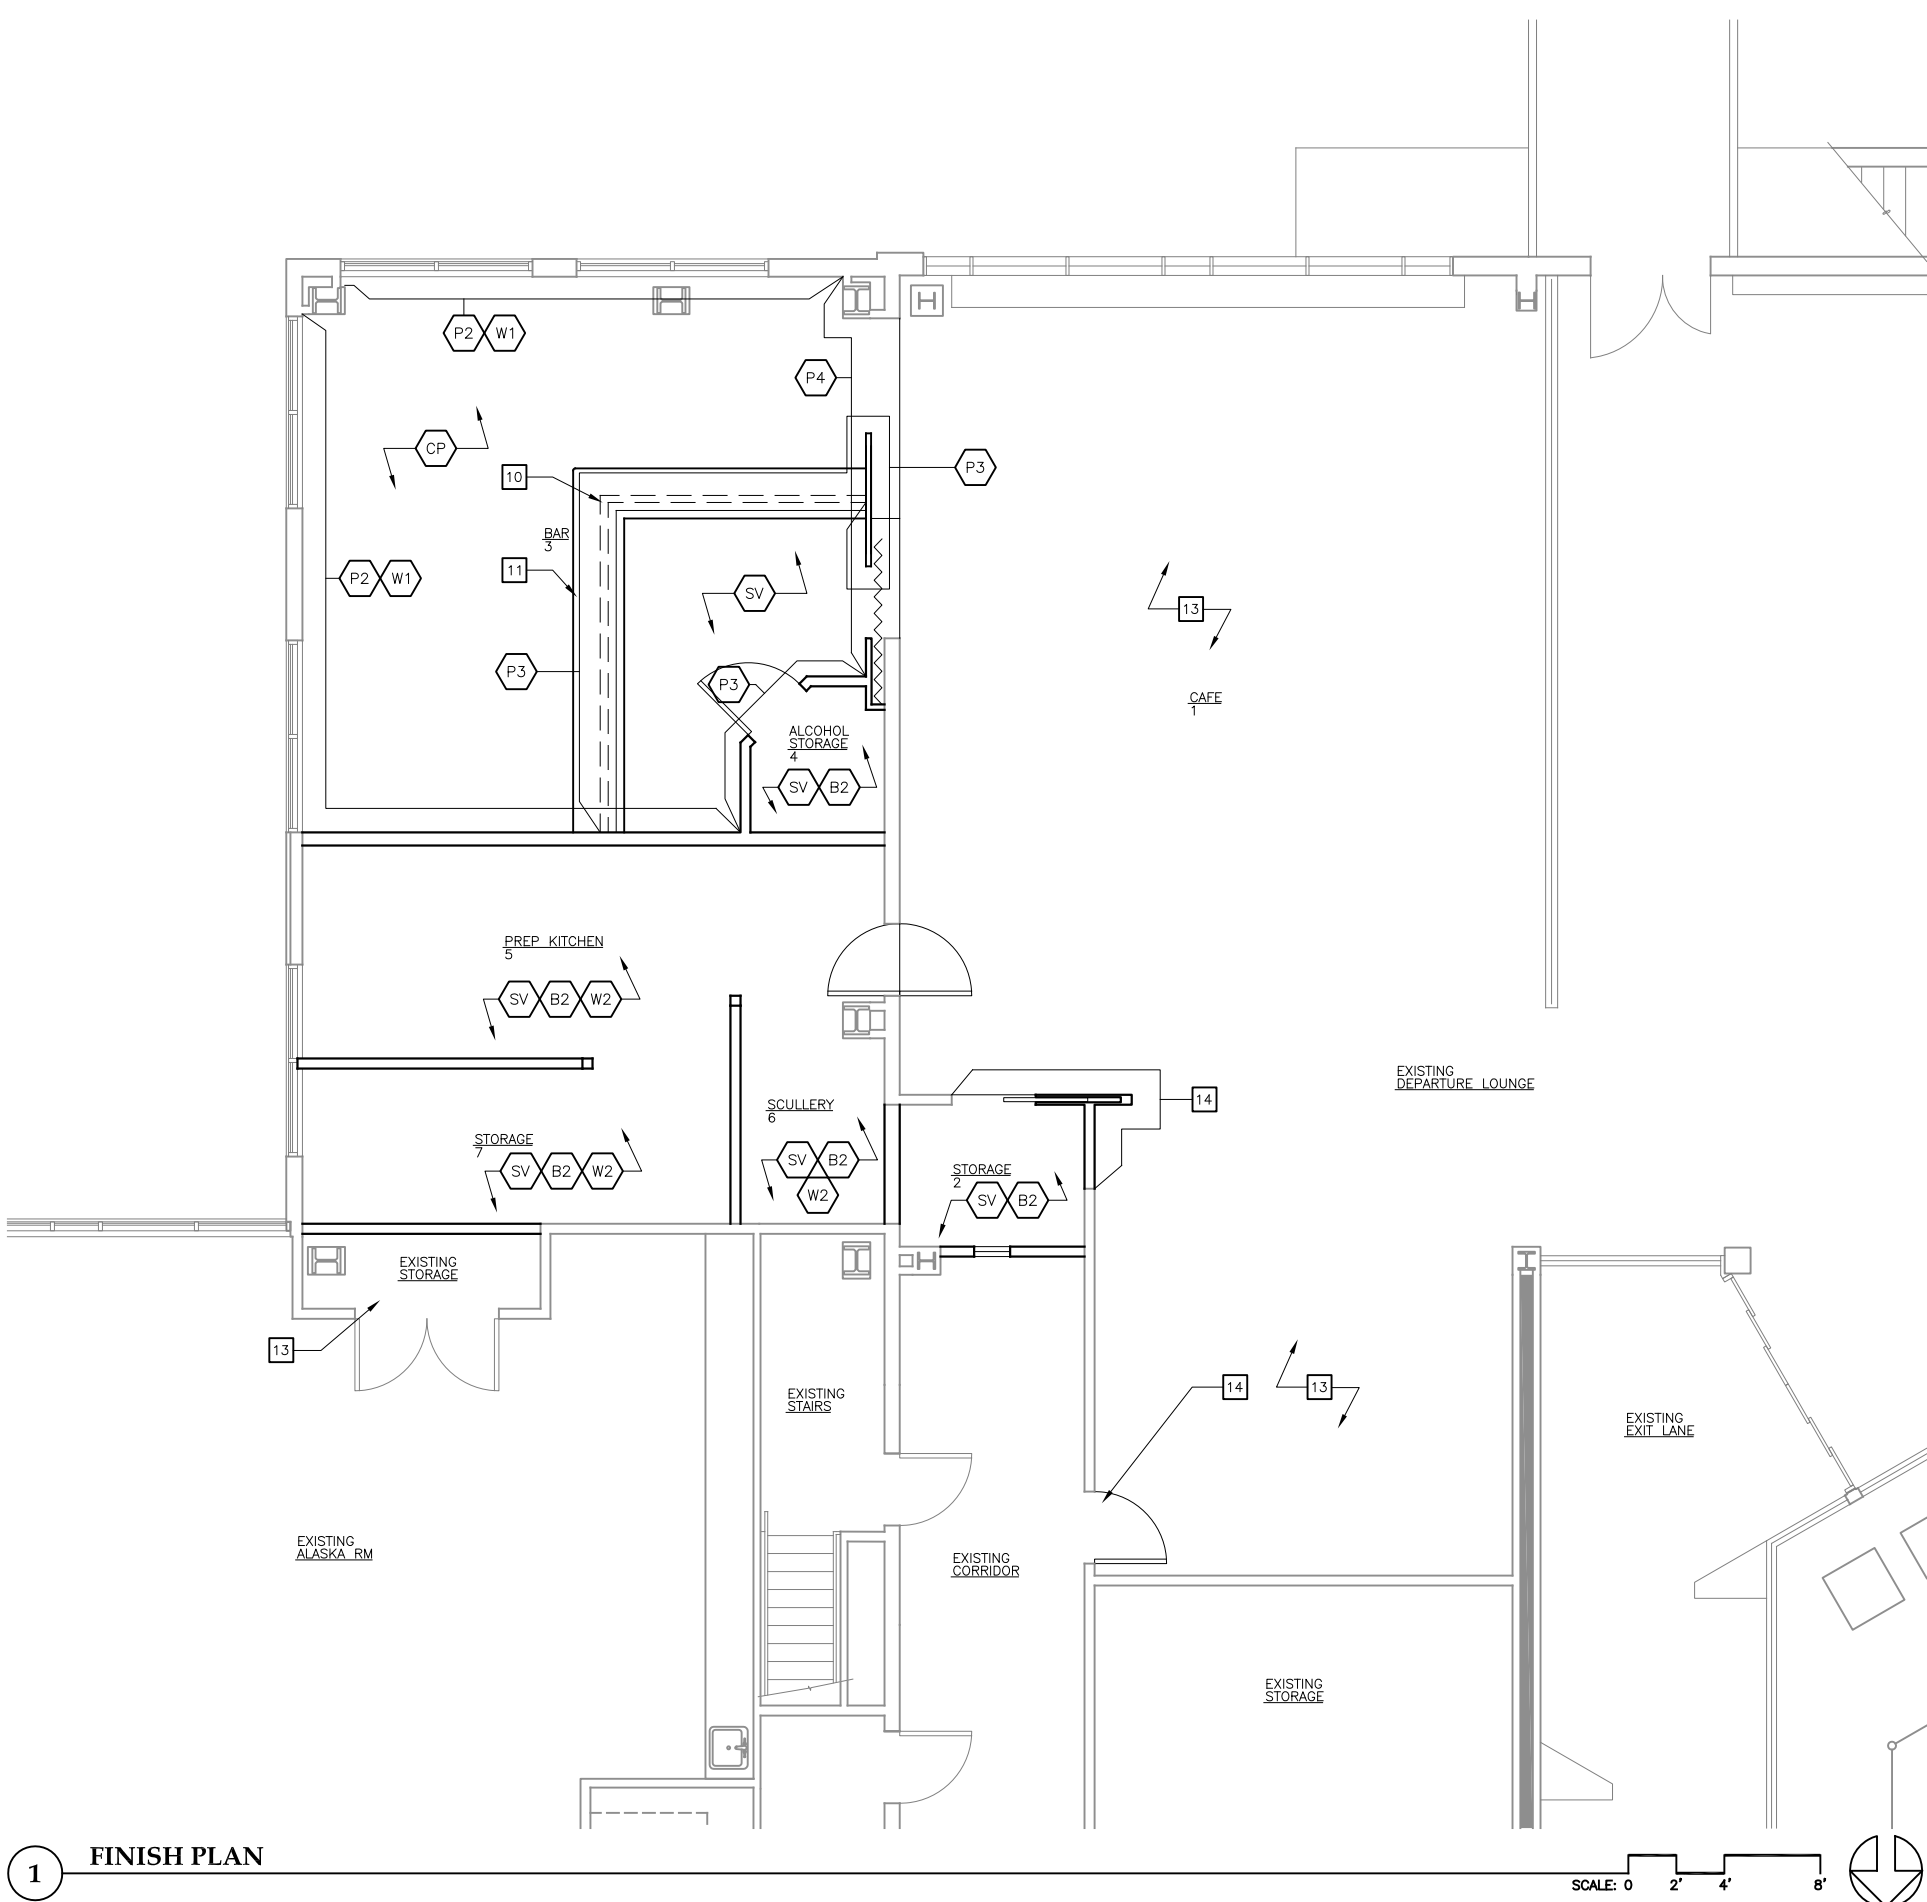

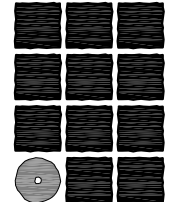

**Jensen
Yorba
Lott
Inc.**

522 West 10th Street
Juneau, Alaska 99801
phone 907-586-1070
fax 907-586-3959
jensenyorbalott.com

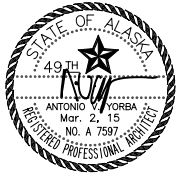

City & Borough of Juneau
Juneau International Airport
CONCESSIONS EXPANSION
CBJ Contract No. E15-195
Juneau, Alaska

BID

REVISIONS

△	.
△	.
△	.

SHEET TITLE

FINISH PLAN

.

.




DATE: February 27, 2015
FILE: 11050

RENOVATION GENERAL NOTES

- 1. CEILING ELEVATIONS TO MATCH EXISTING.
- 2. PATCH EX FINISHES WHERE EX WALLS ARE REMOVED.
- 3. (P1) PAINT, (B1) BASE, (C1) CEILING TILE TYPICAL, UON.
- 4. SEE MECH & ELECT FOR MORE INFORMATION. SEE K001 FOR EQUIPMENT LAYOUT.

RENOVATION KEY NOTES

- 1 EX CLG GRID AND TILES
- 2 PATCH EX CLG GRID & TILES, REUSE SALVAGED EX MEMBERS
- 3 CLG GRID TO MATCH EX
- 4 (EX CLG GRID, (C2) CLG TILES
- 5 (EX WOOD CLG SYSTEM
- 6 WINDOW BEHIND COLUMN
- 7 ALIGN WALL WITH WINDOW MULLION
- 8 GWB WRAPPED FLR TO DECK POST @ END OF LOW WALL, COORDINATE LENGTHS WITH MECH & ELEC
- 9 24"w x36"h HM LITE -- HEAD @ 7'-0"
- 10 LOW WALL BELOW TOP BAR
- 11 TOP BAR
- 12 BREAK MTL PANEL TO WRAP AROUND CORNER
- 13 EX FINISHES
- 14 MATCH EX ADJACENT FINISHES & COLORS
- 15 SS CORNER GUARD
- 16 SIGNAGE BY OWNER
- 17 EX CAFE EQUIPMENT NOT SHOWN FOR CLARITY
- 18 PERFORATED MTL PANELS, SEE DETAILS

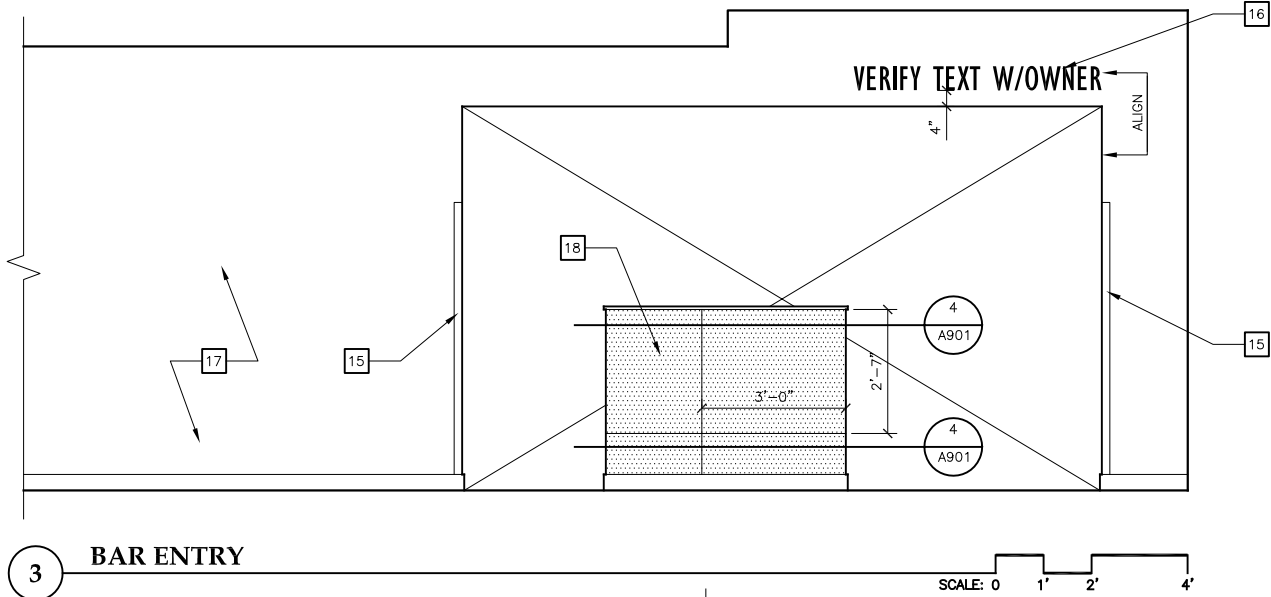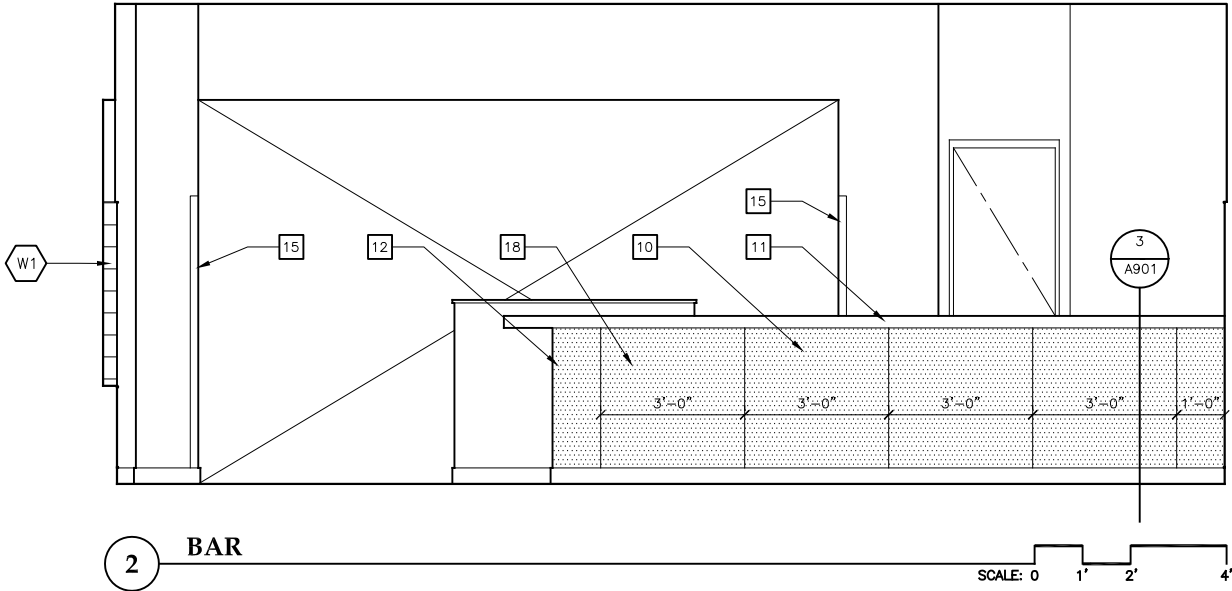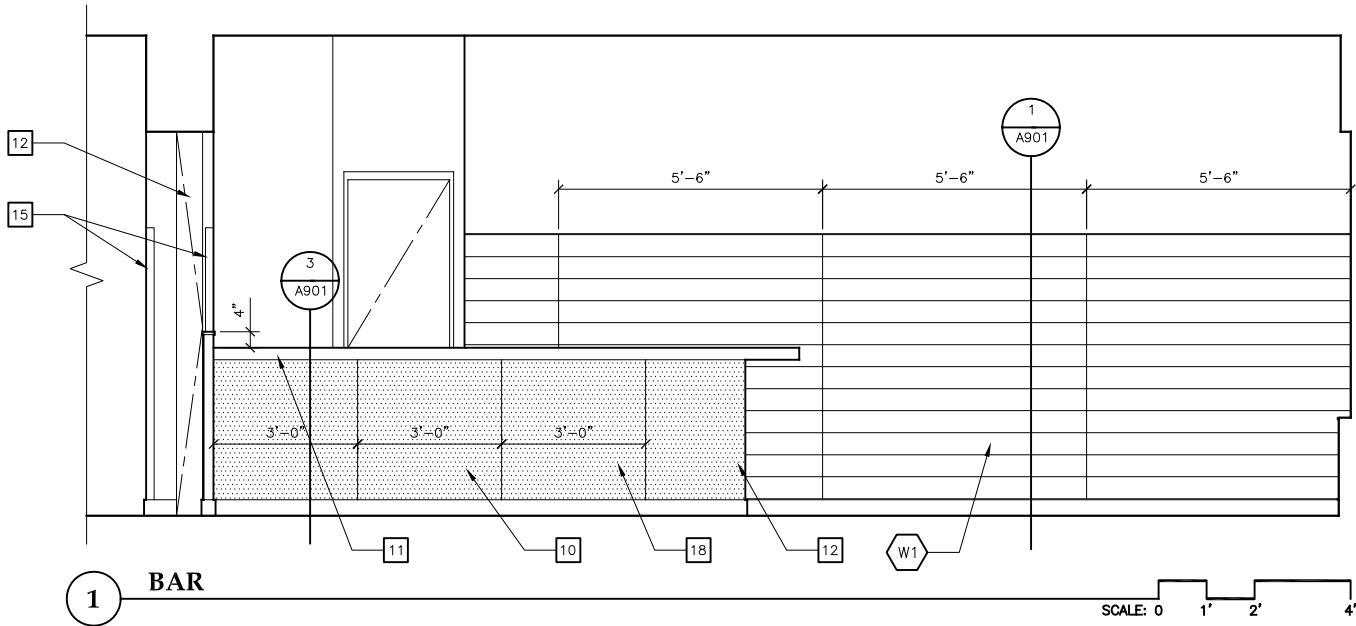

Jensen Yorba Lott Inc.
522 West 10th Street
Juneau, Alaska 99801
phone 907-586-1070
fax 907-586-3959
jensenyorbalott.com



City & Borough of Juneau
Juneau International Airport
CONCESSIONS EXPANSION
CBJ Contract No. E15-195
Juneau, Alaska

BID
REVISIONS
△ .
△ .
△ .
SHEET TITLE
INTERIOR
ELEVATIONS
.
DATE: February 27, 2015
FILE: 11050





A501

RENOVATION GENERAL NOTES

1. CEILING ELEVATIONS TO MATCH EXISTING.
2. PATCH EX FINISHES WHERE EX WALLS ARE REMOVED.
3.  PAINT,  BASE,  CEILING TILE TYPICAL, UON.
4. SEE MECH & ELECT FOR MORE INFORMATION. SEE K001 FOR EQUIPMENT LAYOUT.


RENOVATION KEY NOTES

- 1 EX CLG GRID AND TILES
- 2 PATCH EX CLG GRID & TILES, REUSE SALVAGED EX MEMBERS
- 3 CLG GRID TO MATCH EX
- 4  EX CLG GRID,  CLG TILES
- 5  EX WOOD CLG SYSTEM
- 6 WINDOW BEHIND COLUMN
- 7 ALIGN WALL WITH WINDOW MULLION
- 8 GWB WRAPPED FLR TO DECK POST @ END OF LOW WALL, COORDINATE LENGTHS WITH MECH & ELEC
- 9 24"w x36"h HM LITE — HEAD @ 7'-0"
- 10 LOW WALL BELOW TOP BAR
- 11 TOP BAR
- 12 BREAK MTL PANEL TO WRAP AROUND CORNER
- 13 EX FINISHES
- 14 MATCH EX ADJACENT FINISHES & COLORS
- 15 SS CORNER GUARD
- 16 SIGNAGE BY OWNER
- 17 EX CAFE EQUIPMENT NOT SHOWN FOR CLARITY
- 18 PERFORATED MTL PANELS, SEE DETAILS

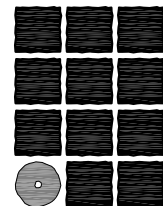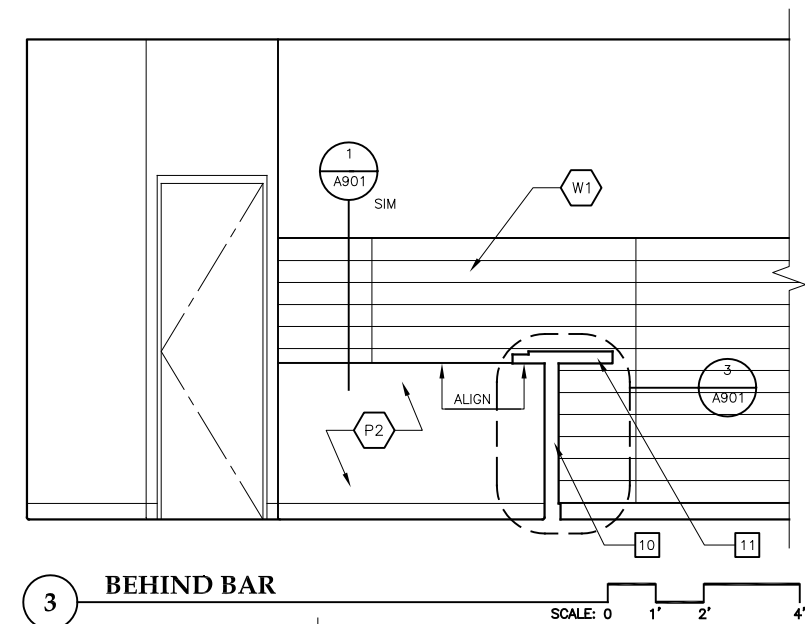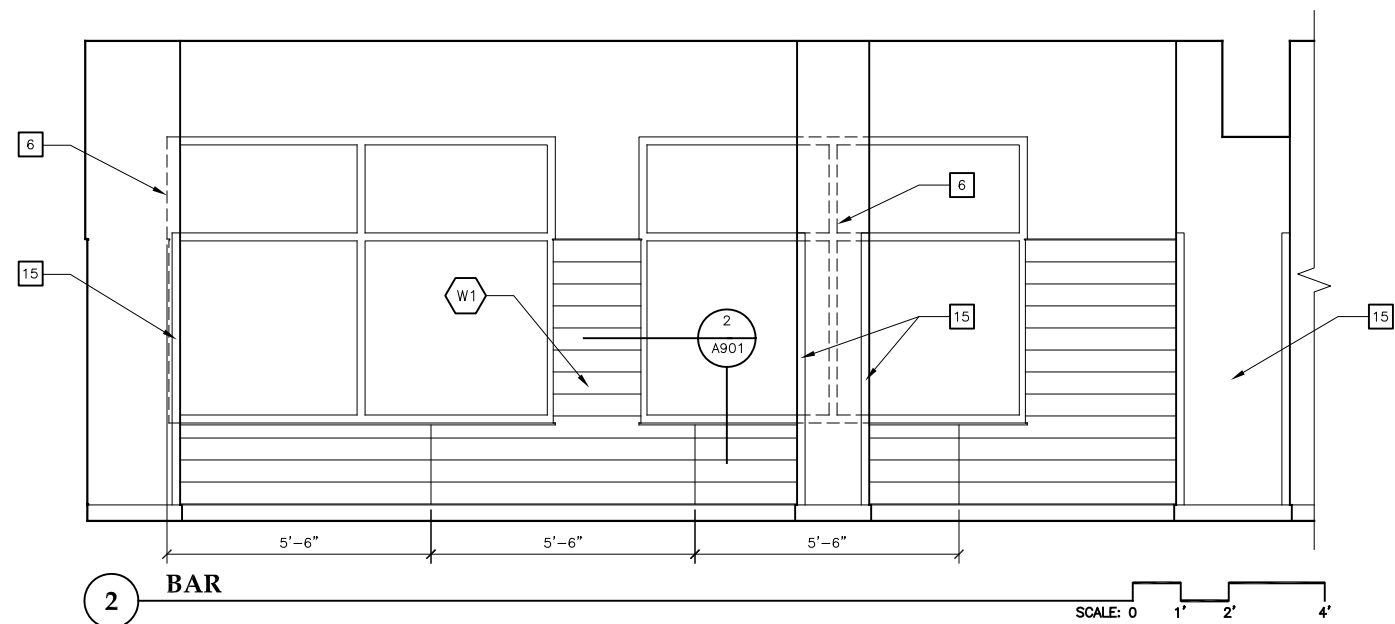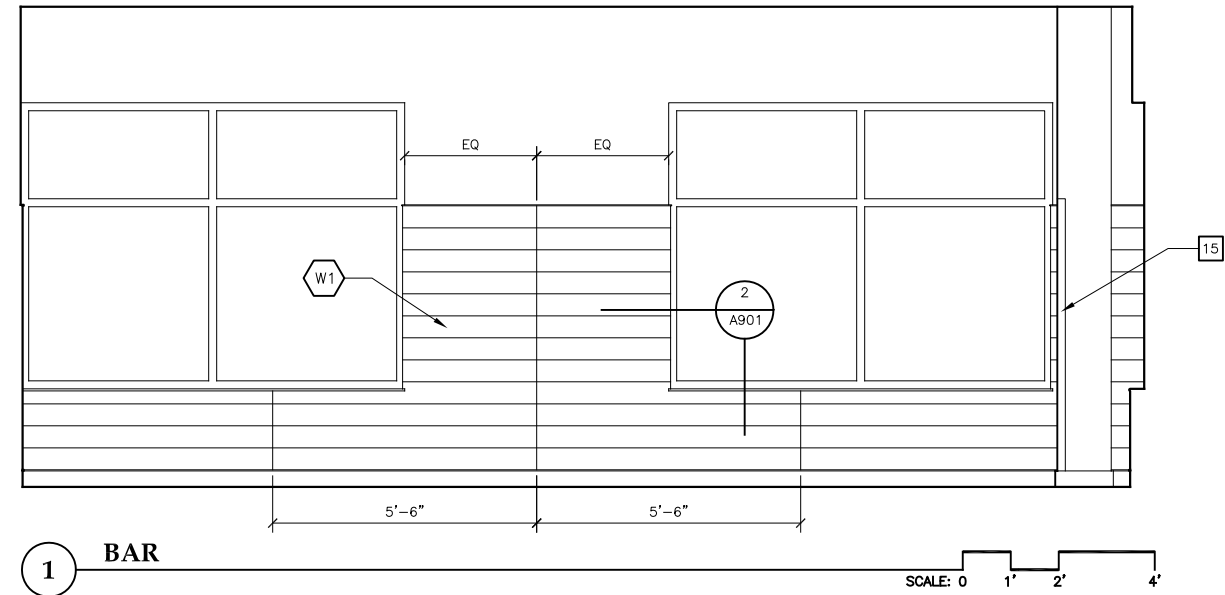

**Jensen
Yorba
Lott
Inc.**

522 West 10th Street
Juneau, Alaska 99801
phone 907-586-1070
fax 907-586-3959
jensenyorbalott.com

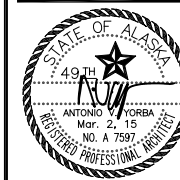

**City & Borough of Juneau
Juneau International Airport
CONCESSIONS EXPANSION
CBJ Contract No. E15-195
Juneau, Alaska**

BID

REVISIONS





SHEET TITLE

INTERIOR ELEVATIONS

•

•

DATE: February 27, 2015

FILE: 11050

A502

RENOVATION GENERAL NOTES

1. CEILING ELEVATIONS TO MATCH EXISTING.
2. PATCH EX FINISHES WHERE EX WALLS ARE REMOVED.
3.

P1

 PAINT,

B1

 BASE,

C1


 CEILING TILE TYPICAL, UON.
4. SEE MECH & ELECT FOR MORE INFORMATION. SEE K001 FOR EQUIPMENT LAYOUT.

RENOVATION KEY NOTES

- 1 EX CLG GRID AND TILES
- 2 PATCH EX CLG GRID & TILES, REUSE SALVAGED EX MEMBERS
- 3 CLG GRID TO MATCH EX
- 4 EX CLG GRID,


C2

 CLG TILES
- 5 EX WOOD CLG SYSTEM
- 6 WINDOW BEHIND COLUMN
- 7 ALIGN WALL WITH WINDOW MULLION
- 8 GWB WRAPPED FLR TO DECK POST @ END OF LOW WALL, COORDINATE LENGTHS WITH MECH & ELEC
- 9 24"w x36"h HM LITE -- HEAD @ 7'-0"
- 10 LOW WALL BELOW TOP BAR
- 11 TOP BAR
- 12 BREAK MTL PANEL TO WRAP AROUND CORNER
- 13 EX FINISHES
- 14 MATCH EX ADJACENT FINISHES & COLORS
- 15 SS CORNER GUARD
- 16 SIGNAGE BY OWNER
- 17 EX CAFE EQUIPMENT NOT SHOWN FOR CLARITY
- 18 PERFORATED MTL PANELS, SEE DETAILS

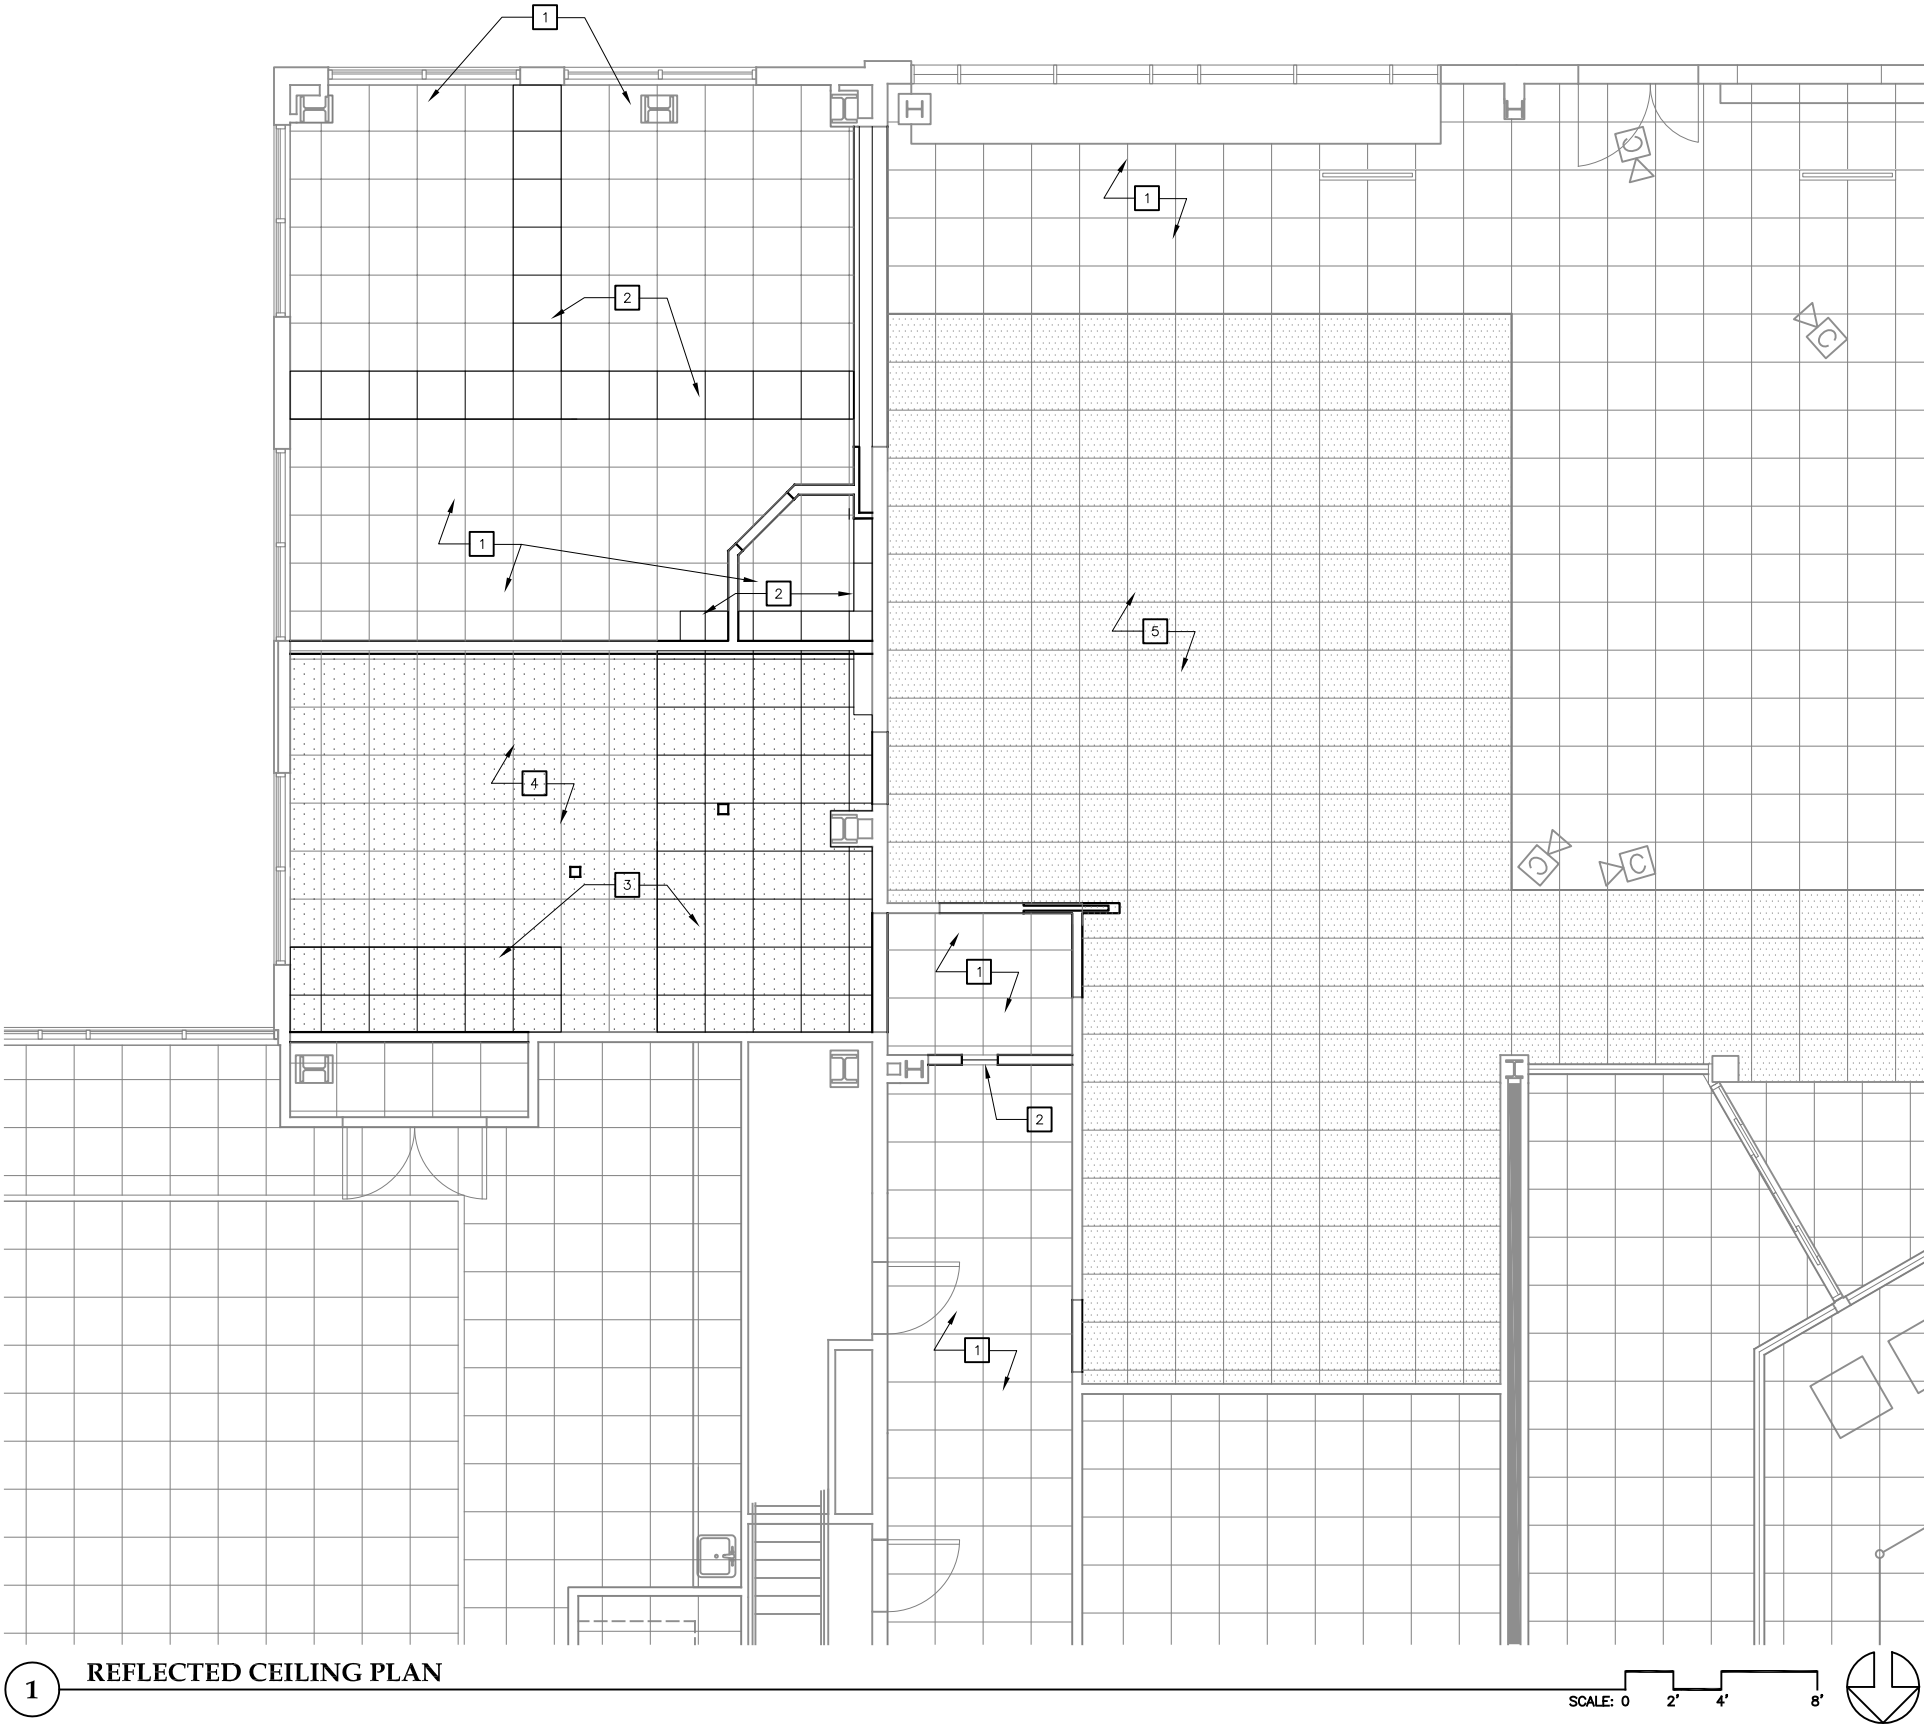

1 REFLECTED CEILING PLAN

SCALE: 0 2' 4' 8'

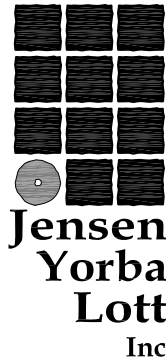

522 West 10th Street
Juneau, Alaska 99801
phone 907-586-1070
fax 907-586-3959
jensenyorbalott.com



City & Borough of Juneau
Juneau International Airport
CONCESSIONS EXPANSION
CBJ Contract No. E15-195
Juneau, Alaska

BID

REVISIONS






SHEET TITLE

CEILING PLAN



.
. .
. .

DATE: February 27, 2015
FILE: 11050

A601

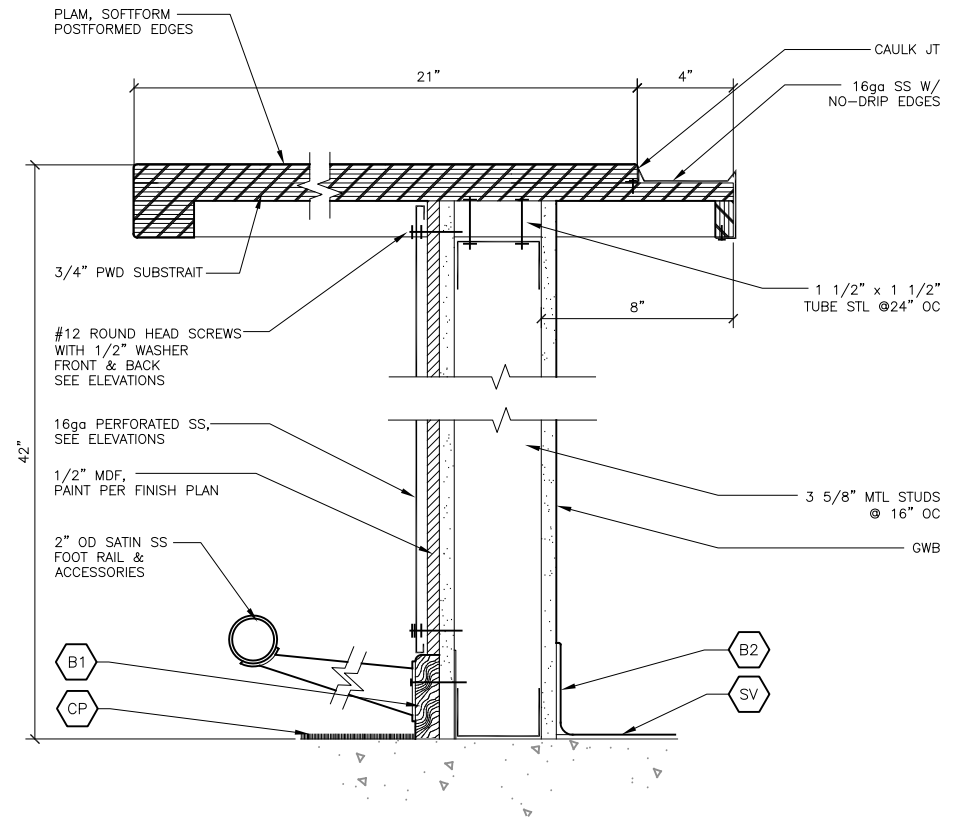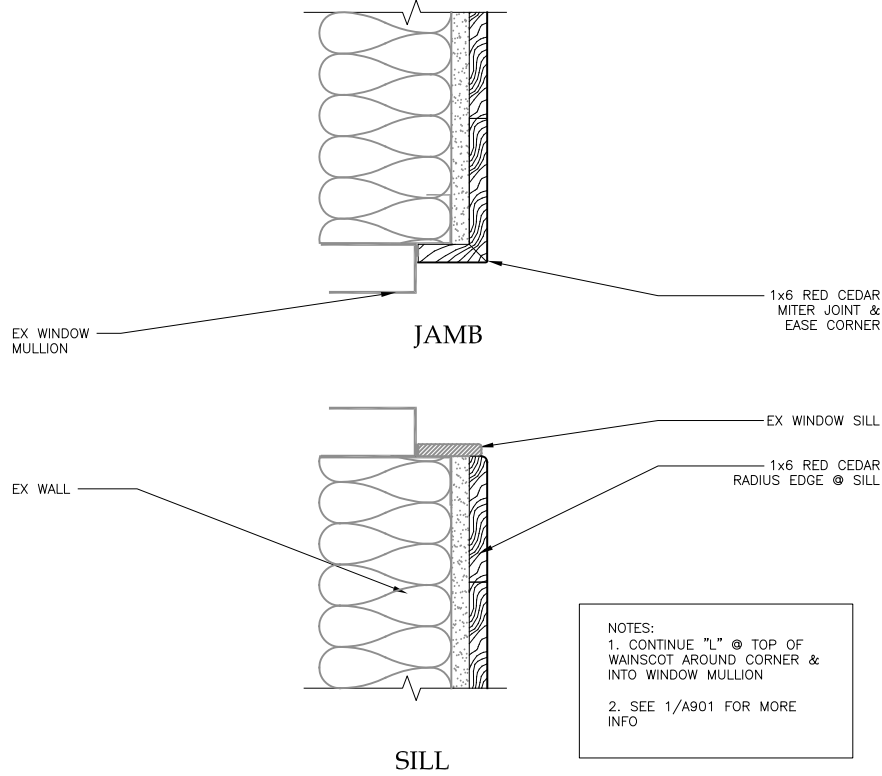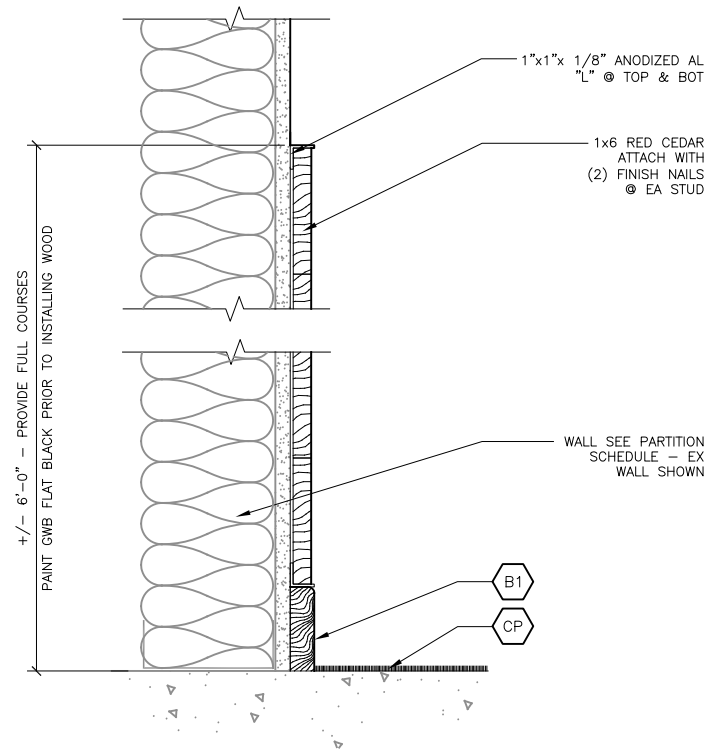


1 WAINSCOT "W1"
11050/X_A901-1 SCALE: 0 3" 6" 1'

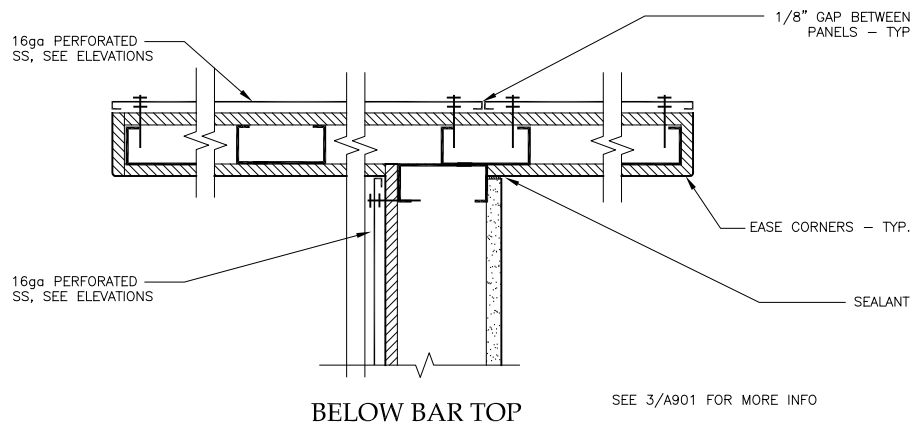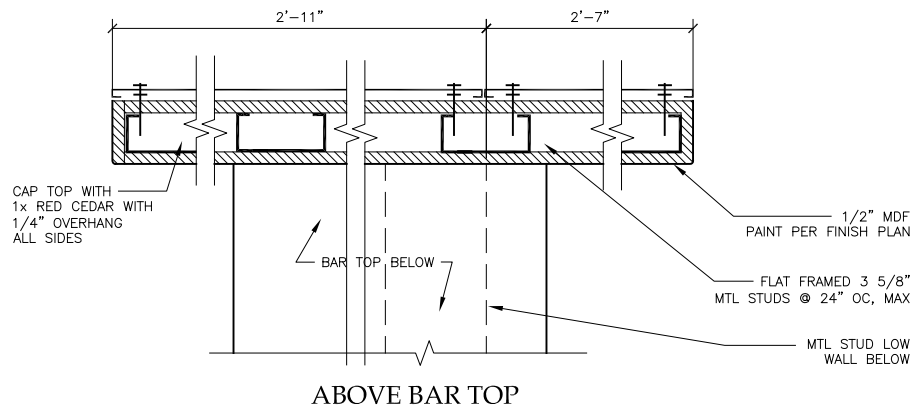

4 BAR @ END
11050/X_A901-4 SCALE: 0 3" 6" 1'

2 WAINSCOT "W1" @ WINDOWS
11050/X_A901-2 SCALE: 0 3" 6" 1'

3 BAR
11050/X_A901-3 SCALE: 0 3" 6" 1'

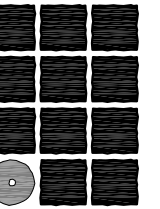

**Jensen
Yorba
Lott
Inc.**

522 West 10th Street
Juneau, Alaska 99801
phone 907-586-1070
fax 907-586-3959
jensenyorbalott.com



**City & Borough of Juneau
Juneau International Airport
CONCESSIONS EXPANSION
CBJ Contract No. E15-195
Juneau, Alaska**






BID

REVISIONS
△ .
△ .
△ .

SHEET TITLE
**INTERIOR
DETAILS**




DATE: February 27, 2015
FILE: 11050

A901

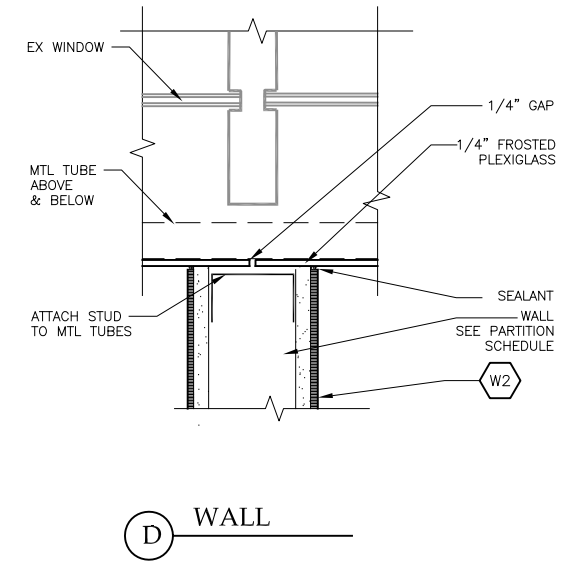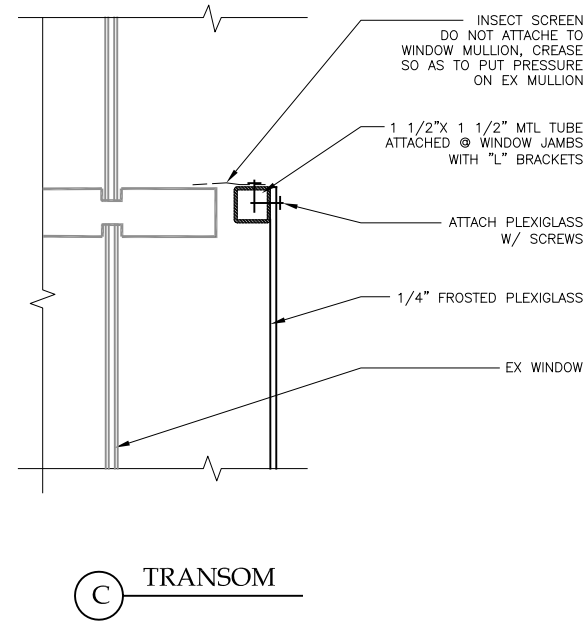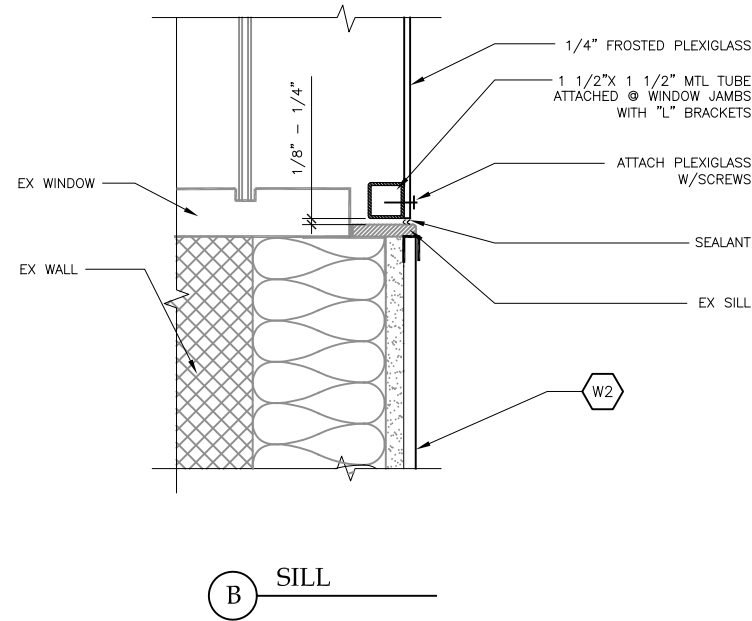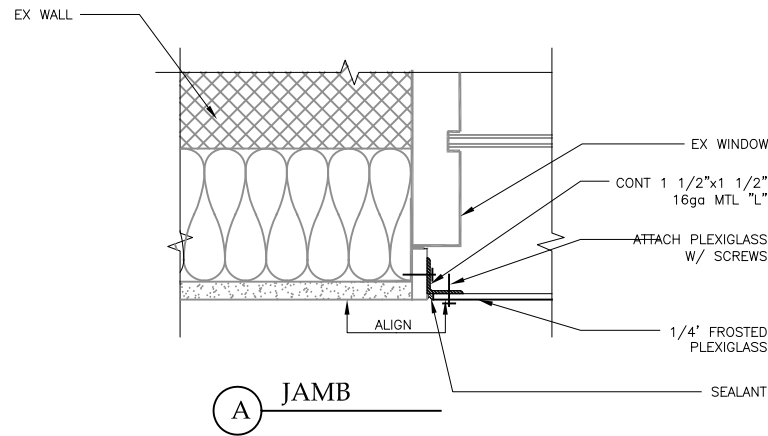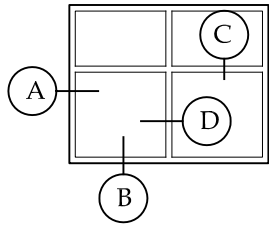

1 PREP KITCHEN WINDOW

11050/X_A902-1

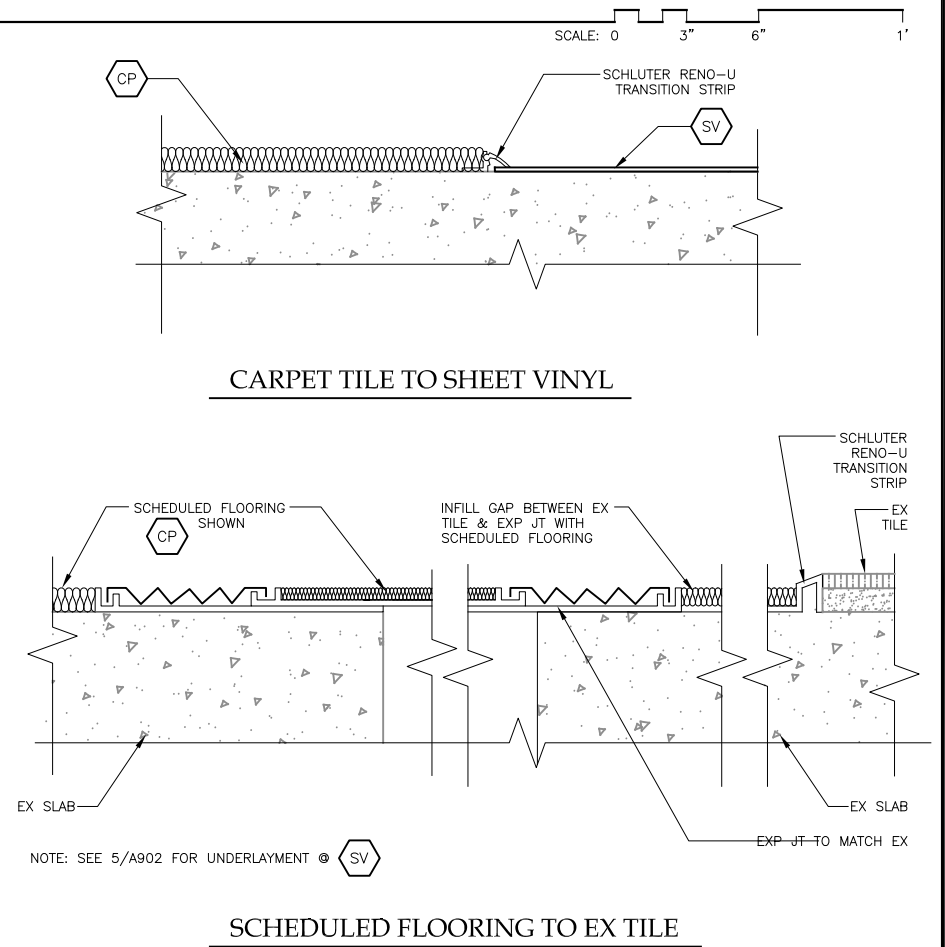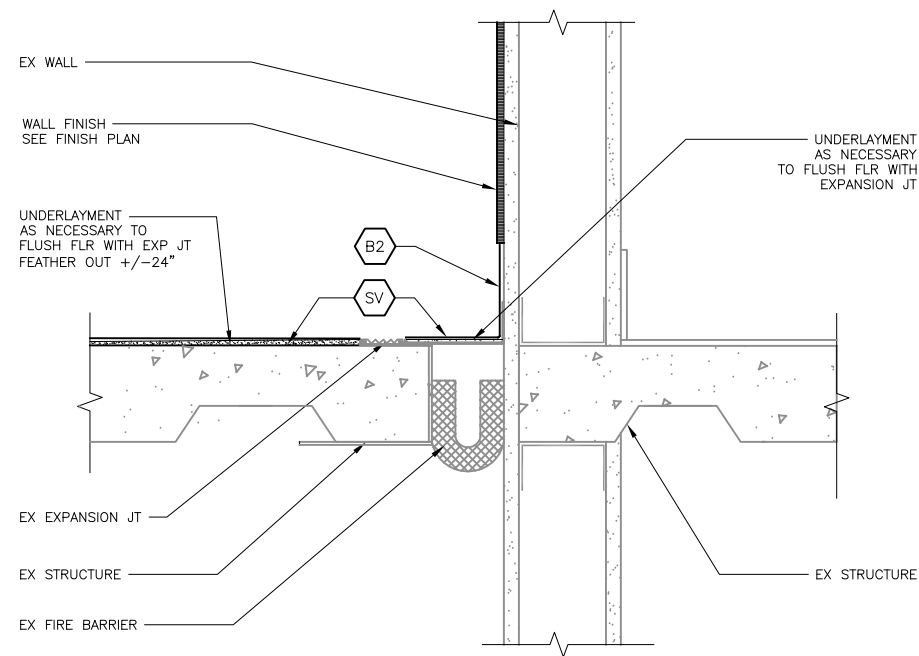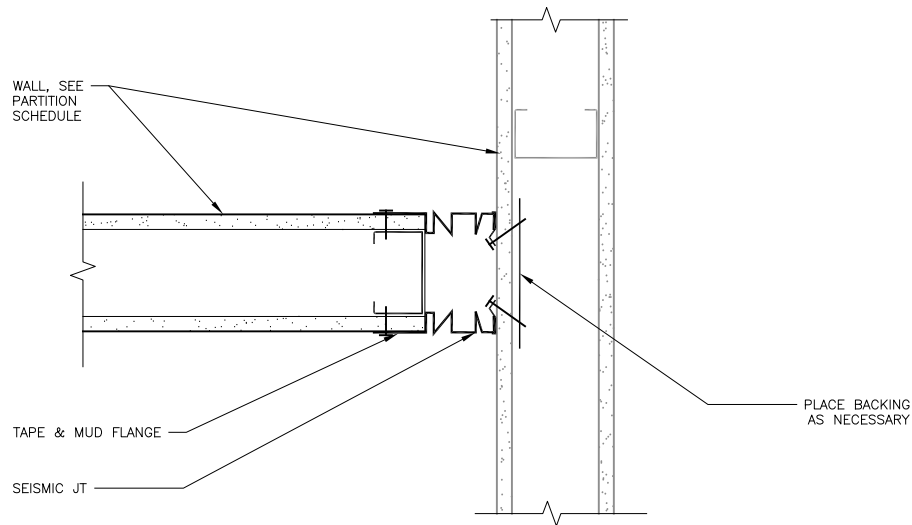

4 EXPANSION JOINT @ WALL

11050/X_A902-4

SCALE: 0 3" 6" 1'

5 EXPANSION JOINT @ FLOOR


11050/X_A902-5

SCALE: 0 3" 6" 1'

6 FLOOR TRANSITIONS


11050\X_902-6

SCALE: 0 1" 2" 4"

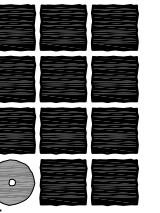

**Jensen
Yorba
Lott
Inc.**

522 West 10th Street
Juneau, Alaska 99801
phone 907-586-1070
fax 907-586-3959
jensenyorbalott.com

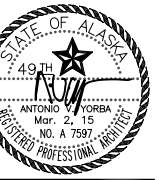

**City & Borough of Juneau
Juneau International Airport
CONCESSIONS EXPANSION
CBJ Contract No. E15-195
Juneau, Alaska**

BID

REVISIONS
△
△
△

SHEET TITLE
**INTERIOR
DETAILS**

DATE: February 27, 2015
FILE: 11050

A902

I:\NU Terminal Renovation Project 1382\H.Miscellaneous (1382.80)\Departure Lounge Food and Alcohol Concession Remodel 2015\Sheet K001

GENERAL NOTES:


EQUIPMENT INFORMATION PROVIDED FOR CONTRACTOR COORDINATION AND REFERENCE. SEE ARCHITECTURAL, MECHANICAL AND ELECTRICAL FOR ADDITIONAL INFORMATION.

ABBREVIATIONS:

H.W.	HAND WASH
NIC	NOT IN CONTRACT
OFCI	OWNER FURNISHED, CONTRACTOR INSTALLED
OFOI	OWNER FURNISHED, OWNER INSTALLED
S.S.	STAINLESS STEEL

EQUIPMENT LEGEND:

1. TRUE TSSU 72-18 REFRIGERATED SANDWICH MAKING TABLE (OFOI)
(30.13" D x 35.50" H x 72.25" W)
2. TRUE TSSU 72-30M-B REFRIGERATED SANDWICH MAKING TABLE (OFOI)
(34" D x 46.13" H x 72.25" W)
3. GF5 QUICK N' CRISPY GREASELESS FRYER (OFOI)
(25" H x 29" W x 21" D)
4. JOHN BOOS E SERIES 1 COMPARTMENT STAINLESS STEEL PREP SINK (OFCI)
MODEL # E1S8-18-12L 18
(23.5" D x 38.5" W x 43.812" H)
5. STAINLESS STEEL HAND WASH SINK (OFCI)
(14.75" D x 19" W)
6. ALTO SHAAM HEAT COOK/HOLD/SERVE SYSTEMS (OFOI)
(73 ⁷/₈" H x 22 ¹/₈" W x 33 ¹/₂" D)
7. TRUE T-49F TWO DOOR FREEZER (OFOI)
(54 ¹/₈" W x 29 ¹/₂" D x 78 ³/₈" H)
8. TRUE T-49 TWO SECTION REACH-IN REFRIGERATOR (OFOI)
(78.38" H x 54.13" W x 29.5" D)
9. BK RESOURCES 3 COMPARTMENT CORNER STAINLESS STEEL SINK (OFCI)
MODEL # BKCS-3-18-14-18T
(23.5" D x 57" W EACH SIDE)
10. KROWNE KR21-C30RD DRAINBOARD (OFCI)
(30" W x 26" D)
11. KROWNE KR 21-GW2 DUMP STATION (OFCI)
(24" W x 26" D)
12. KROWNE KR 21-6SH SODA GUN HOLDER (OFCI)
(6" W x 21" D)
13. KROWNE KR 21-30DP-10 ICE BIN W/ INTEGRAL COLD PLATE (OFCI)
(30" W x 19.5" D)
14. KROWNE KR 21-GSB1 GLASS STORAGE BIN (OFCI)
(24" W x 26" D)
15. KROWNE KR 21-GW2 HAND WASH SINK (OFCI)
(24" W x 26" D)
16. ADVANCE TABCO STAINLESS STEEL TABLE KSLAG-243-X W/ 5" RIGHT BACKSPLASH (OFOI)
(36" W x 24" D)
17. INSINGER RL-30 UNDER COUNTER DISHWASHER (OFCI)
(30.75" H x 23" W x 25" D)
18. MICRO MATIC MDD94 PRO-LINE DIRECT DRAW 5 KEG REFRIGERATOR (OFOI)
(37.25" H x 95.50" W x 28.25" D)
19. POINT OF SALE (POS) CABINET (OFOI)
20. ICE O-MATIC ICE MAKER (OFOI)
(42.5" W x 32" D x 69" H)

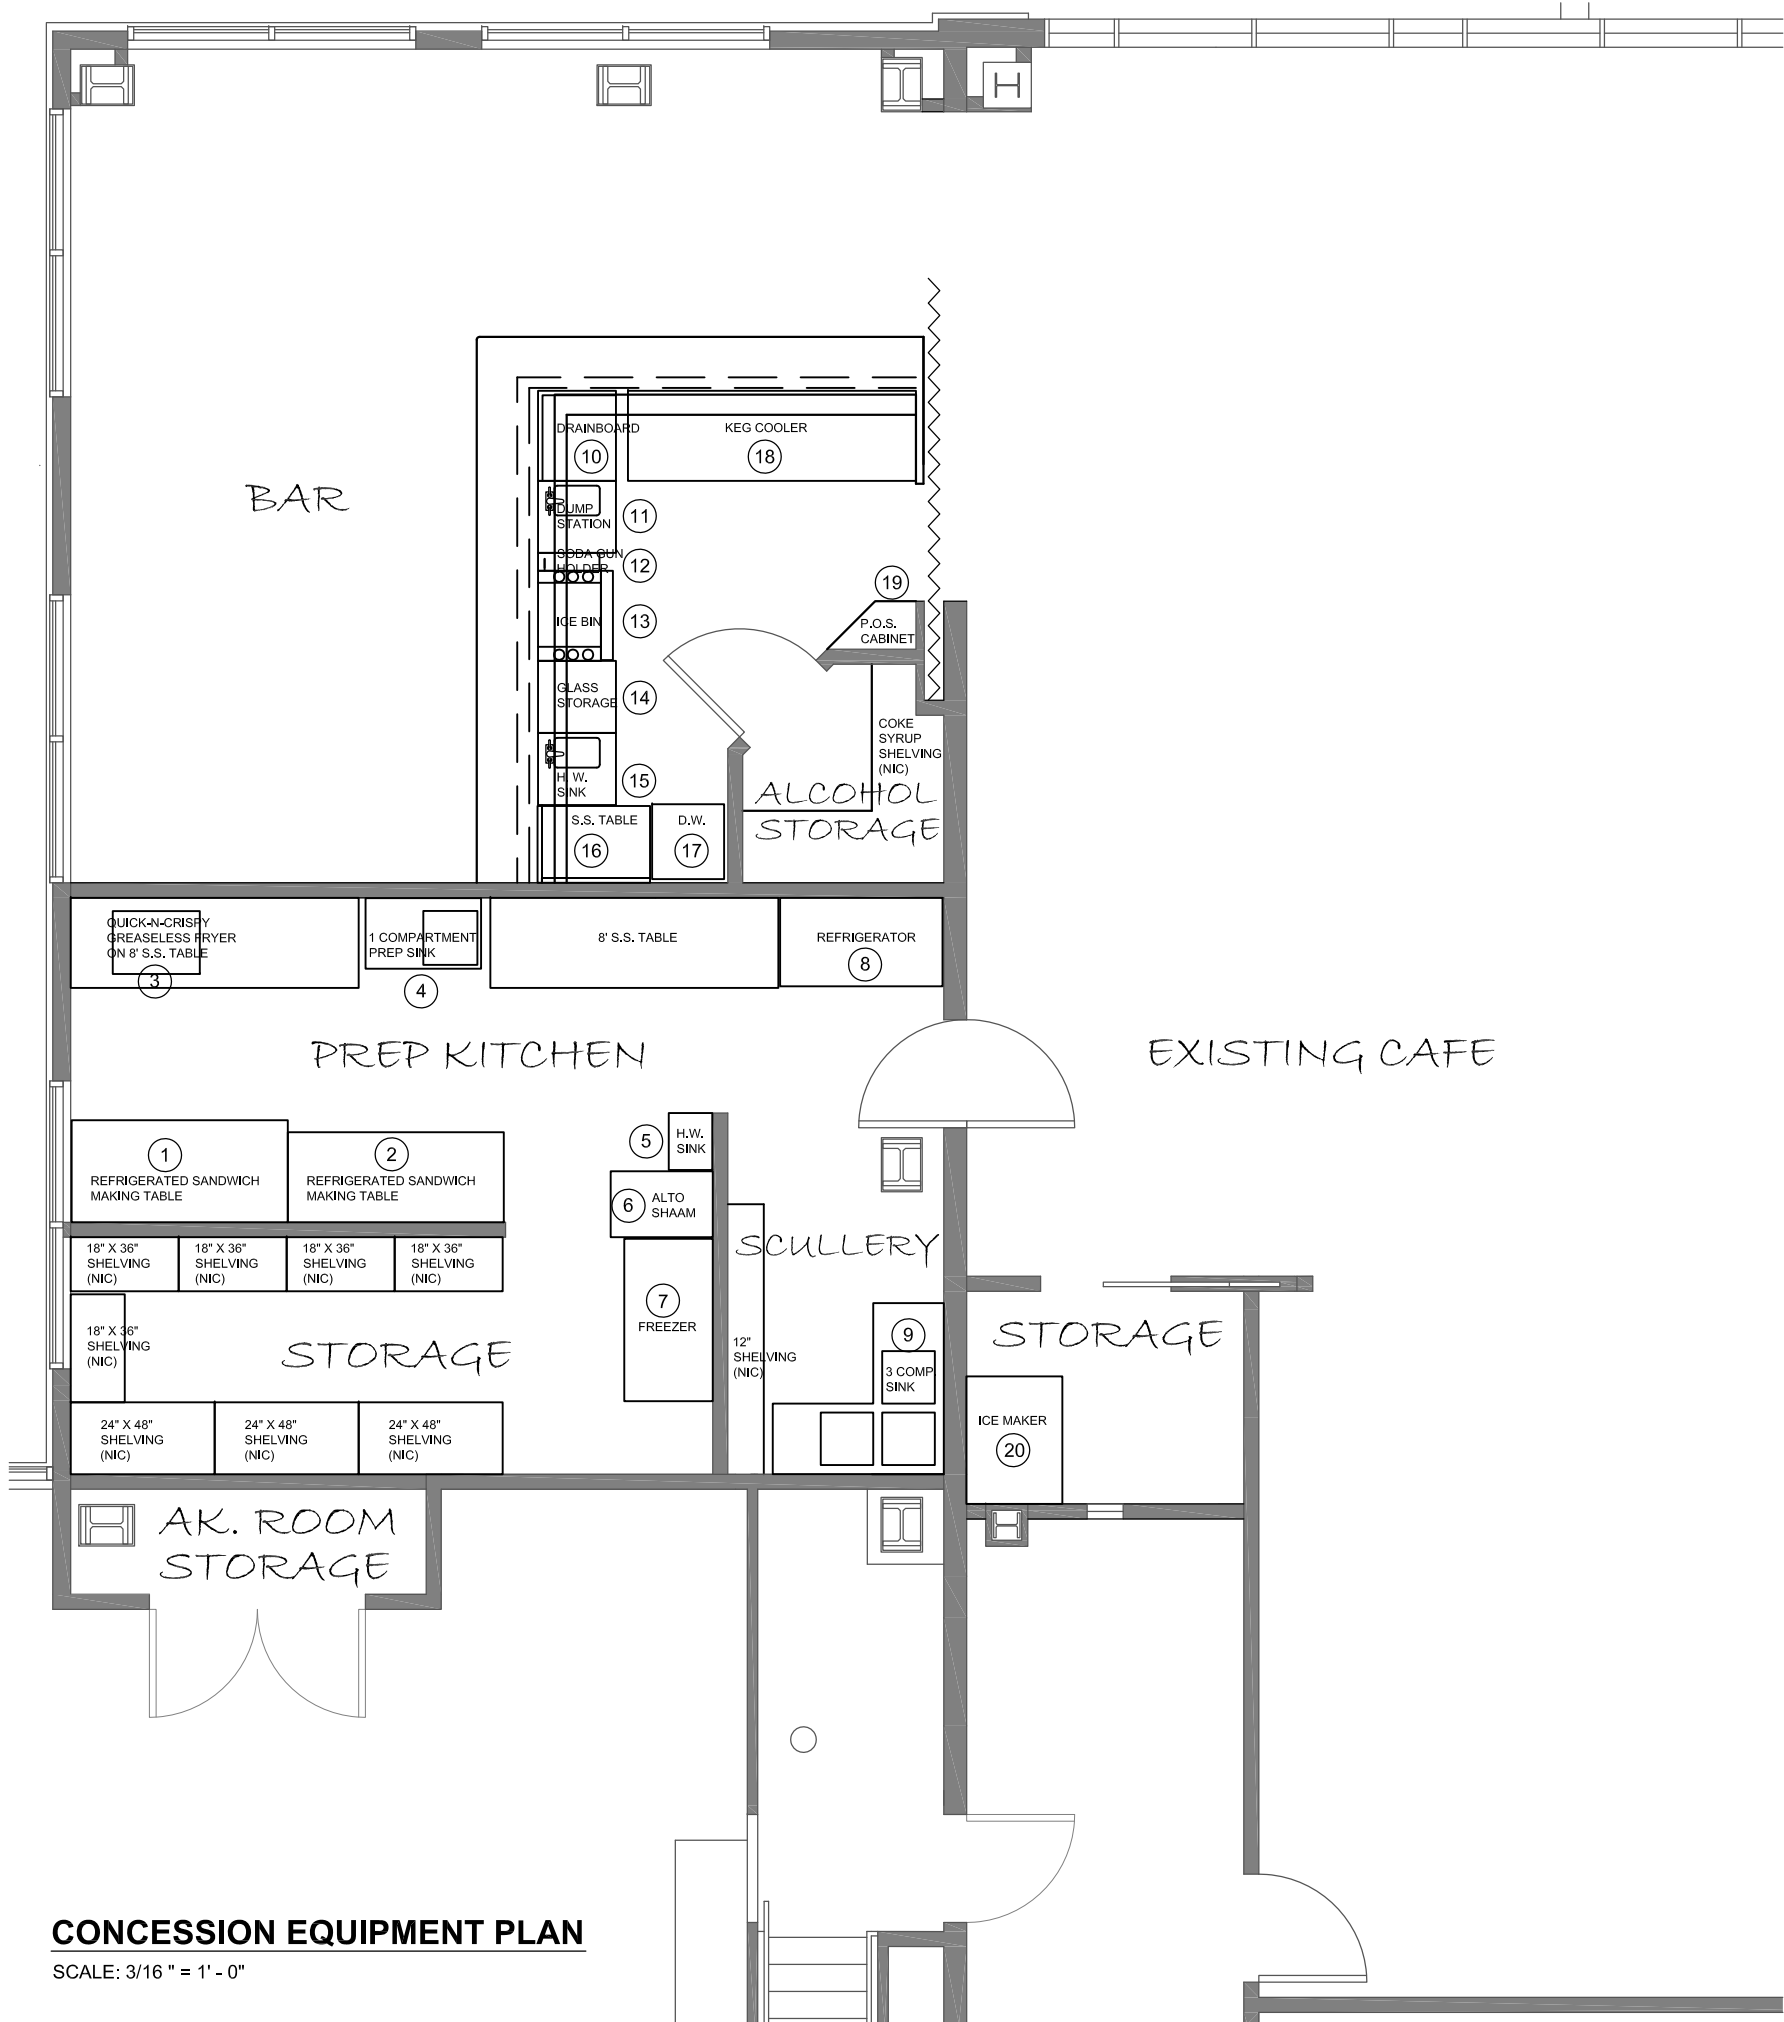

CONCESSION EQUIPMENT PLAN

SCALE: 3/16" = 1' - 0"



JUNEAU AIRPORT
PROJECT OFFICE
1873 Shell Simmons Drive
Juneau, Alaska 99801
phone: 907-789-7821
fax: 907-789-1227
www.juneau.org/airport

City & Borough of Juneau
Juneau International Airport
CONCESSIONS EXPANSION
Juneau, Alaska

CONTRACT NO.:
E15-195

 
 
 
 
 
 
 
BID

DATE:
FEBRUARY 27, 2015
REVISIONS:

SHEET TITLE:
EQUIPMENT
PLAN / LEGEND

FILE: 1382.80L

K001

SYMBOLS			
--- CR --- CR ---	CR	CONDENSATE RETURN	
--- GR --- GR ---	GR	GROUND SOURCE WATER RETURN	
----- GS -----	GS	GROUND SOURCE WATER SUPPLY	
----- PC -----	PC	PUMPED CONDENSATE	
----- CW -----	CW	COLD WATER	
----- HW -----	HW	HOT WATER	
----- HWR -----	HWR	HOT WATER RECIRCULATING	
--- V --- V --- V ---	V	VENT	
----- W -----	W	WASTE, SOIL, DRAINAGE	
----- HS -----	HS	HEATING SUPPLY	
--- HR --- HR ---	HR	HEATING RETURN	
		GATE VALVE OR BALL VALVE	
		CHECK VALVE	
		UNION	
		GLOBE VALVE OR ISOLATING BALL VALVE	
	DV	DRAIN VALVE	
		PITCHED DOWN	
		REDUCER	
		CAPPED OR PLUGGED	
	CO	CLEANOUT	
		TEST PORT/PLUG	
	PRV	PRESSURE REDUCING VALVE	
		FLEXIBLE CONNECTION	
		STRAINER	
		POINT OF CONNECTION OR REMOVAL	
		CONSTRUCTION NOTE	
		FLOWSETTER NUMBER	
		THERMOSTAT -- IMMERSION, ROOM	
		THERMOMETER	
		PRESSURE GAGE	
		PRESSURE SWITCH	
		CONTROL SWITCH	
		DIAMETER	
		CENTER LINE	
		ACCESS DOOR	
		EXISTING	
		RELOCATE	
		REMOVE	
AFF		ABOVE FINISHED FLOOR	
AV		AUTOMATIC VALVE	
CFM		CUBIC FEET PER MINUTE	
CO		CLEANOUT	
DV		DRAIN VALVE	
DW		DISHWASHER	
EA		EXHAUST AIR	
EAD		EXHAUST AIR DAMPER	
EG		EXHAUST GRILLE	
ESP		EXTERNAL STATIC PRESSURE	
FD		FLOOR DRAIN	
FS		FLOOR SINK	
FT		FEET	
GI		GREASE INTERCEPTOR	
GPH		GALLONS PER HOUR	
HP		HEAT PUMP	
IAW		IN ARCHITECTURAL WORK	
IEW		IN ELECTRICAL WORK	
MB		MULTI BLADE DAMPER	
MXB		MIXING BOX	
NIC		NOT IN CONTRACT	
NIM		NOT IN MECHANICAL	
OD		OUTSIDE DIMENSION	
OAD		OUTSIDE AIR DAMPER	
OSA		OUTSIDE AIR	
PSI		POUNDS PER SQUARE INCH	
RA		RETURN AIR	
RD		ROOF DRAIN	
RL		ROOF DRAIN LEADER	
RG		RETURN GRILLE	
SA		SUPPLY AIR	
SG		SUPPLY GRILLE	
SPR		SPRINKLER	
T&P		TEMPERATURE AND PRESSURE RELIEF VALVE	
TSP		TOTAL STATIC PRESSURE	
TYP		TYPICAL	
VTR		VENT THROUGH ROOF	
WHA		WATER HAMMER ARRESTOR	

MECHANICAL NOTES:

- CODES & REGULATIONS: ALL WORK HEREUNDER SHALL BE STRICTLY IN CONFORMANCE WITH APPLICABLE CODES AND REGULATIONS. ALL WORK SHALL BE IN ACCORDANCE WITH THE 2009 INTERNATIONAL FIRE CODE, 2009 INTERNATIONAL MECHANICAL CODE, 2009 UNIFORM PLUMBING CODE, 2009 INTERNATIONAL BUILDING CODE, NFPA, AND CITY AND BOROUGH OF JUNEAU MODIFICATIONS INSOFAR AS MINIMUM REQUIREMENTS ARE CONCERNED, BUT THE DRAWINGS AND SPECIFICATIONS SHALL GOVERN IN CASE THE MINIMUM REQUIREMENTS ARE EXCEEDED. ALL ELECTRICAL EQUIPMENT SHALL BEAR THE UL LABEL. ALL SHEET METAL WORK TO BE DONE IN ACCORDANCE WITH SMACNA REQUIREMENTS. PROVIDE ALL TESTING REQUIREMENTS FOR MECHANICAL SYSTEMS AS REQUIRED AND WITNESSED BY ADMINISTRATIVE AUTHORITY.
- PROVIDE AS-BUILT DRAWINGS, TRAINING, AND OPERATING AND MAINTENANCE MANUALS TO OWNER.
- MECHANICAL CONTRACTOR TO ROUGH-IN AND CONNECT ALL HOT AND COLD WATER SUPPLY PIPING, WASTE, DRAINAGE, AND VENT AS REQUIRED FOR ALL PLUMBING FIXTURES AND OTHER FOOD SERVICE EQUIPMENT PROVIDED BY THE CONTRACTOR OR BY THE OWNER. MECHANICAL CONTRACTOR TO INSTALL ALL LOOSE EQUIPMENT SUCH AS FITTINGS, VALVES, AND FAUCETS PROVIDED WITH THE FOOD SERVICE EQUIPMENT. THE MECHANICAL CONTRACTOR IS TO PROVIDE ALL CONNECTING PIPING AND ALL TRAPS, TRIM, AND RELATED PLUMBING APPURTENANCES NOT SUPPLIED WITH THE FOOD SERVICE EQUIPMENT BUT REQUIRED TO COMPLETE THE EQUIPMENT INSTALLATION. INSTALL ISOLATING VALVE OR STOP ON EACH FIXTURE OR EQUIPMENT SUPPLY WHETHER SHOWN OR NOT.
- COORDINATE AND FIELD VERIFY ALL ROUGH-IN DIMENSIONS, SIZES, EQUIPMENT LOCATIONS, AND CONNECTION REQUIREMENTS WITH THE ACTUAL EQUIPMENT SUPPLIED BY THE FOOD SERVICE CONTRACTOR OR BY THE OWNER FOR A COMPLETE INSTALLATION. VERIFY ALL STRUCTURAL AND EXISTING CONDITIONS.
- ALL MATERIALS AND EQUIPMENT INTENDED FOR USE ON THIS PROJECT TO BE APPROVED IN ADVANCE BY THE OWNER.
- 115°F HW IS SUPPLIED TO DISHWASHER AND GLASS WASHER. BOOSTER HEATER REQUIRED TO BOOST HW TEMPERATURE FROM 115°F TO 180°F. COORDINATE REQUIREMENTS WITH OWNER.
- COORDINATE RESPONSIBILITY FOR PROVISION OF EQUIPMENT/FIXTURES WITH OWNER. OWNER WILL BE PURCHASING SOME OF THE EQUIPMENT/FIXTURES FOR INSTALLATION BY THE CONTRACTOR.
- INSTALL ALL EQUIPMENT PER MANUFACTURER'S INSTRUCTIONS.
- REVISE EXISTING WET SPRINKLER SYSTEM FOR NEW LAYOUT PER NFPA 13 AND CBJ REQUIREMENTS. REVISE SPRINKLER HEAD LOCATIONS AND ADD ADDITIONAL HEADS AS NEEDED. SPRINKLER PIPING SHALL BE SCH. 40 STEEL, THREADED. PROVIDE SHOP/AS-BUILT DRAWINGS. COORDINATE WITH OWNER OF BUILDING FOR SHUTDOWNS.
- ACCESSIBILITY: MECHANICAL SYSTEMS AND WORK SHALL NOT IMPEDE ACCESS TO EXISTING EQUIPMENT AND FUNCTIONS REQUIRING SERVICE. COORDINATE ONSITE WITH EXISTING CONDITIONS AND ADJUST ACCORDINGLY

PLUMBING SCHEDULE

EQUIPMENT	DESIGN MANUFACTURER	CONTROLS/OPTIONS
FLOOR SINK, FS-1	MIFAB FS1520	8"x8"x6" DEEP FLOOR SINK. 2" OUTLET. ACID RESISTANT PORCELAIN ENAMEL WITH ALUMINUM DOME STRAINER. 1/2 LOOSE SET GRATE WITH SQUARE OPENINGS.
FLOOR SINK, FS-2	MIFAB FS1730	12"x12"x8" DEEP FLOOR SINK. 3" OUTLET. ACID RESISTANT PORCELAIN ENAMEL WITH ALUMINUM DOME STRAINER. 1/2 LOOSE SET GRATE WITH SQUARE OPENINGS.
FLOOR DRAIN, FD-1	MIFAB F1220	5" DIAMETER FLOOR DRAIN NICKEL BRONZE STRAINER. GALVANIZED CAST-IRON BODY. FOR CORE DRILLED APPLICATION.
GREASE INTERCEPTOR, GI-1	MIFAB MI-G-SD	HYDRO MECHANICAL GREASE INTERCEPTOR. 20 GPM. 40 LBS GREASE CAPACITY. ASME A112.14.3 TESTED AND CERTIFIED. VENTED FLOW CONTROL FITTING. GREASE DRAW-OFF VALVE. POWDER EPOXY COATED INSIDE AND OUTSIDE. 10 GAUGE STEEL.
PRESSURE REDUCING VALVE, PRV	MIFAB	LOW PRESSURE TYPE WITH 10 PSI TO 35 PSI ADJUSTABLE DISCHARGE RANGE. SET AT 20 PSI FOR DISHWASHER. SET AT 10 PSI FOR BEER COOLER.
TRAP PRIMER	MIFAB MR500	BRASS TRAP SEAL PRIMER. 6 DRAIN CAPACITY. MIFAB MI-DU DISTRIBUTION UNIT.

DIFFUSER/GRILLE SCHEDULE


EQUIPMENT	DESIGN MANUFACTURER	CONTROLS/OPTIONS
SG-1	TITUS TDCA-AA	ALUMINUM CEILING DIFFUSER. 24x24 LAY-IN PANEL WITH LOUVERED FACE AND ROUND NECK (LOUVER FACE AND ROUND NECK SIZES AS SHOWN ON DRAWINGS). ADJUSTABLE DISCHARGE.
RG-1/EG-1	TITUS 350FL	ALUMINUM LOUVERED RETURN GRILLE. 35° DEFLECTION. LONG BLADES. 3/4-INCH BLADE SPACING.

GROUND SOURCE HEAT PUMP SCHEDULE

EQUIPMENT	AREA SERVED	NOMINAL COOLING OUTPUT MBH	BRINE FLOW RATE GPM	AIR VOLUME CFM	DESIGN MANUFACTURER: MODEL #	FEATURES	ELECTRICAL CHARACTERISTICS	NOTES
HP-35	KITCHEN PREP 5	36	7.5	990	CLIMATEMASTER TRANQUILITY TS SERIES TSH036CFP18ULPS	VARIABLE SPEED FAN. ECM MOTOR	460 VOLT, 3 PHASE, 9.7 MCA	CONTROLS: DXM WITH MPC. UNIT SHALL MATCH EXISTING TSH SERIES HEAT PUMPS INSTALLED IN 2009 RENOVATION PROJECT.

MECHANICAL SHEET LIST

NUMBER	TITLE
M001	SYMBOLS & NOTES
M101	DEMO PARTIAL 1ST FLOOR PIPING
M102	DEMO PARTIAL 2ND FLOOR PIPING
M103	DEMO PARTIAL 2ND FLOOR DUCTWORK
M201	PARTIAL 1ST FLOOR PIPING
M202	PARTIAL 2ND FLOOR PIPING
M203	PARTIAL 2ND FLOOR DUCTWORK
M301	PIPING DIAGRAMS
M401	DETAILS & DIAGRAMS

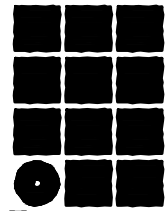

Jensen
Yorba
Lott
Inc.


522 West 10th Street
Juneau, Alaska 99801
phone 907-586-1070
fax 907-586-3959
jensenyorbalott.com



MURRAY &
ASSOCIATES P.C.
CONSULTING
ENGINEERS



P O BOX 21081
JUNEAU, AK 99802
MURRAYPC.COM
TEL: 907 780-6151 FAX: 907 780-6182

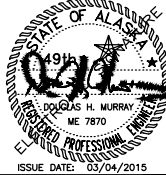

City & Borough of Juneau
Juneau International Airport
CONCESSIONS EXPANSION
CBJ Contract No. E15-195
Juneau, Alaska

BID

REVISIONS



SHEET TITLE

SYMBOLS & NOTES


DATE: February 27, 2015

FILE: 11050/10-330

M001

DEMOLITION NOTES:


△ REMOVE 1-1/4"HS&HR AND LOWER TO ALLOW FOR NEW WASTE PIPING INSTALLATION.

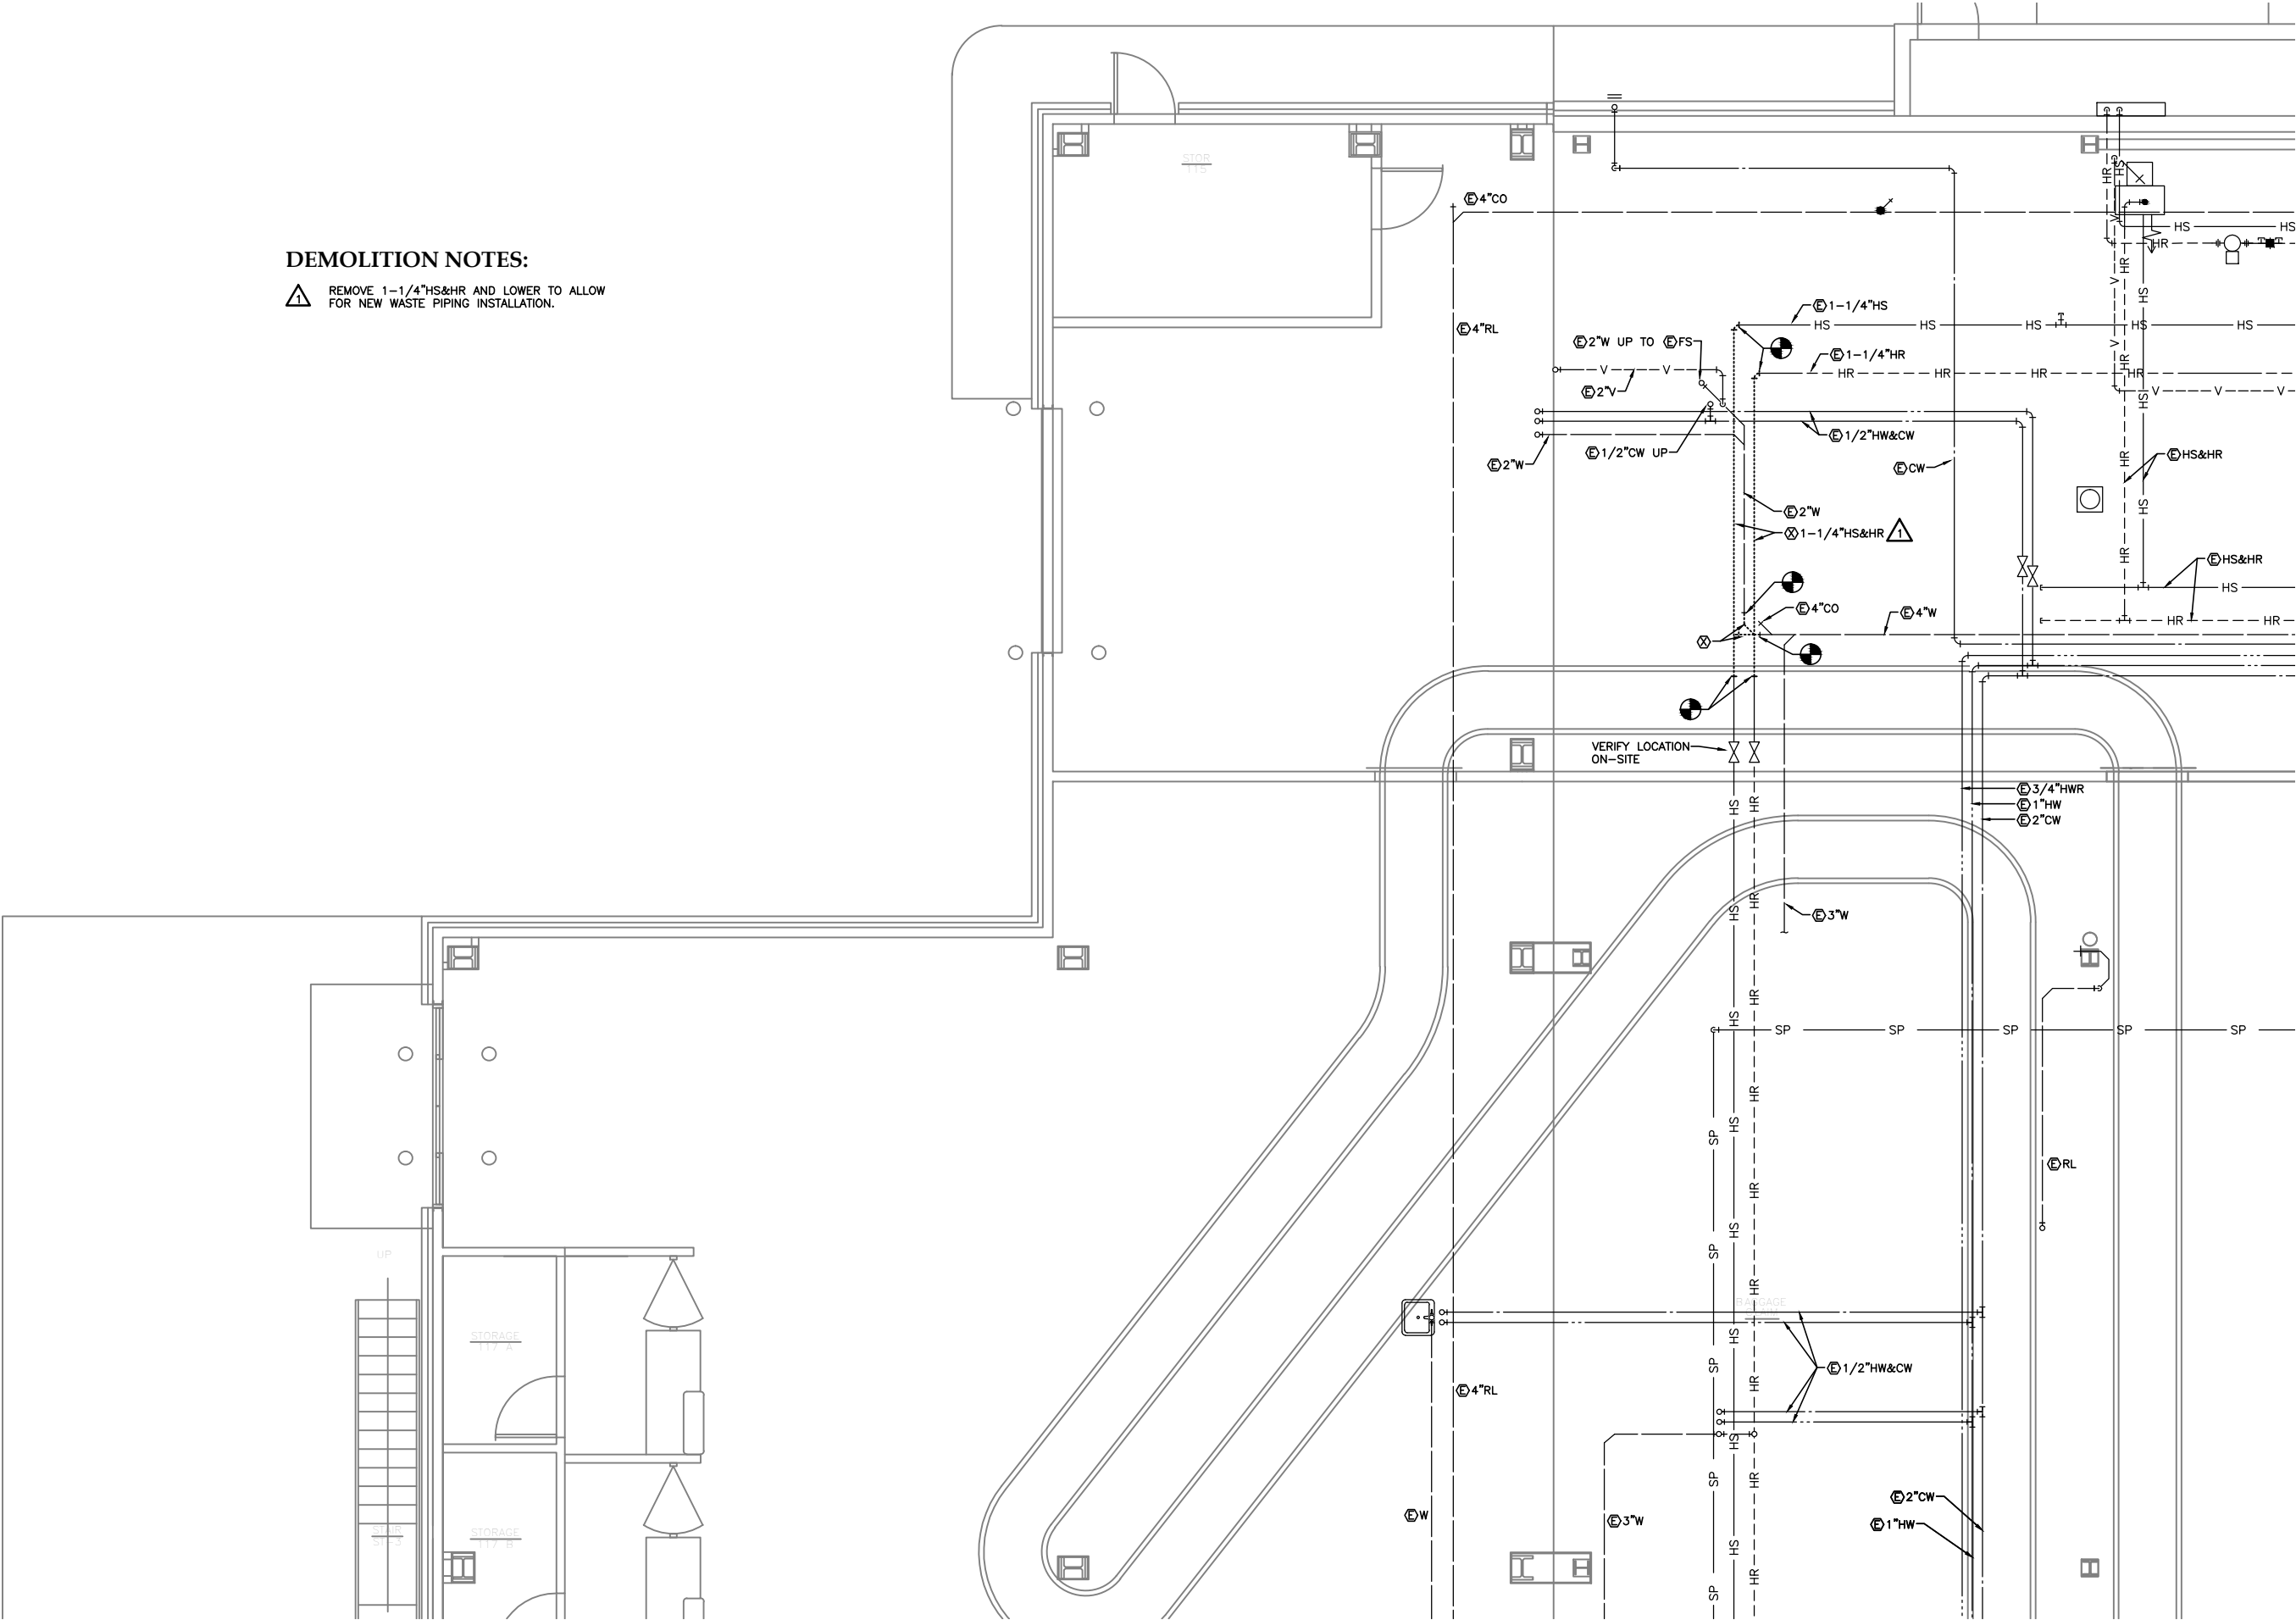

1 DEMO PARTIAL 1ST FLOOR PIPING

SCALE: 0 2' 4' 8'



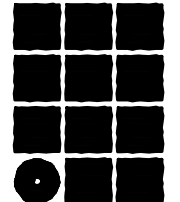

**Jensen
Yorba
Lott
Inc.**


522 West 10th Street
Juneau, Alaska 99801
phone 907-586-1070
fax 907-586-3959
jensenyorbalott.com



MURRAY &
ASSOCIATES P.C.
CONSULTING
ENGINEERS



P.O. BOX 21081
JUNEAU, AK 99802
MURRAYPC.COM
TEL: 907 780-6151 FAX: 907 780-6182

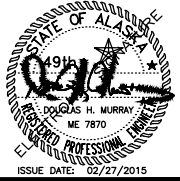


City & Borough of Juneau
Juneau International Airport
CONCESSIONS EXPANSION
CBJ Contract No. E15-195
Juneau, Alaska

BID
REVISIONS
△
△
△

SHEET TITLE
DEMO PARTIAL
1ST FLOOR PIPING


DATE: February 27, 2015
FILE: 11050/10-330

M101

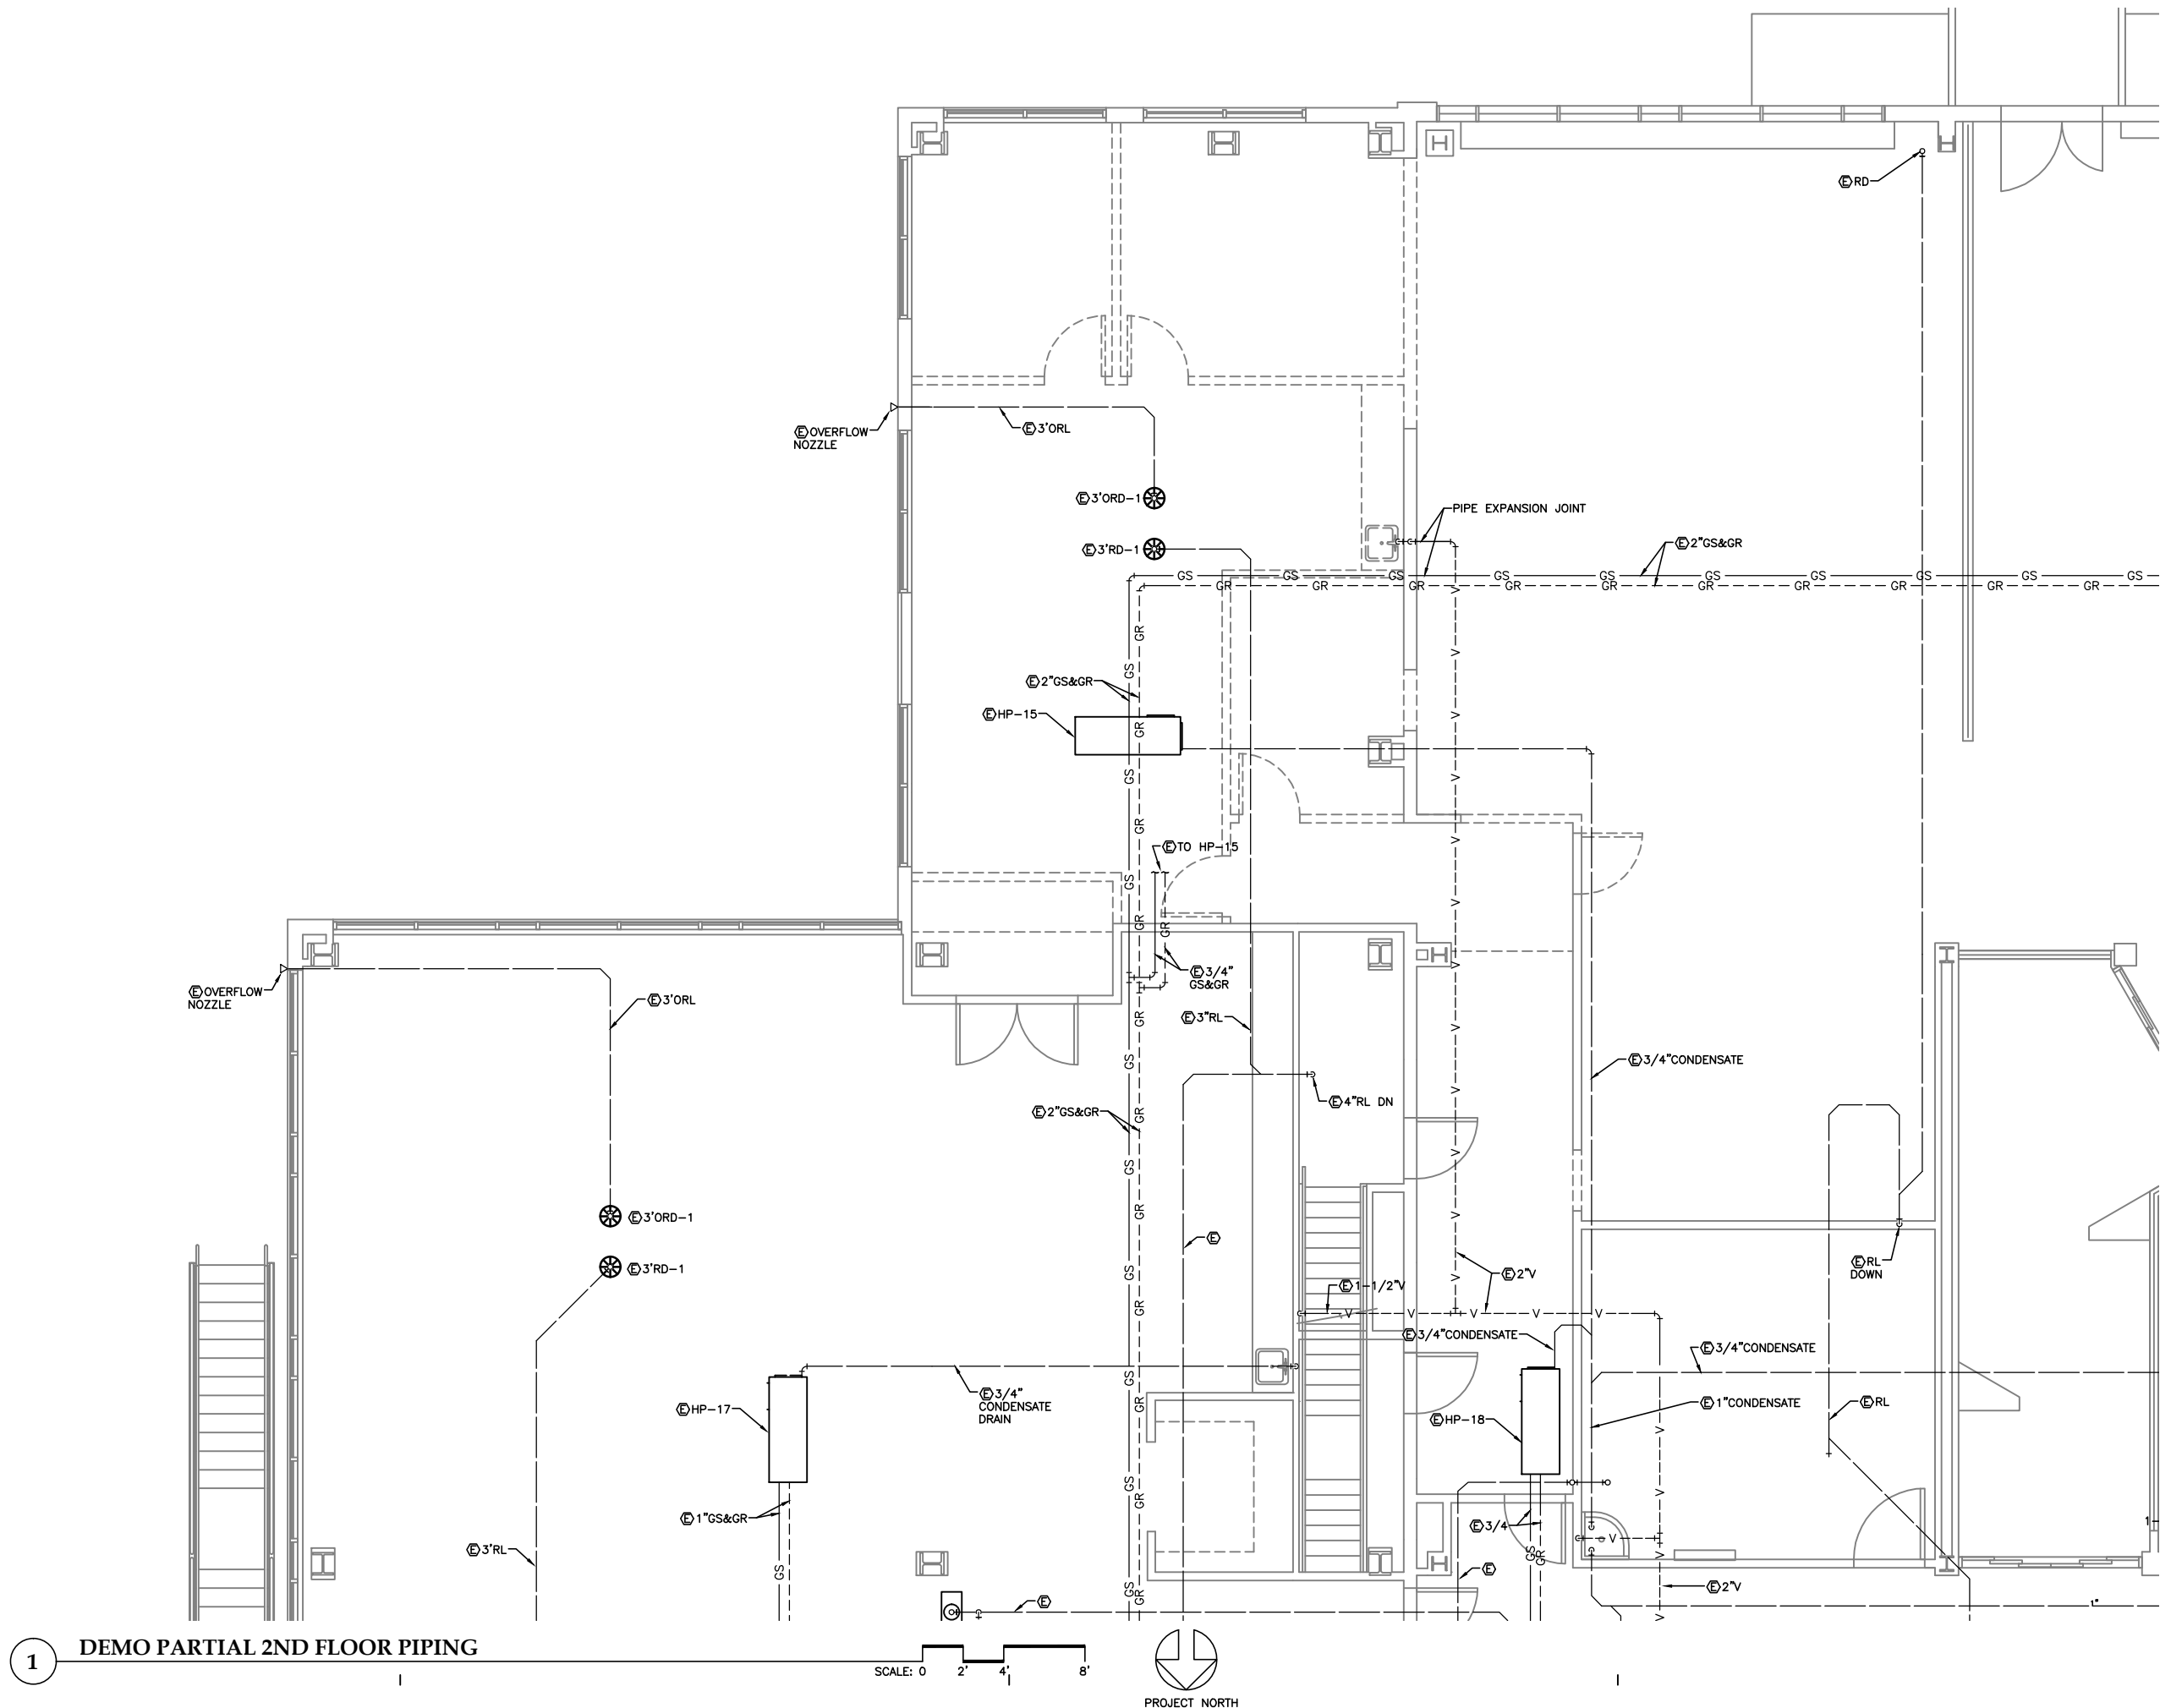

1 DEMO PARTIAL 2ND FLOOR PIPING

SCALE: 0 2' 4' 8'

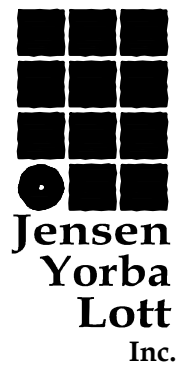


522 West 10th Street
Juneau, Alaska 99801
phone 907-586-1070
fax 907-586-3959
jensenyorbalott.com



MURRAY &
ASSOCIATES P.C.
CONSULTING
ENGINEERS



P.O. BOX 21081
JUNEAU, AK 99802
MURRAYPC.COM
TEL: 907 780-6151 FAX: 907 780-6182

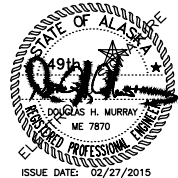

City & Borough of Juneau
Juneau International Airport
CONCESSIONS EXPANSION
CBJ Contract No. E15-195
Juneau, Alaska


BID



SHEET TITLE
DEMO PARTIAL
2ND FLOOR PIPING

DATE: February 27, 2015
FILE: 11050/10-330

M102

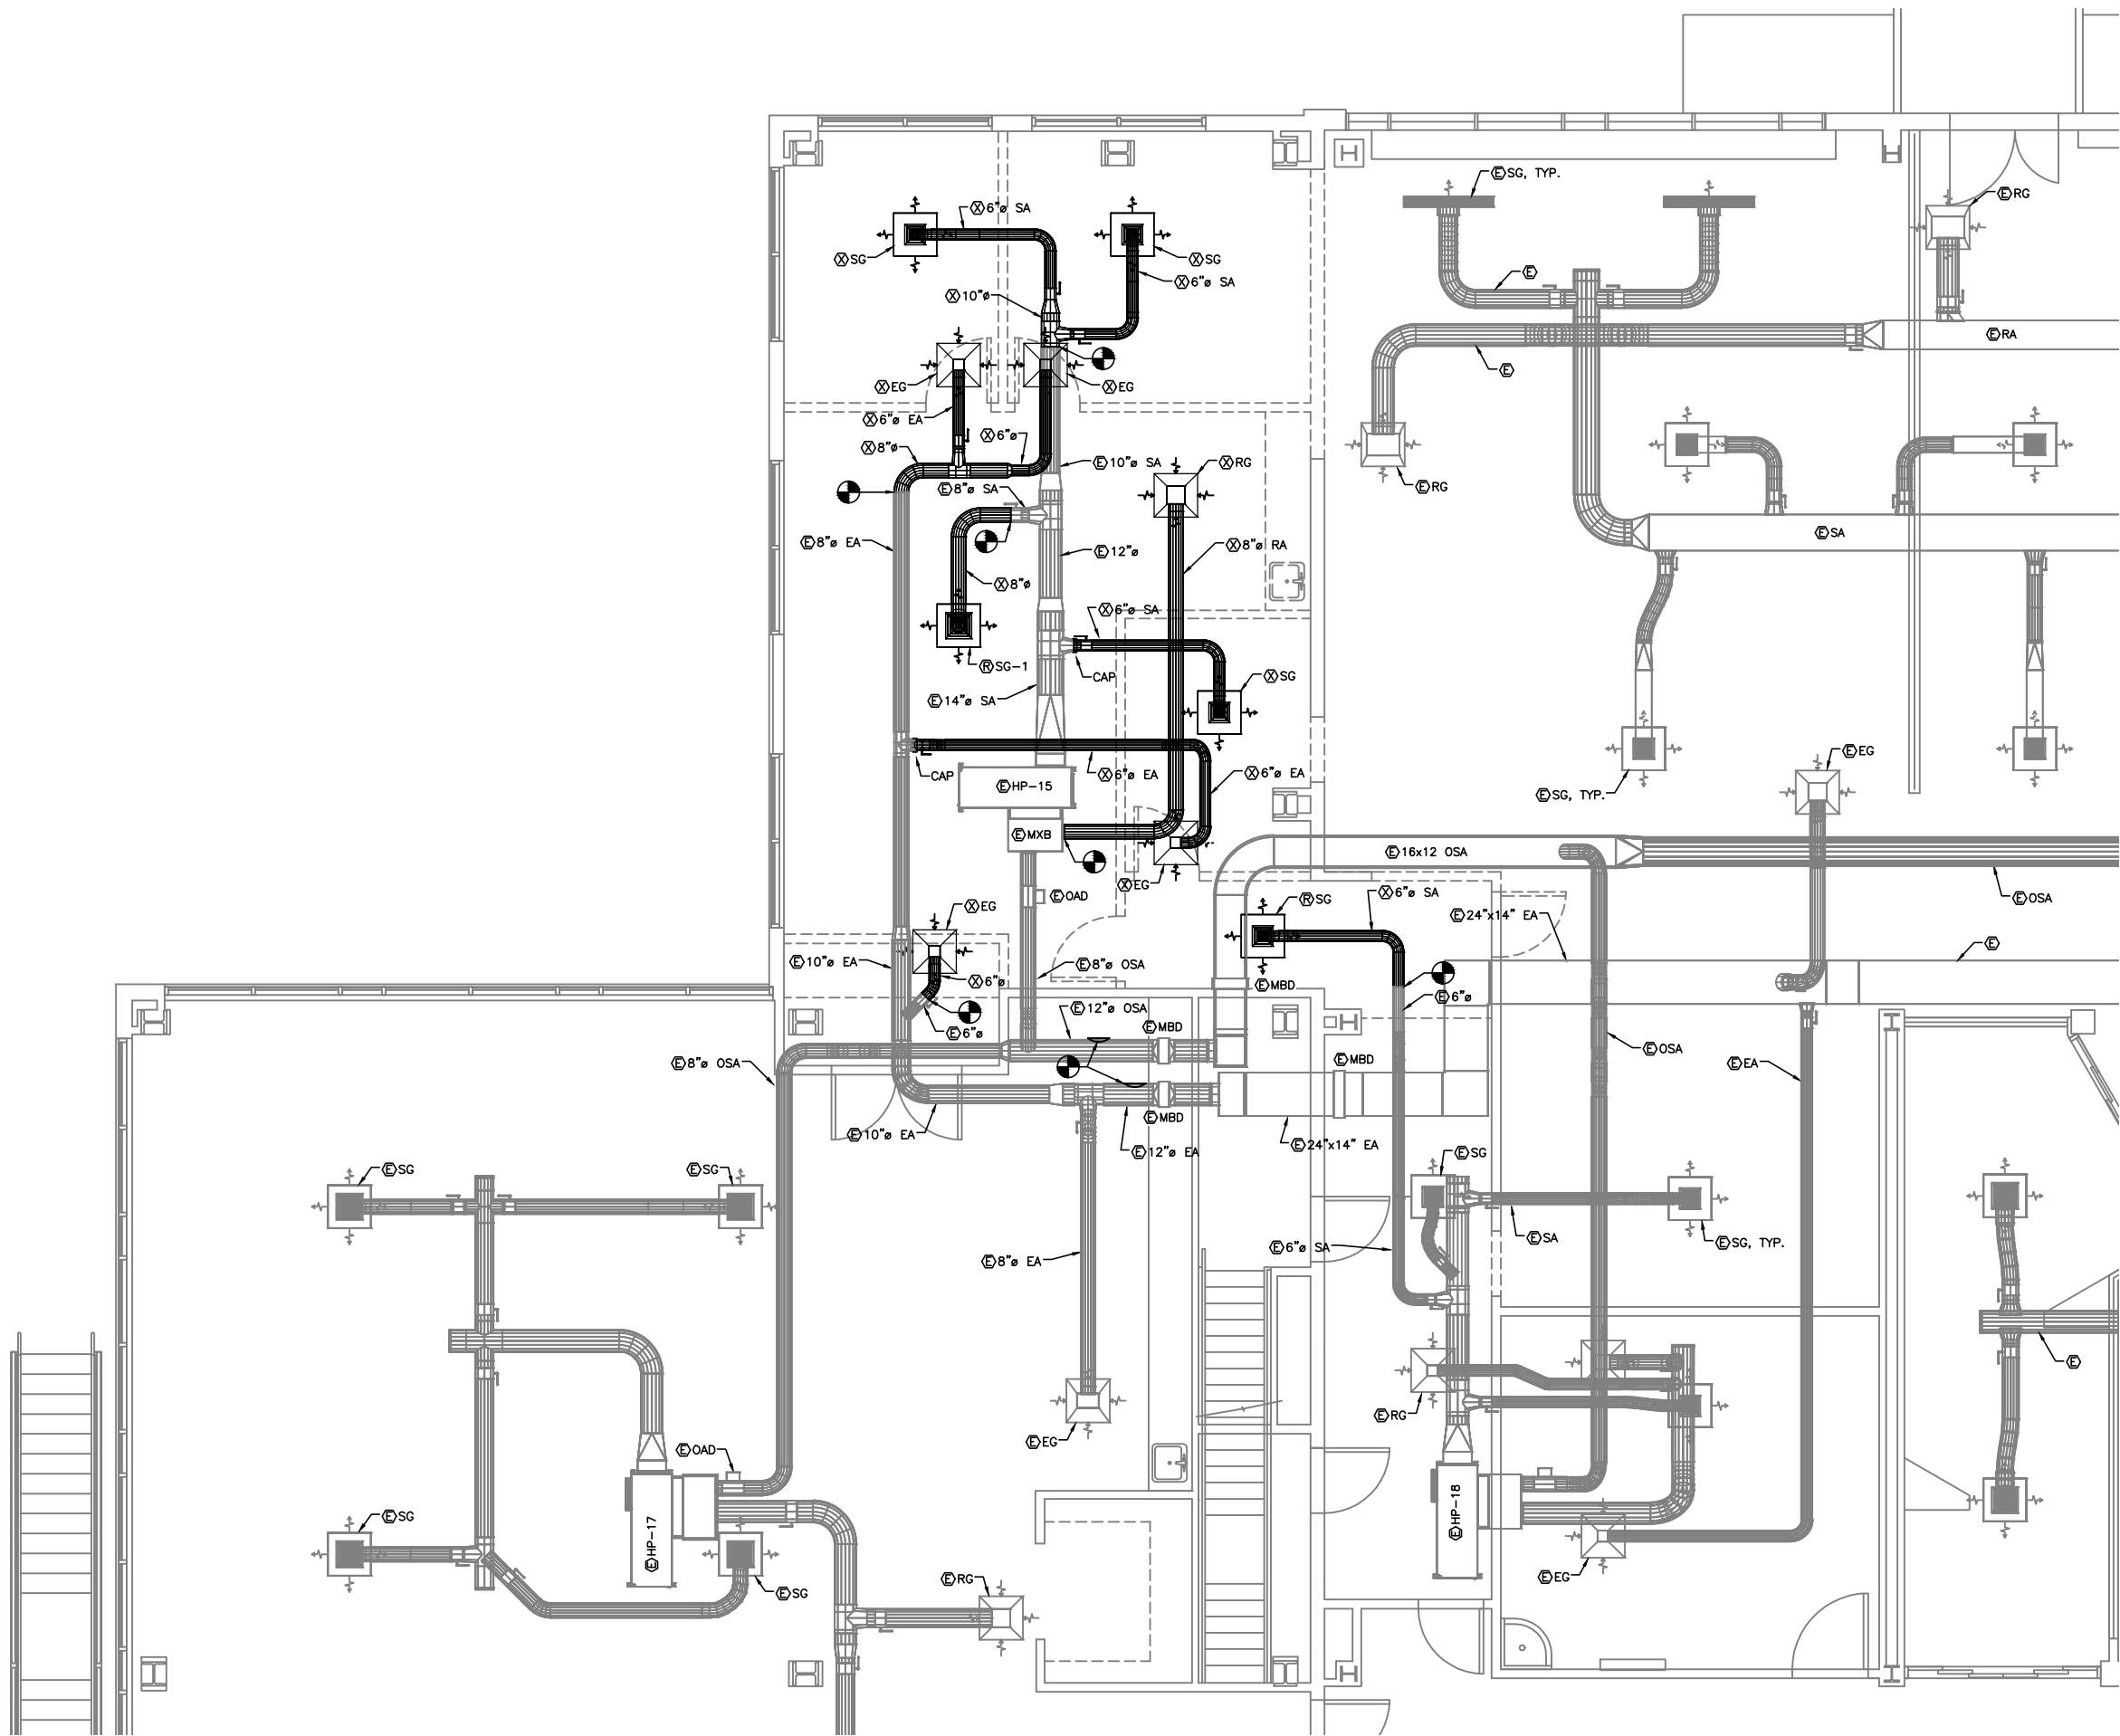

1 DEMO PARTIAL 2ND FLOOR DUCTWORK

SCALE: 0 2' 4' 8'



Jensen Yorba Lott Inc.


522 West 10th Street
Juneau, Alaska 99801
phone 907-586-1070
fax 907-586-3959
jensenyorbalott.com



MURRAY & ASSOCIATES P.C.
CONSULTING ENGINEERS

MSA

P.O. BOX 21081
JUNEAU, AK 99802
MURRAYPC.COM
TEL: 907 780-6151 FAX: 907 780-6182

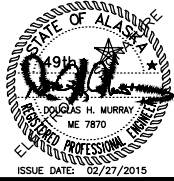


City & Borough of Juneau
Juneau International Airport
CONCESSIONS EXPANSION
CBJ Contract No. E15-195
Juneau, Alaska

BID
REVISIONS
△
△
△
SHEET TITLE
DEMO PARTIAL 2ND FLOOR DUCTWORK

DATE: February 27, 2015
FILE: 11050/10-330

M103

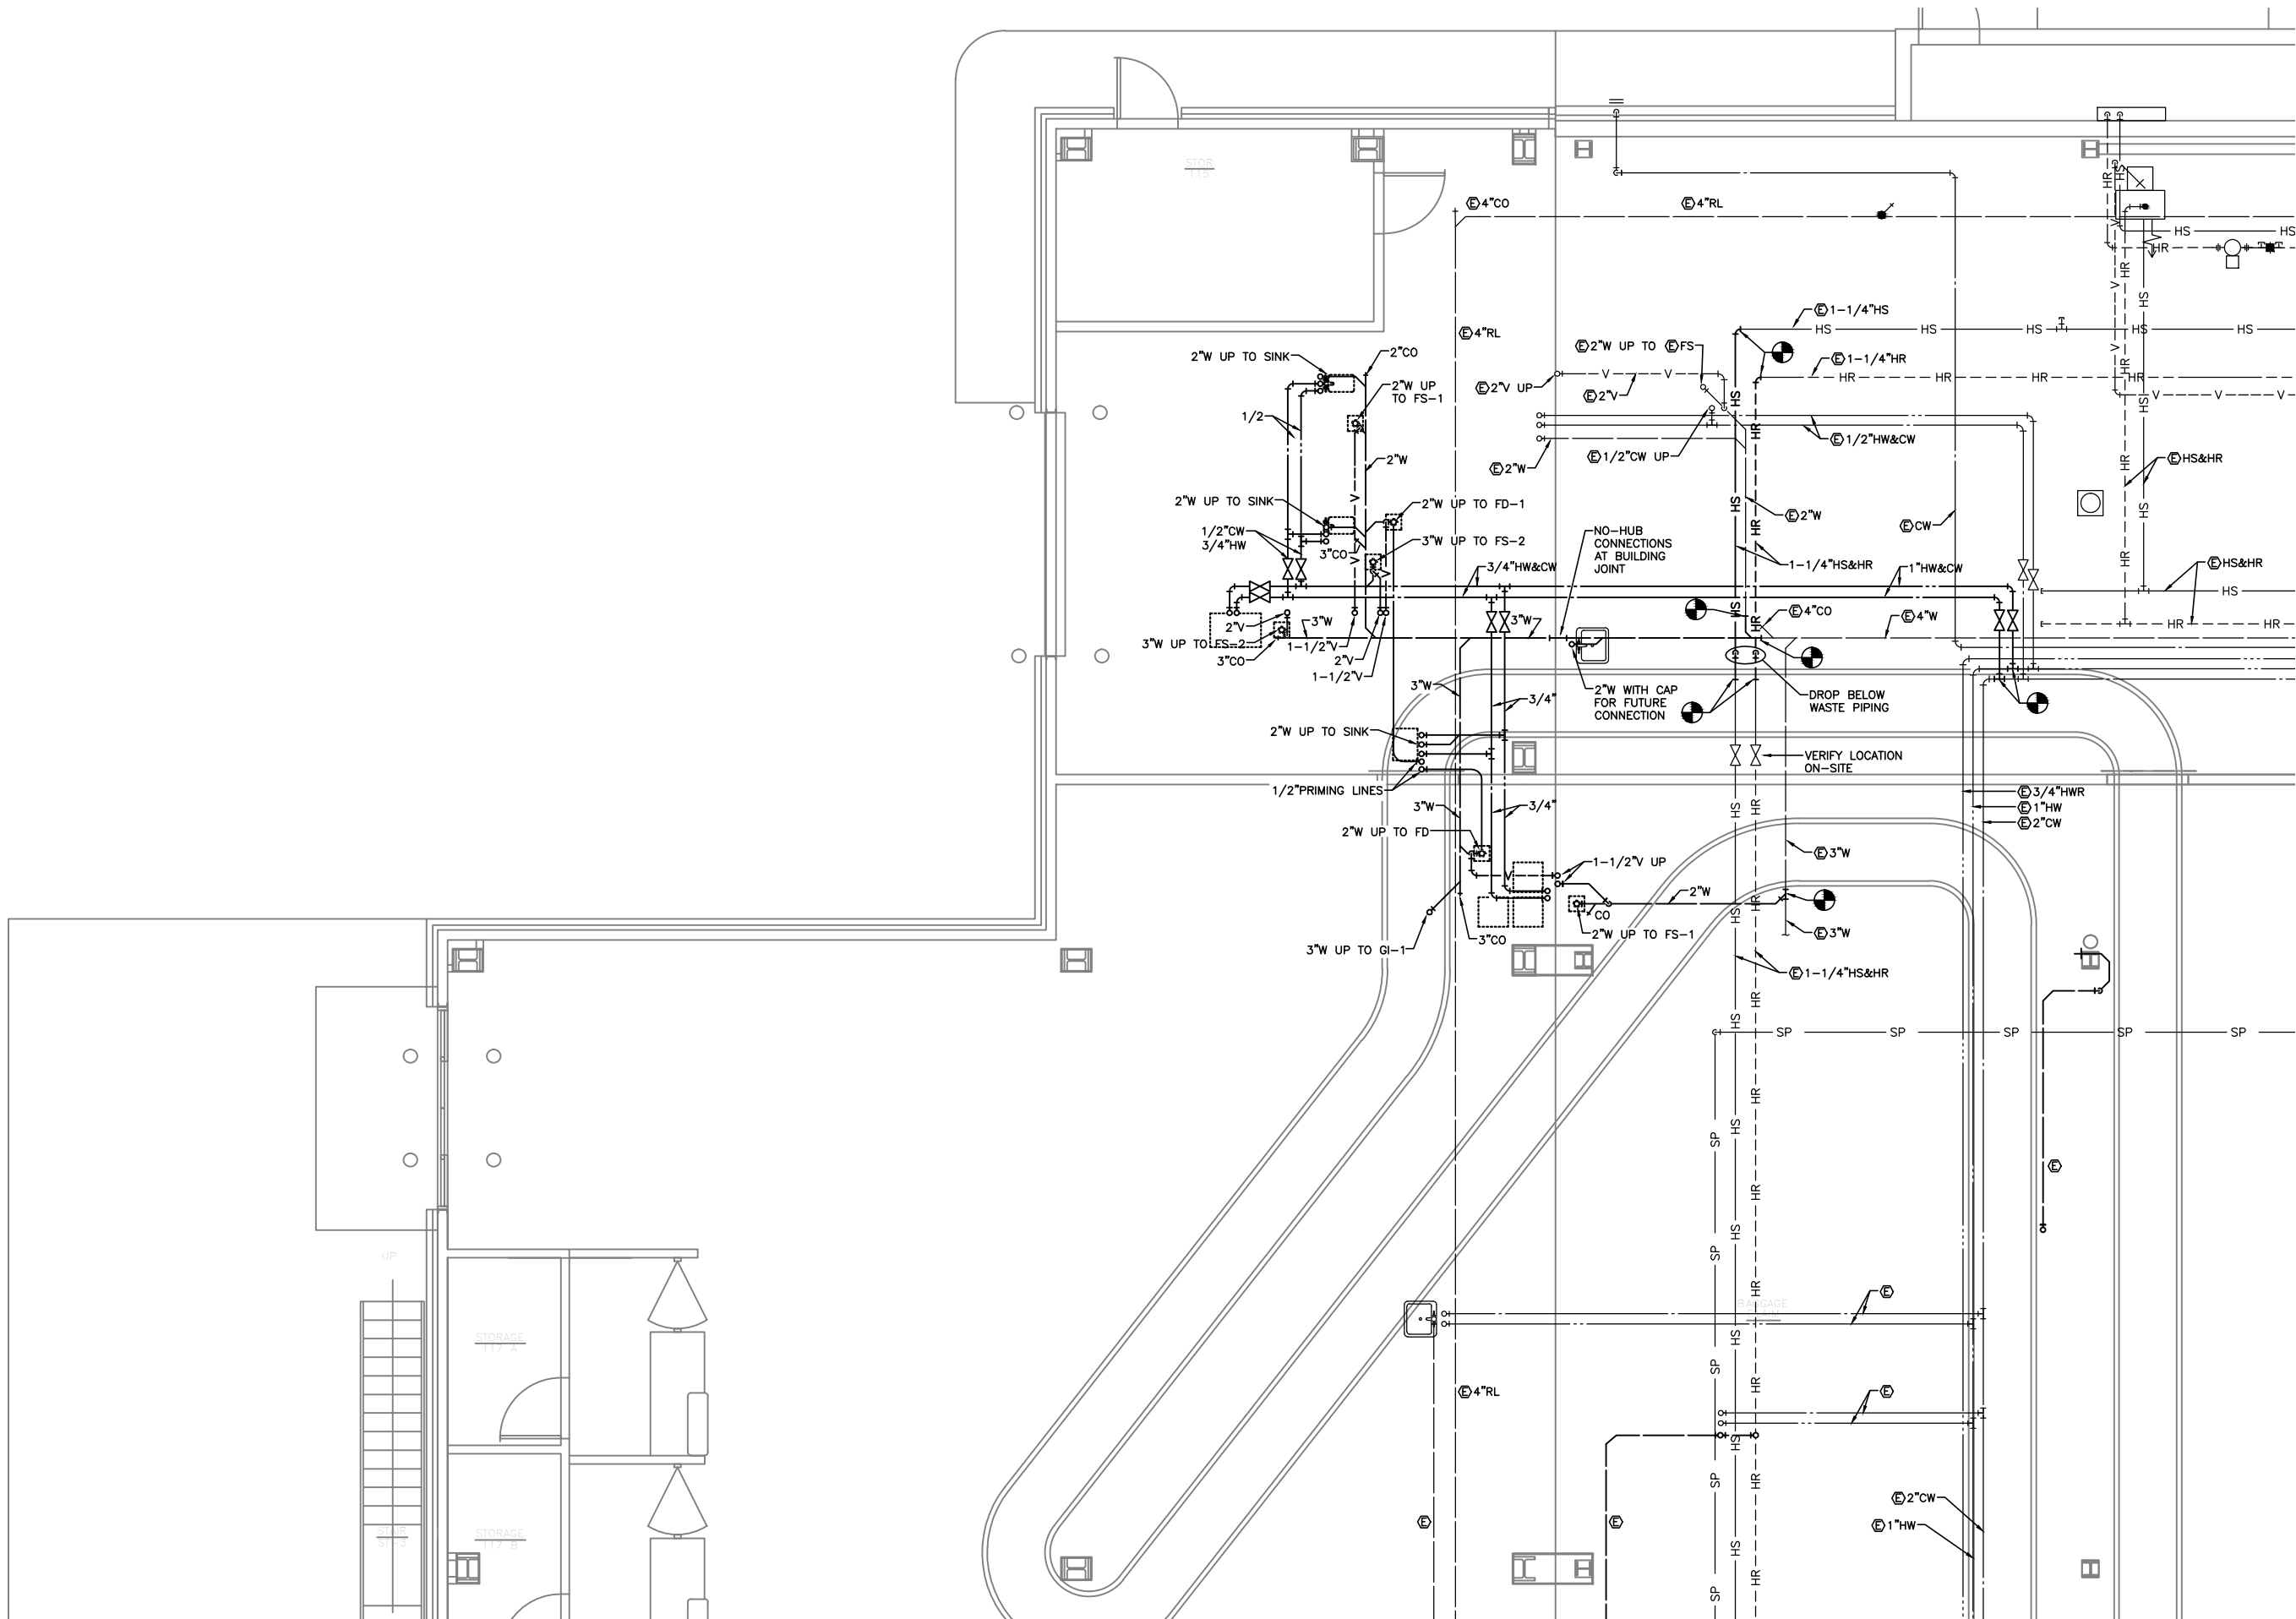

1 PARTIAL 1ST FLOOR PIPING

SCALE: 0 2' 4' 8'




Jensen Yorba Lott Inc.

522 West 10th Street
Juneau, Alaska 99801
phone 907-586-1070
fax 907-586-3959
jensenyorbalott.com



MURRAY & ASSOCIATES P.C.
CONSULTING ENGINEERS

P.O. BOX 21081
JUNEAU, AK 99802
MURRAYPC.COM
TEL: 907 780-6151 FAX: 907 780-6182

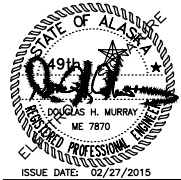

City & Borough of Juneau
Juneau International Airport
CONCESSIONS EXPANSION
CBJ Contract No. E15-195
Juneau, Alaska

BID

REVISIONS
△
△
△

SHEET TITLE
PARTIAL 1ST
FLOOR PIPING

DATE: February 27, 2015
FILE: 11050/10-330


M201

CONSTRUCTION NOTES:

1. INSTALL HP-35 FROM CEILING STRUCTURE WITH VIBRATION ISOLATORS ON ALL SUPPORTS. ROUTE 1"GS&GR PIPING TO HP-35 UNIT. CONNECT TO HP-35 WITH STAINLESS STEEL FLEXIBLE CONNECTIONS. INSTALL ISOLATING VALVES ON GS, GR AND STRAINER ON GS PIPING. INSTALL AUTOMATIC VALVE AND FLOW CONTROL VALVE IF PROVIDED LOOSE WITH EQUIPMENT.
2. PROVIDE AND INSTALL CONDENSATE PUMP. ROUTE 3/4"CONDENSATE PIPING TO EXISTING 3/4"CONDENSATE PIPING SERVING EXISTING HP-15.

SHEET NOTES:

1. SEE KITCHEN FOOD SERVICE (K) PLANS FOR ADDITIONAL INFORMATION.
2. ALL FIXTURE DESIGNATIONS, , RELATE TO EQUIPMENT ON FOOD SERVICE PLANS (K). SEE FOOD SERVICE PLANS FOR ALL REQUIREMENTS.
3. MECHANICAL CONTRACTOR TO ROUGH-IN AND CONNECT ALL HOT AND COLD WATER SUPPLY PIPING, WASTE, DRAINAGE, AND VENT AS REQUIRED FOR ALL PLUMBING FIXTURES AND OTHER FOOD SERVICE EQUIPMENT PROVIDED BY THE CONTRACTOR OR BY THE OWNER. MECHANICAL CONTRACTOR TO INSTALL ALL LOOSE EQUIPMENT SUCH AS FITTINGS, VALVES, AND FAUCETS PROVIDED WITH THE FOOD SERVICE EQUIPMENT. THE MECHANICAL CONTRACTOR IS TO PROVIDE ALL CONNECTING PIPING AND ALL TRAPS, TRIM, AND RELATED PLUMBING APPURTENANCES NOT SUPPLIED WITH THE FOOD SERVICE EQUIPMENT BUT REQUIRED TO COMPLETE THE EQUIPMENT INSTALLATION. INSTALL ISOLATING VALVE OR STOP ON EACH FIXTURE SUPPLY WHETHER SHOWN OR NOT.
4. COORDINATE AND FIELD VERIFY ALL ROUGH-IN DIMENSIONS, SIZES, EQUIPMENT LOCATIONS, AND CONNECTION REQUIREMENTS WITH THE ACTUAL EQUIPMENT SUPPLIED BY THE CONTRACTOR OR BY THE OWNER FOR A COMPLETE INSTALLATION. VERIFY ALL STRUCTURAL AND EXISTING CONDITIONS.
5. 115°F HW IS SUPPLIED TO DISHWASHER. BOOSTER HEATER REQUIRED TO BOOST HW TEMPERATURE FROM 115°F TO 180°F. COORDINATE REQUIREMENTS WITH OWNER AND GENERAL CONTRACTOR.
6. FLOOR SINKS, FLOOR DRAINS, AND GREASE INTERCEPTORS PROVIDED AND INSTALLED BY PLUMBING CONTRACTOR.
7. SEE PIPING DIAGRAM ON M301.
8. REVISE EXISTING WET SPRINKLER SYSTEM FOR NEW LAYOUT PER NFPA 13 AND CBJ REQUIREMENTS. REVISE SPRINKLER HEAD LOCATIONS AND ADD ADDITIONAL HEADS AS NEEDED. SPRINKLER PIPING SHALL BE SCH. 40 STEEL, THREADED. PROVIDE SHOP/AS-BUILT DRAWINGS. COORDINATE WITH OWNER OF BUILDING FOR SHUTDOWNS.
9. INSTALL HP UNIT AS REQUIRED BY MANUFACTURER AND AS INDICATED IN INSTALLATION MANUAL.

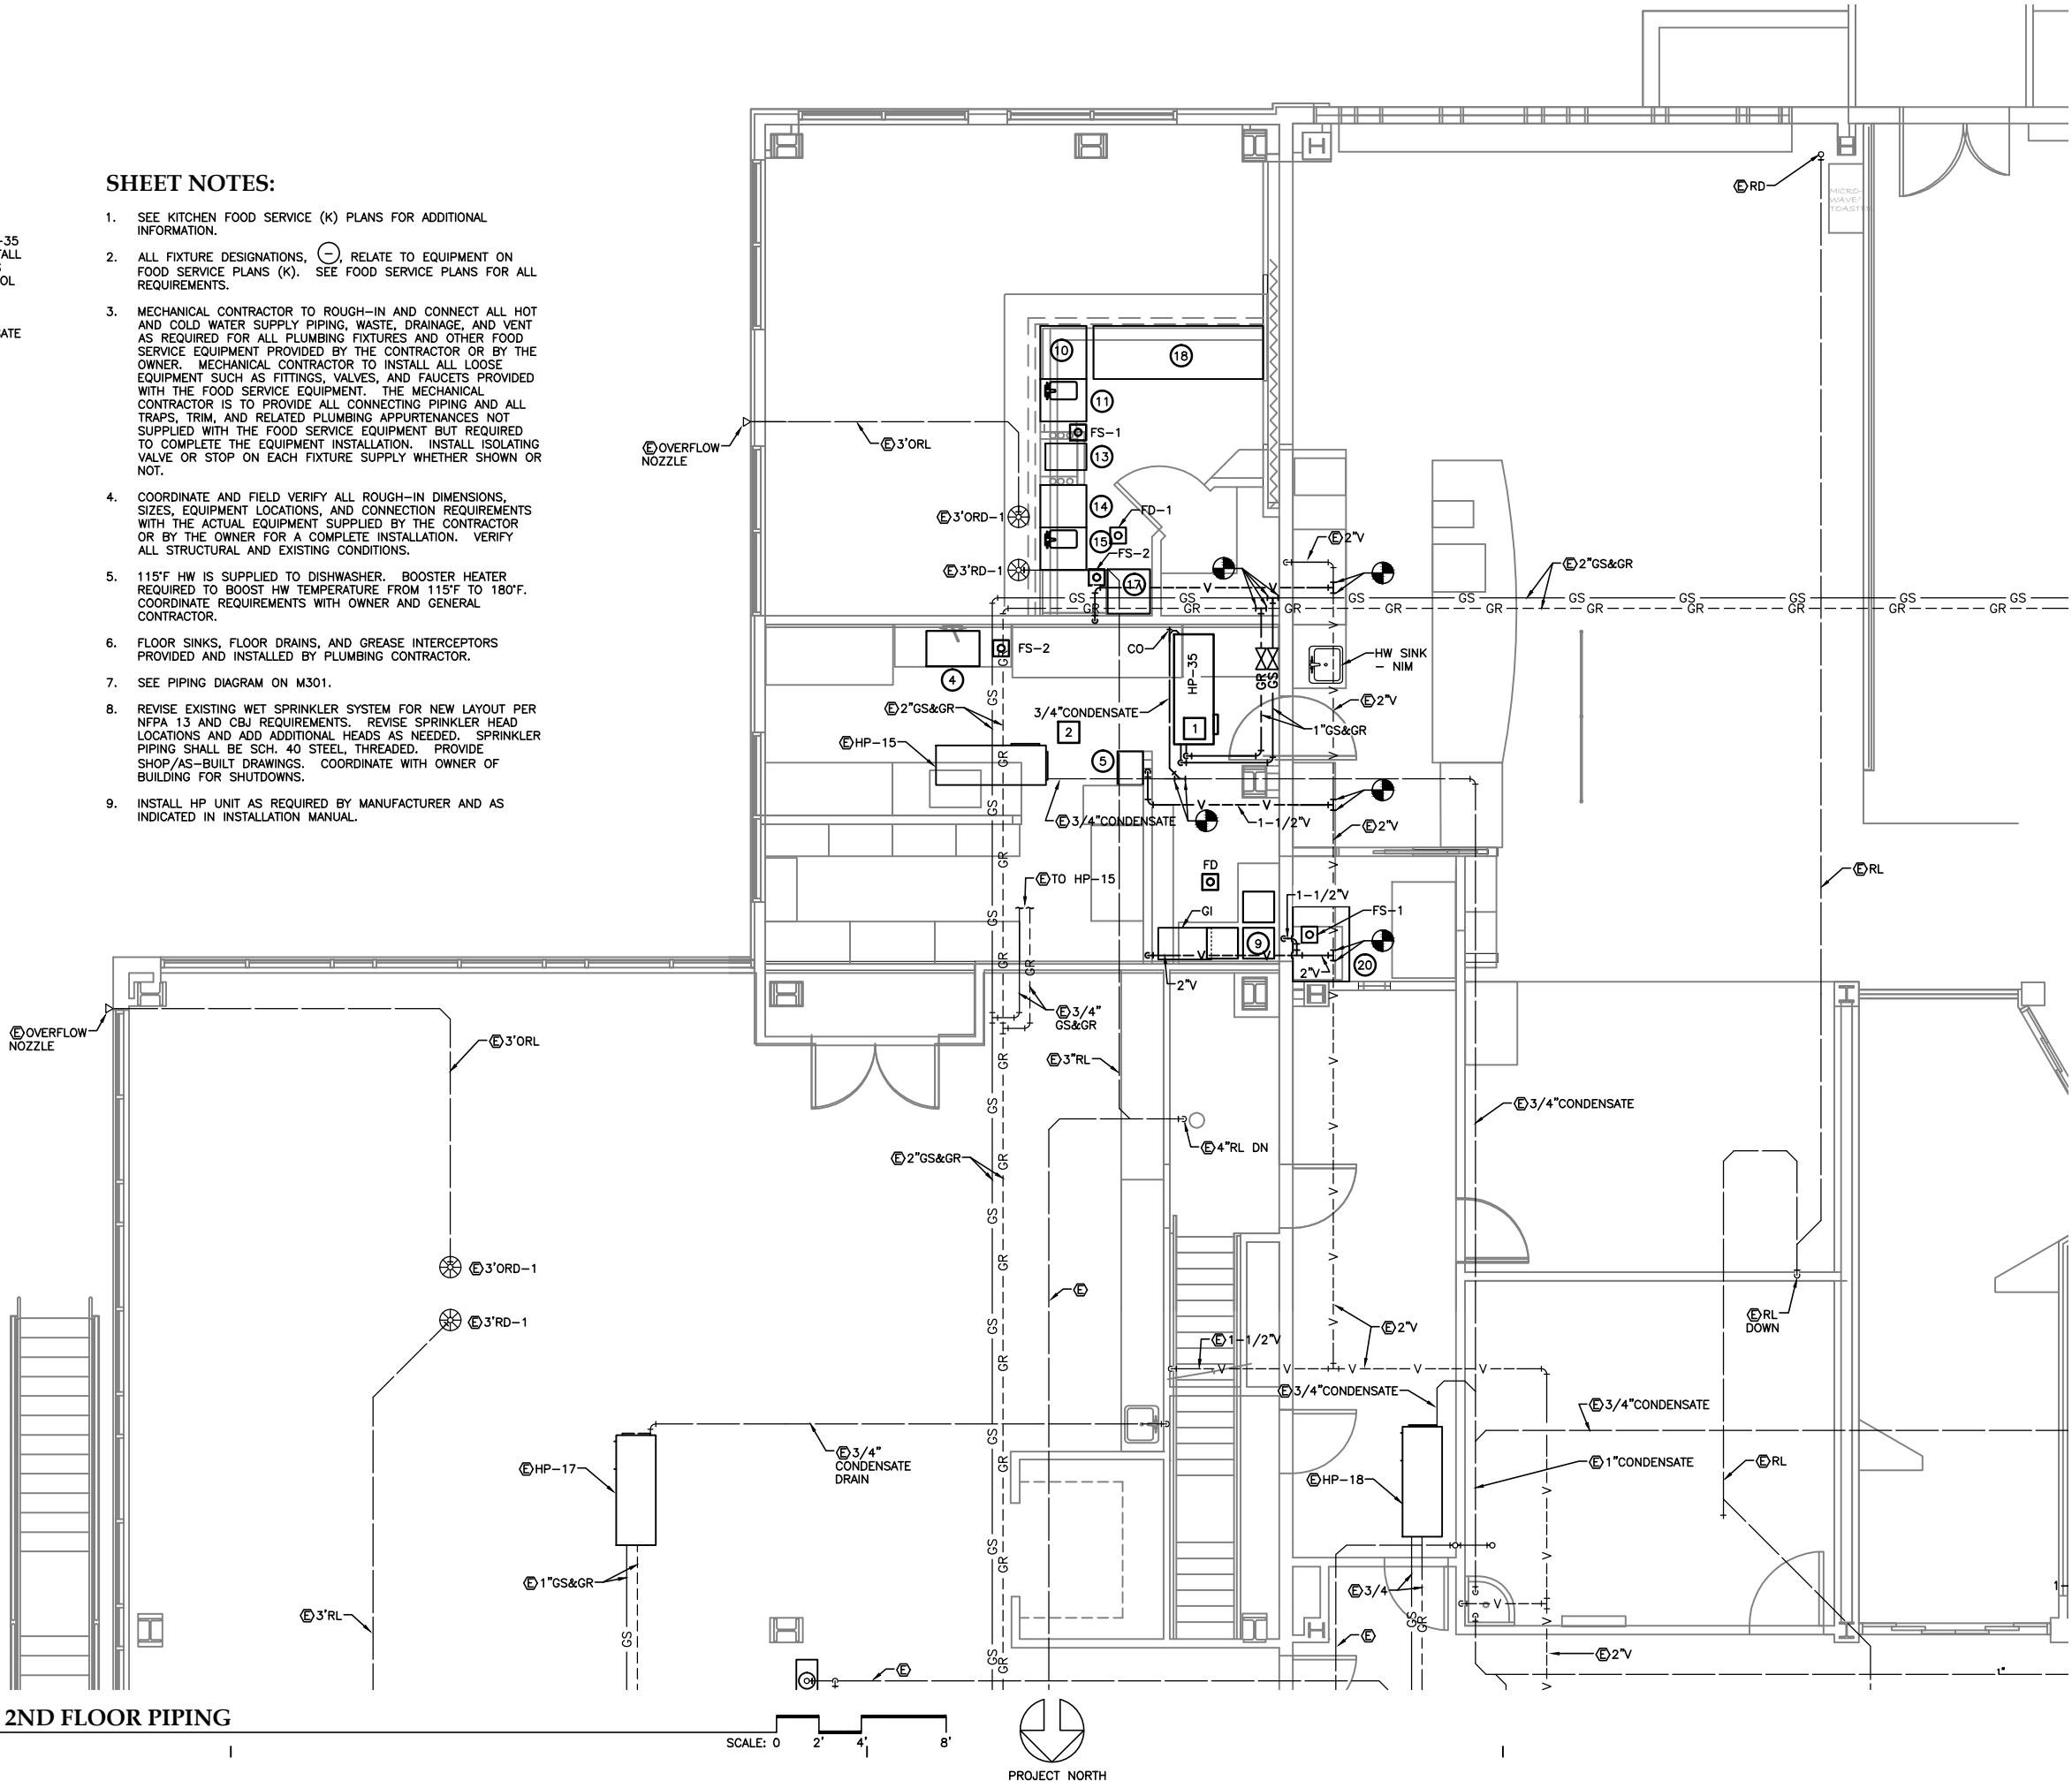

1 PARTIAL 2ND FLOOR PIPING

SCALE: 0 2' 4' 8'




Jensen Yorba Lott Inc.

522 West 10th Street
Juneau, Alaska 99801
phone 907-586-1070
fax 907-586-3959
jensenyorbalott.com



MURRAY & ASSOCIATES P.C.
CONSULTING ENGINEERS

P.O. BOX 21081
JUNEAU, AK 99802
MURRAYPC.COM
TEL: 907 780-6151 FAX: 907 780-6182

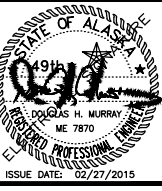

City & Borough of Juneau
Juneau International Airport
CONCESSIONS EXPANSION
CBJ Contract No. E15-195
Juneau, Alaska

BID

REVISIONS





SHEET TITLE
PARTIAL 2ND FLOOR PIPING

DATE: February 27, 2015
FILE: 11050/10-330


M202

CONSTRUCTION NOTES:

- 1 NOT USED.
- 2 MIXING BOX. INSTALL WITH HEIGHT AND LENGTH AS NEEDED FOR FABRICATED HP INLET DUCT/FILTER CONNECTION. DEPTH OF MINIMUM 30-INCHES TO ALLOW FOR 14" RA AND 8" OSA CONNECTIONS.
- 3 RELOCATE HP-15 AND HP-21 THERMOSTATS DUE TO REVISED LAYOUT. COORDINATE WITH ELECTRICAL CONTRACTOR.
- 4 ADJUST OSA FOR EXISTING HP-15 (230 CFM), HP-17 (230 CFM), AND NEW HP-35 (200 CFM). ADJUSTMENT TO BE COMPLETED UNDER SEPARATE CONTRACT BY OWNER.

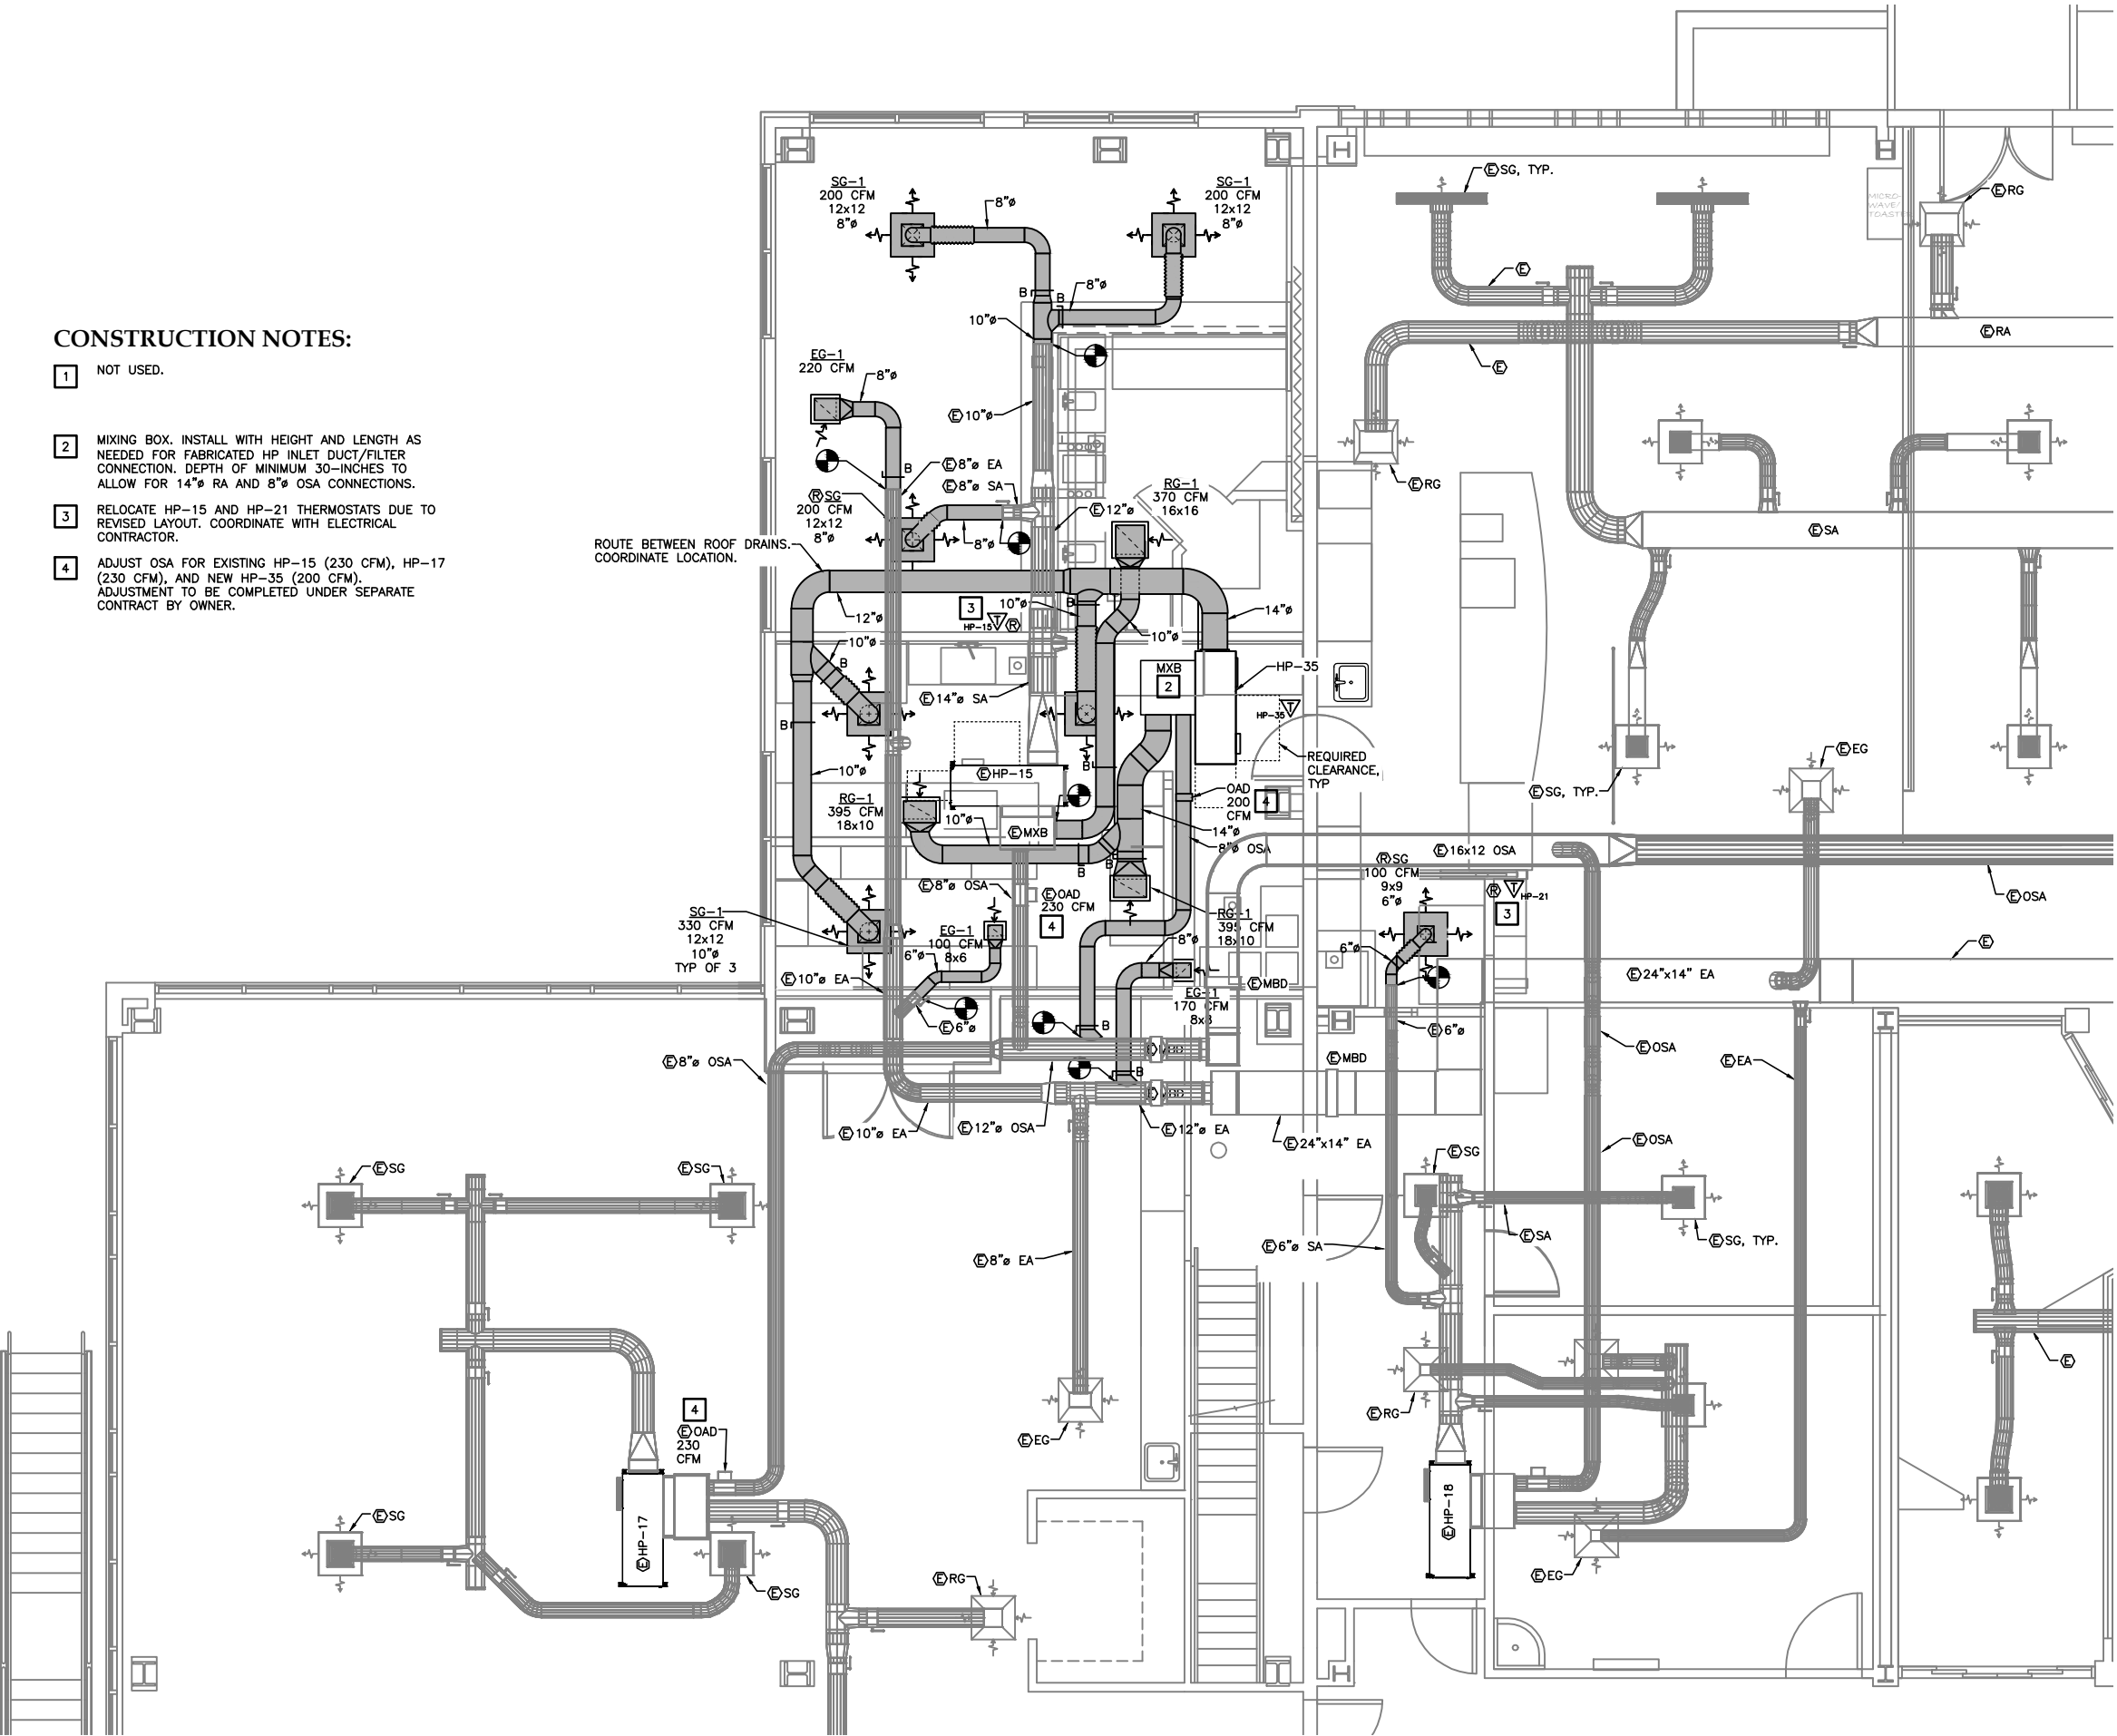

1 PARTIAL 2ND FLOOR DUCTWORK

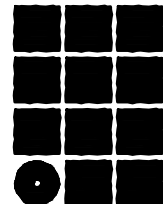


**Jensen
Yorba
Lott
Inc.**

522 West 10th Street
Juneau, Alaska 99801
phone 907-586-1070
fax 907-586-3959
jensenyorbalott.com



**MURRAY &
ASSOCIATES P.C.**
CONSULTING
ENGINEERS

P.O. BOX 21081
JUNEAU, AK 99802
MURRAYPC.COM
TEL: 907 780-6151 FAX: 907 780-6182

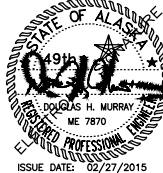

**City & Borough of Juneau
Juneau International Airport
CONCESSIONS EXPANSION
CBJ Contract No. E15-195
Juneau, Alaska**

BID


REVISIONS



SHEET TITLE
PIPING DIAGRAMS

DATE: February 27, 2015
FILE: 11050/10-330

M301

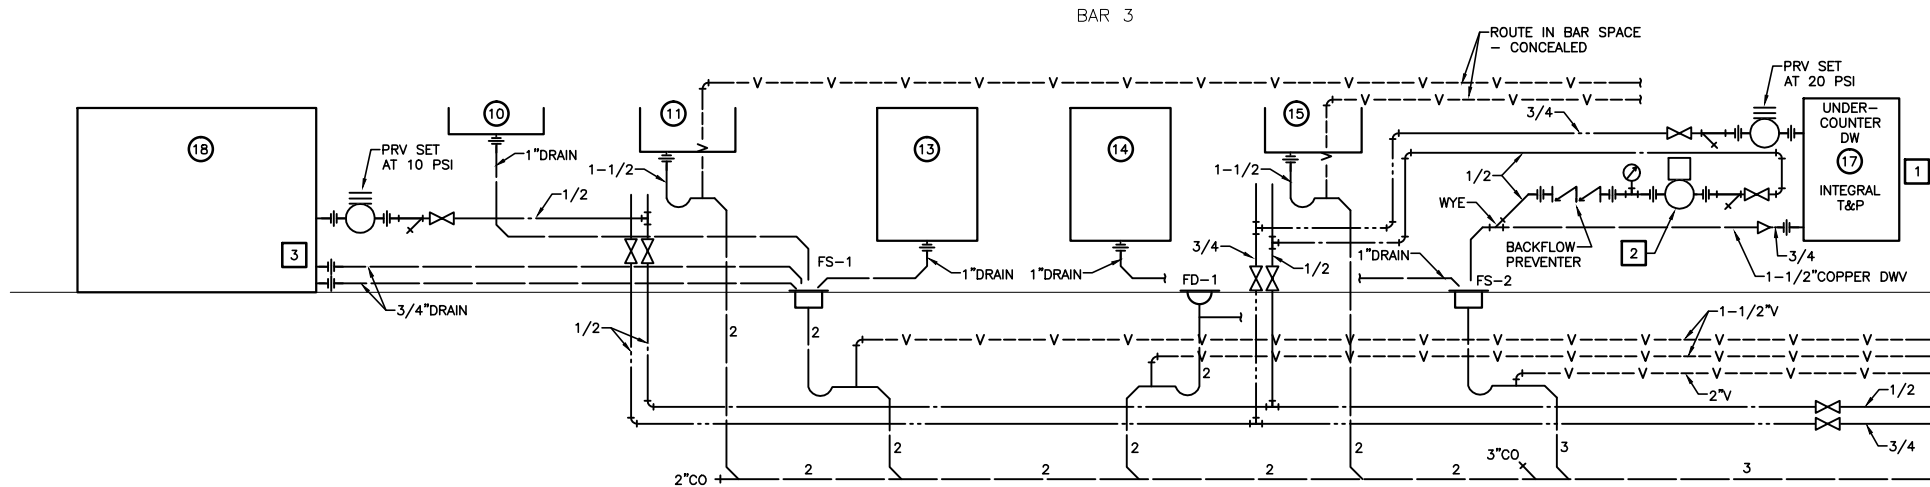


1 BAR PLUMBING DIAGRAM
NO SCALE

CONSTRUCTION NOTES:



1. INSTALL STRAINER, PRV, AND ISOLATING VALVE FOR DISHWASHER. SET PRV AT 20 PSI. THERMOMETERS, PRESSURE GAGES, SOLENOID VALVE, T&P INCLUDED WITH DW. INSTALL IN ACCORDANCE WITH MANUFACTURER'S REQUIREMENTS.
2. INSTALL DRAIN WATER TEMPERING KIT AND RELATED TRIM.
3. INSTALL ISOLATING VALVE, STRAINER, AND PRV FOR BEER COOLER AND GLASS RINSER. SET PRV AT 10 PSI. INSTALL CW CONNECTIONS AND ROUTE DRAINS PER MANUFACTURER'S INSTRUCTIONS.

SHEET NOTES:

1. SEE KITCHEN FOOD SERVICE (K) PLANS FOR ADDITIONAL INFORMATION.
2. ALL FIXTURE DESIGNATIONS, (K), RELATE TO EQUIPMENT ON FOOD SERVICE PLANS (K). SEE FOOD SERVICE PLANS FOR ALL REQUIREMENTS.
3. CONCRETE SAWCUTTING AND CORE DRILLING REQUIRED. SEAL PENETRATION WATERTIGHT.

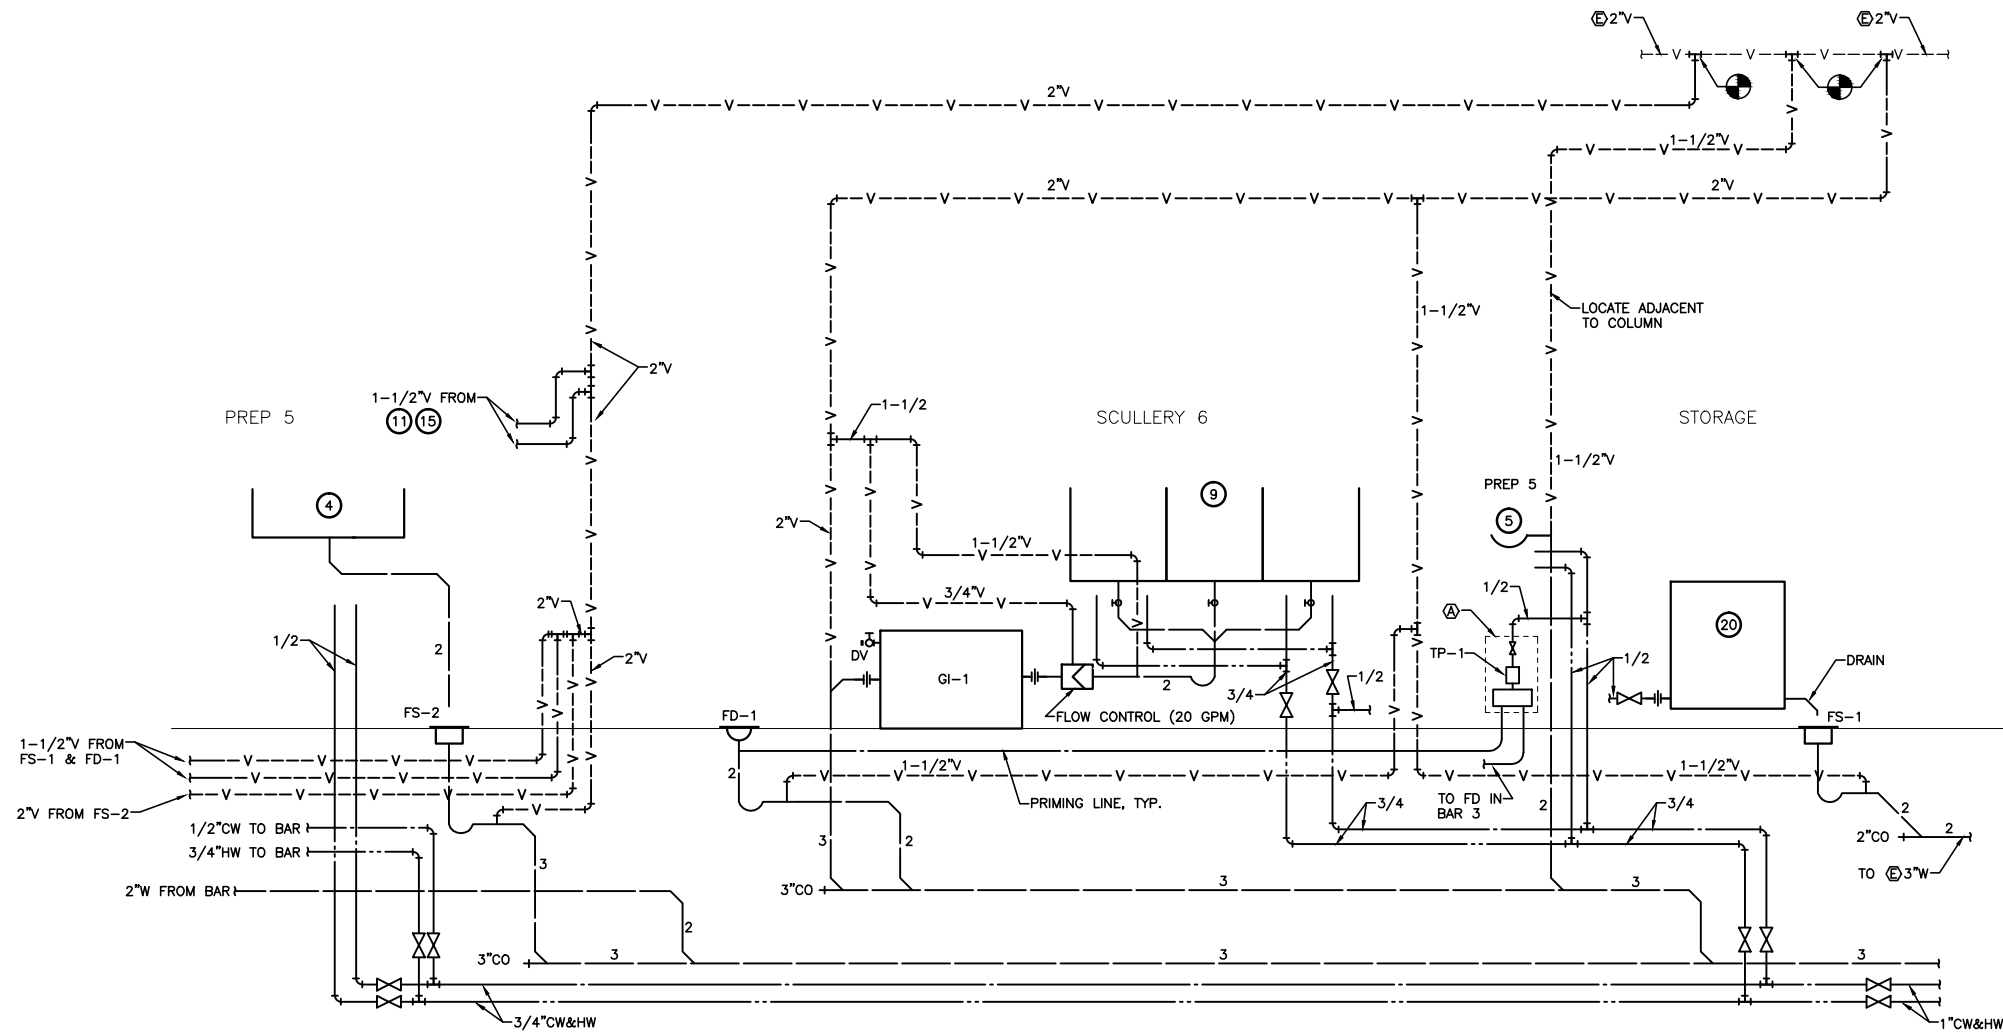

2 PREP KITCHEN PLUMBING DIAGRAM
NO SCALE

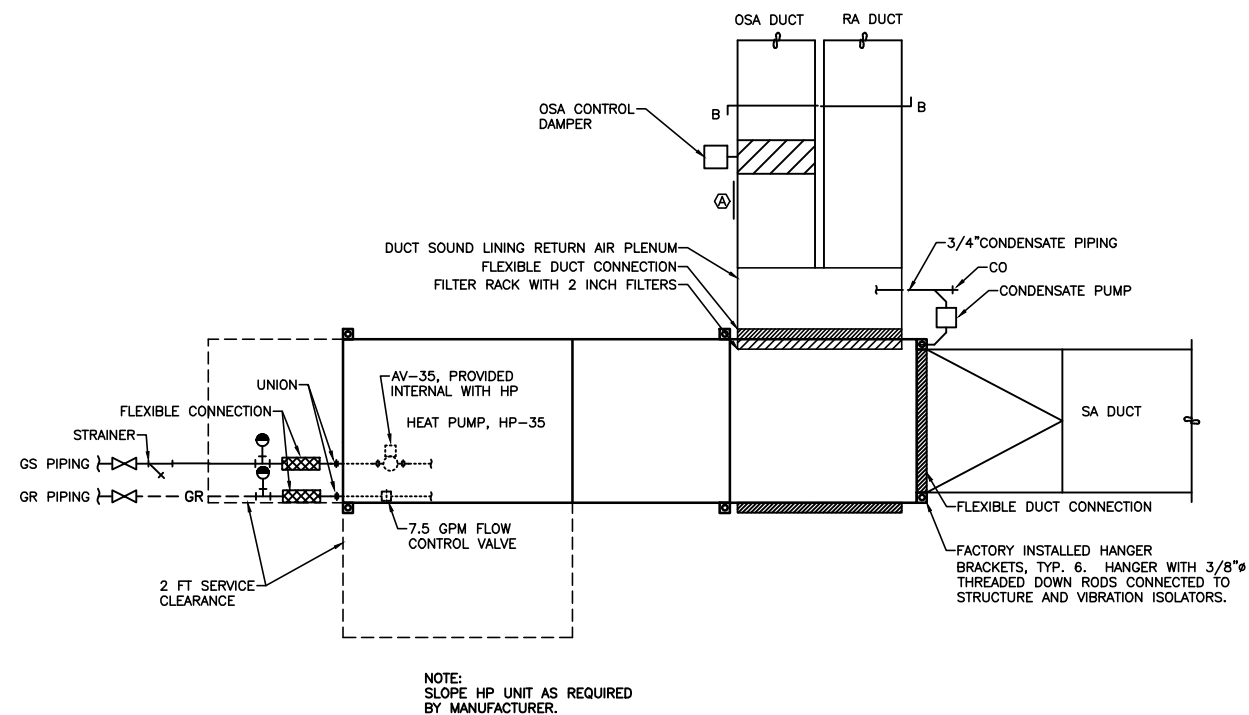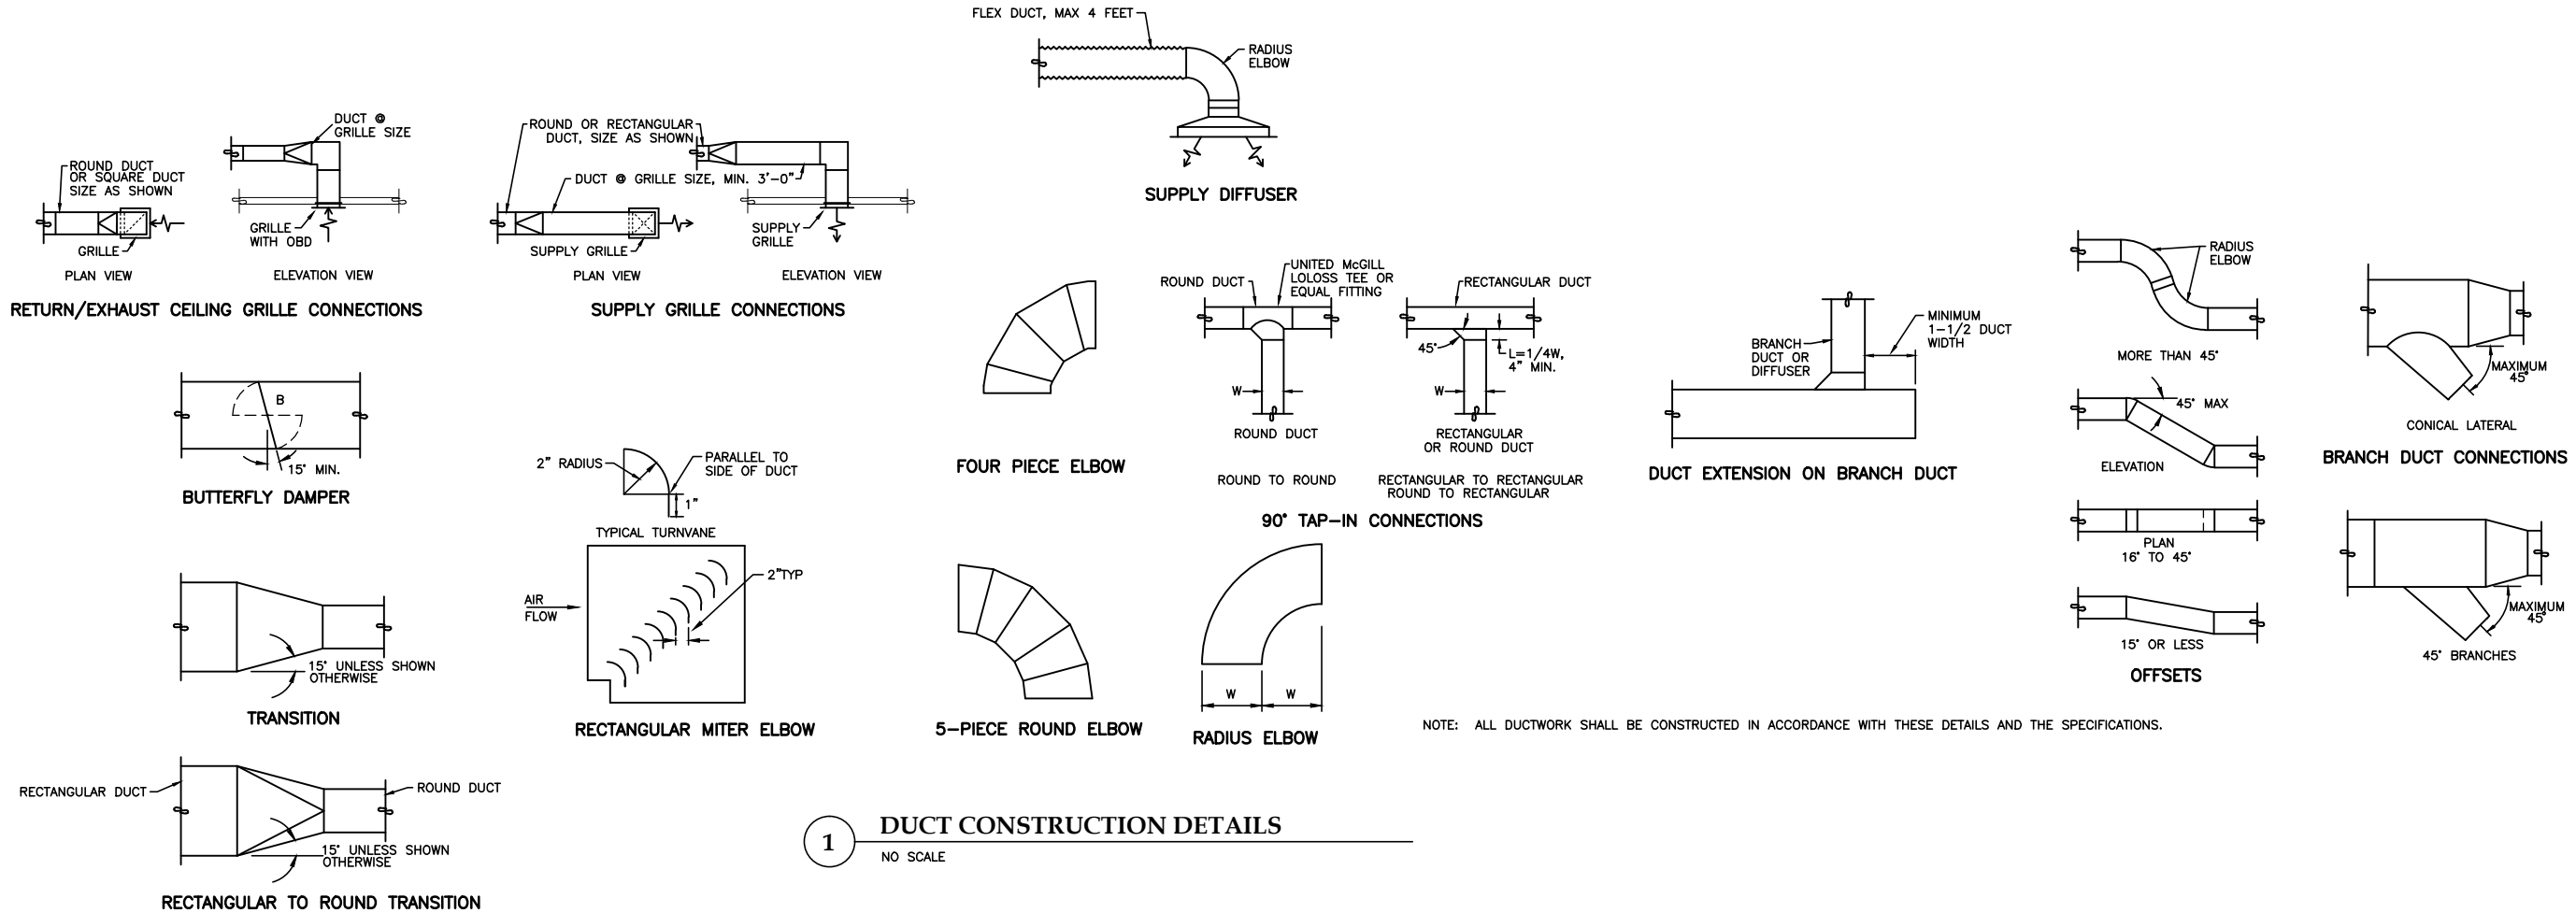

**Jensen
Yorba
Lott
Inc.**

522 West 10th Street
Juneau, Alaska 99801
phone 907-586-1070
fax 907-586-3959
jensenyorbalott.com



**MURRAY &
ASSOCIATES P.C.**
CONSULTING
ENGINEERS

P.O. BOX 21081
JUNEAU, AK 99802
MURRAYPC.COM
TEL: 907 780-6151 FAX: 907 780-6182



**City & Borough of Juneau
Juneau International Airport
CONCESSIONS EXPANSION
CBJ Contract No. E15-195
Juneau, Alaska**

BID

REVISIONS



**SHEET TITLE
DETAILS &
DIAGRAMS**

DATE: February 27, 2015
FILE: 11050/10-330

M401

Plotted 2/4/2015 8:21 AM by Robbie Jensen
F:\Projects\100 Jensen Yorba Lott Inc\285 JNU Concession Expansion\Drawings\Working\ED201.dwg

LEGEND

ABBREVIATIONS:

AFF	ABOVE FINISHED FLOOR
GFI	GROUND FAULT INTERRUPTED
LV	LOW VOLTAGE
UON	UNLESS OTHERWISE NOTED

SHEET NOTE SYMBOLS:

(E)	EXISTING TO REMAIN
(N)	NEW
(R)	RELOCATE EXISTING
(X)	REMOVE EXISTING

POWER:

	SINGLE RECEPTACLE
	DUPLEX RECEPTACLE
	DOUBLE DUPLEX RECEPTACLE
	250V SINGLE PHASE RECEPTACLE
	DUPLEX RECEPTACLE, ABOVE COUNTER
	JUNCTION BOX
	MOTOR CONNECTION
	MOTOR STARTER
	DISCONNECT, F=FUSED
	THERMOSTAT

SERVICE EQUIPMENT:

	PANELBOARD
--	------------

LIGHTING:

	SURFACE LINEAR LUMINAIRE
	RECESSED TROFFER LUMINAIRE
	LUMINAIRE, EQUIP WITH EMERGENCY BATTERY PACK
	PENDANT MOUNTED LUMINAIRE
	RECESSED DOWNLIGHT LUMINAIRE
	WALL MOUNTED EXIT LUMINAIRE

LIGHTING CONTROLS:

S	SINGLE POLE SWITCH
	OCCUPANCY SENSOR: W=WALL SWITCH, U=ULTRASONIC, D=DUAL TECH
	OCCUPANCY POWER PACK
	OCCUPANCY POWER PACK W/ DIMMING CONTROL
	LIGHTING CONTROL STATION
X	X=NUMBER OF BUTTONS, D=DIMMING

FIRE ALARM:


	FIRE ALARM HORN/STROBE
	FIRE ALARM STROBE ONLY

NETWORK DEVICES:

	DATA
	DATA, ABOVE COUNTER OR TABLE MOUNTED
	DATA/TELEPHONE
	TELEVISION
	INTERCOM CALL STATION

CONDUIT & CONDUCTORS:


	HOME RUN
	CONDUIT: 1/2" UON.
	UNGROUND CONDUCTORS (#12 AWG)
	NEUTRAL: #10 WITH DOT #12 OTHERWISE
	GROUND CONDUCTOR
	CONDUCTORS NOT SHOWN WHERE ONLY #12 NEUTRAL AND UNGROUNDED CONDUCTOR ARE REQUIRED
	EXISTING CONDUIT
	CONDUIT W/ LOW VOLTAGE CONDUCTORS, SLASHES INDICATE NO. OF CONDUCTORS IF NOT TWO
	FLEXIBLE CONDUIT
	TYPE MC CABLE

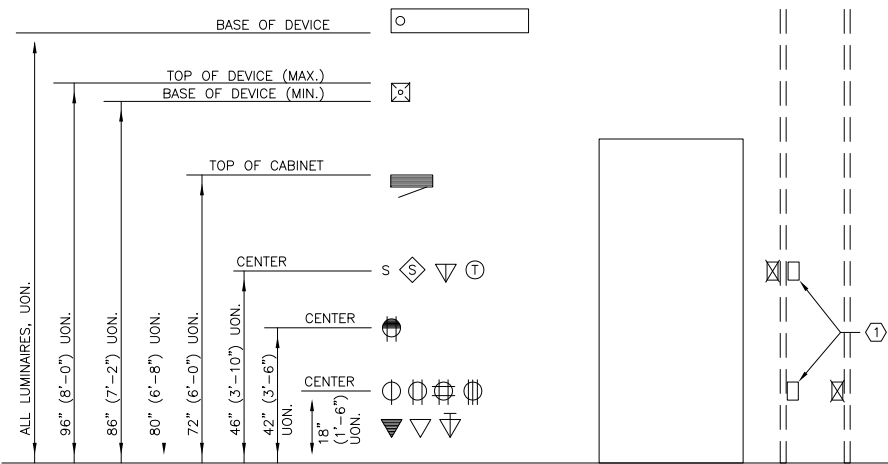

TYPICAL DEVICE MOUNTING HEIGHTS


NOTES:

- ALL DEVICES INDICATED TO BE INSTALLED AT DIFFERENT MOUNTING HEIGHTS AND LOCATED WITHIN ONE STUD SPACE FROM EACH OTHER SHALL ALIGN VERTICALLY ON THE SAME SIDE OF THE STUD. WHERE WALL MOUNTED TELEPHONES OCCUR OVER LIGHT SWITCHES, VOLUME CONTROLS, ETC. OFFSET ONE STUD SPACE.
- HEIGHTS SHOWN ARE TYPICAL TO CENTERLINE OF BOX UNLESS OTHERWISE NOTED.
- WHERE EVER DEVICES ARE INDICATED TO BE ABOVE DOORS, DEVICE SHALL BE CENTERED BETWEEN TOP OF DOOR TRIM AND CEILING LINE.
- MOUNTING HEIGHTS SHOWN ON ARCHITECTURAL ELEVATIONS SHALL GOVERN OVER THOSE SHOWN ABOVE.

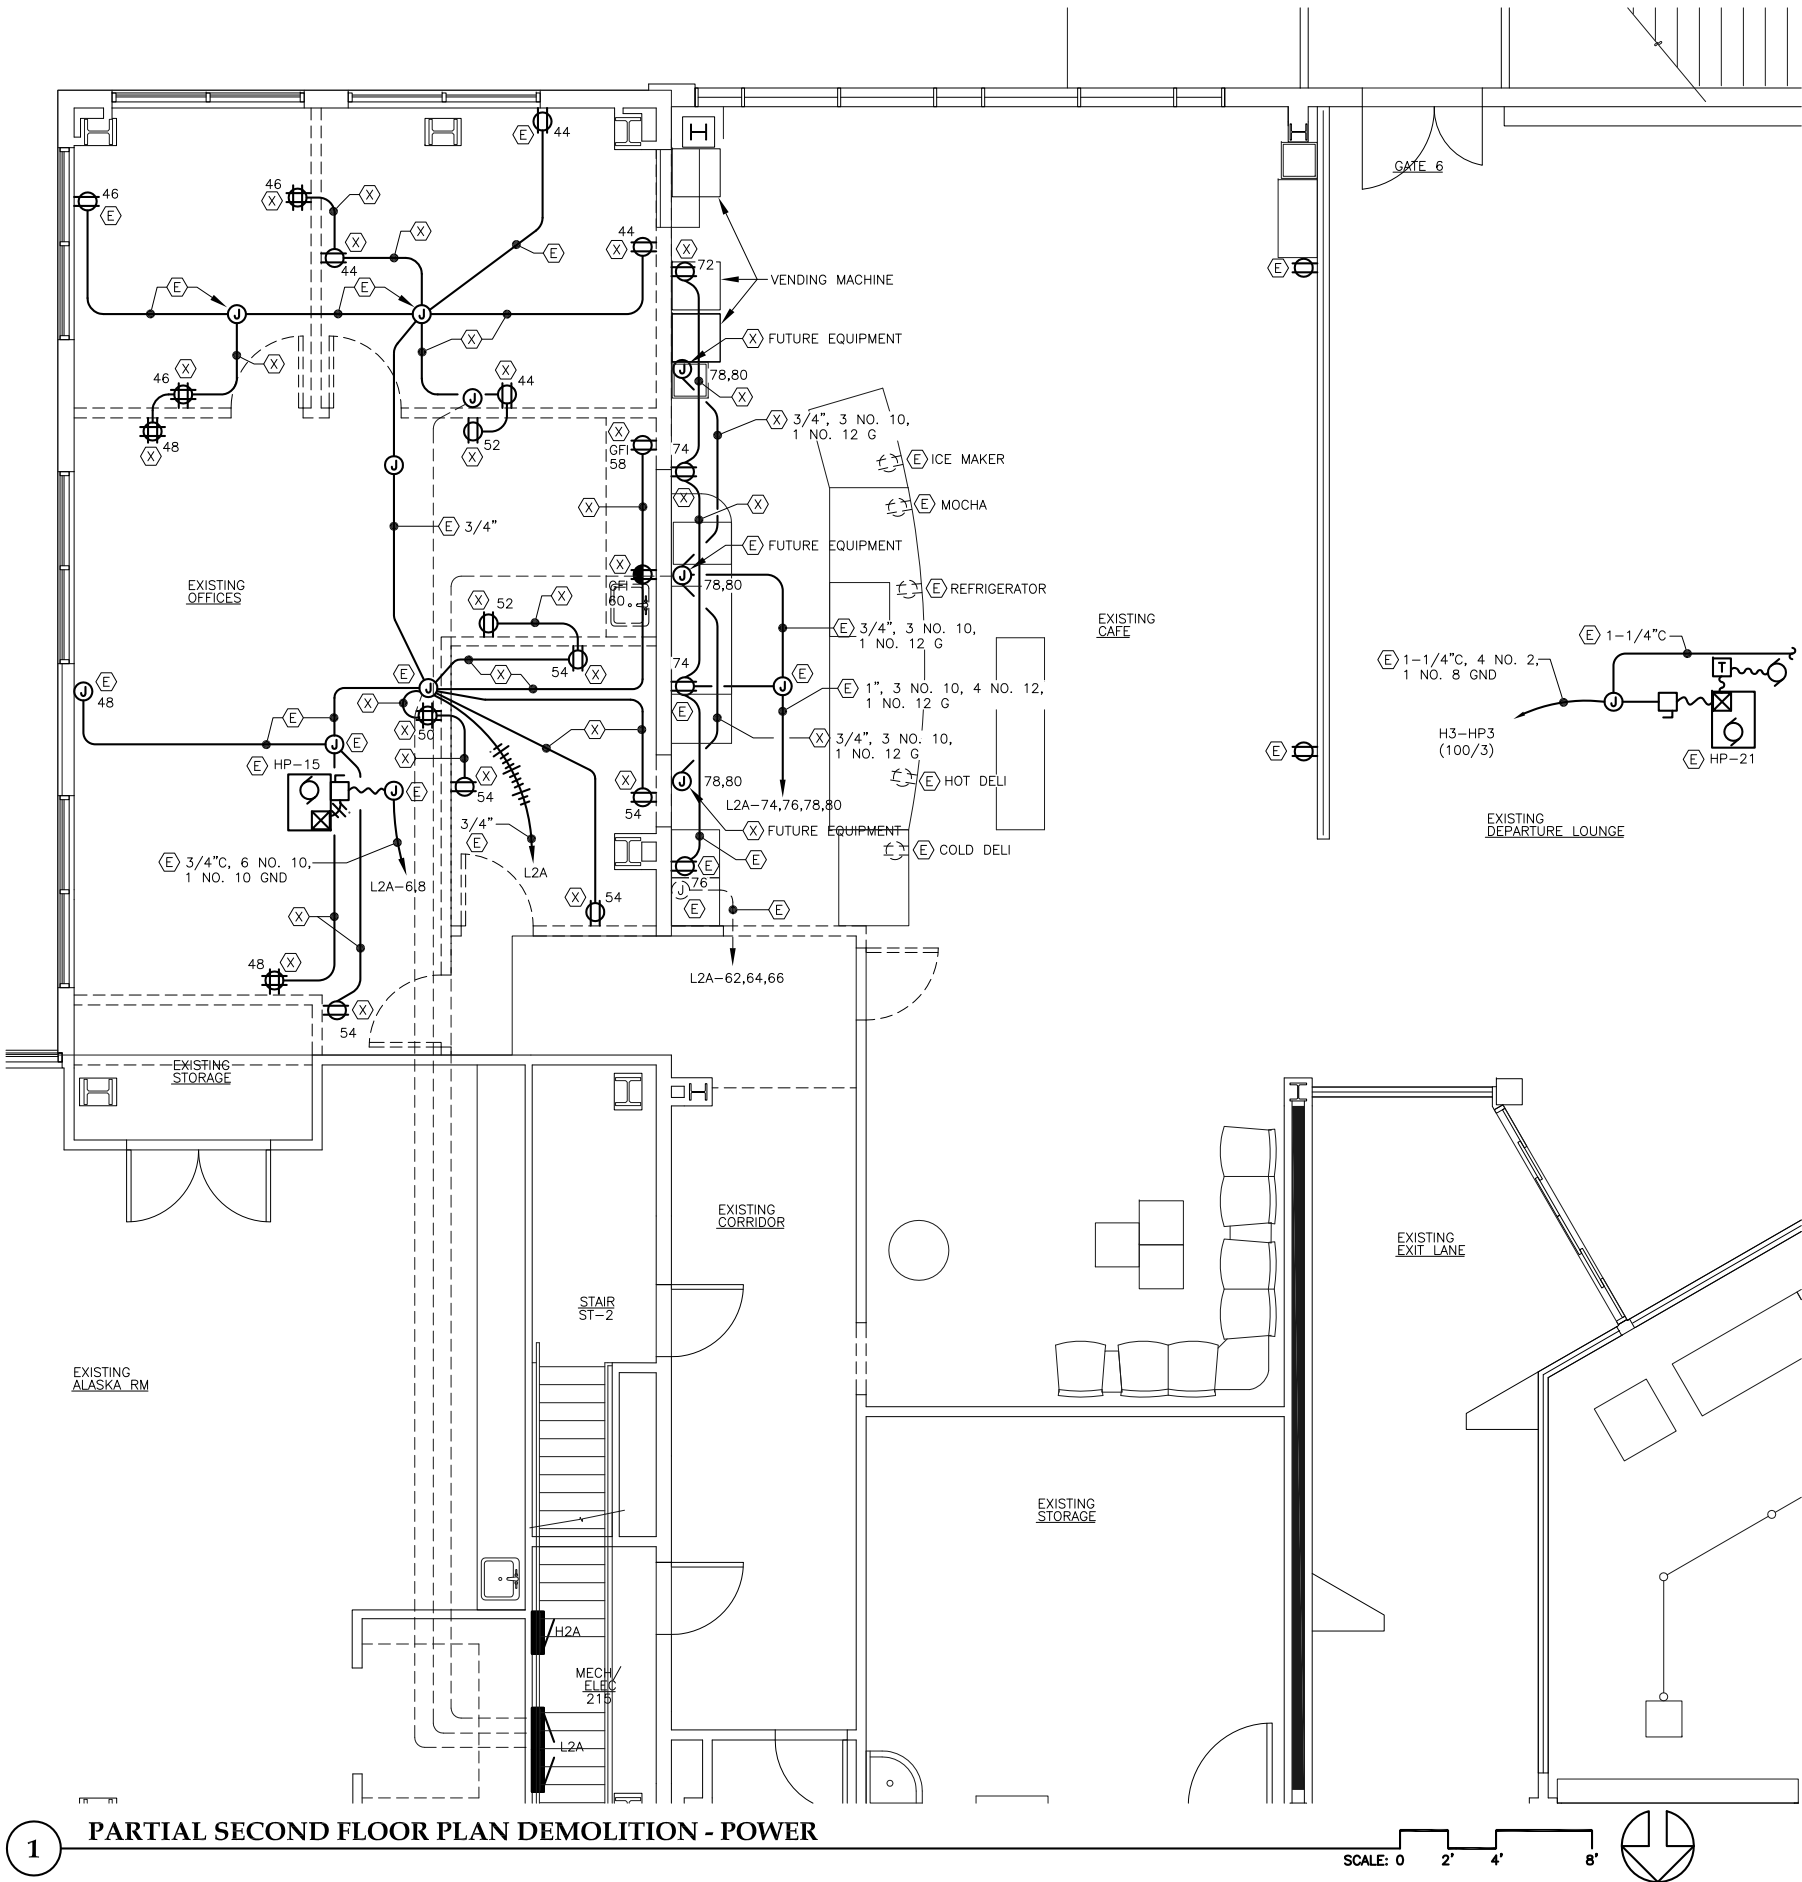


1 PARTIAL SECOND FLOOR PLAN DEMOLITION - POWER

SCALE: 0 2' 4' 8'

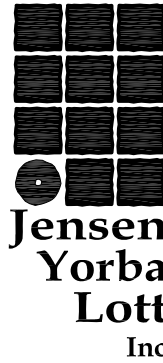

522 West 10th Street
Juneau, Alaska 99801
phone 907-586-1070
fax 907-586-3959
jensenyorbalott.com

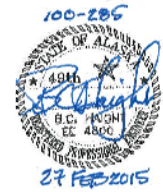

City & Borough of Juneau
Juneau International Airport
CONCESSIONS EXPANSION
CBJ Contract No. E15-195
Juneau, Alaska

BID

REVISIONS



SHEET TITLE

PARTIAL SECOND
FLOOR PLAN
DEMOLITION
POWER

DATE: February 27, 2015

FILE: 11050

ED201


Plotted 2/4/2015 8:31 AM by Robbie Jensen
F:\Projects\100 Jensen Yorba Lott Inc\85 JNU Concession Expansion\Drawings\Working\E201.dwg

NOTES:

1. CIRCUIT THERMOSTATS TO THEIR RESPECTIVE HEAT PUMPS.
COORDINATE WITH MECHANICAL.


1 PARTIAL SECOND FLOOR PLAN - POWER

SCALE: 0 2' 4' 8'

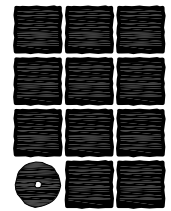

**Jensen
Yorba
Lott**
Inc.

522 West 10th Street
Juneau, Alaska 99801
phone 907-586-1070
fax 907-586-3959
jensenyorbalott.com

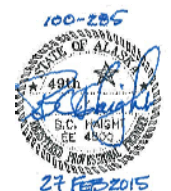

City & Borough of Juneau
Juneau International Airport
CONCESSIONS EXPANSION
CBJ Contract No. E15-195
Juneau, Alaska

BID

REVISIONS



 
SHEET TITLE

**PARTIAL SECOND
FLOOR PLAN
POWER**

DATE: February 27, 2015

FILE: 11050

E201




**Jensen
Yorba
Lott
Inc.**

522 West 10th Street
Juneau, Alaska 99801
phone 907-586-1070
fax 907-586-3959
jensenyorbalott.com



HAIGHT
& ASSOCIATES
CONSULTING
ELECTRICAL
ENGINEERS
526 Main Street, Juneau, AK 99801
(907) 595-0788

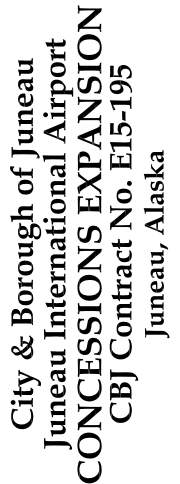

MECHANICAL EQUIPMENT SCHEDULE													
DESIGNATION			LOAD					CIRCUITING			CONTROL		
ITEM	DESCRIPTION	LOCATION	HP	KW	AMPS	VOLTS	PHASE	CONDUCTORS	DISCONNECT		STARTER SIZE	CONTROL	REMARKS
									SWITCH	FUSE			
HP-35	HEAT PUMP	PREP KITCHEN 5			7.1	480	3	3 NO. 10, 1 NO. 10 GND	30A	10A			
HP-35	CONDENSATE PUMP	PREP KITCHEN 5			1	115	1	2 NO. 12, 1 NO. 12 GND					PROVIDE 480:120V, 500W XFMR



BID	
REVISIONS	
	.
	.
	.
SHEET TITLE	
SCHEDULES	
. . .	
DATE: February 27, 2015	
FILE: 11050	

E202

Plotted 2/4/2015 8:33 AM by Robbie Jensen F:\Projects\100 Jensen Yorba Lott Inc\285 JNU Concession Expansion\Drawings\Working\ED301.dwg

NOTE:

- ① SALVAGE LOW VOLTAGE LIGHTING CONTROLS AND LUMINAIRES. USE COMPONENTS AS NEEDED AND DELIVER THE REMAINDER TO THE AIRPORT.

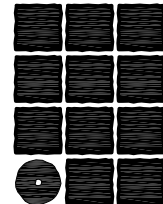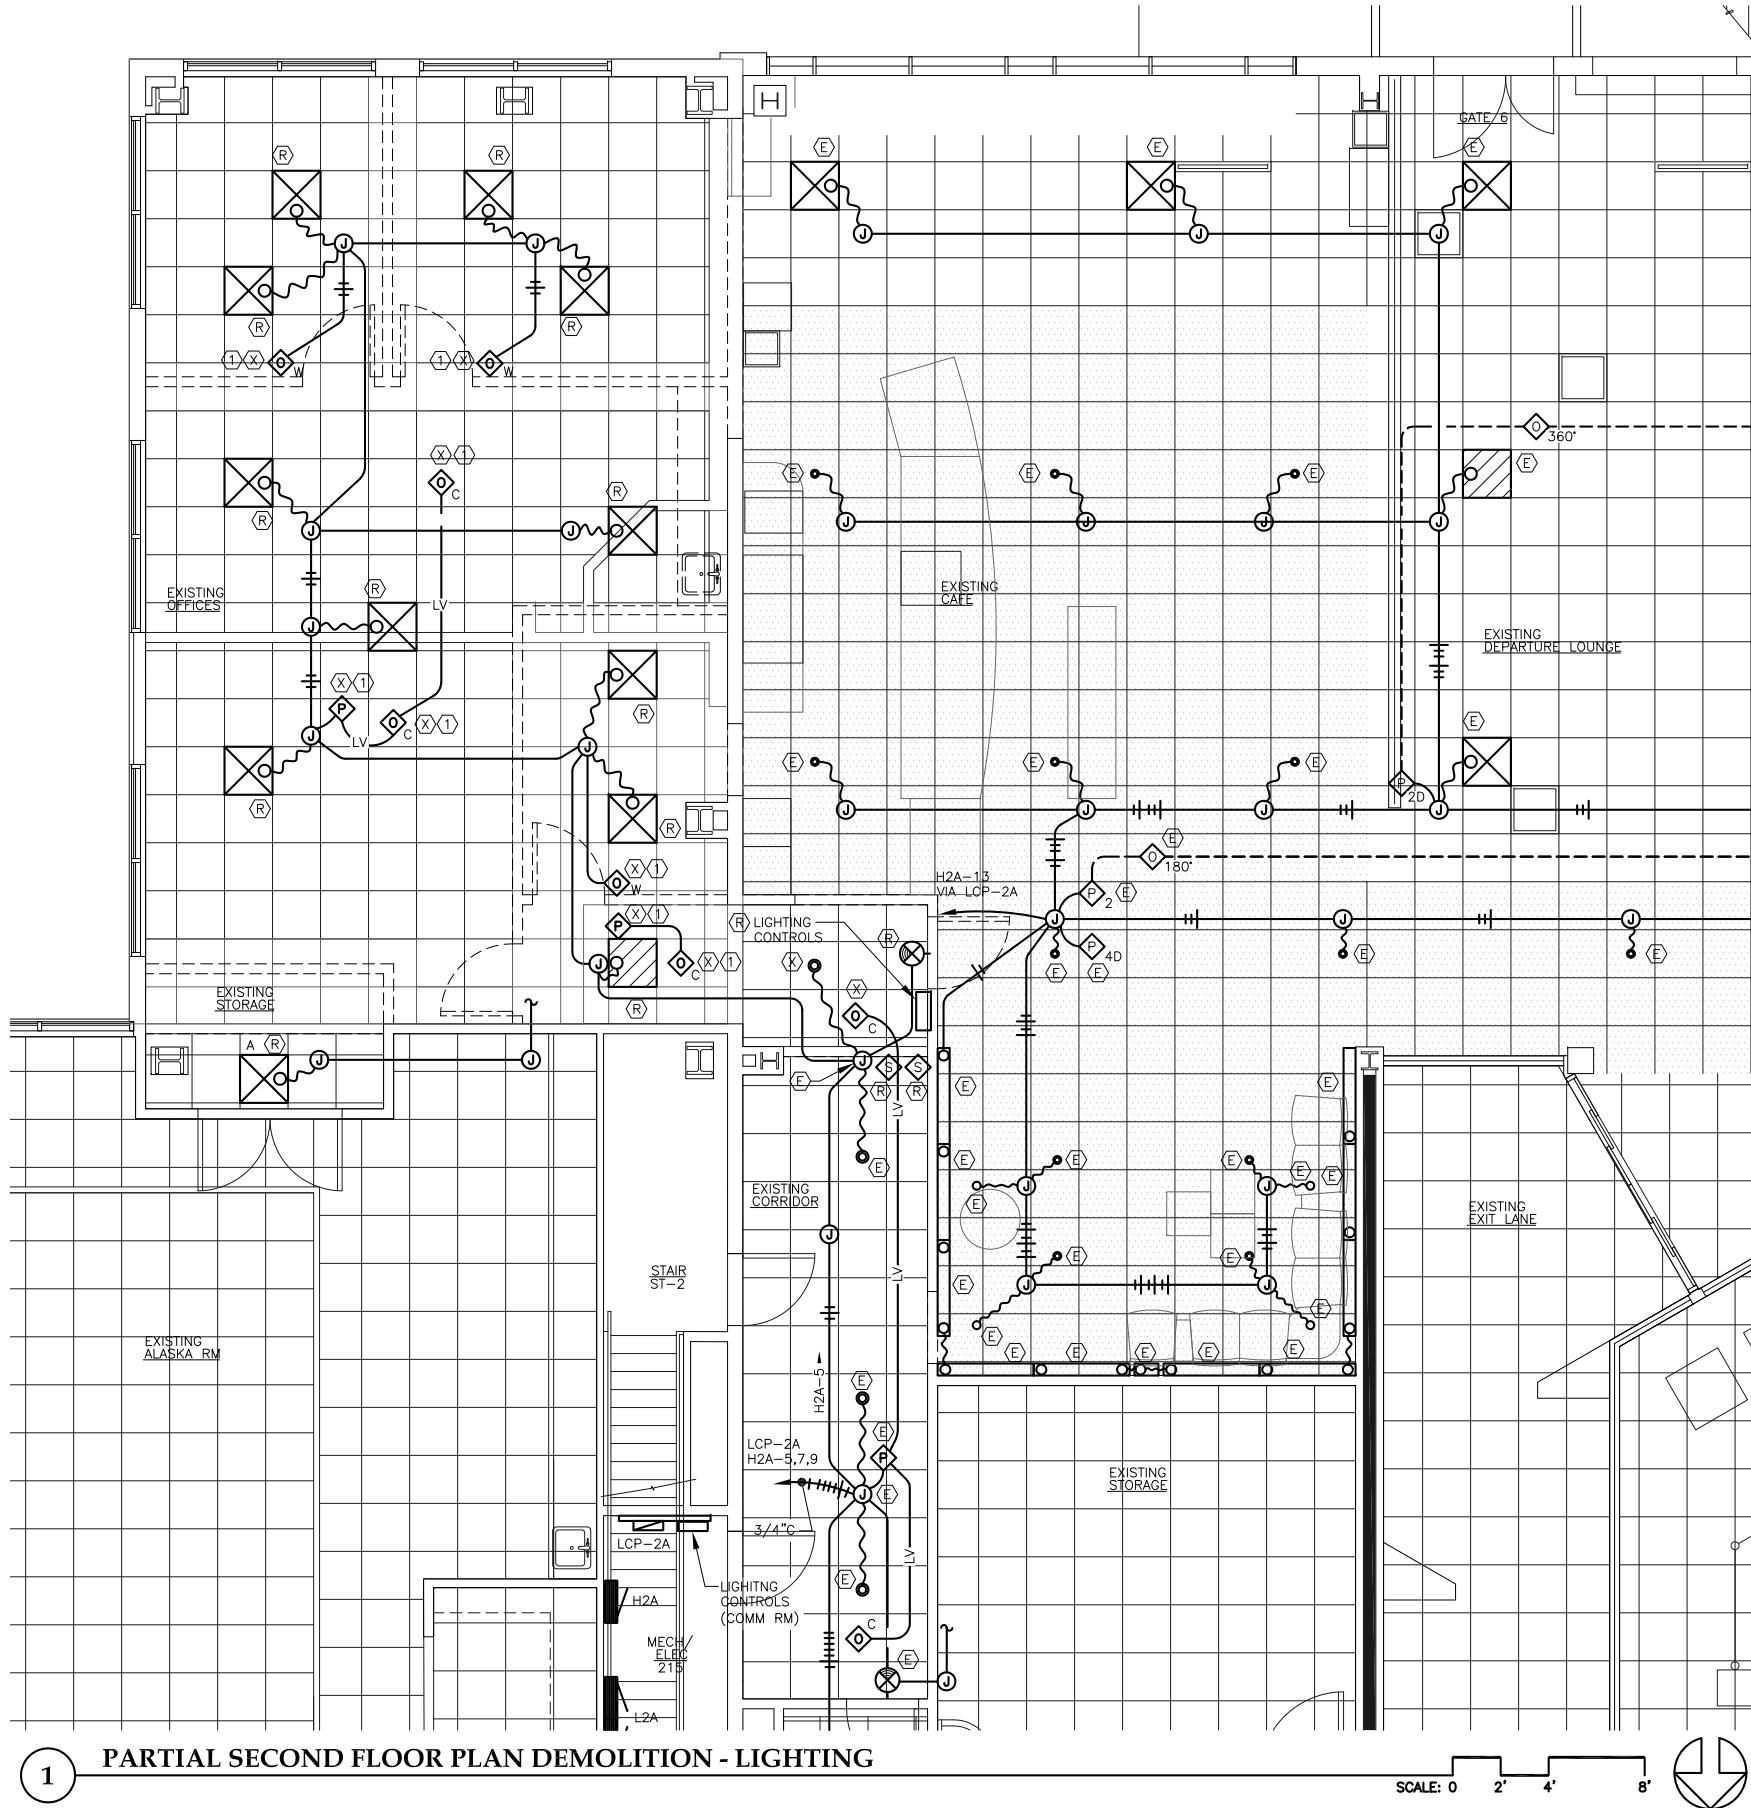

**Jensen
Yorba
Lott
Inc.**

522 West 10th Street
Juneau, Alaska 99801
phone 907-586-1070
fax 907-586-3959
jensenyorbalott.com



**City & Borough of Juneau
Juneau International Airport
CONCESSIONS EXPANSION
CBJ Contract No. E15-195
Juneau, Alaska**

BID

REVISIONS



SHEET TITLE

**PARTIAL SECOND
FLOOR PLAN
DEMOLITION
LIGHTING**

DATE: February 27, 2015


FILE: 11050

ED301

Plotted 2/4/2015 8:35 AM by Robbie Jensen
F:\Projects\100 Jensen Yorba Lott Inc\285 JNU Concession Expansion\Drawings\Working\E301.dwg


LUMINAIRE SCHEDULE				
TYPE	DESCRIPTION	MANUFACTURER	LAMPS	REMARKS
A	2x2 RECESSED LED TROFFER, STEEL HOUSING, FLAT PANEL ACRYLIC LENS, INTEGRAL ELECTRONIC 0-10V DRIVER, 120/277V	LITHONIA LIGHTING 2TL2 33L FW A12 D38 LP835 NX	38W WHITE LED 3500K, CRI 82	
B	4" DIA RECESSED LED OPEN DOWNLIGHT, CLEAR ALZAK APERATURE, INTEGRAL ELECTRONIC DIMMING DRIVER, 600 LUMENS, 120V	JUNO LIGHTING IC1RLWDG4N-3K-1-17C-WH	12W WHITE LED 3000K, CRI 82	
C	DECORATIVE PENDANT, CYLINDRICAL GLASS, FROST FINISH, STEEL PENDANT WITH SATIN NICKEL FINISH PROVIDE WITH DIMMABLE LED A19 LAMP	DESTINATION LIGHTING 430592	SYLVANIA OSRAM 10W A19 LED 2700K	MOUNT @ 6'-0" AFF TO BOTTOM OF LUMINAIRE, UON.

NOTE: ALL LUMINAIRE MOUNTING HEIGHTS ARE TO THE BOTTOM OF THE LUMINAIRE, UNLESS OTHERWISE NOTED AND OR APPLICABLE.

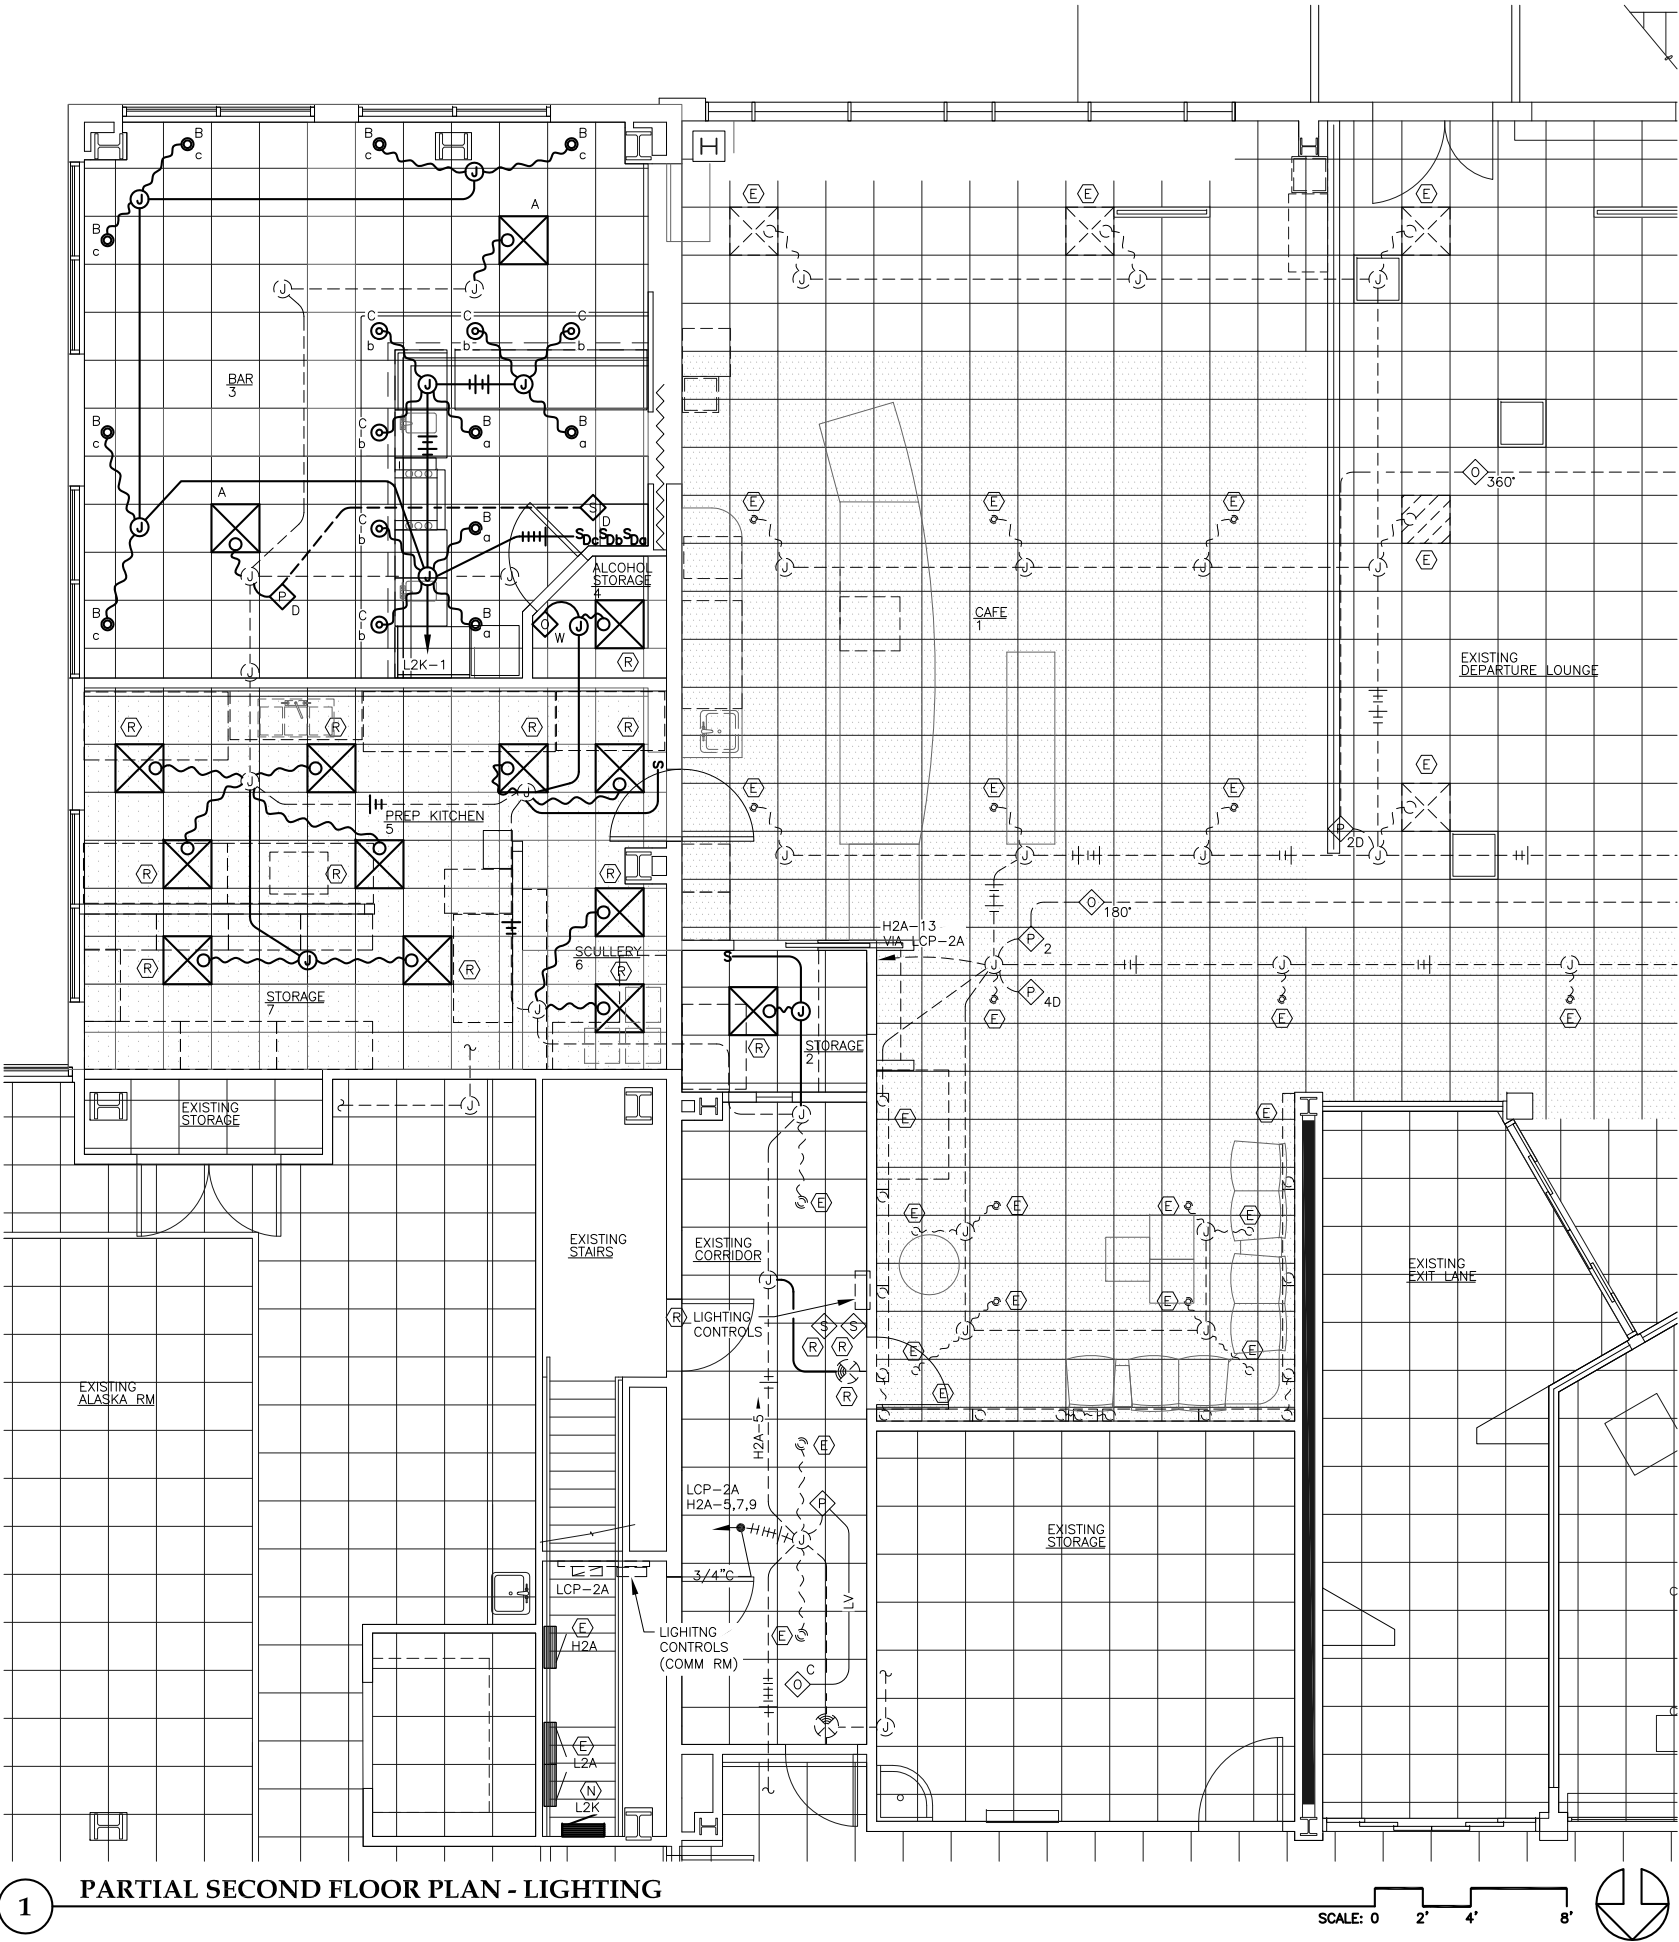

**Jensen
Yorba
Lott
Inc.**

522 West 10th Street
Juneau, Alaska 99801
phone 907-586-1070
fax 907-586-3959
jensenyorbalott.com

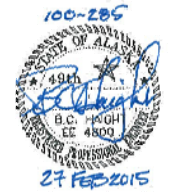

**City & Borough of Juneau
Juneau International Airport
CONCESSIONS EXPANSION
CBJ Contract No. E15-195
Juneau, Alaska**

BID


REVISIONS

△ .
△ .
△ .

SHEET TITLE
**PARTIAL SECOND
FLOOR PLAN
LIGHTING**

DATE: February 27, 2015
FILE: 11050


E301

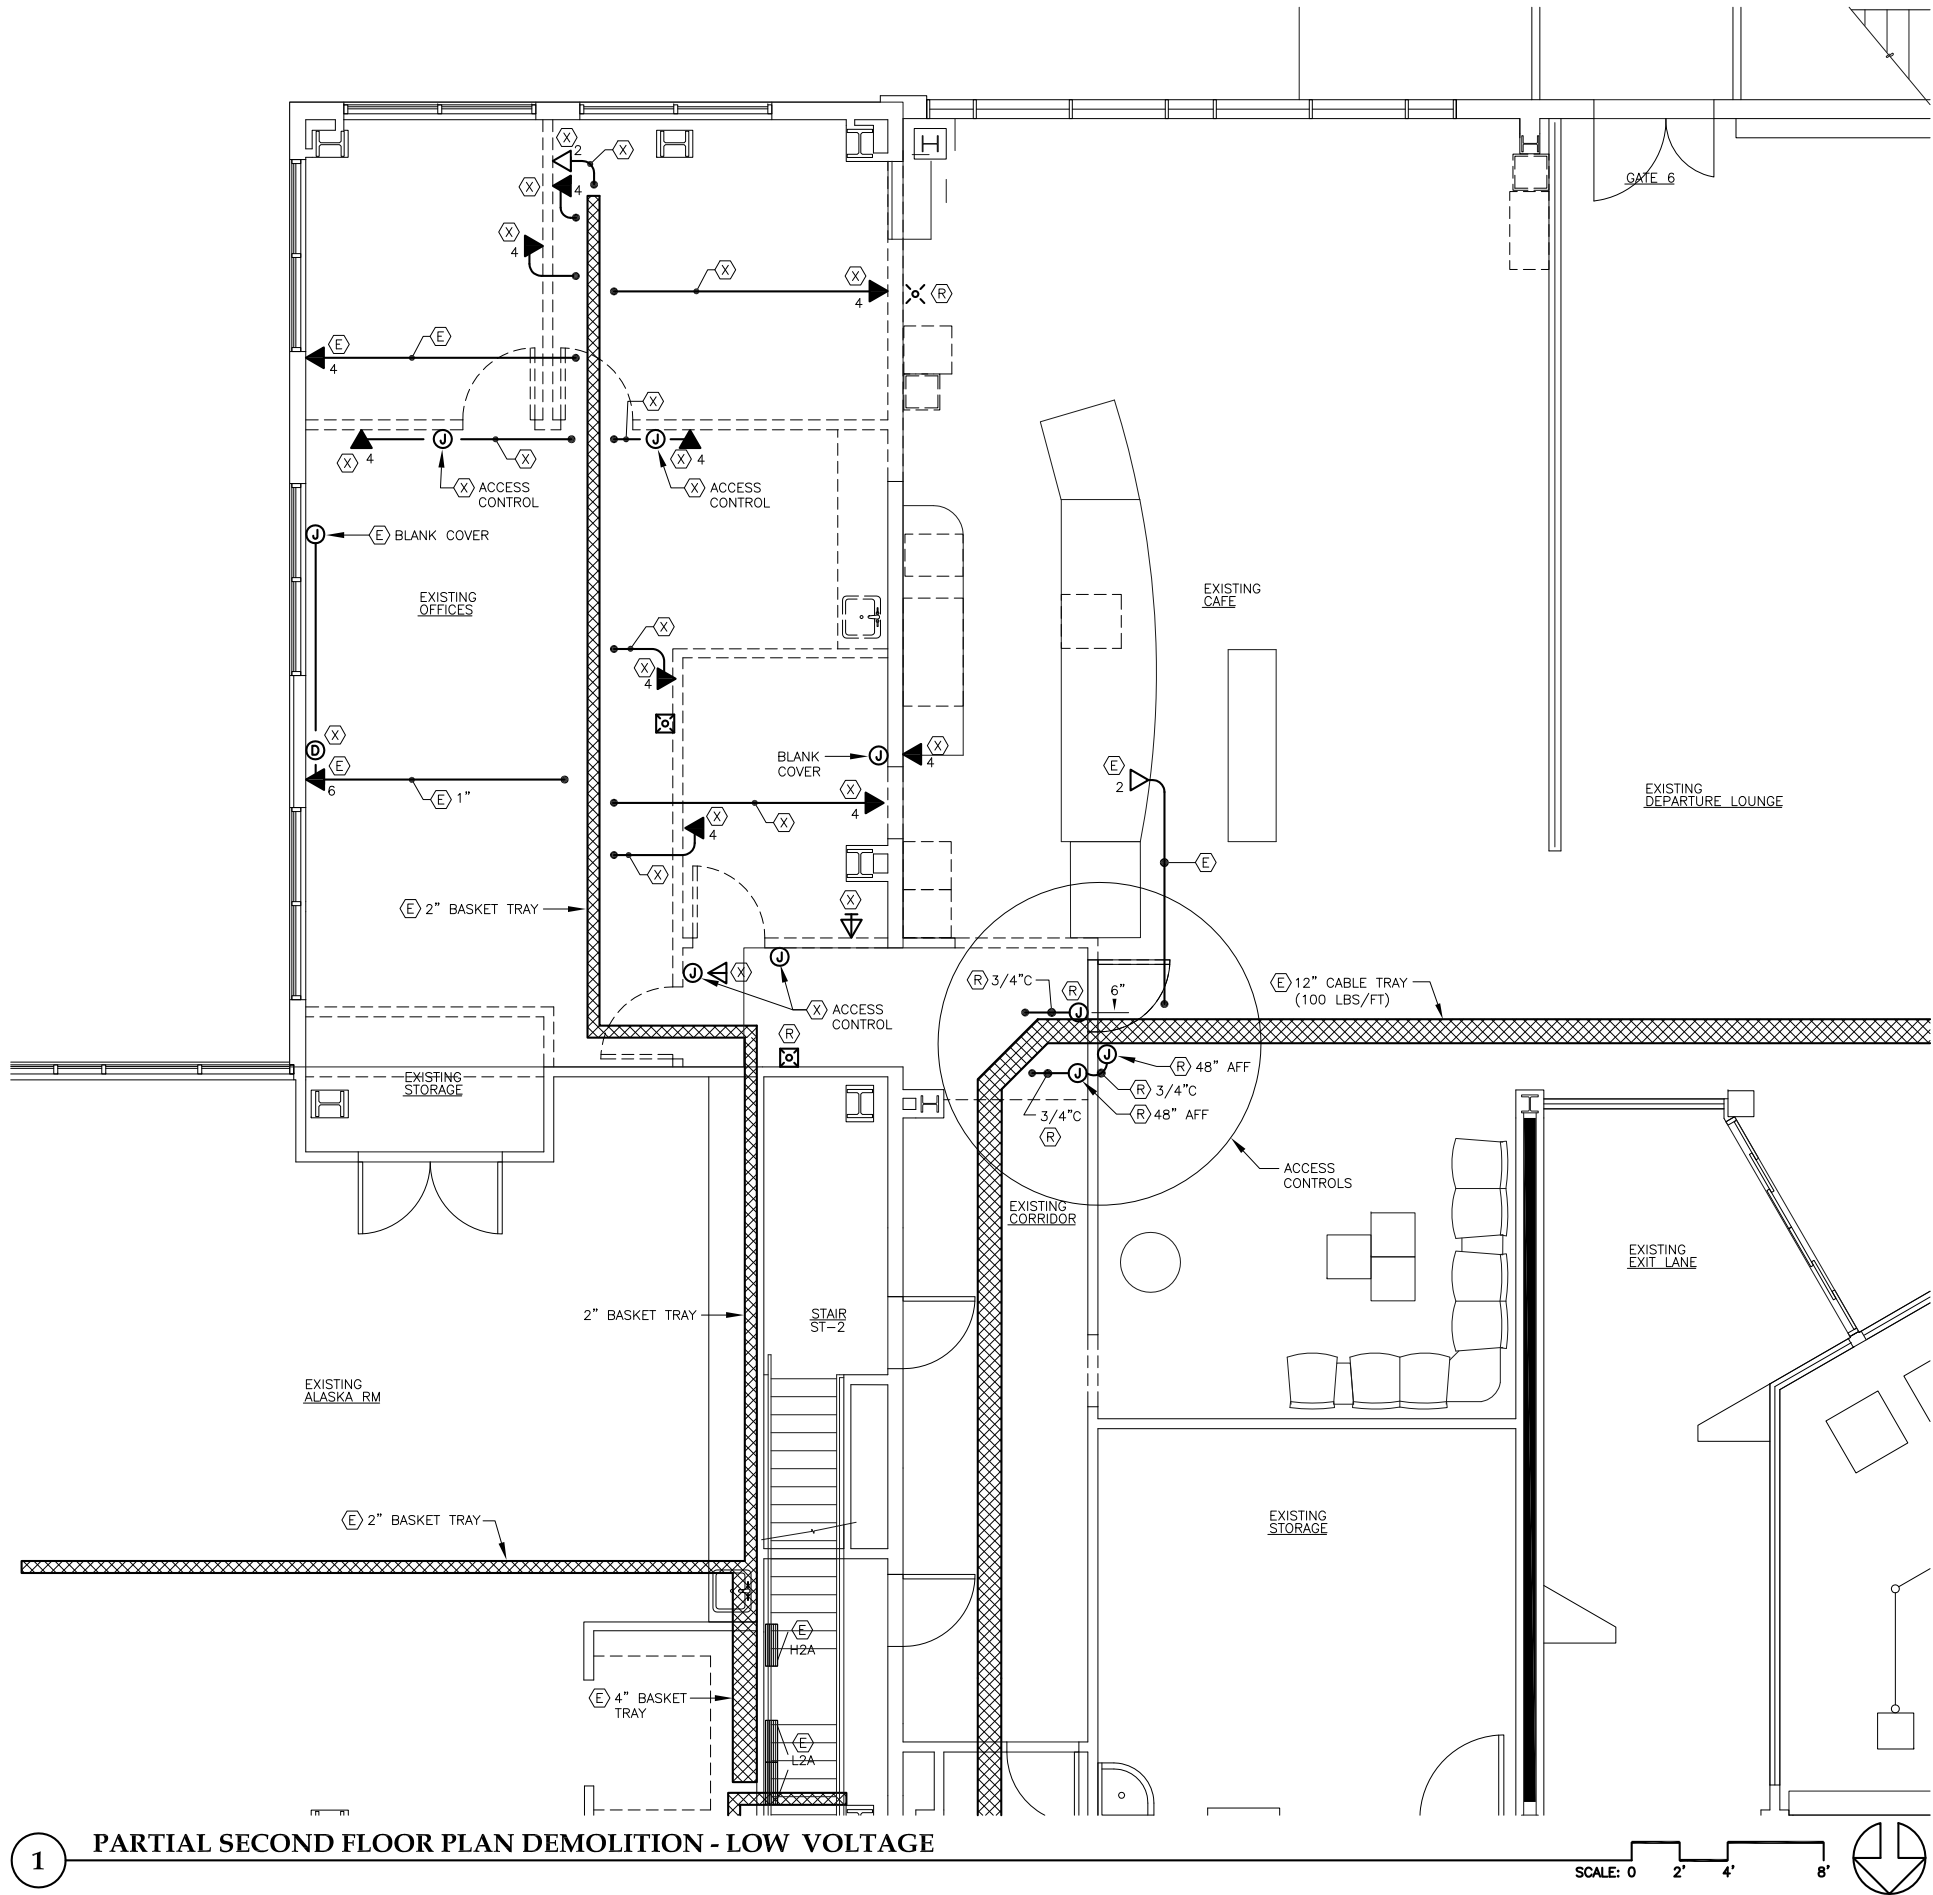


1

PARTIAL SECOND FLOOR PLAN DEMOLITION - LOW VOLTAGE

SCALE: 0 2' 4' 8'

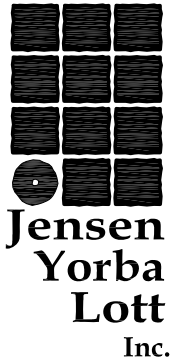

522 West 10th Street
Juneau, Alaska 99801
phone 907-586-1070
fax 907-586-3959
jensenyorbalott.com

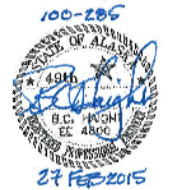

City & Borough of Juneau
Juneau International Airport
CONCESSIONS EXPANSION
CBJ Contract No. E15-195
Juneau, Alaska

BID

REVISIONS




SHEET TITLE

**PARTIAL SECOND
FLOOR PLAN
DEMOLITION
LOW VOLTAGE**

DATE: February 27, 2015

FILE: 11050


ED401

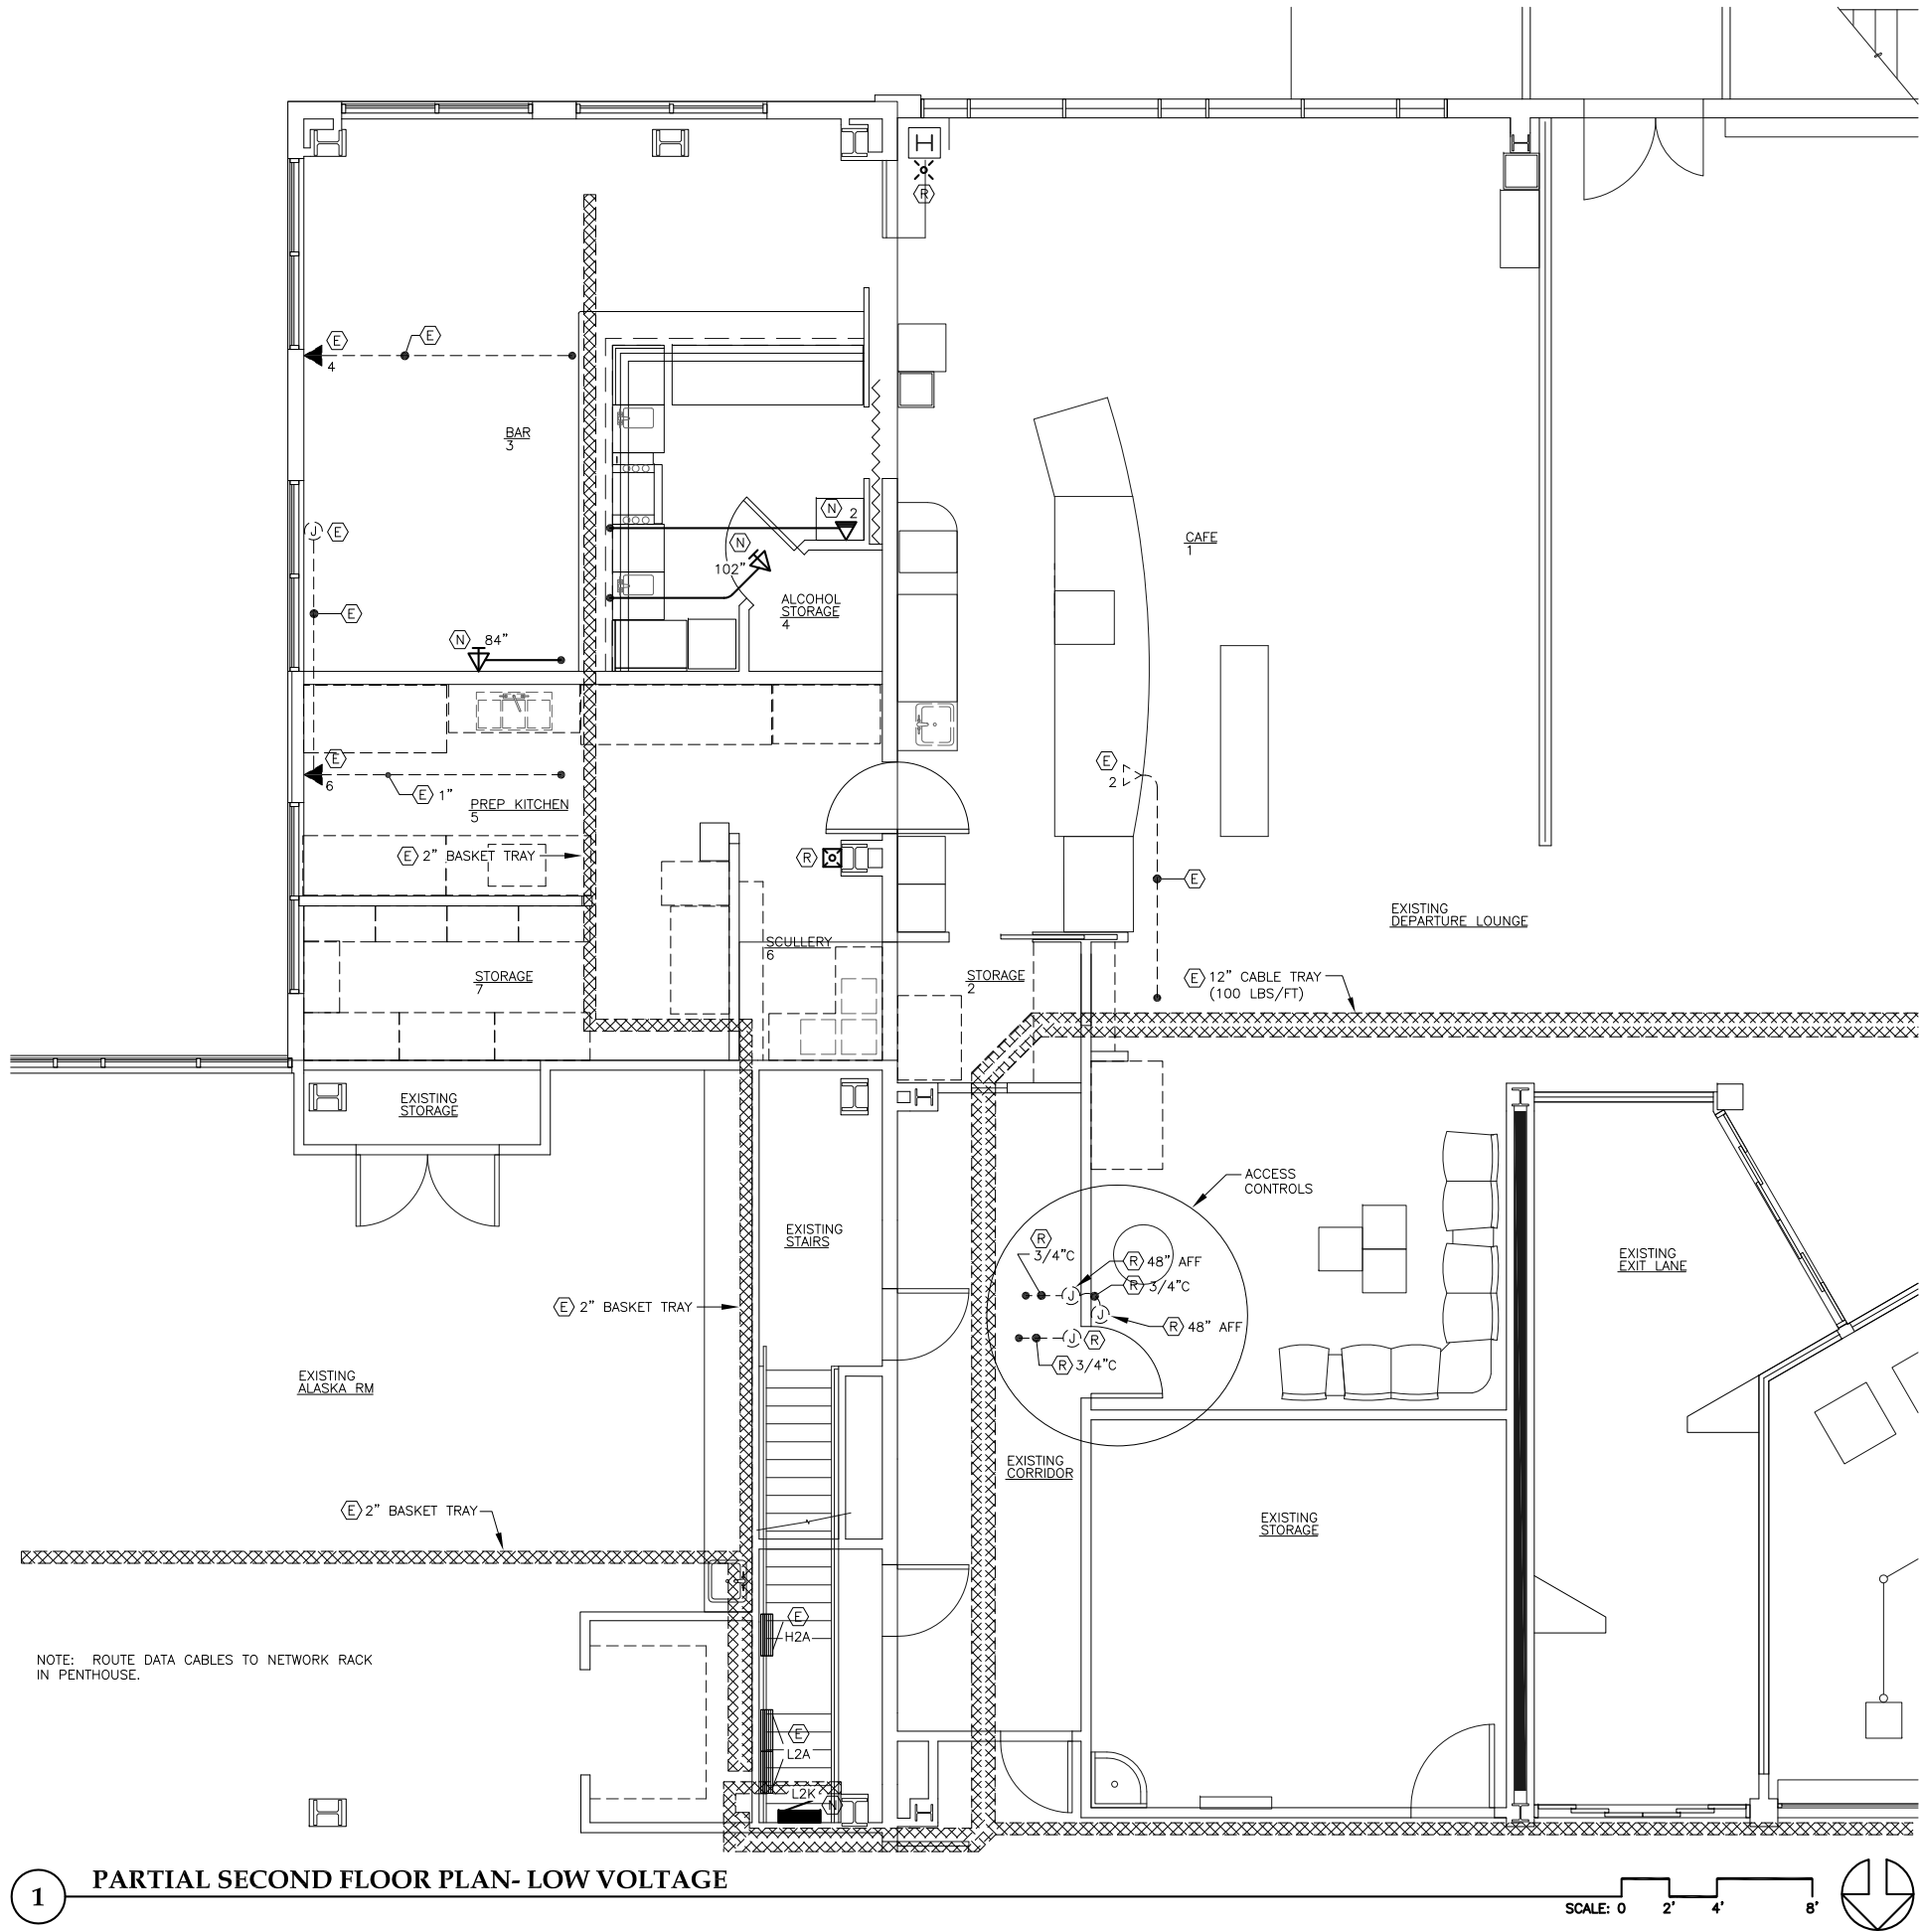

1 PARTIAL SECOND FLOOR PLAN- LOW VOLTAGE

NOTE: ROUTE DATA CABLES TO NETWORK RACK IN PENTHOUSE.

SCALE: 0 2' 4' 8'

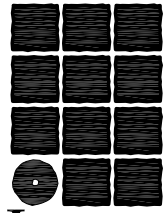

Jensen
Yorba
Lott
Inc.

522 West 10th Street
Juneau, Alaska 99801
phone 907-586-1070
fax 907-586-3959
jensenyorbalott.com



City & Borough of Juneau
Juneau International Airport
CONCESSIONS EXPANSION
CBJ Contract No. E15-195
Juneau, Alaska

BID

REVISIONS
△
△
△

SHEET TITLE
PARTIAL SECOND
FLOOR PLAN
LOW VOLTAGE

DATE: February 27, 2015
FILE: 11050

E401