



The Whale Project Water Feature

Juneau, AK

Index Of Sheets

COVER	Cover Page
WF-1.10	Fountain Finish Plan
WF-1.11	Basin Structure Plan
WF-1.12	Basin Equipment Plan
WF-1.13	Basin Finishes Plan
WF-1.20	Enlarged Plans
WF-1.21	Enlarged Equipment Layout Plans
WF-1.22	Enlarged Electrical Layout Plan
WF=1.23	Enlarged Access Chamber Plan & Elevations
WF-2.00	Elevations
WF-2.10	Elevations (With Water Effects Illustrated)
WF-3.00	Cross Section
WF-3.10	Enlarged Section Details
WF-3.11	Enlarged Section Details
WF-3.12	Enlarged Section Details
WF-H1	Suction Diagram
WF-H2	Suction Diagram
WF-H3	Suction Diagram
WF-H4	Discharge Diagram
WF-H5	Discharge Diagram
WF-H6	Fog and Air Diargam
WF-H7	Hydraulic Schematic and Parts List
WF-E1	Electrical Schematics
WF-E2	Electrical
WF-E3	Electrical
WF-D1	Equipment Details
WF-D2	Equipment Details

IN-HOUSE SIGN-OFFS:

CAD STANDARDS _____ DATE: ____/____/____
SALES _____ DATE: ____/____/____
CONSTRUCTION _____ DATE: ____/____/____
ELECTRICAL _____ DATE: ____/____/____
PRODUCTION _____ DATE: ____/____/____
ENGINEERING _____ DATE: ____/____/____

2015 Wesco Fountains, Inc. Reserves Copyright & Other Rights Restricting These Documents To The Original Site And/Or Purpose For Which They Were Prepared. Reproductions, Changes Or Assignments Are Prohibited. All Stated Dimensions Will Override Scaled Dimensions. Contact Wesco For Clarification(s).

Parts Of These Plans Have Been Generated Using Existing Plans & Information Supplied From Other Sources. All Dimensions And Notations Should Be Checked And Confirmed By General Contractor, Owner, Or Owners Representative Prior To The Start Of Construction.



PRINT DATE:

DRAWN BY: CR
PROJECT #: 3145
QUOTE #: DE 3145
CREATION DATE: 4/24/2013


REV.	DATE
0	9/14/2015

The Whale Project
Water Feature

Project# 3145

D.E.S.D. #2

\\DATA_STORAGE\VOLUME_1\PROJECTS\NEW PROJECTS\2013\THE WHALE PROJECT - 3145\DWG - PLOTTED-9/15/2015 4:14 PM - SHEET SIZE: ARCH EXPAND D (24.00 X 36.00 INCHES)

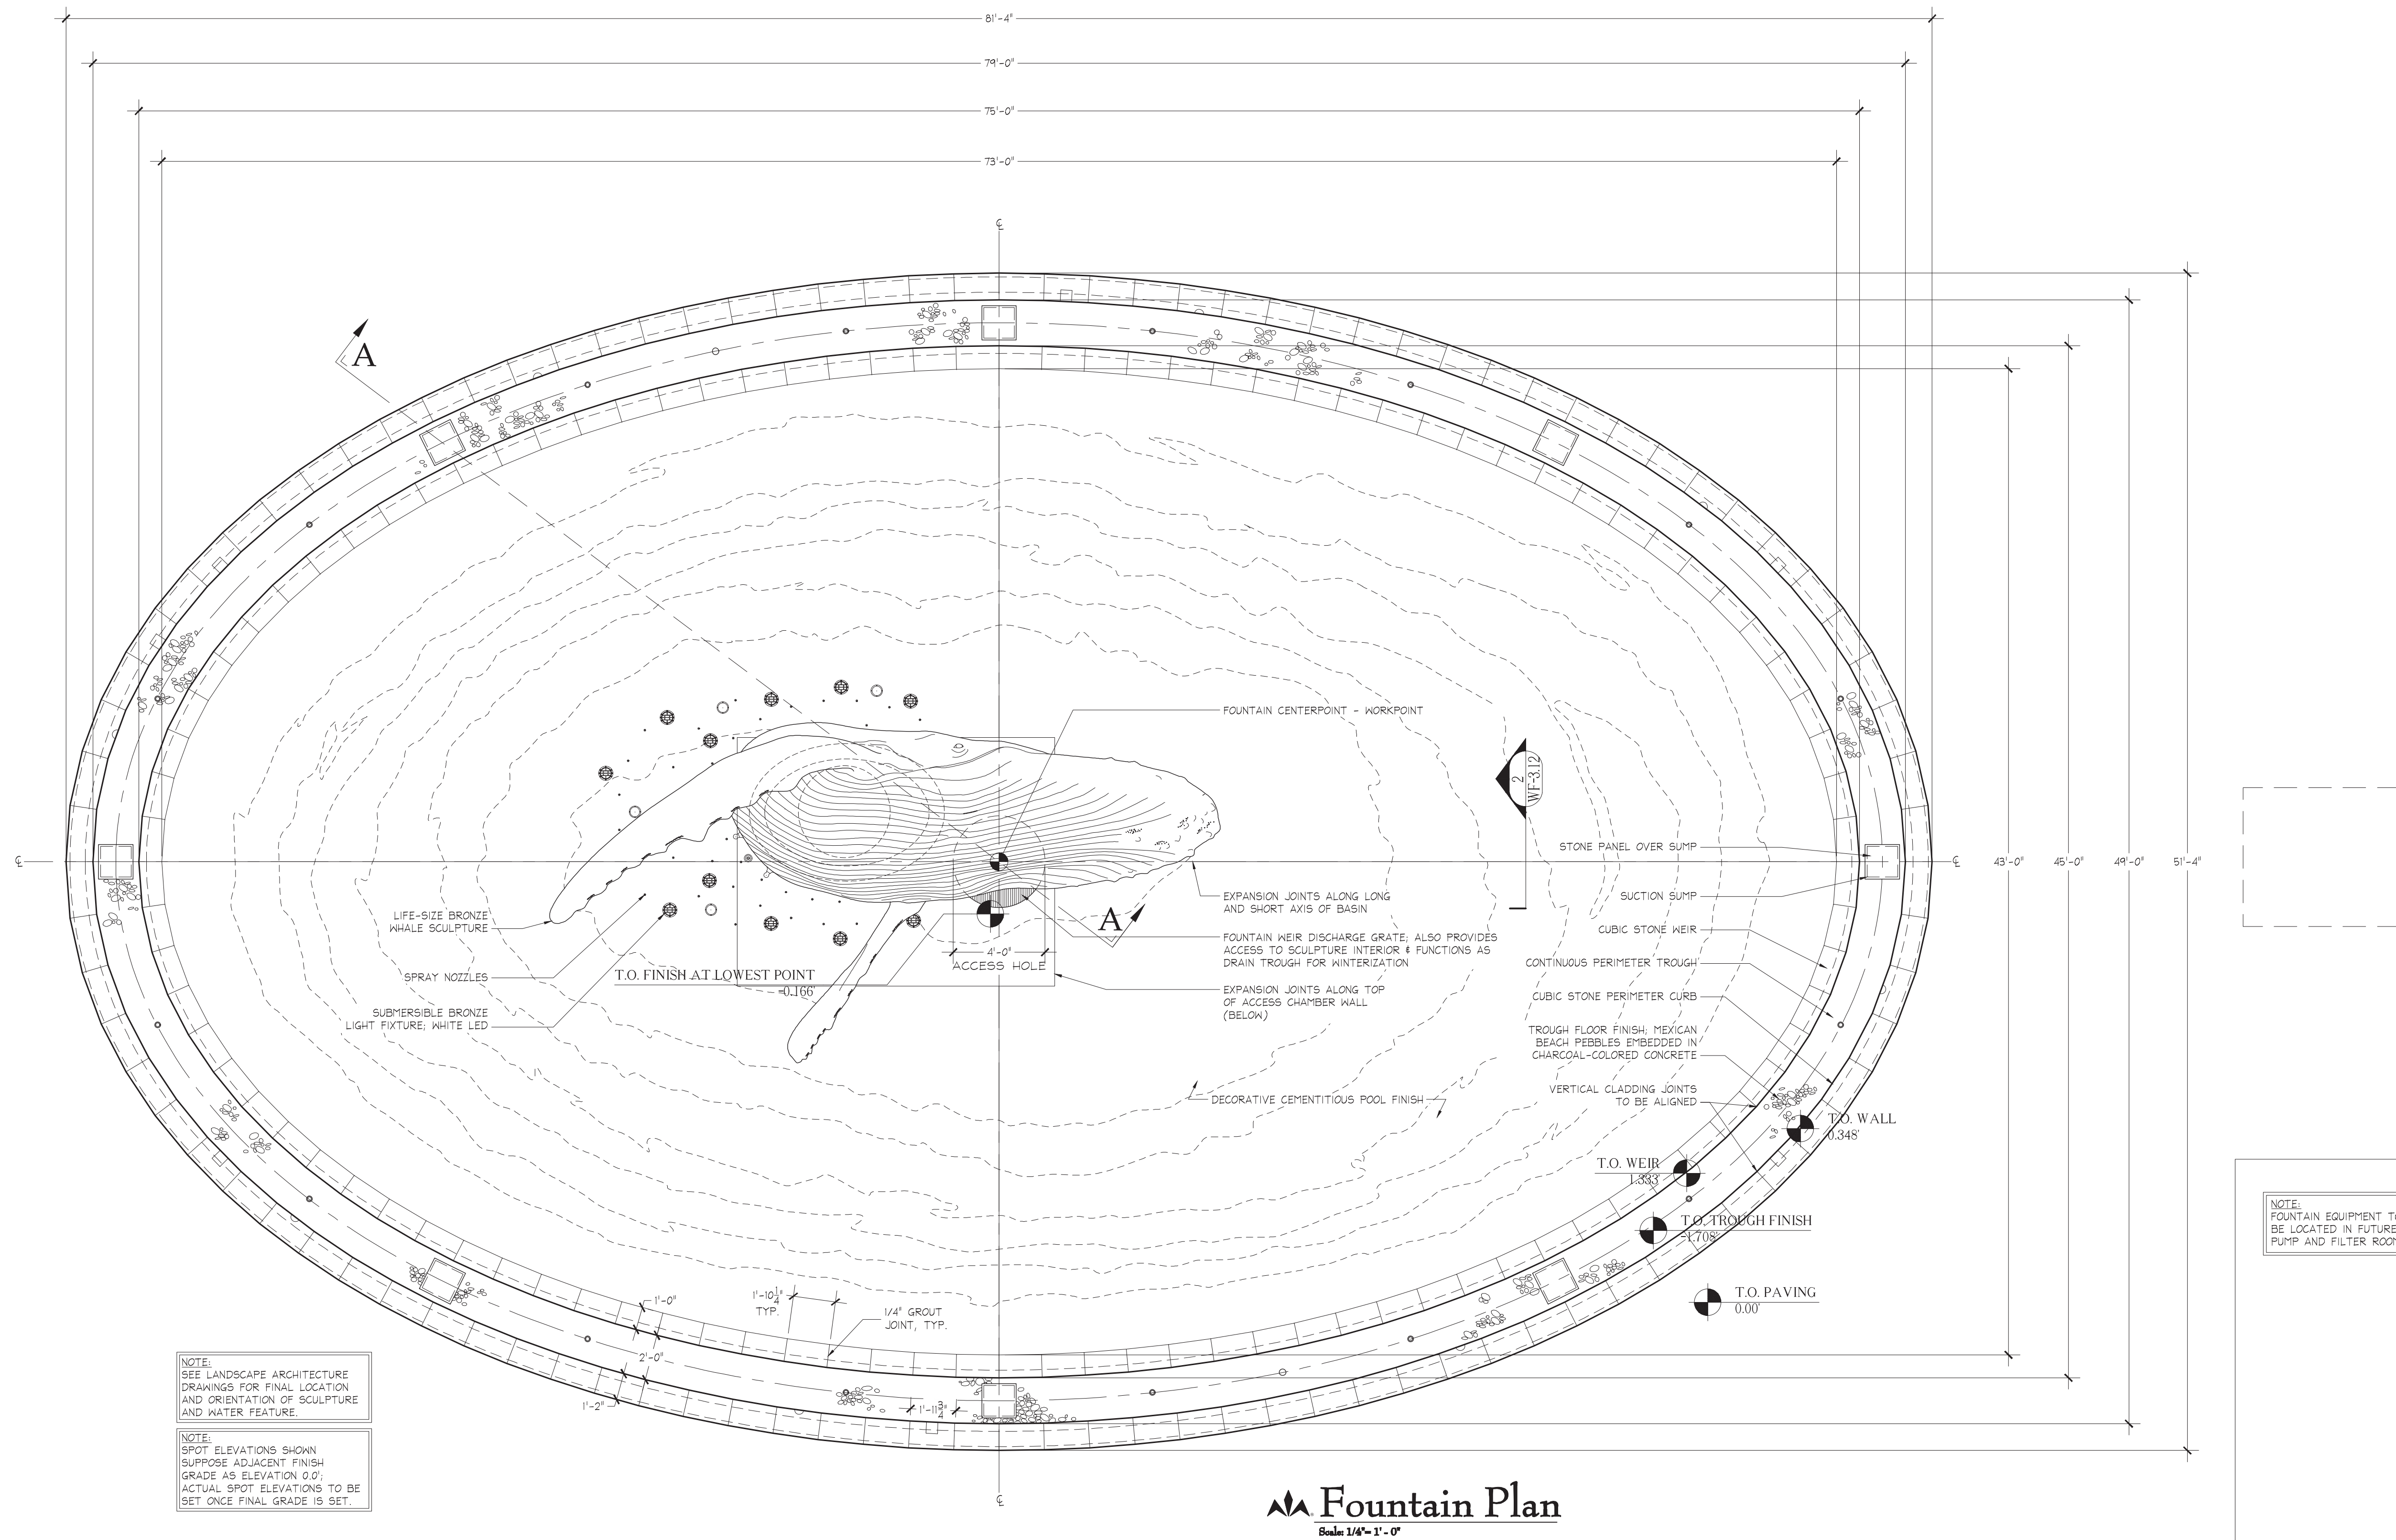

Fountain Plan
Scale: 1/4" = 1' - 0"

NOTE:
SEE LANDSCAPE ARCHITECTURE
DRAWINGS FOR FINAL LOCATION
AND ORIENTATION OF SCULPTURE
AND WATER FEATURE.

NOTE:
SPOT ELEVATIONS SHOWN
SUPPOSE ADJACENT FINISH
GRADE AS ELEVATION 0.0';
ACTUAL SPOT ELEVATIONS TO BE
SET ONCE FINAL GRADE IS SET.

NOTES:


-STRUCTURAL ELEVATIONS SHOWN ARE RELATIVE
ELEVATIONS USING ADJACENT FINISH PAVING AS
BASELINE 0.0' ELEVATION; ONCE ADJ. PAVING
ELEVATION IS SET BY LANDSCAPE ARCHITECTS, ALL
FOUNTAIN SPOT ELEVATIONS MUST BE ADJUSTED
ACCORDINGLY.

NOTE:
FOUNTAIN EQUIPMENT TO
BE LOCATED IN FUTURE
PUMP AND FILTER ROOM

The Whale Project
Water Feature
Fountain Finish Plan

REV	REFERENCE & DESCRIPTION	DATE	BY
1	100% CONSTRUCTION DOCUMENTS	9/14/14	CR

\\DATA_STORAGE\\VOLUME_1\\PROJECTS\\NEW\\PROJECTS-2013\\THE WHALE PROJECT - 3145\\THE WHALE PROJECT - 3145.DWG - PLOTTED: 9/15/2015 4:14 PM - SHEET SIZE: ARCH EXPAND D (24.00 X 36.00 INCHES)

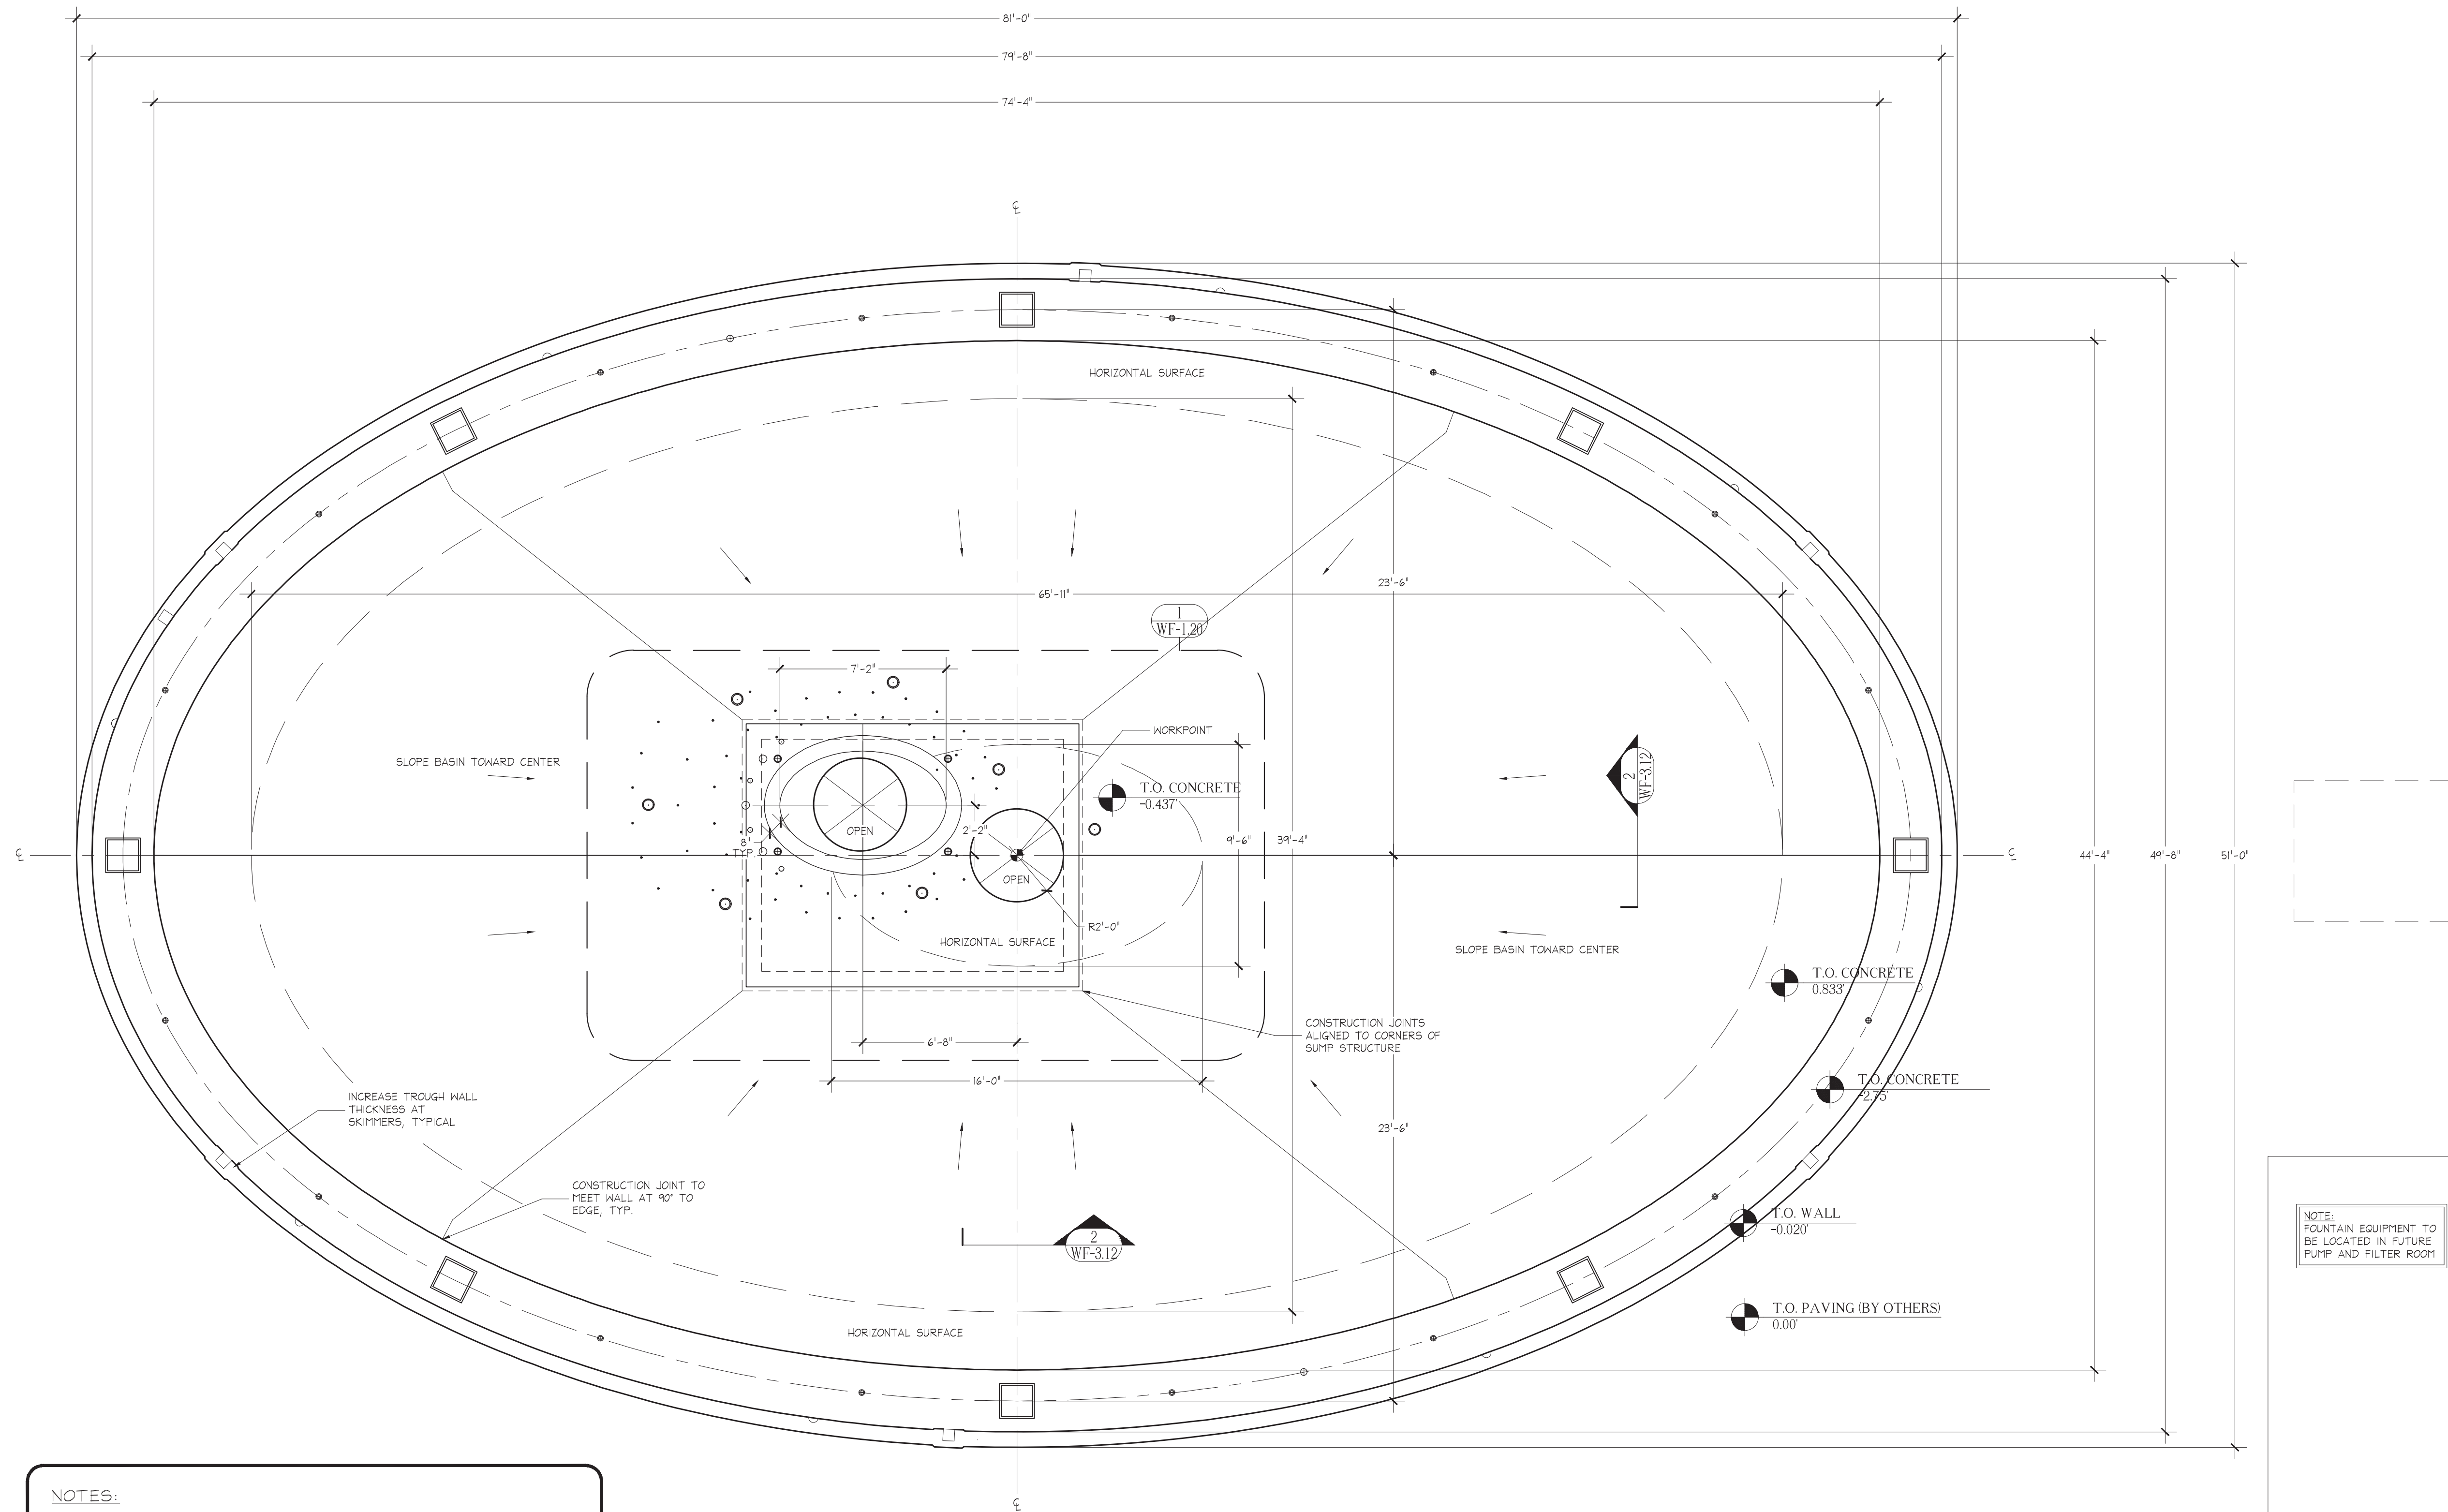

NOTES:
-STRUCTURAL ELEVATIONS SHOWN ARE RELATIVE ELEVATIONS USING ADJACENT FINISH PAVING AS BASELINE 0.0' ELEVATION; ONCE ADJ. PAVING ELEVATION IS SET BY LANDSCAPE ARCHITECTS, ALL FOUNTAIN SPOT ELEVATIONS MUST BE ADJUSTED ACCORDINGLY.

Basin Structure Plan
Scale: 1/4" = 1' - 0"

REV. 0 DATE 9/14/2015

WESCO *fountains* INCORPORATED
THE ART OF WATER
www.wescofountains.com

REV	REFERENCE & DESCRIPTION	DATE	BY
100%	CONSTRUCTION DOCUMENTS	2/14/14	CR

D.E.S.D. NO.: 2
DRAWN BY: CR
PROJECT NO.: 3145
DATE: 9/14/15


The Whale Project
Water Feature
Basin Structural Plan

3445 TECHNOLOGY DRIVE
NORTH VENICE, FLORIDA 34275
PHONE: 941.484.9224
FAX: 941.484.9302

WESCO *fountains* INCORPORATED
THE ART OF WATER
www.wescofountains.com

WF-1.11

\\DATA_STORAGE\\VOLUME_1\\PROJECTS\\NEW\\PROJECTS-2013\\THE WHALE PROJECT - 3145.DWG - PLOTTED: 9/15/2015 4:14 PM - SHEET SIZE: ARCH EXPAND D (24.00 X 36.00 INCHES)

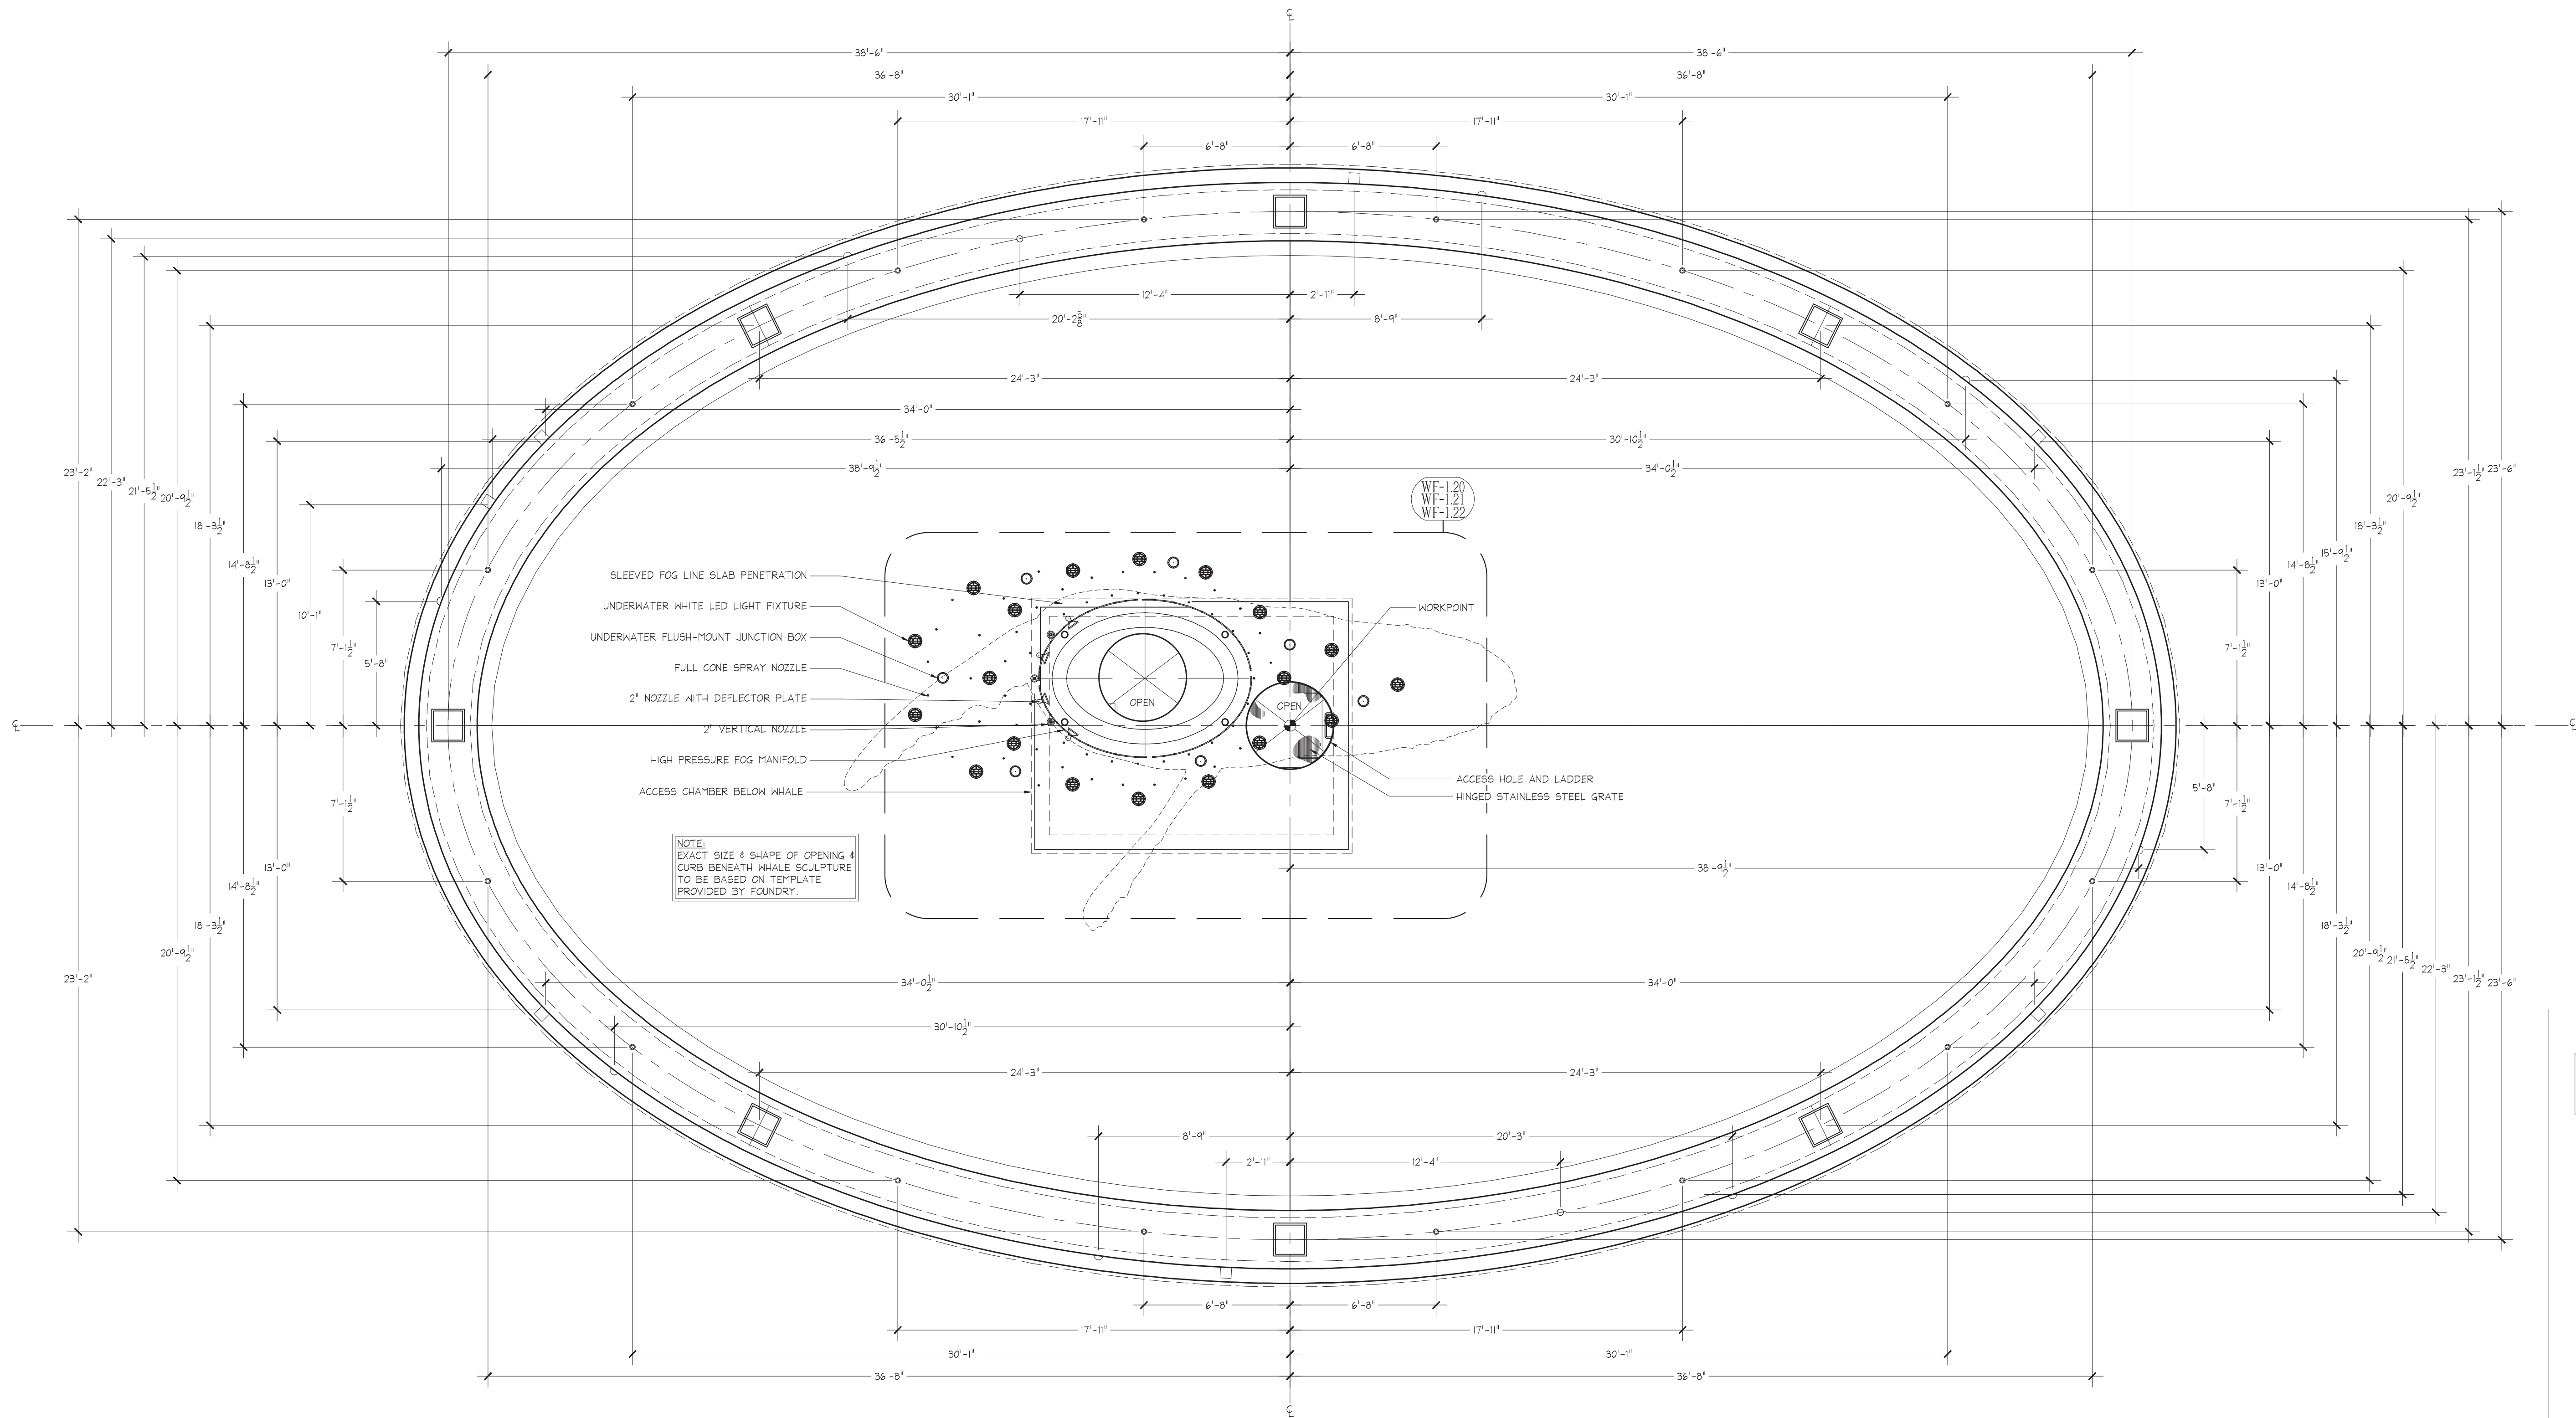

Basin Equipment Plan

Scale: 1/4" = 1' - 0"



REV. 0 DATE 9/14/2015

The Whale Project

Water Feature


Basin Equipment Plan

REV	REFERENCE & DESCRIPTION	DATE	BY
100%	CONSTRUCTION DOCUMENTS	2/14/14	CR

D.E.S.D. NO.: 2
DRAWN BY: CR
PROJECT NO.: 3145
DATE: 9/14/15


WF-1.12

\\DATA_STORAGE\\VOLUME_1\\PROJECTS\\NEW\\PROJECTS-2013\\THE WHALE PROJECT - 3145\\THE WHALE PROJECT - 3145.DWG - PLOTTED: 9/15/2015 4:14 PM - SHEET SIZE: ARCH EXHIBIT D (24.00 X 36.00 INCHES)

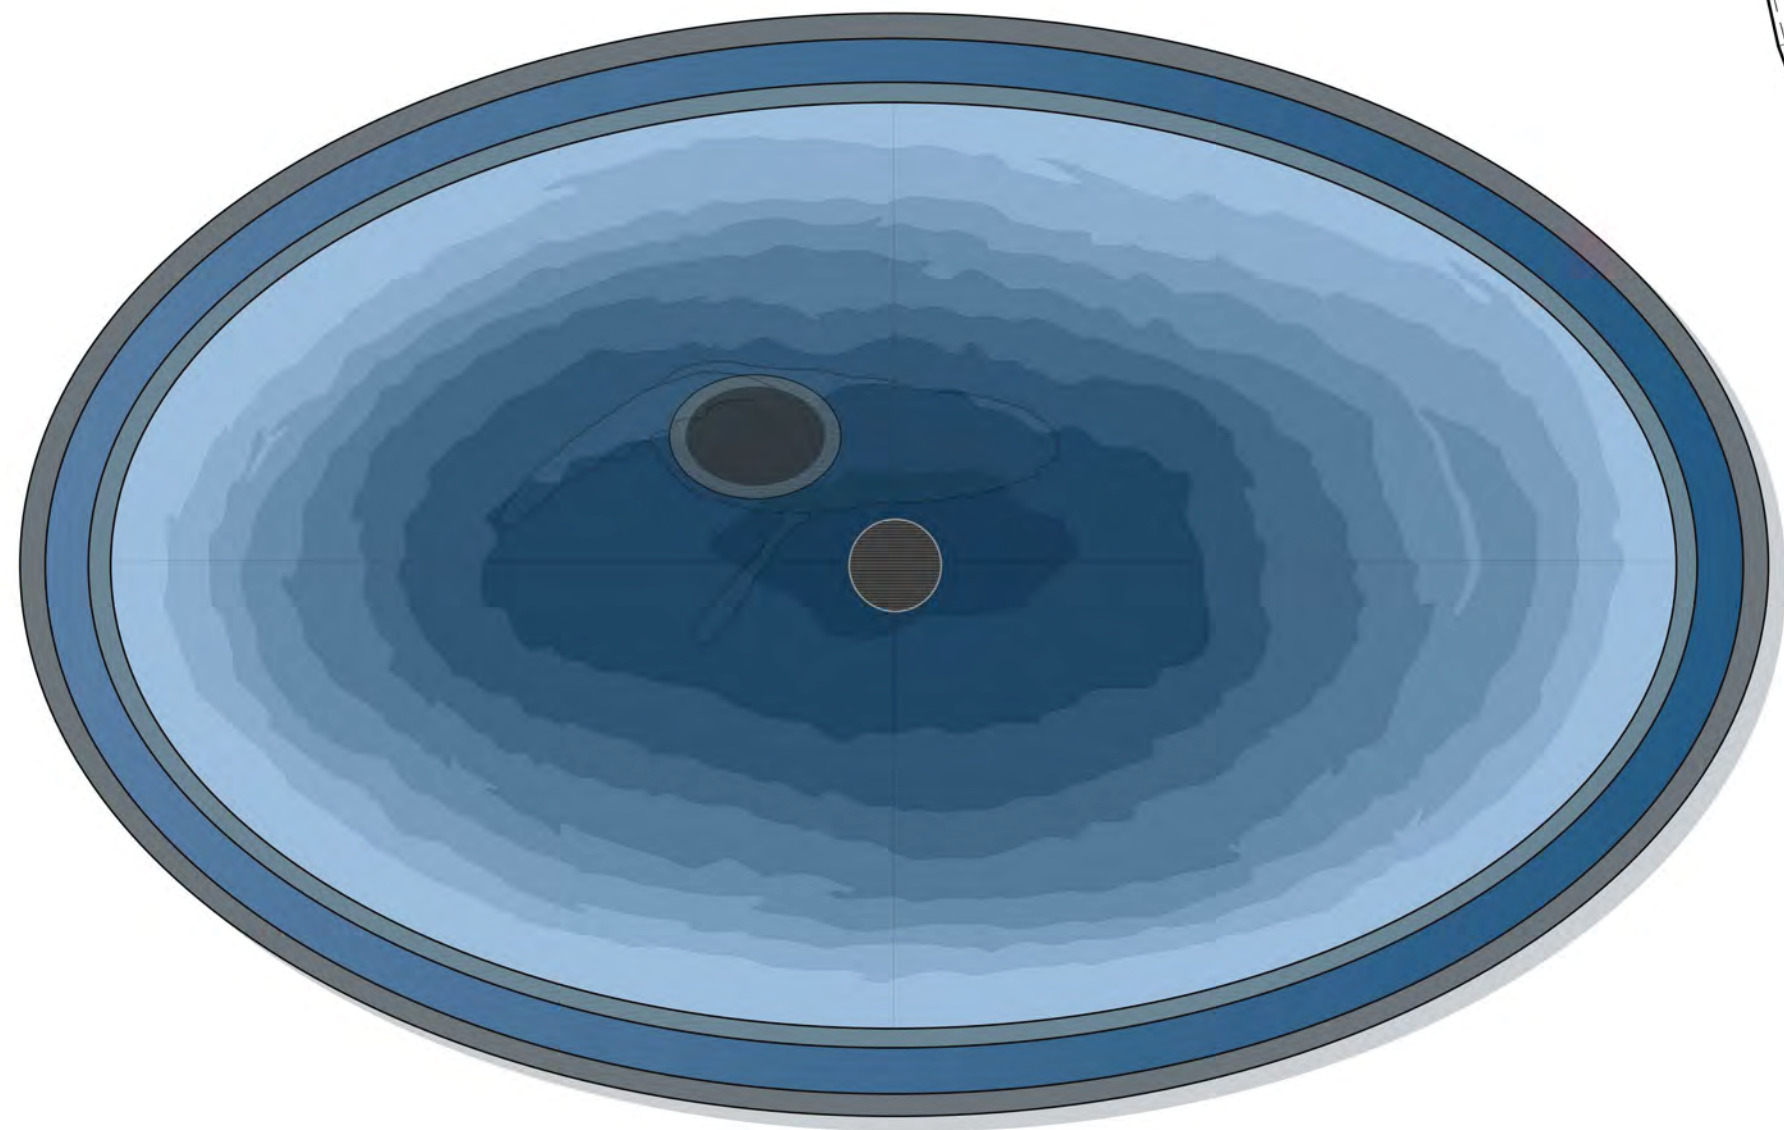

Color Finish Plan
Scale: 3/16" = 1'-0"

NOTE:
COLOR PDF OF THE PLAN IS AVAILABLE FROM WESCO FOUNTAINS FOR REFERENCE. FINISH MATERIAL TO BE SUPER-KRETE S-120 COLOR-BOND, CUSTOM COLORED BY INSTALLER FOR PROJECT. COLOR SAMPLES FOR EACH COLOR BAND TO BE APPROVED BY ARTIST PRIOR TO INSTALLATION.

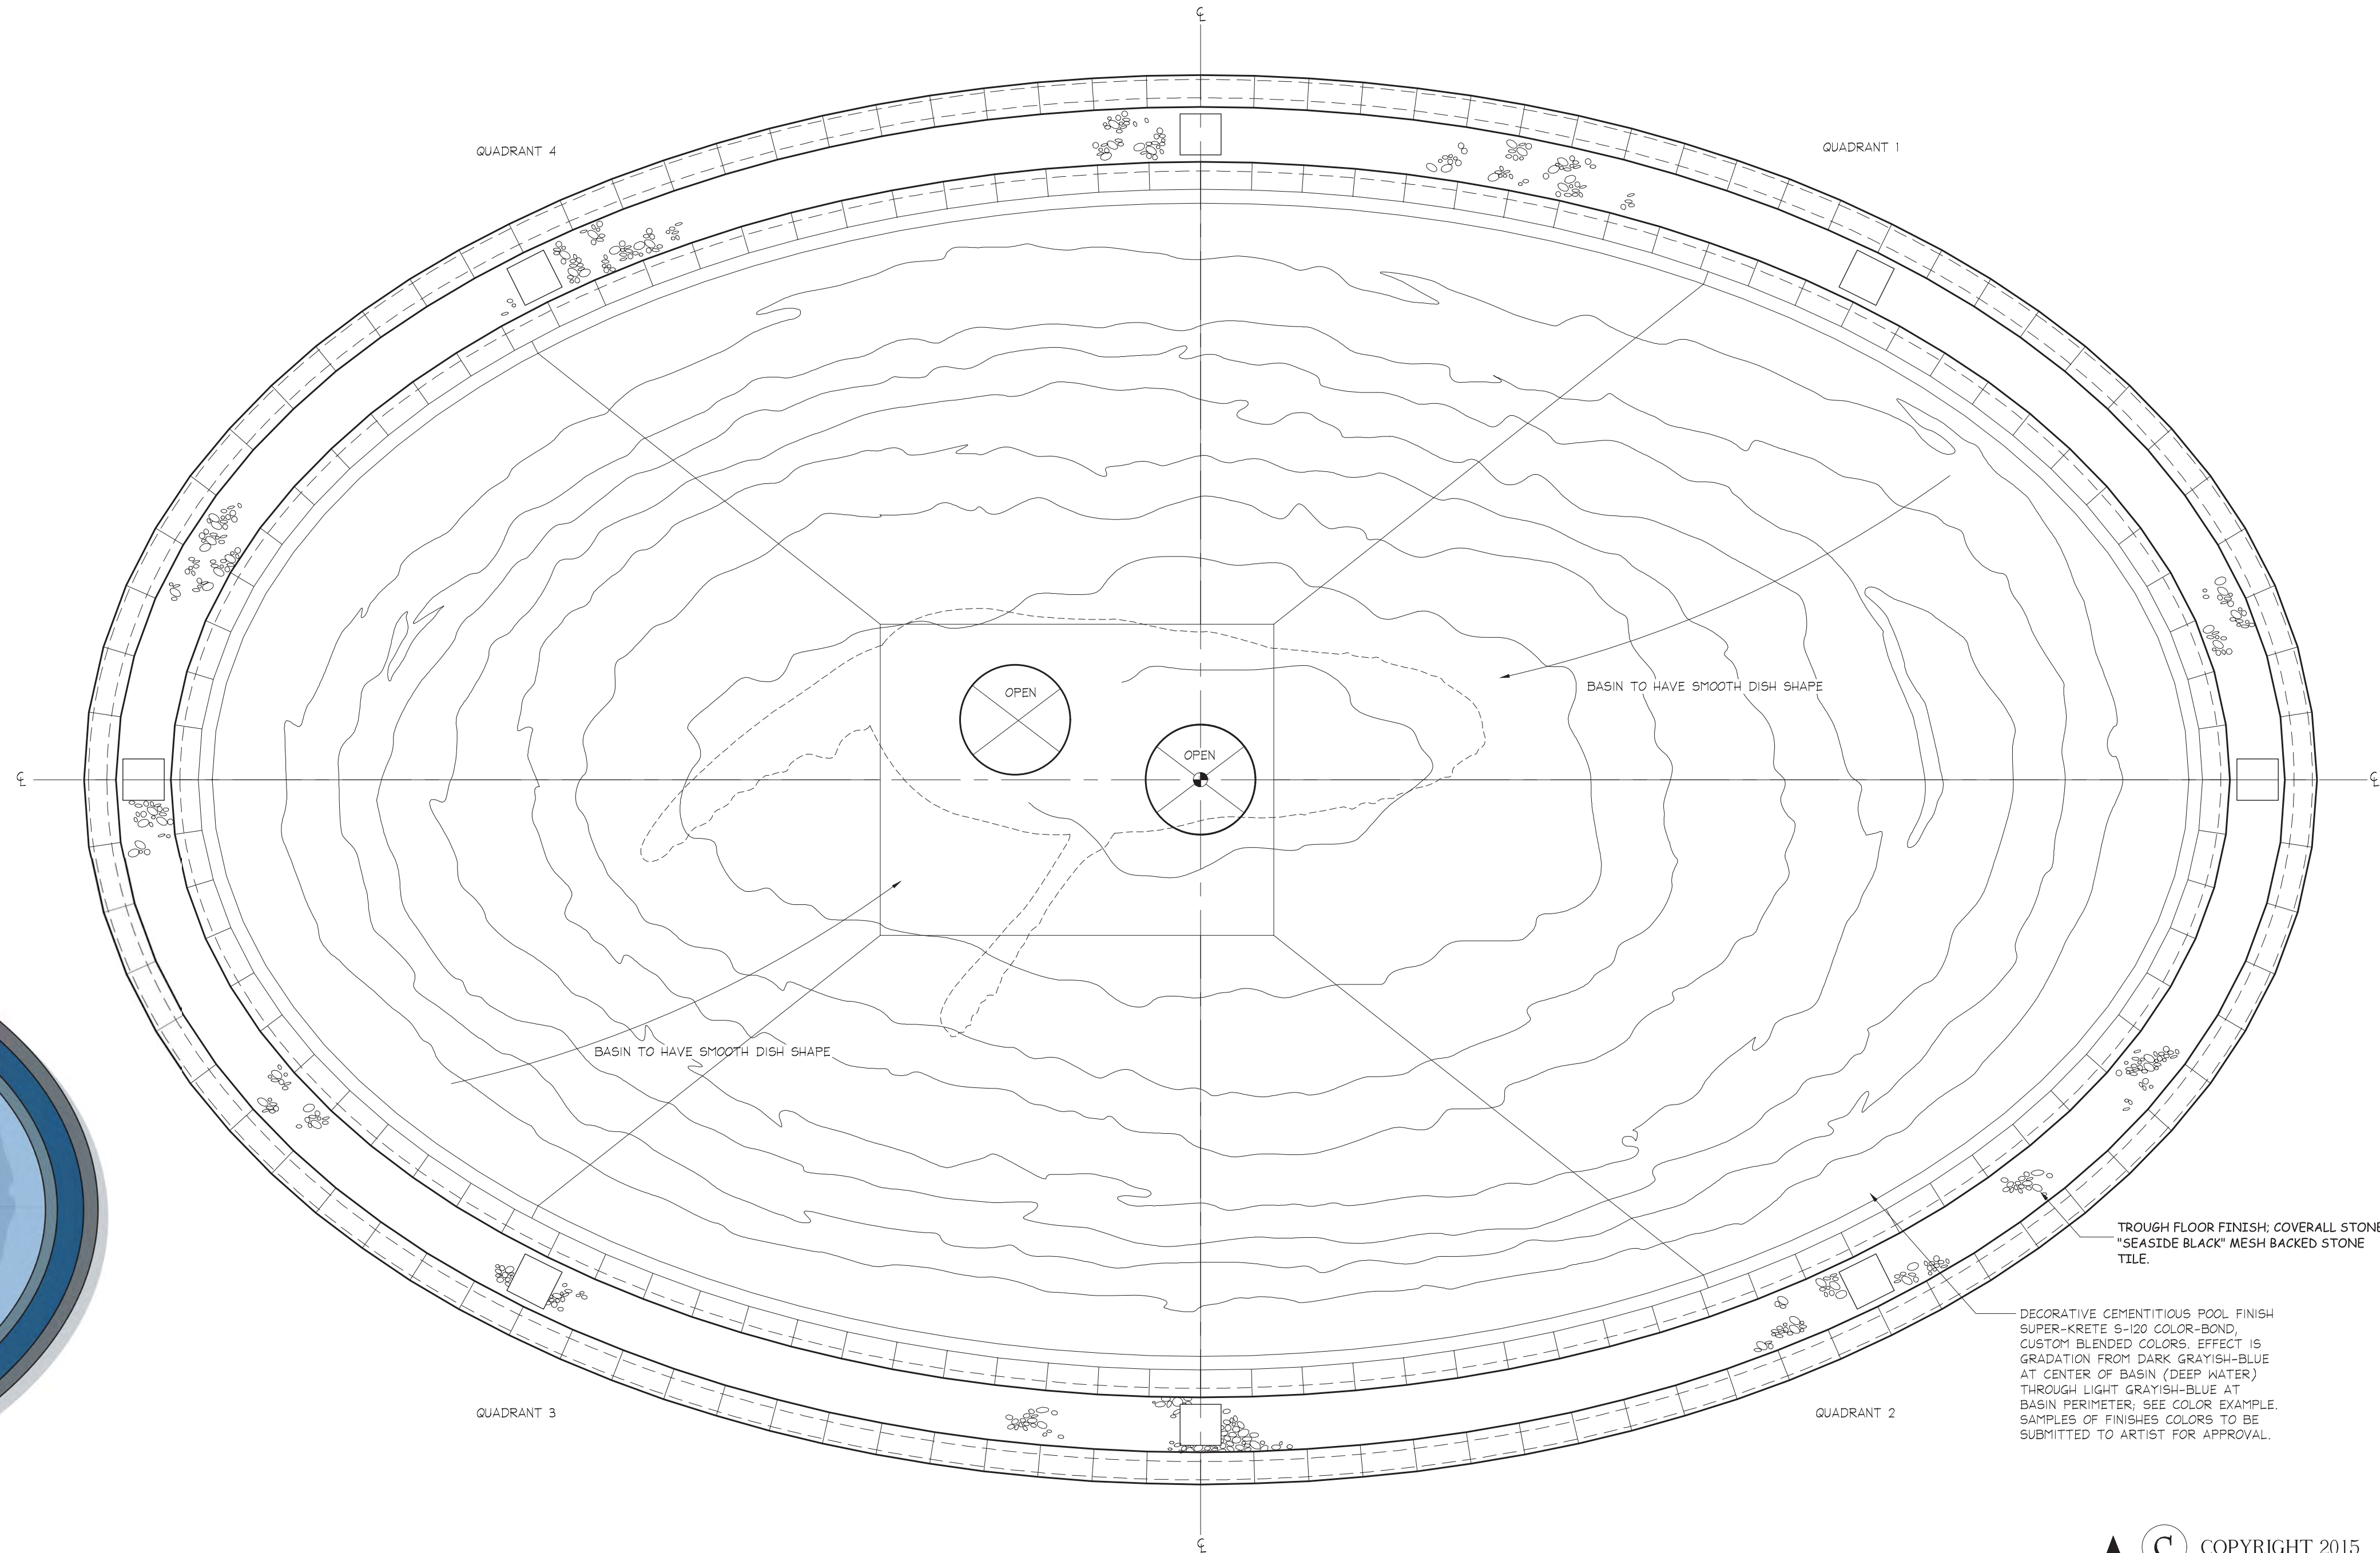


REV. 0 DATE 9/14/2015

The Whale Project
Water Feature
Basin Equipment Plan

REV	DESCRIPTION	DATE	BY
100%	CONSTRUCTION DOCUMENTS	2/14/14	CR

D.E.S.D. NO.: 2
DRAWN BY: CR
PROJECT NO.: 3145
DATE: 9/14/15


WF-1.13

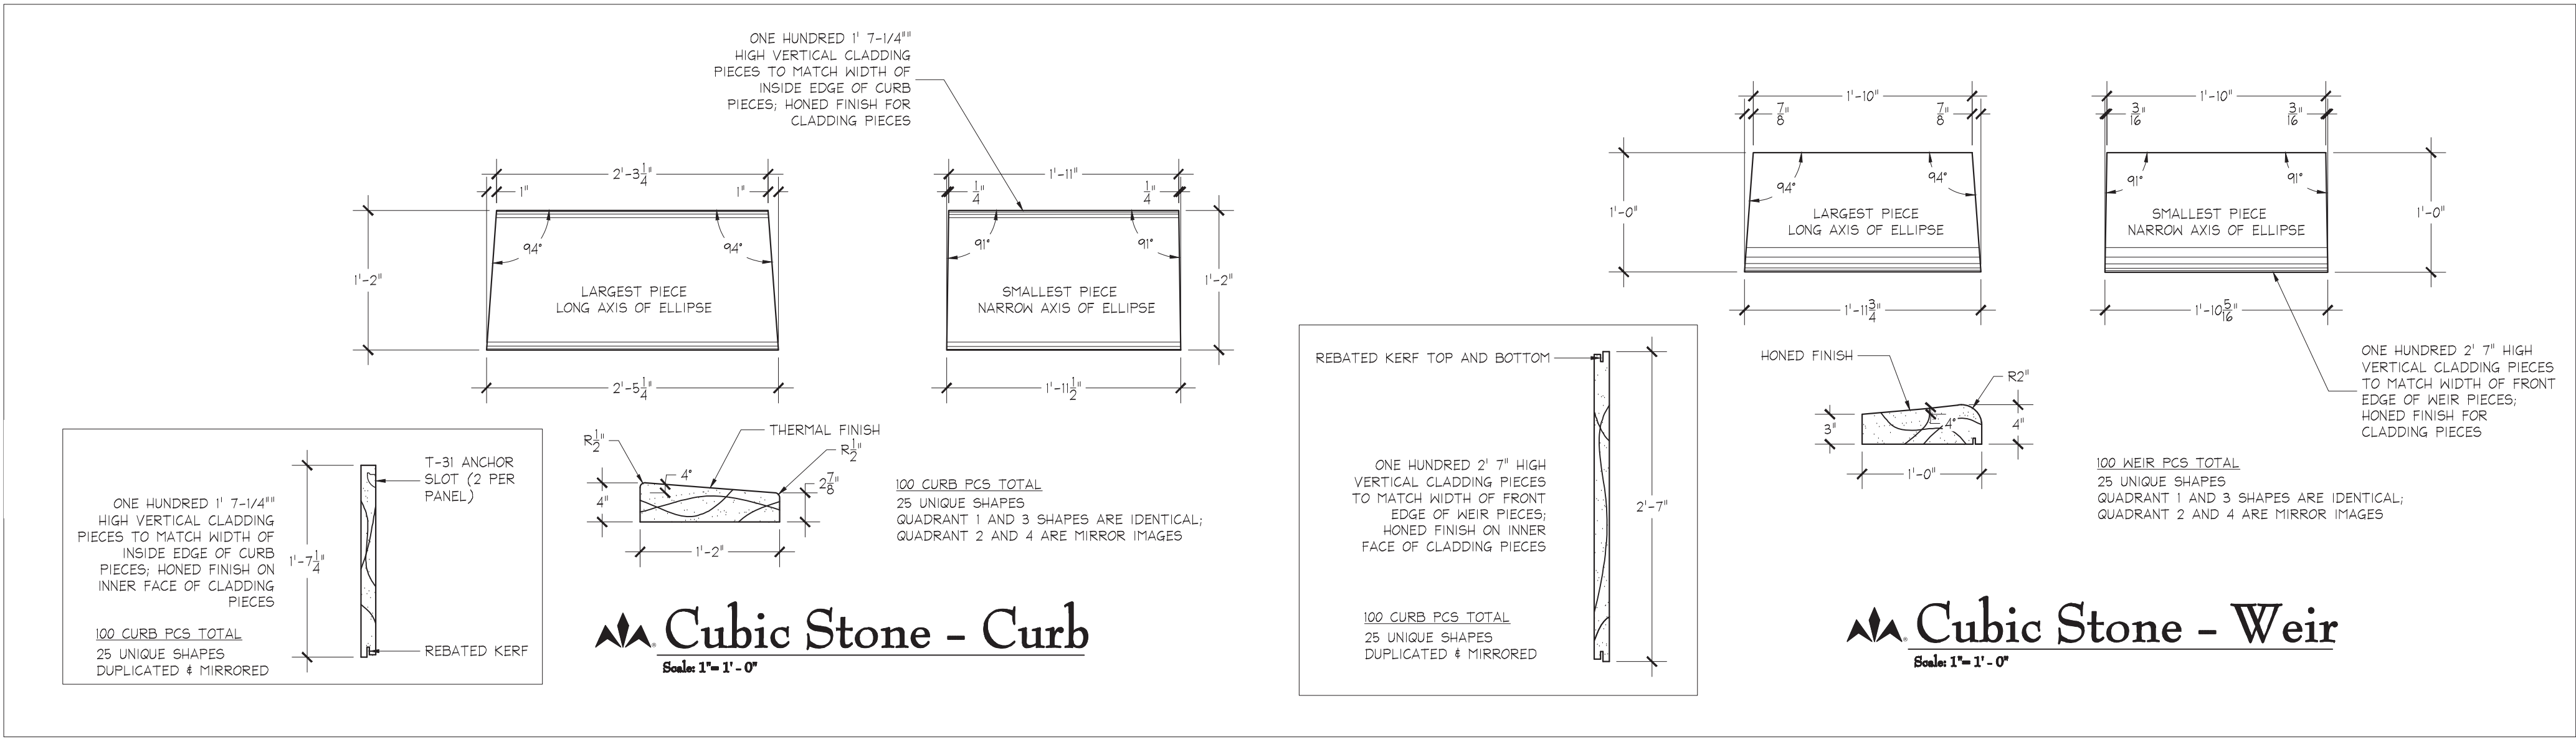


3445 TECHNOLOGY DRIVE
NORTH VENICE, FLORIDA 34275
PHONE: 941.484.9324
FAX: 941.484.9302

WESCO *fountains* THE ART OF WATER
www.wescofountains.com


\\DATA_STORAGE\\VOLUME_1\\PROJECTS\\NEWPROJECTS\\2013\\THE WHALE PROJECT - 3145.DWG - PLOTTED: 9/15/2015 4:14 PM - SHEET SIZE: ARCH EXPAND D (24.00 X 36.00 INCHES)

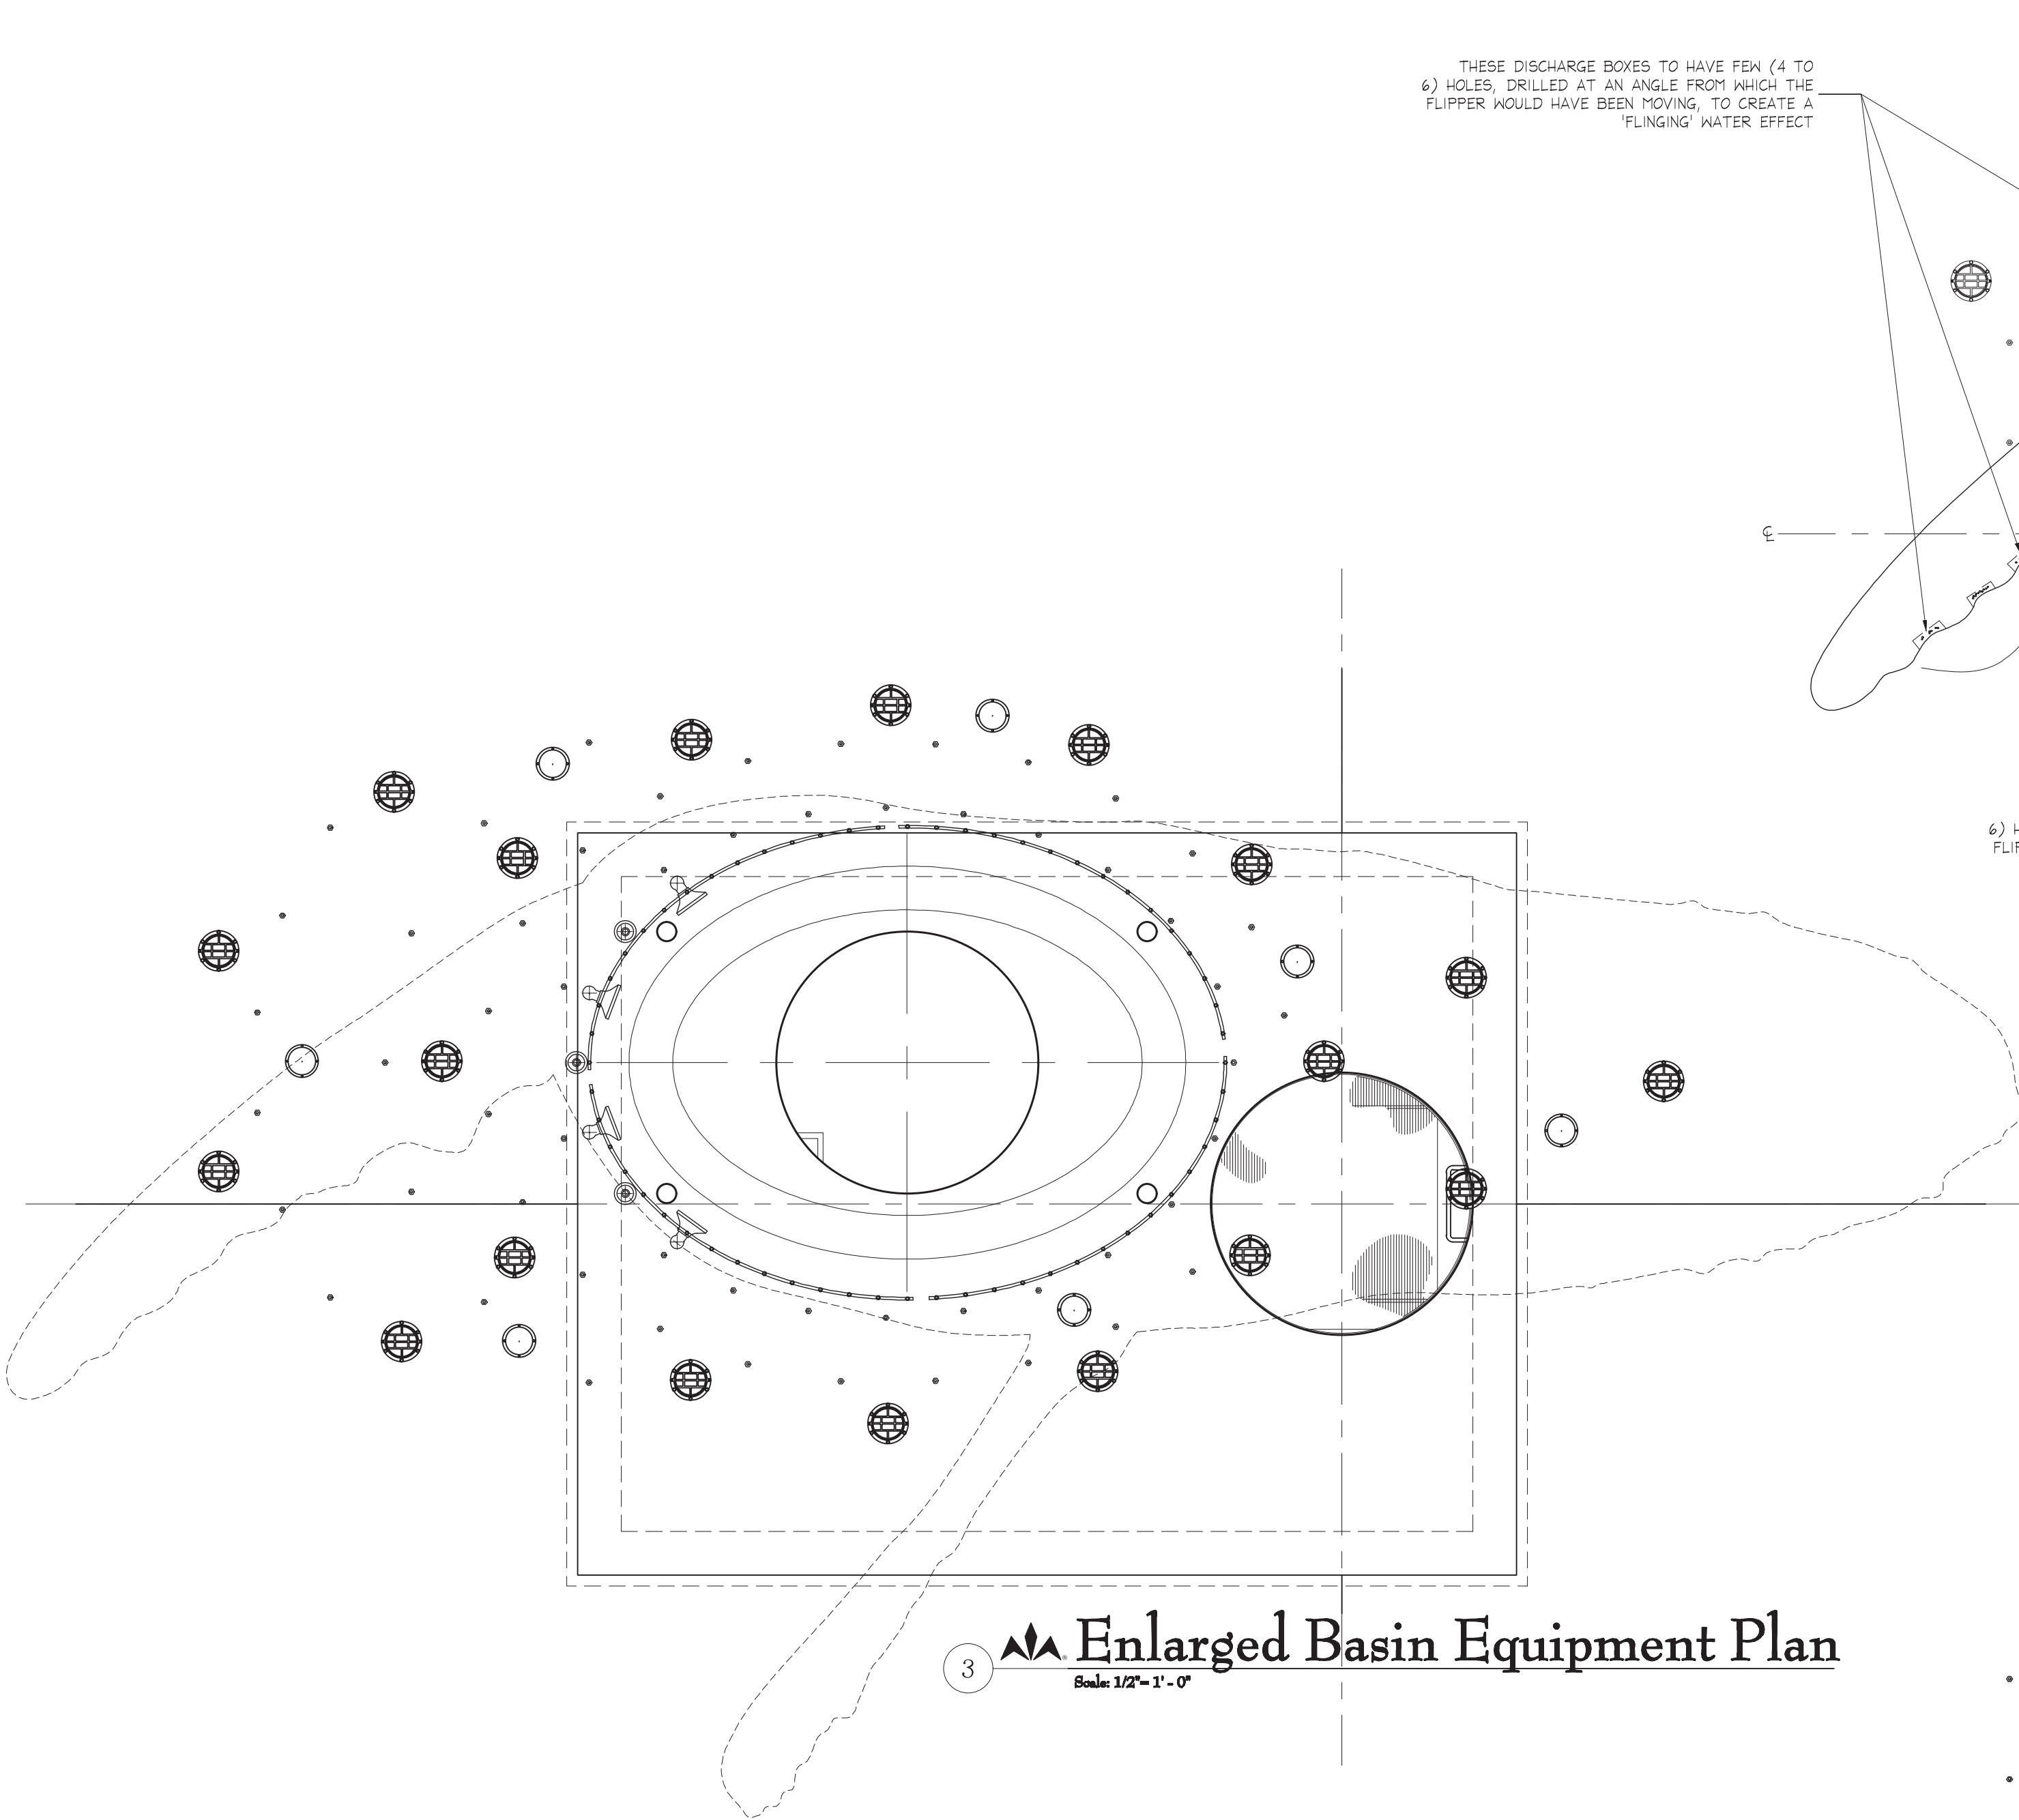

3 **Enlarged Basin Equipment Plan**
Scale: 1/2" = 1' - 0"

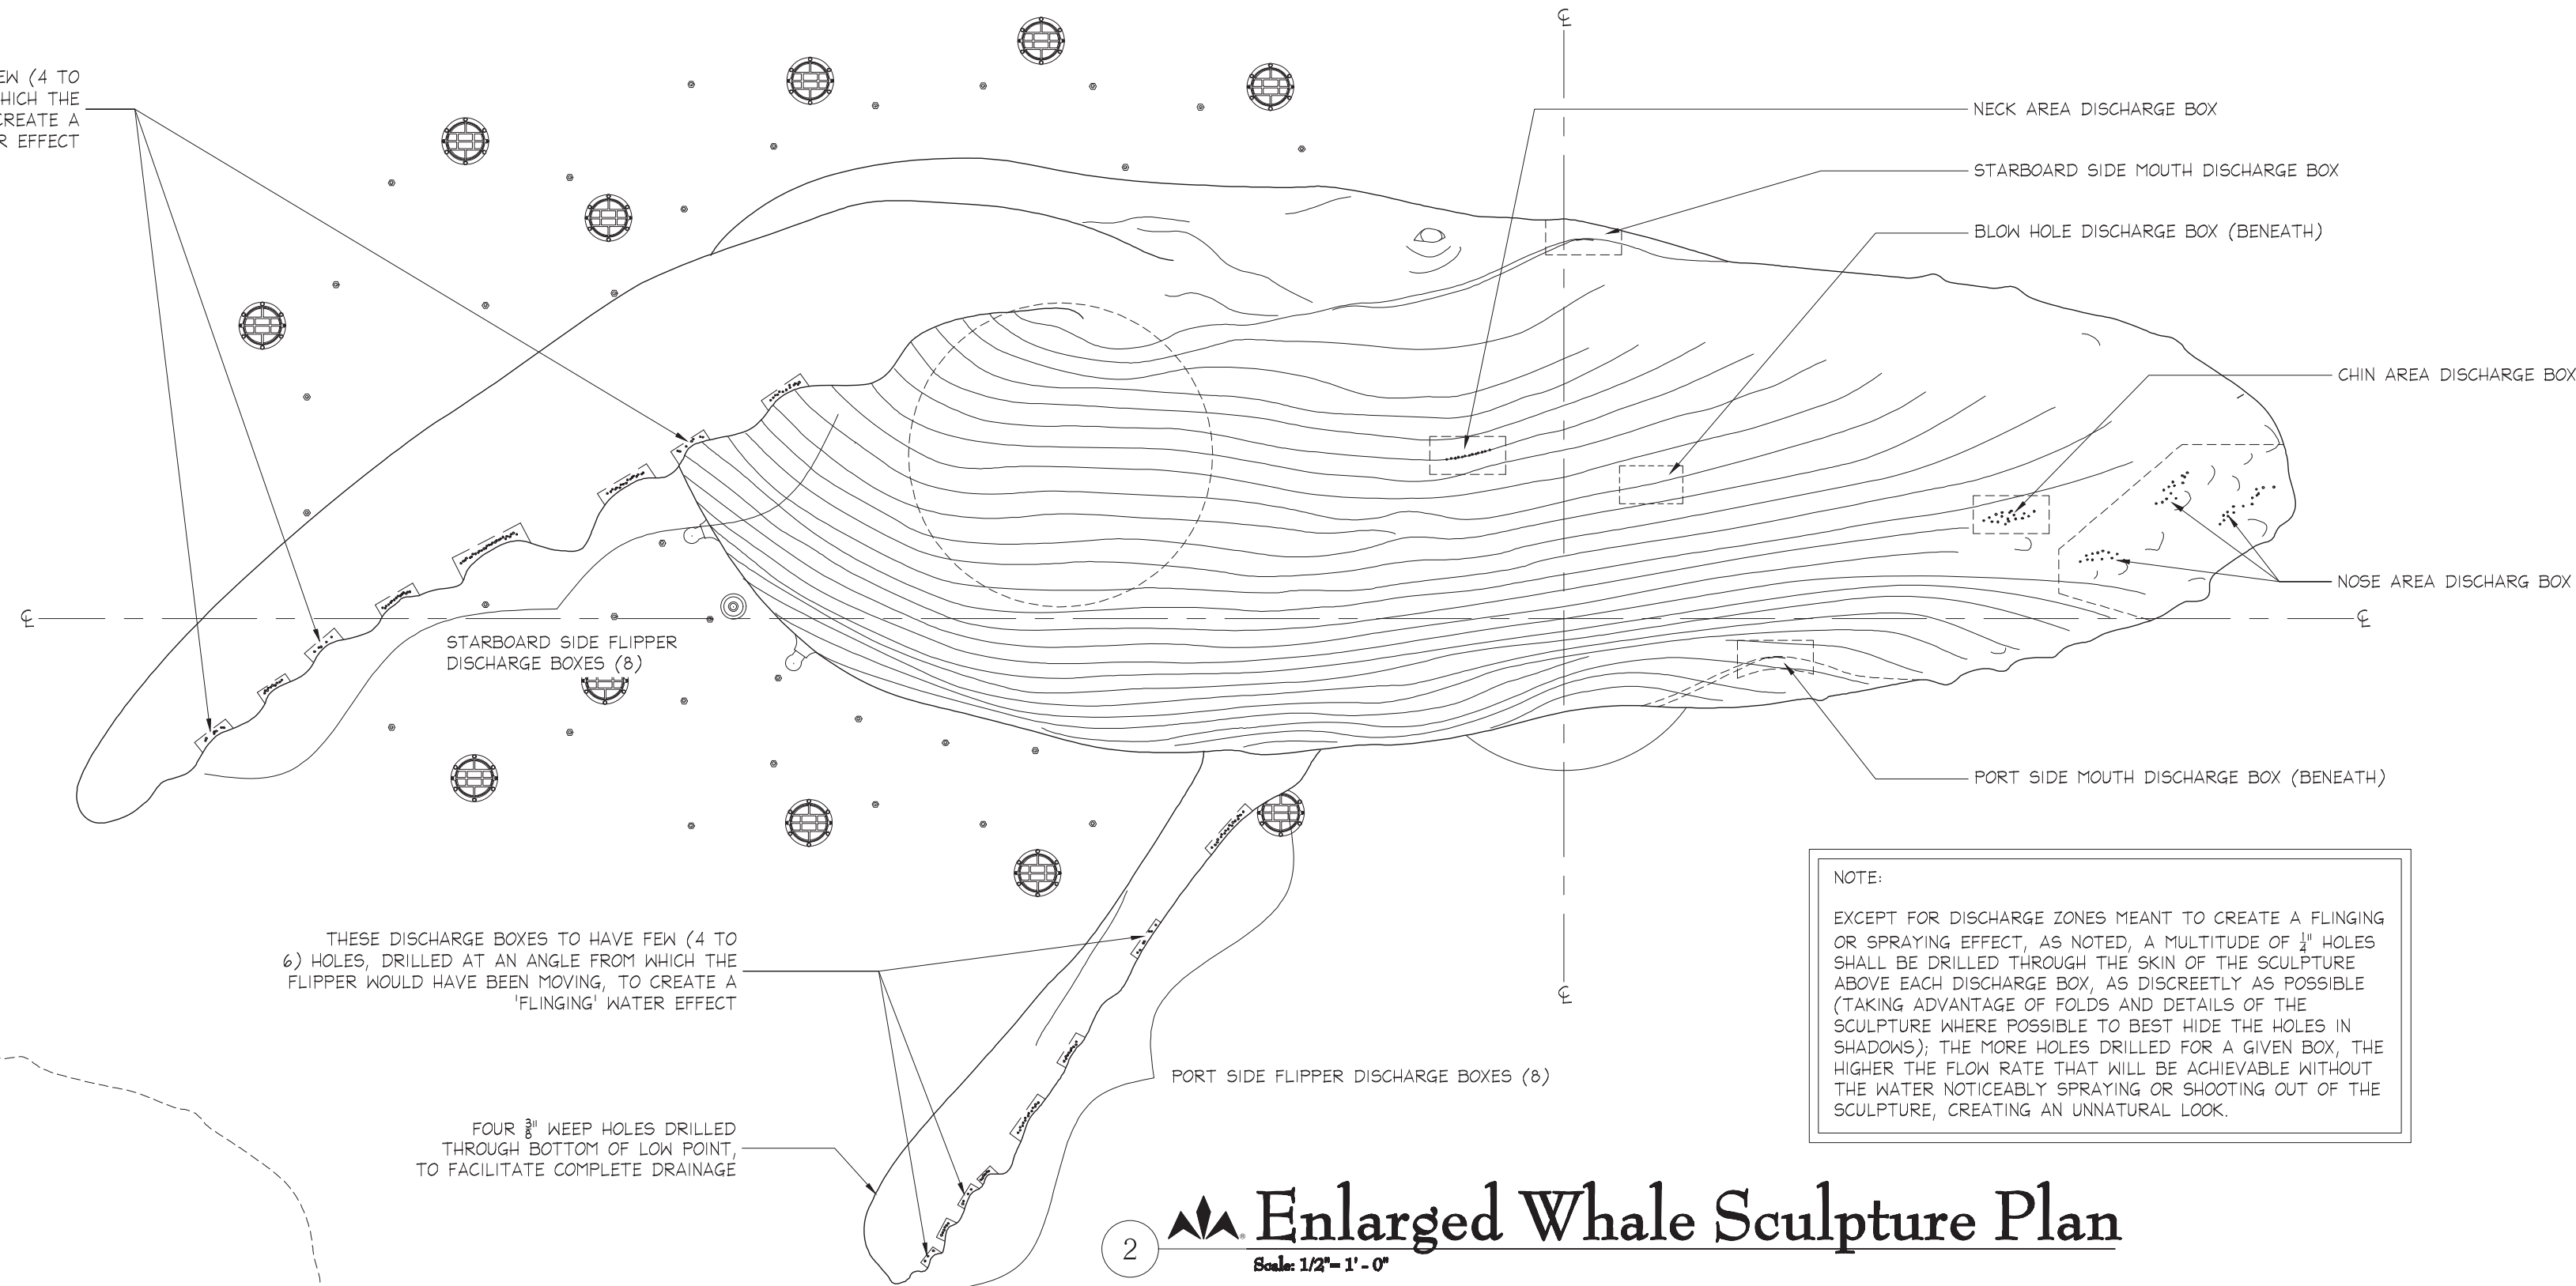

2 **Enlarged Whale Sculpture Plan**
Scale: 1/2" = 1' - 0"

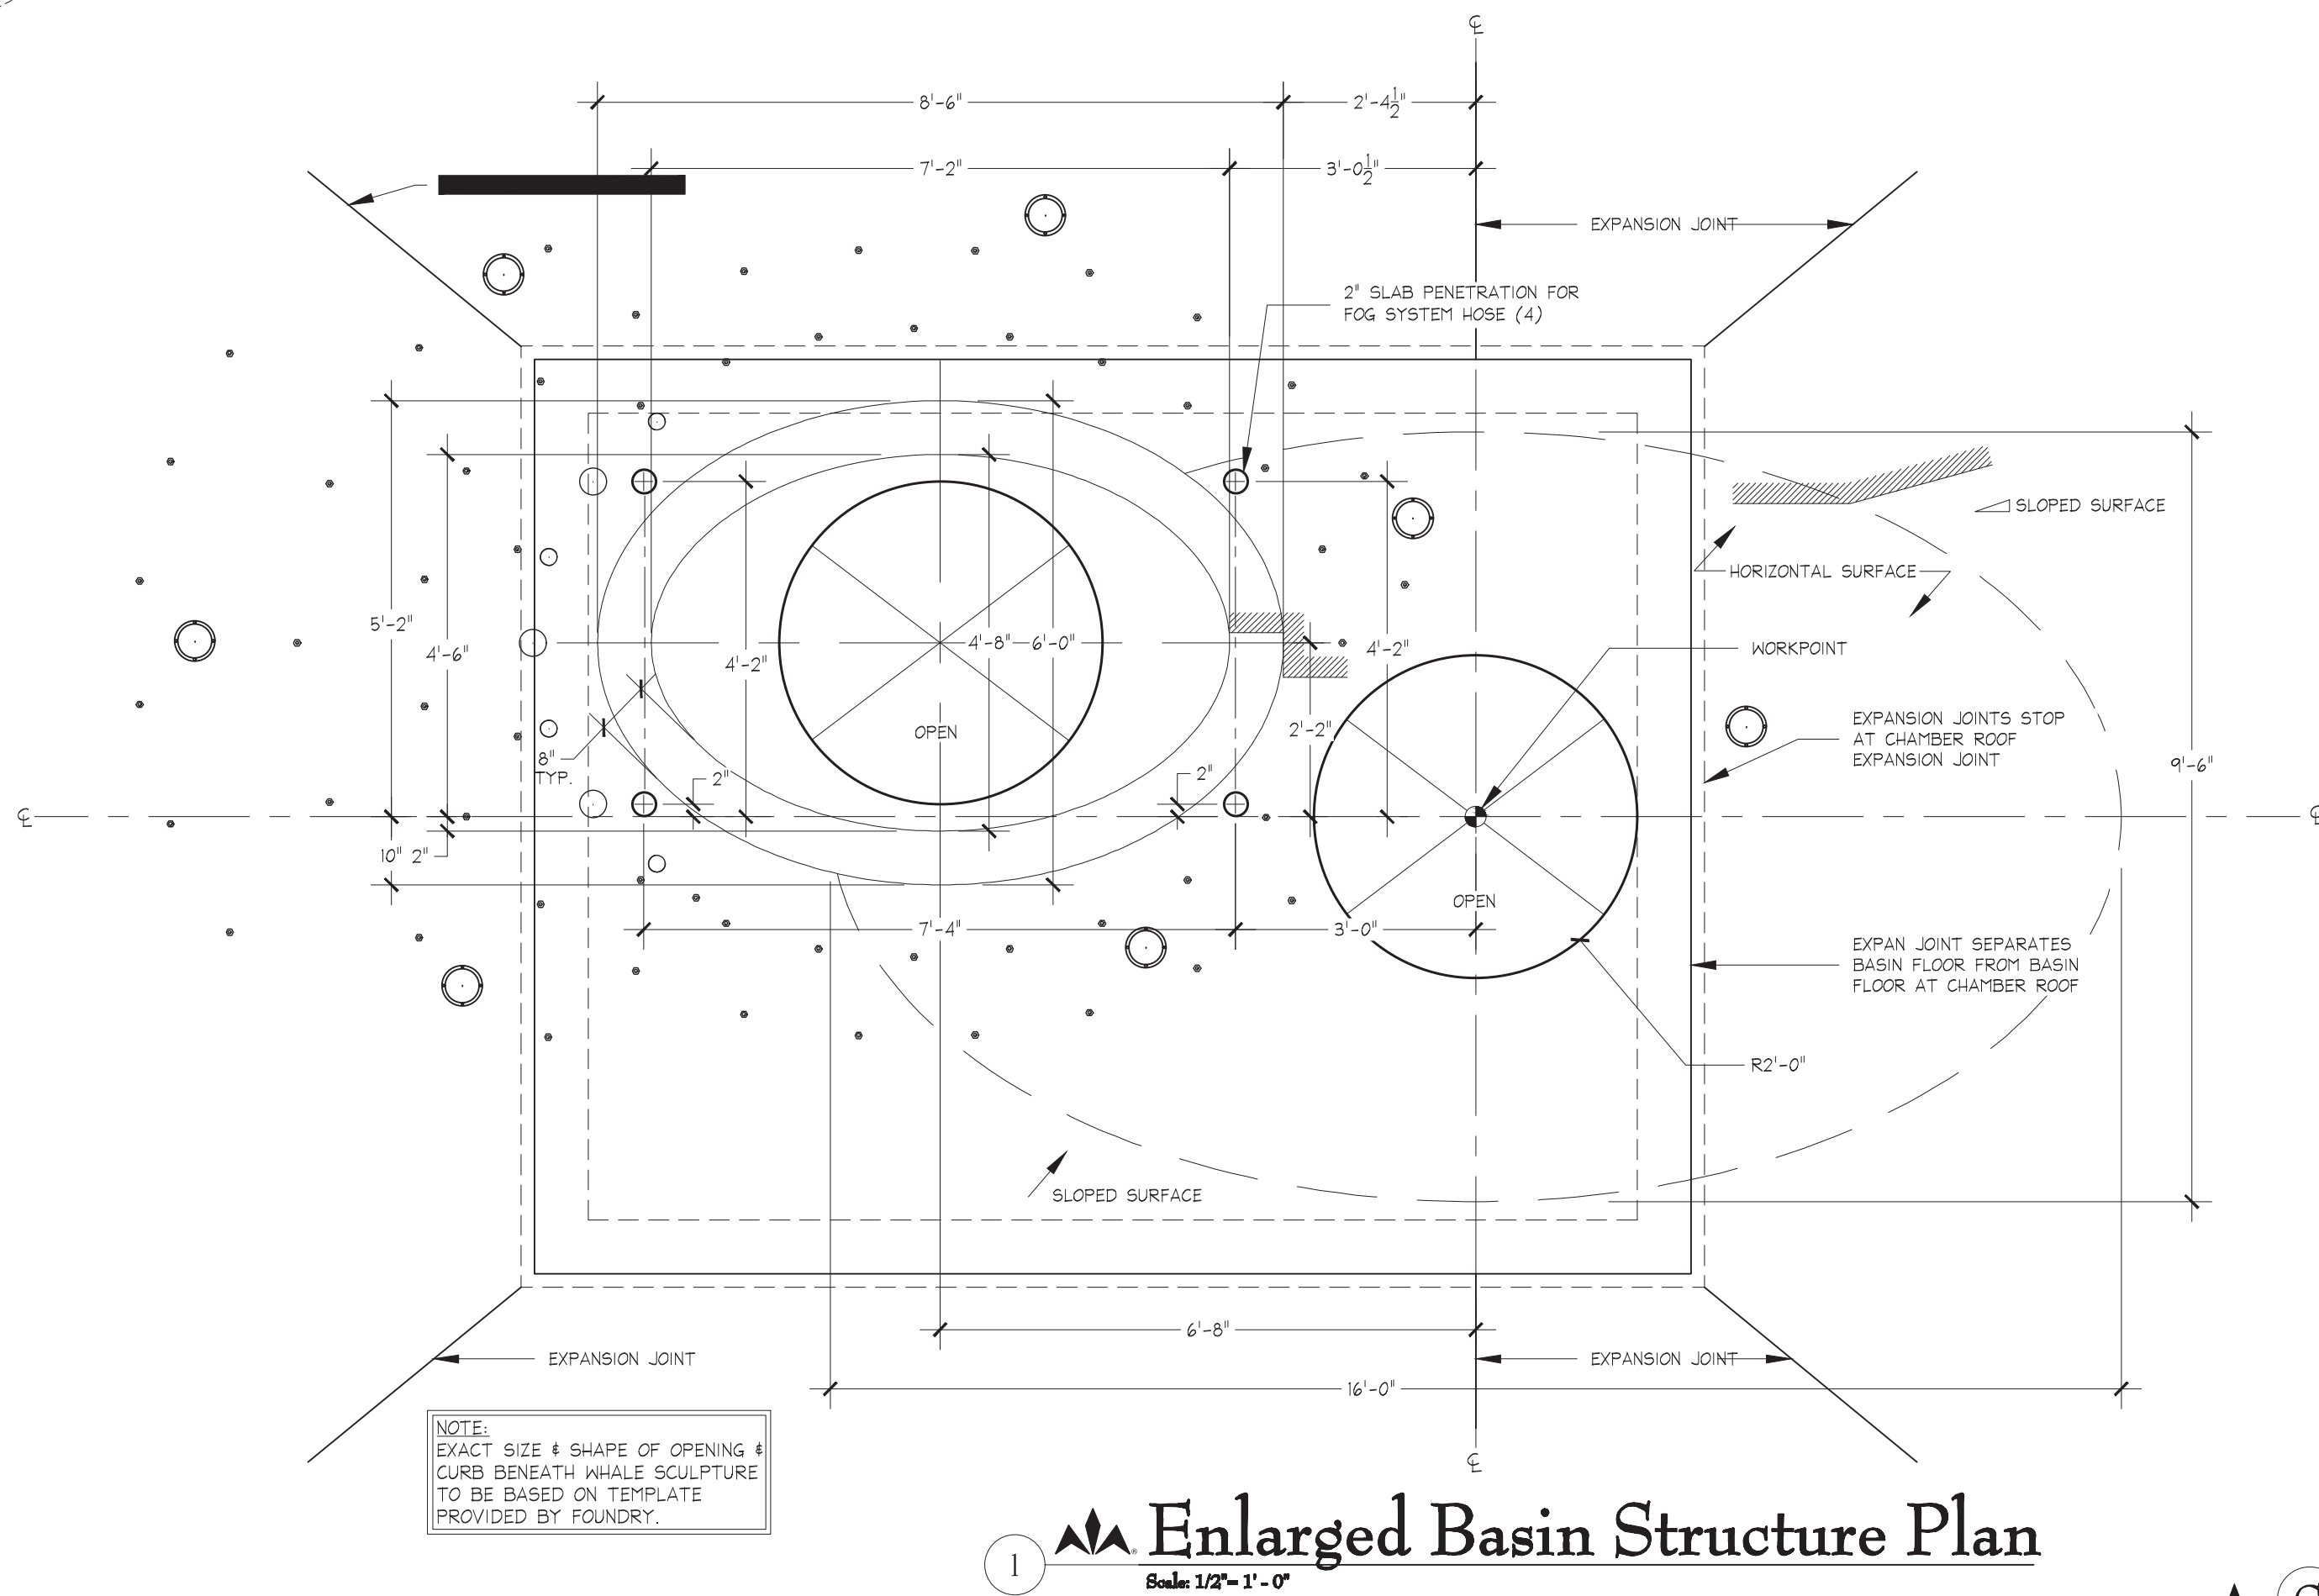

1 **Enlarged Basin Structure Plan**
Scale: 1/2" = 1' - 0"

REV. 0 DATE 9/14/2015

3445 TECHNOLOGY DRIVE
NORTH VENICE, FLORIDA 34275
PHONE: 941.484.9274
FAX: 941.484.9302


WESCO *fountains* THE ART OF WATER
www.wescofountains.com

The Whale Project
Water Feature
Enlarged Layout Plans


REV	REFERENCE & DESCRIPTION	DATE	BY
100%	CONSTRUCTION DOCUMENTS	2/14/14	CR

D.E.S.D. NO.: 2
DRAWN BY: CR
PROJECT NO.: 3145
DATE: 9/14/15


WF-1.20

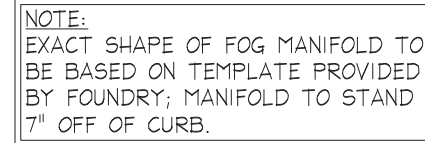

2  Foghorn
Scale: 1/2" = 1' - 0"

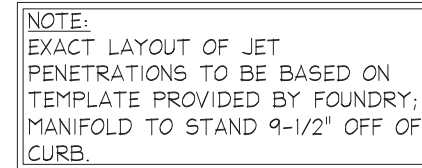

2 **Spla**
Scale: 1/2" = 1' - 0"

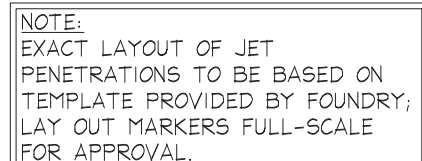

1 **Spray**
Scale: 1/2" = 1' - 0"



REV.	DATE
0	9/14/2015

The Whale Project

Water Feature


Enlarged Layout Plans

REV	REFERENCE & DESCRIPTION	DATE	BY
	100% CONSTRUCTION DOCUMENTS	2/14/14	CR

D.E.S.D. NO.: 2
DRAWN BY: CR
PROJECT NO.: 3145
DATE: 9/14/15

WF-1.21

\\DATA_STORAGE\VOLUME_1\PROJECTS NEW\PROJECTS-2013\THE WHALE PROJECT - 3145.DWG - PLOTTED: 9/15/2015 4:14 PM - SHEET SIZE: ARCH EXPAND D (24.00 X 36.00 INCHES)

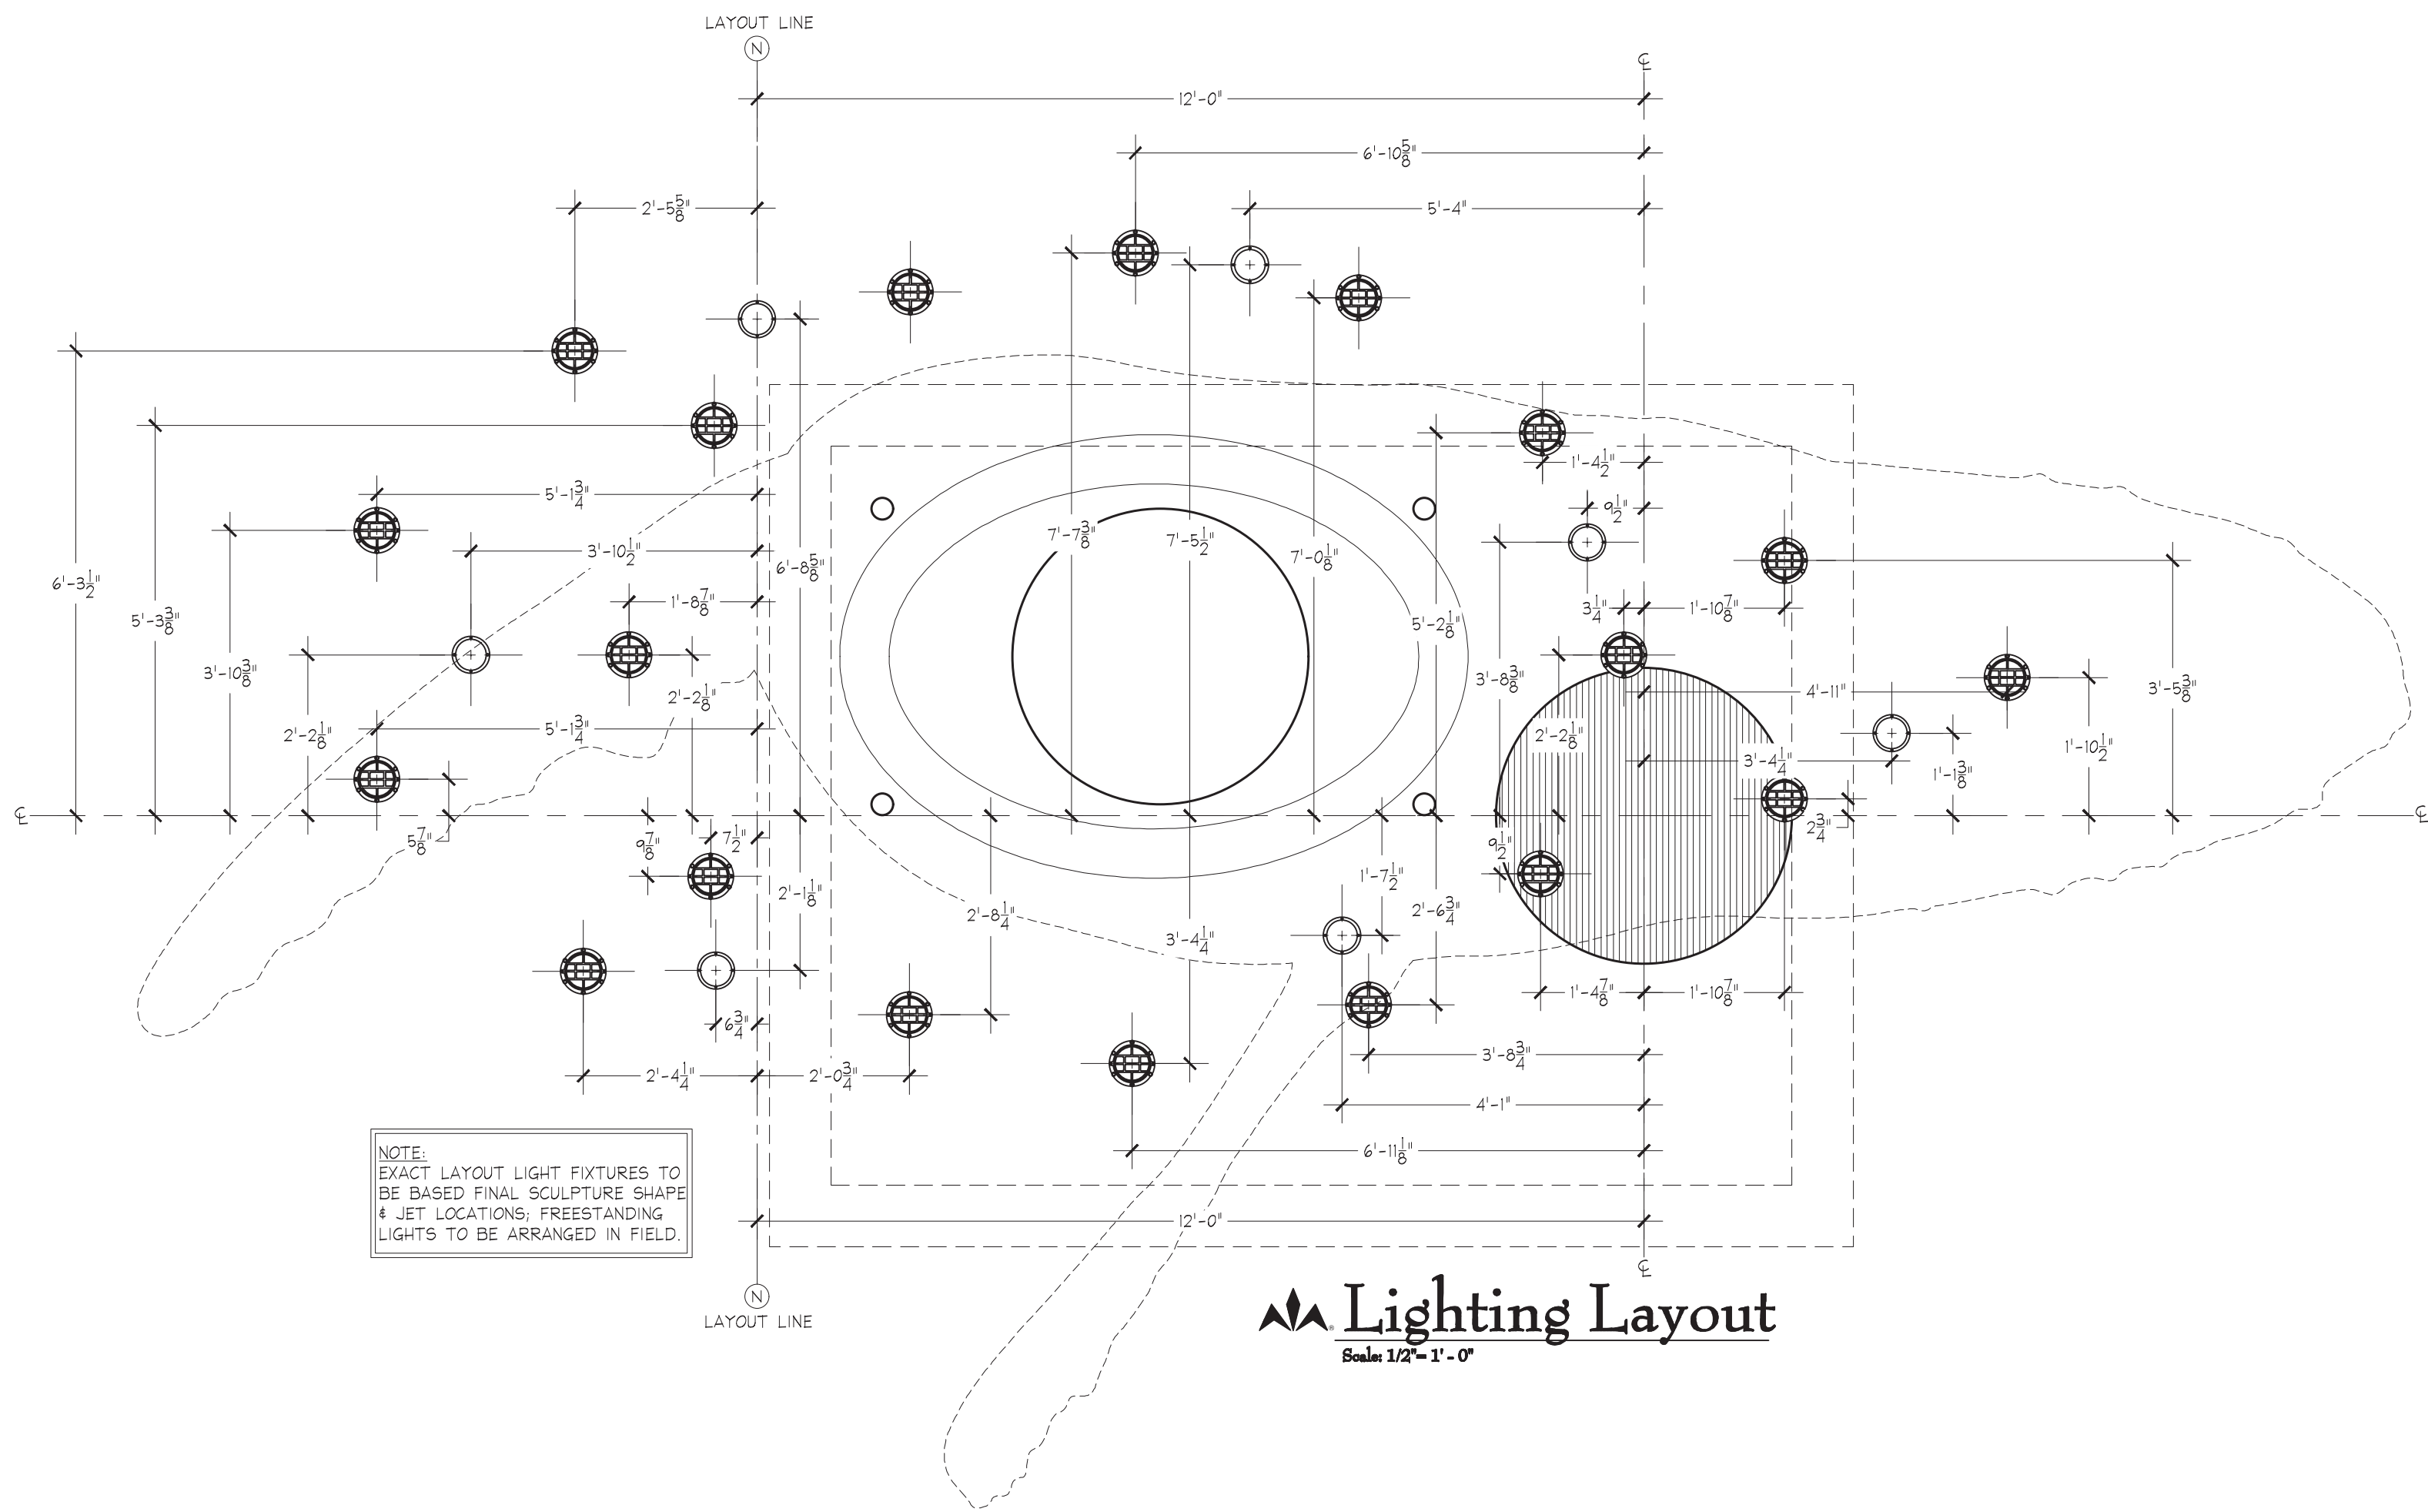



C

COPYRIGHT 2015
WESCO
fountains INCORPORATED

REV.

0

DATE

9/14/2015

The Whale Project

Water Feature

Enlarged Lighting and Junction Box Layout Plan

REV	REFERENCE & DESCRIPTION	DATE	BY
100%	CONSTRUCTION DOCUMENTS	2/14/14	CR

D.E.S.D. NO.: 2

DRAWN BY: CR

PROJECT NO.: 3145

DATE: 9/14/15

WF-1.22




3445 TECHNOLOGY DRIVE
NORTH VENICE, FLORIDA 34275
PHONE: 941.484.8224
FAX: 941.484.9302


WESCO
fountains INCORPORATED
THE ART OF WATER

www.wescofountains.com

\\DATA_STORAGE\\VOLUME_1\\PROJECTS\\NEW\\PROJECTS-2013\\THE WHALE PROJECT - 3145\\THE WHALE PROJECT - 3145.DWG - PLOTTED: 9/15/2015 4:14 PM - SHEET SIZE: ARCH EXPAND D (24.00 X 36.00 INCHES)

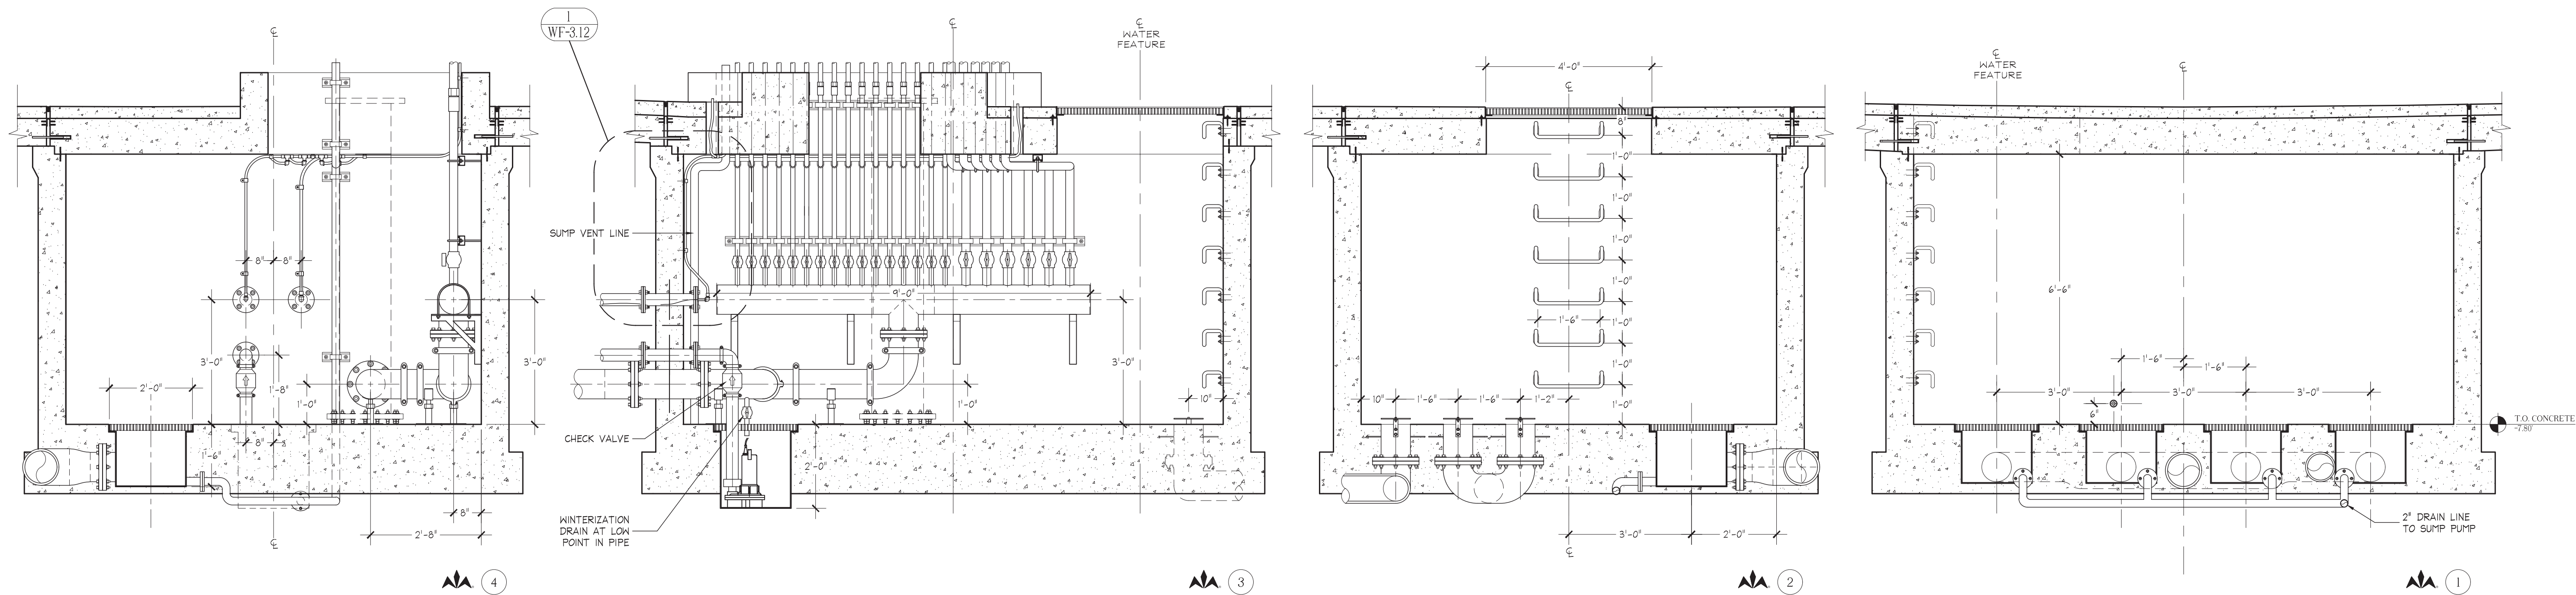

Access Chamber Interior Elevations
Scale 1/2" = 1' - 0"

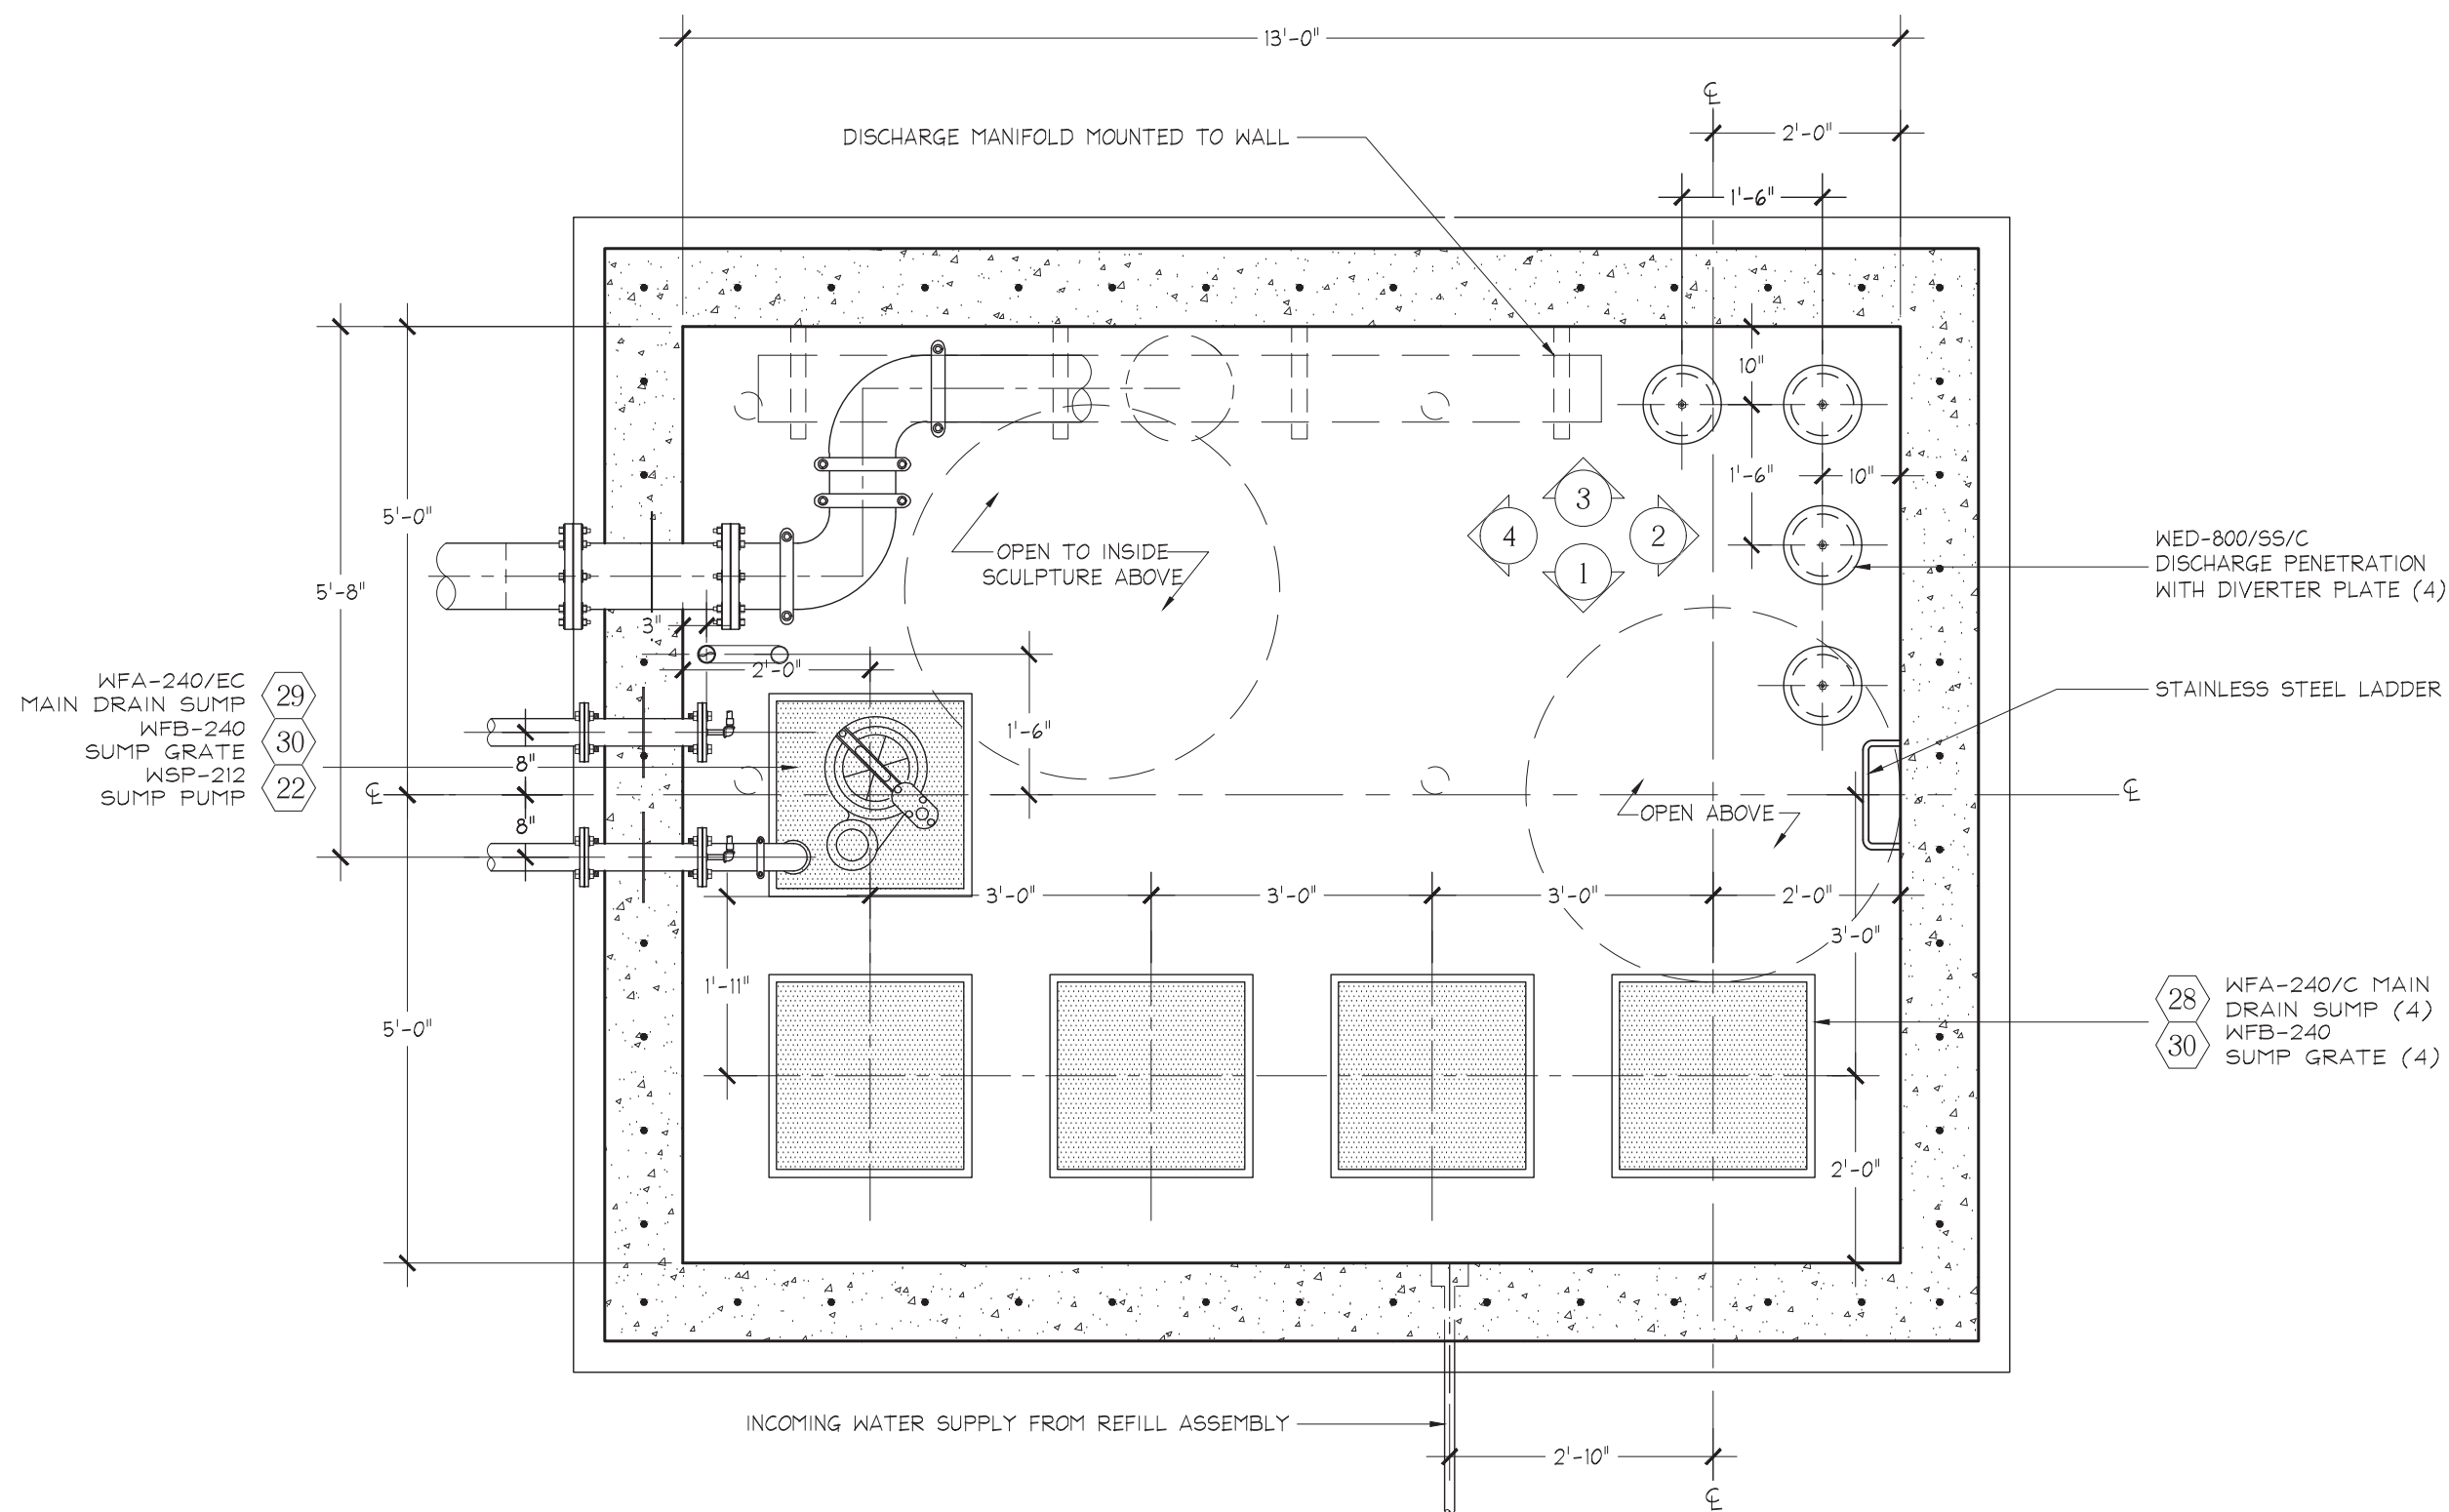

Under Pool Access Chamber Plan
Scale 1/2" = 1' - 0"

NOTES:
-ALL CONCRETE THICKNESS, MIX, AND REINFORCING DESIGNS PER STRUCTURAL ENGINEER'S DRAWINGS AND SPECIFICATIONS

NOTES:
-STRUCTURAL ELEVATIONS SHOWN ARE RELATIVE ELEVATIONS USING ADJACENT FINISH PAVING AS BASELINE 0.0' ELEVATION; ONCE ADJ. PAVING ELEVATION IS SET BY LANDSCAPE ARCHITECTS, ALL FOUNTAIN SPOT ELEVATIONS MUST BE ADJUSTED ACCORDINGLY.



REV.	DATE
0	9/14/2015



The Whale Project
Water Feature
Enlarged Chamber Plan and Elevations

REV	REFERENCE & DESCRIPTION	DATE	BY
100%	CONSTRUCTION DOCUMENTS	2/14/14	CR

D.E.S.D. NO:	2
DRAWN BY:	CR
PROJECT NO:	3145
DATE:	9/14/15

WF-1.23

\\DATA_STORAGE\\VOLUME_1\\PROJECTS\\NEW\\PROJECTS-2013\\THE WHALE PROJECT - 3145\\THE WHALE PROJECT - 3145.DWG - PLOTTED: 9/15/2015 4:15 PM - SHEET SIZE: ARCH EXPAND D (24.00 X 36.00 INCHES)

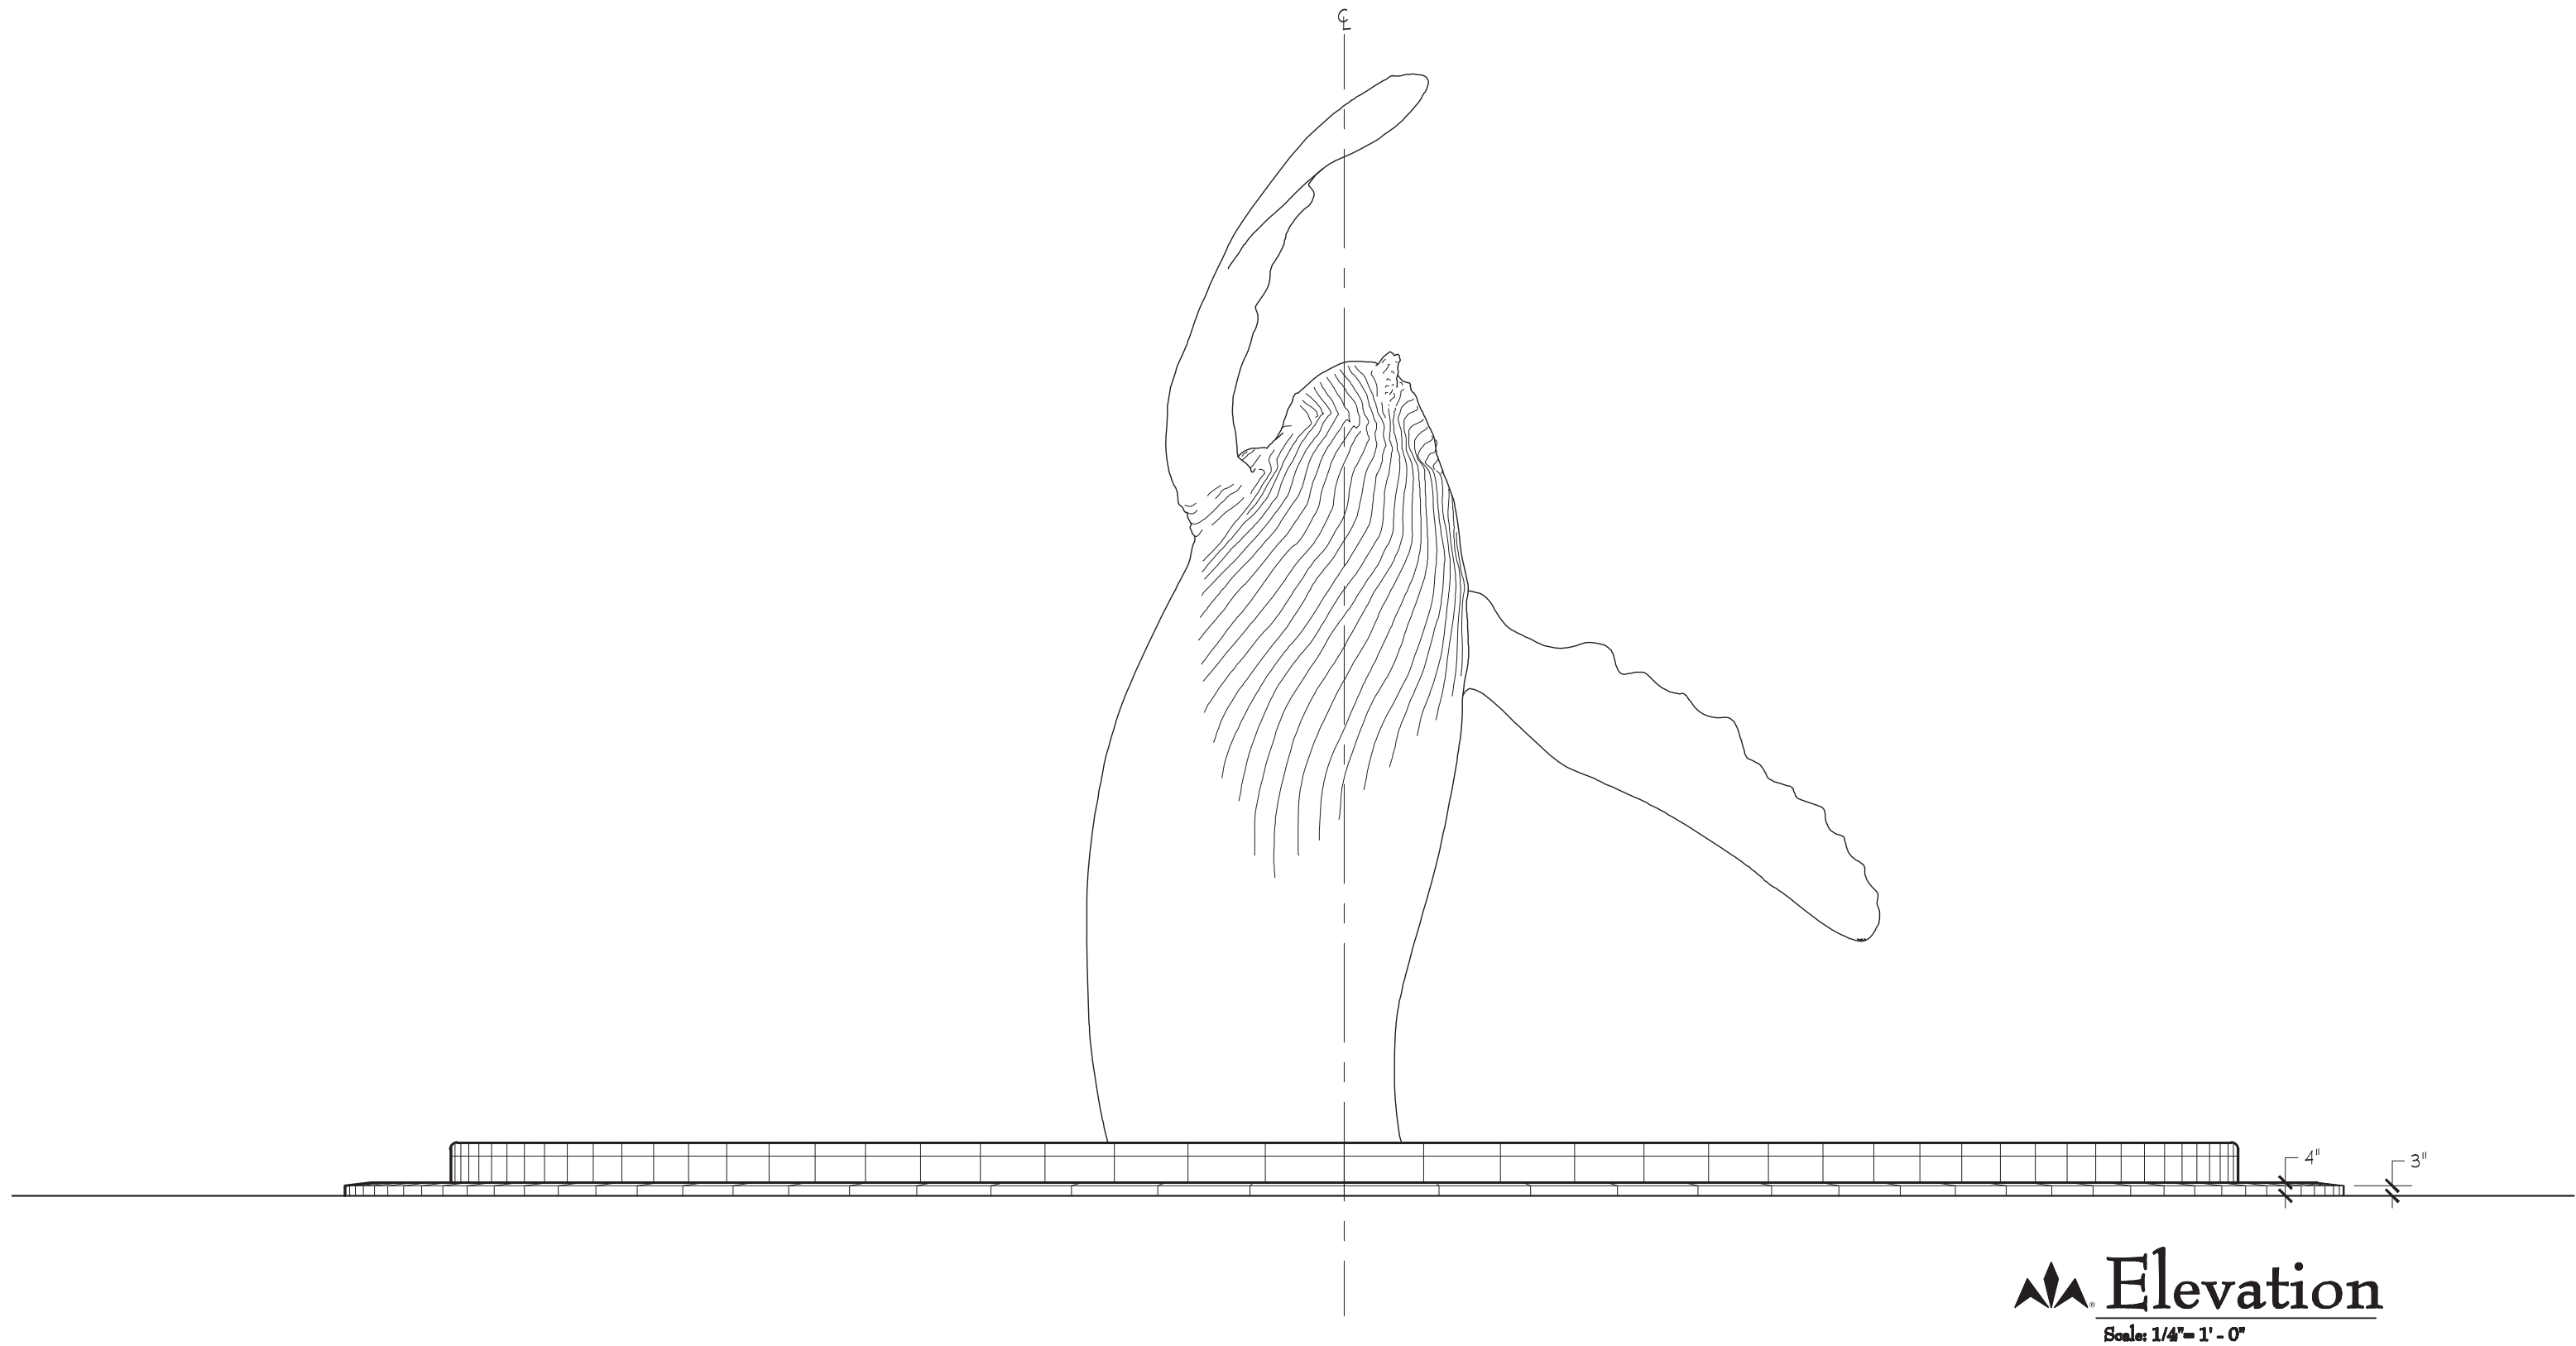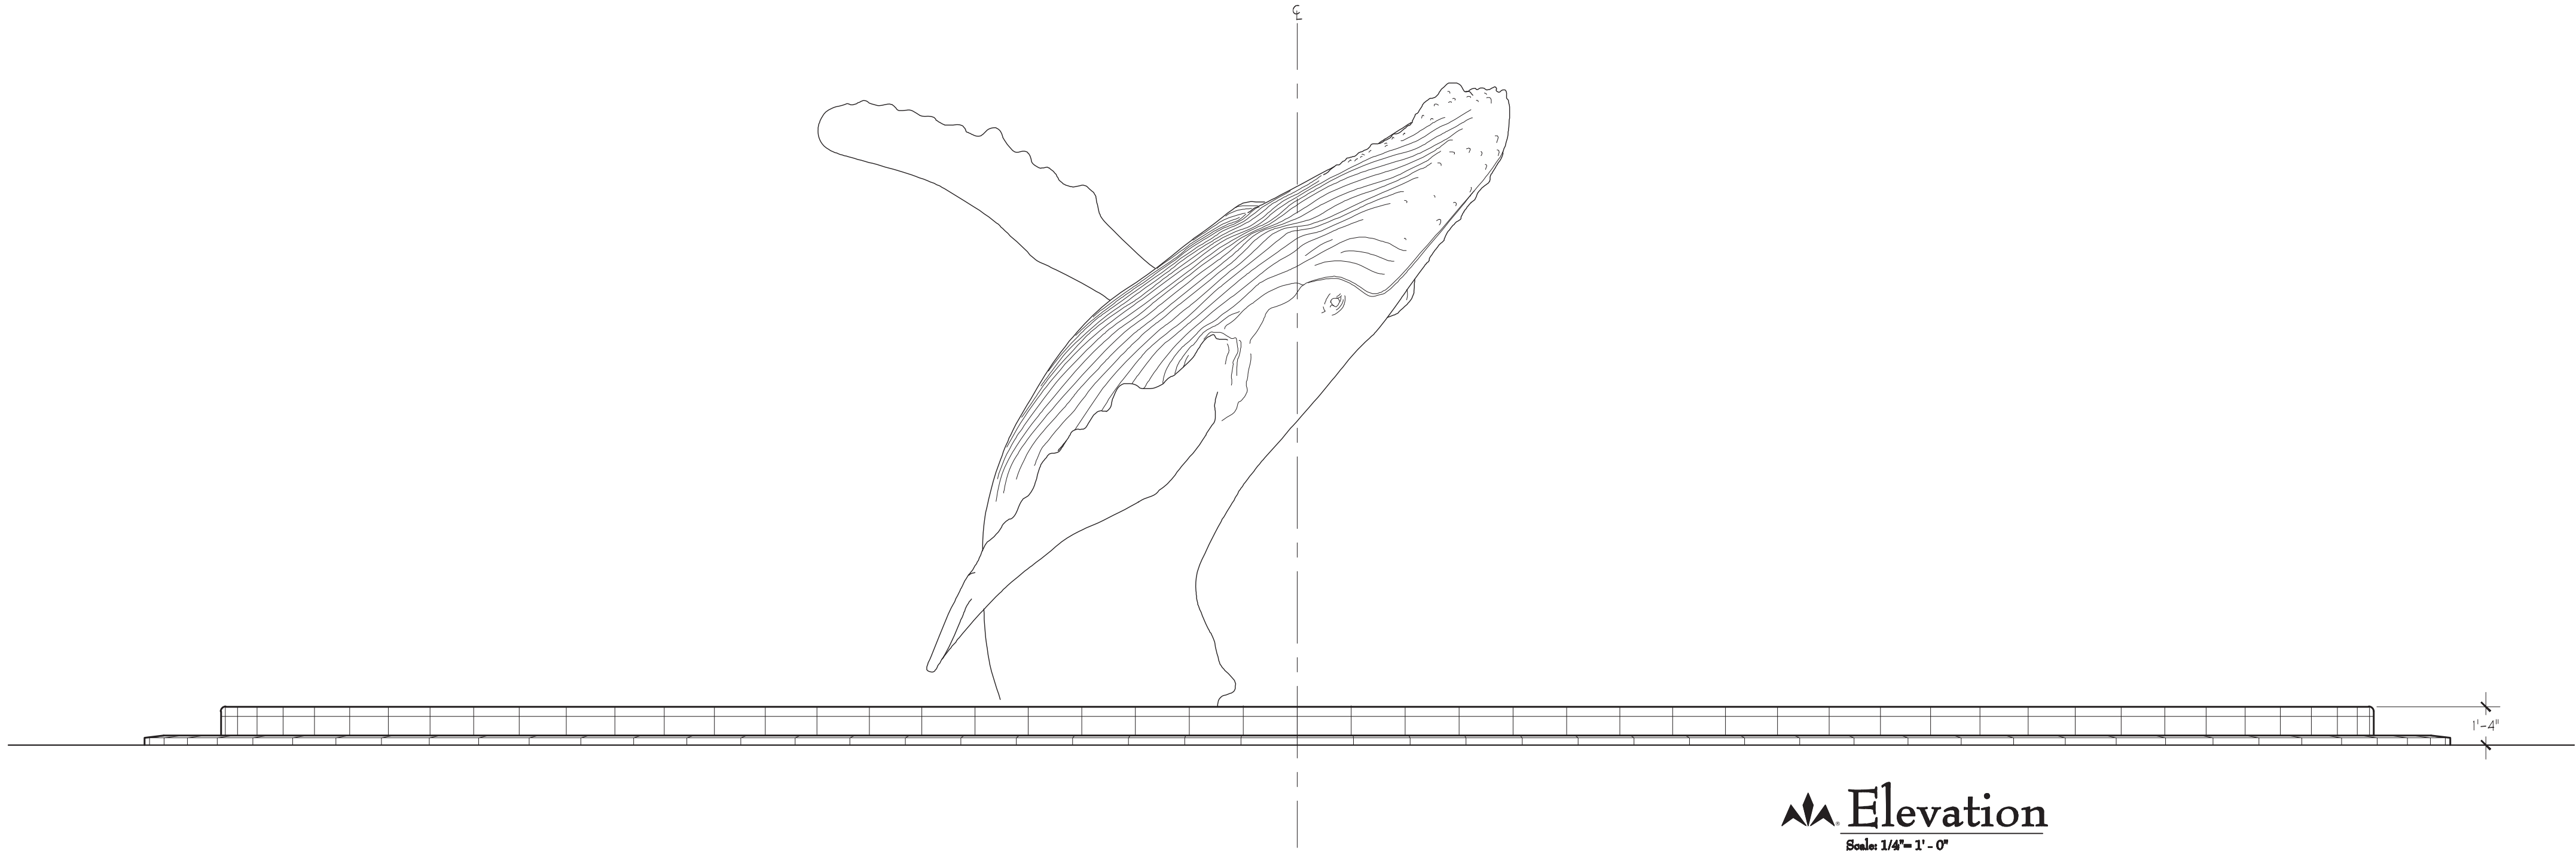



C

COPYRIGHT 2015

WESCO

fountains INCORPORATED

REV.

DATE

0

9/14/2015

REV	REFERENCE & DESCRIPTION	DATE	BY
100%	CONSTRUCTION DOCUMENTS	2/14/14	CR

D.E.S.D. NO.:

DRAWN BY:

PROJECT NO.:

DATE:

2

CR

3145

9/14/15

WF-2.00

The Whale Project

Water Feature

Elevations



3445 TECHNOLOGY DRIVE

NORTH VENICE, FLORIDA 34275

PHONE: 941.484.9224

FAX: 941.484.9302


WESCO

fountains INCORPORATED


THE ART OF WATER

www.wescofountains.com

\\DATA_STORAGE\\VOLUME_1\\PROJECTS\\NEW\\PROJECTS-2013\\THE WHALE PROJECT - 3145\\THE WHALE PROJECT - 3145.DWG - PLOTTED: 9/15/2015 4:15 PM - SHEET SIZE: ARCH EXPAND D (24.00 X 36.00 INCHES)

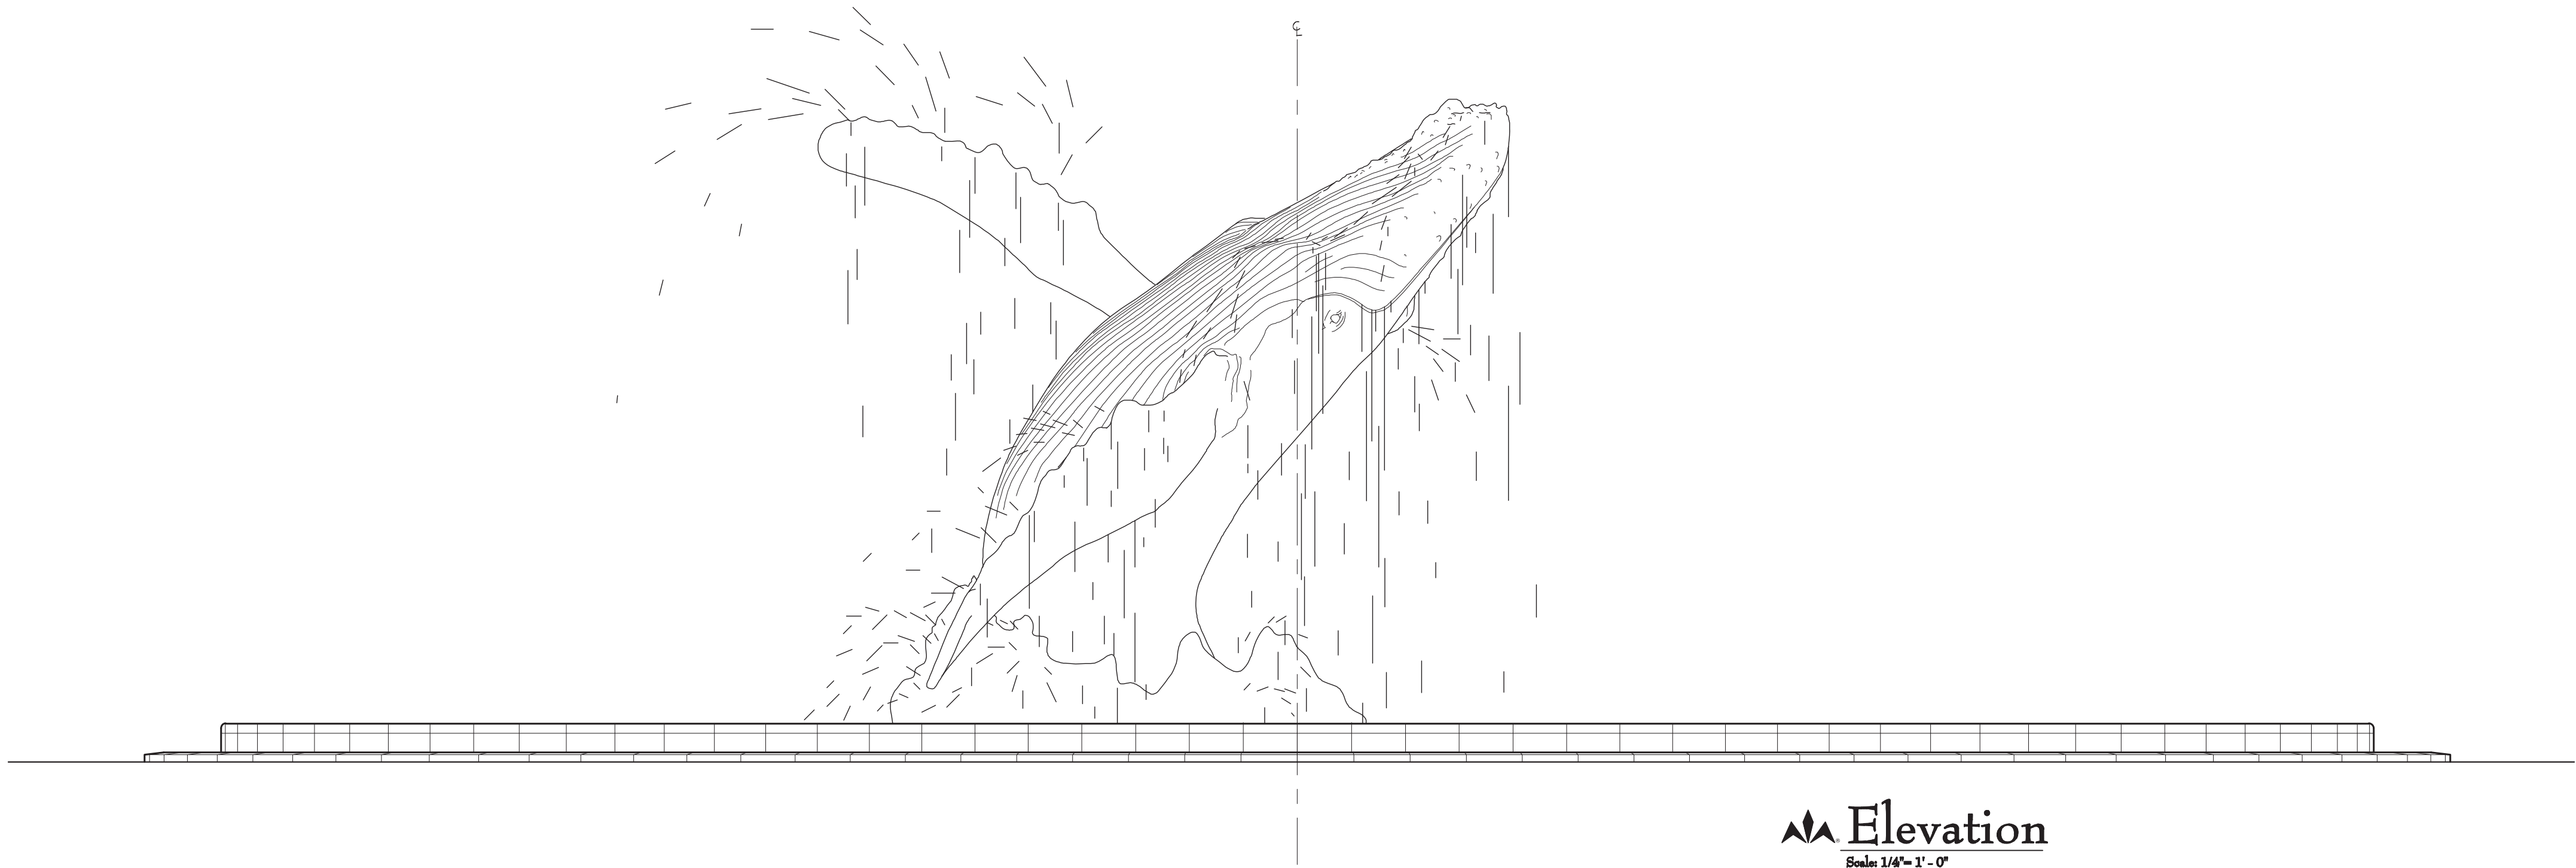

 **Elevation**
Scale: 1/4" = 1' - 0"

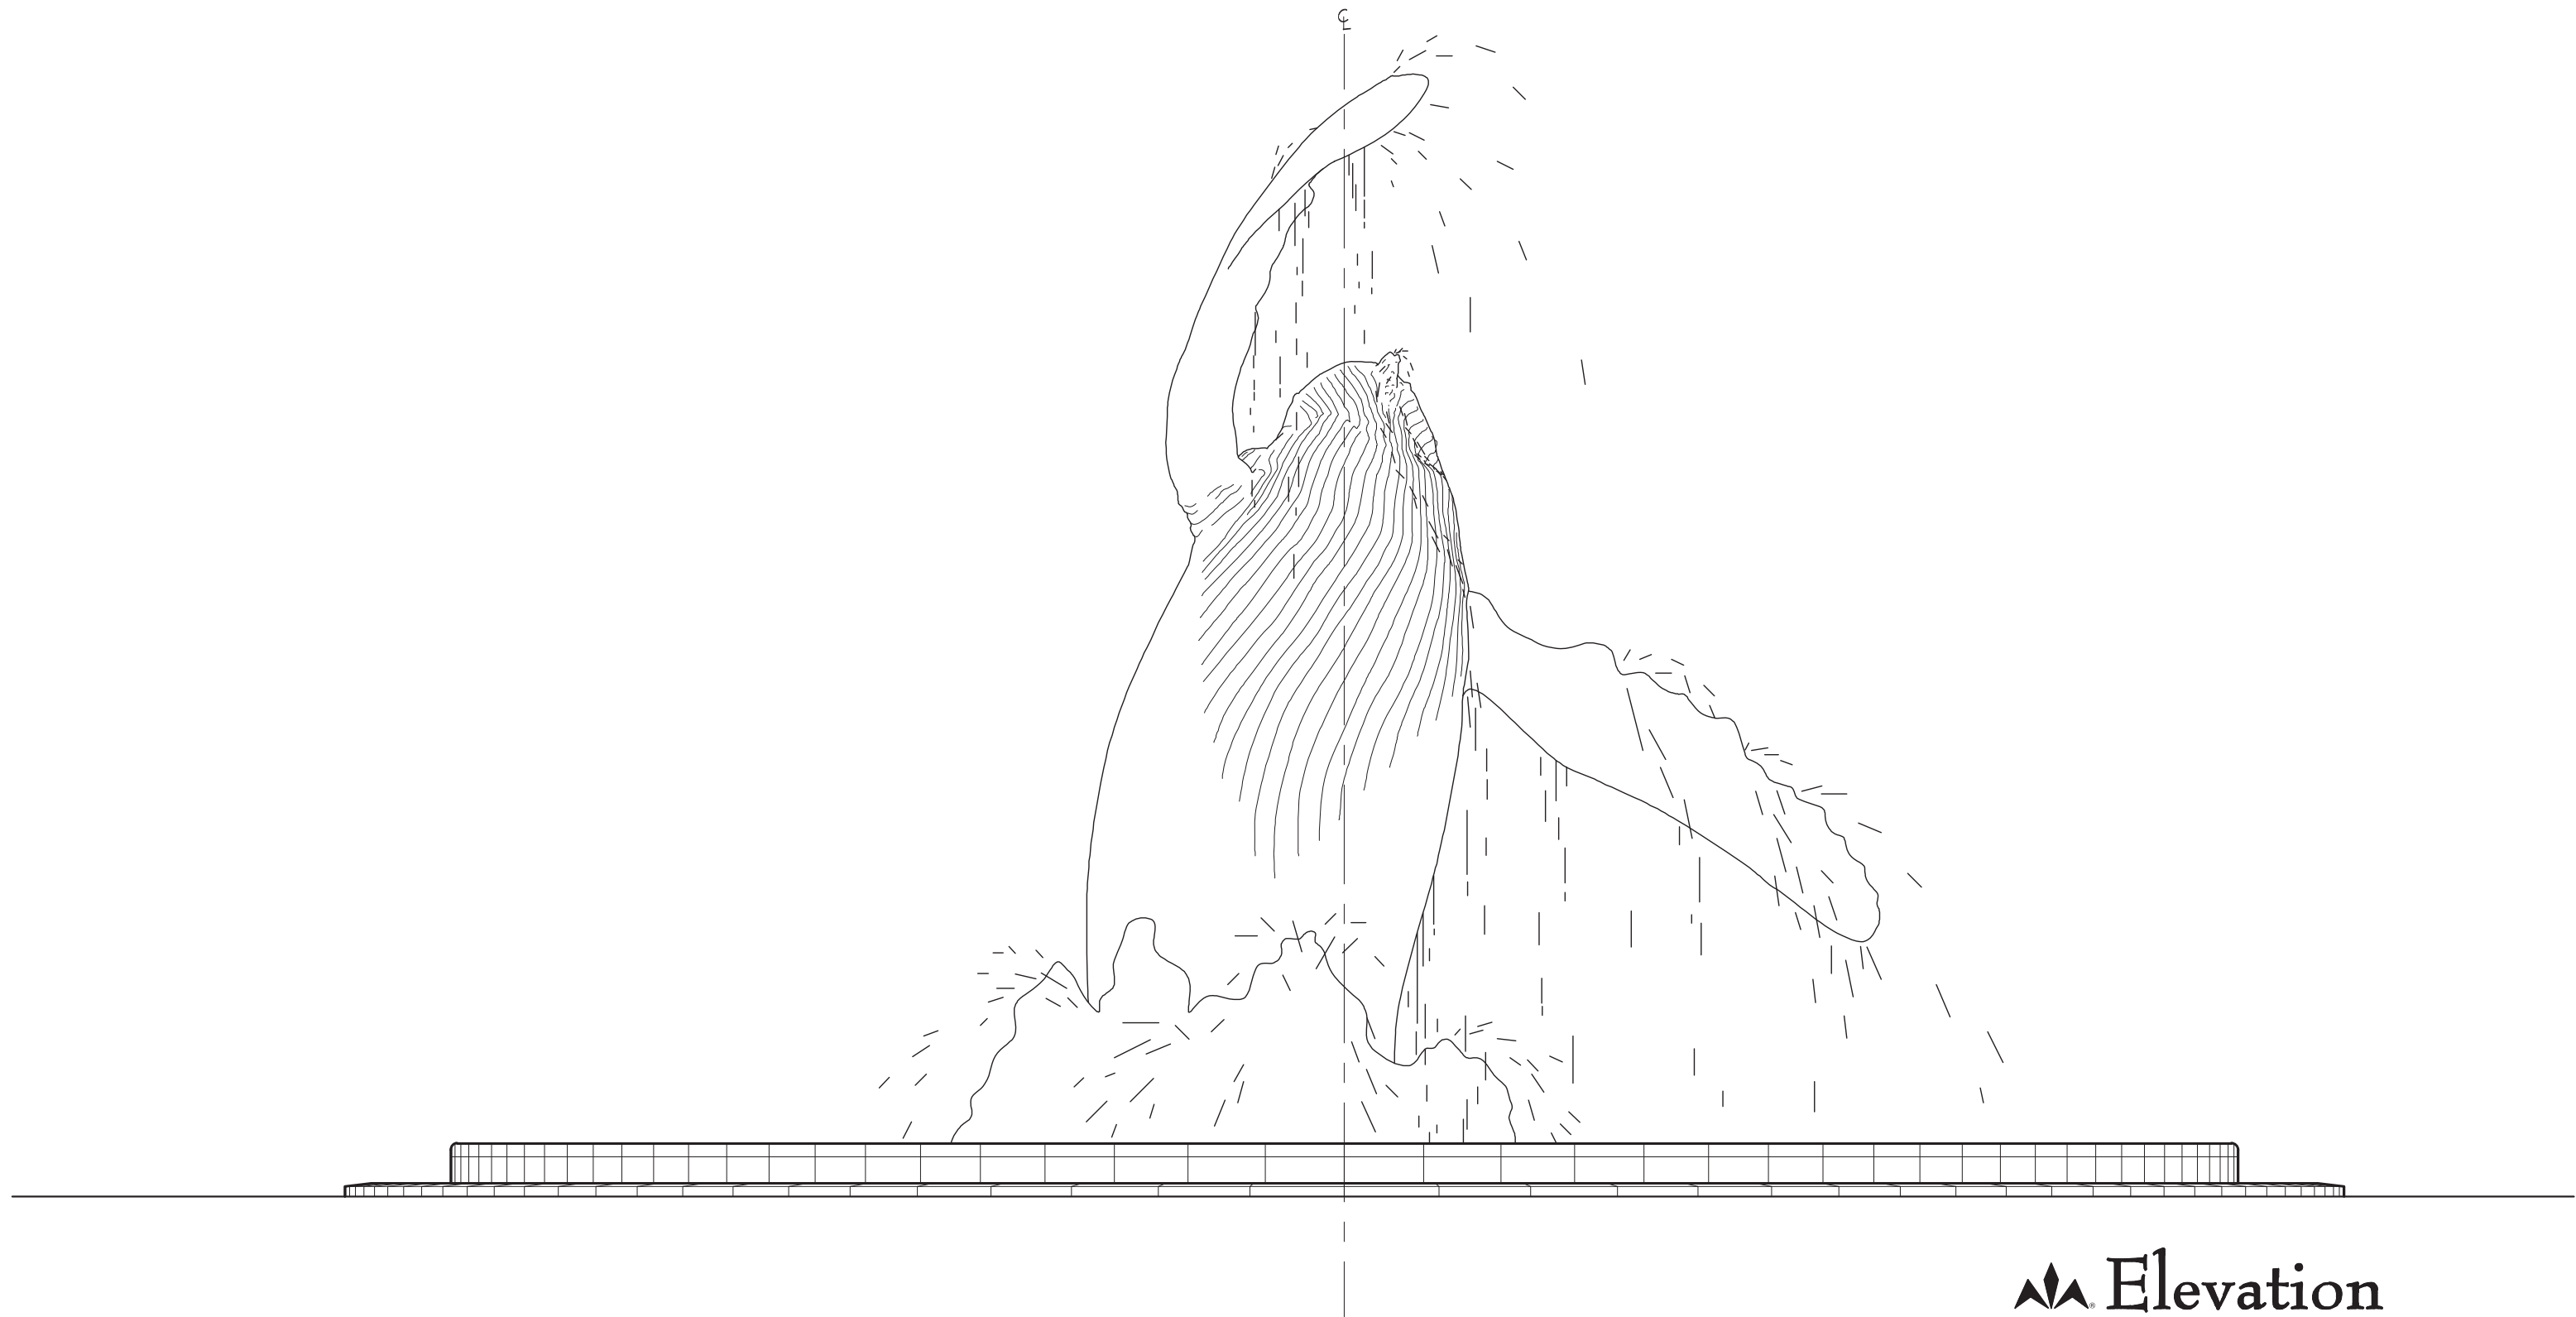

 **Elevation**
Scale: 1/4" = 1' - 0"



REV.	DATE
0	9/14/2015

REV	REFERENCE & DESCRIPTION	DATE	BY
100%	CONSTRUCTION DOCUMENTS	2/14/14	CR

D.E.S.D. NO.:	2
DRAWN BY:	CR
PROJECT NO.:	3145
DATE:	9/14/15

WF-2.10

The Whale Project
Water Feature
Elevations (With Water Display Illustration)



3445 TECHNOLOGY DRIVE
NORTH VENICE, FLORIDA 34275
PHONE: 941-484-9324
FAX: 941-484-9302

WESCO *fountains* INCORPORATED
THE ART OF WATER
www.wescofountains.com